



D.L. MAZE, A.S. Mechanical Engineer, State of Louisiana, License No. ME 10574, Exp. 12/31/2025, 12/31/2025.

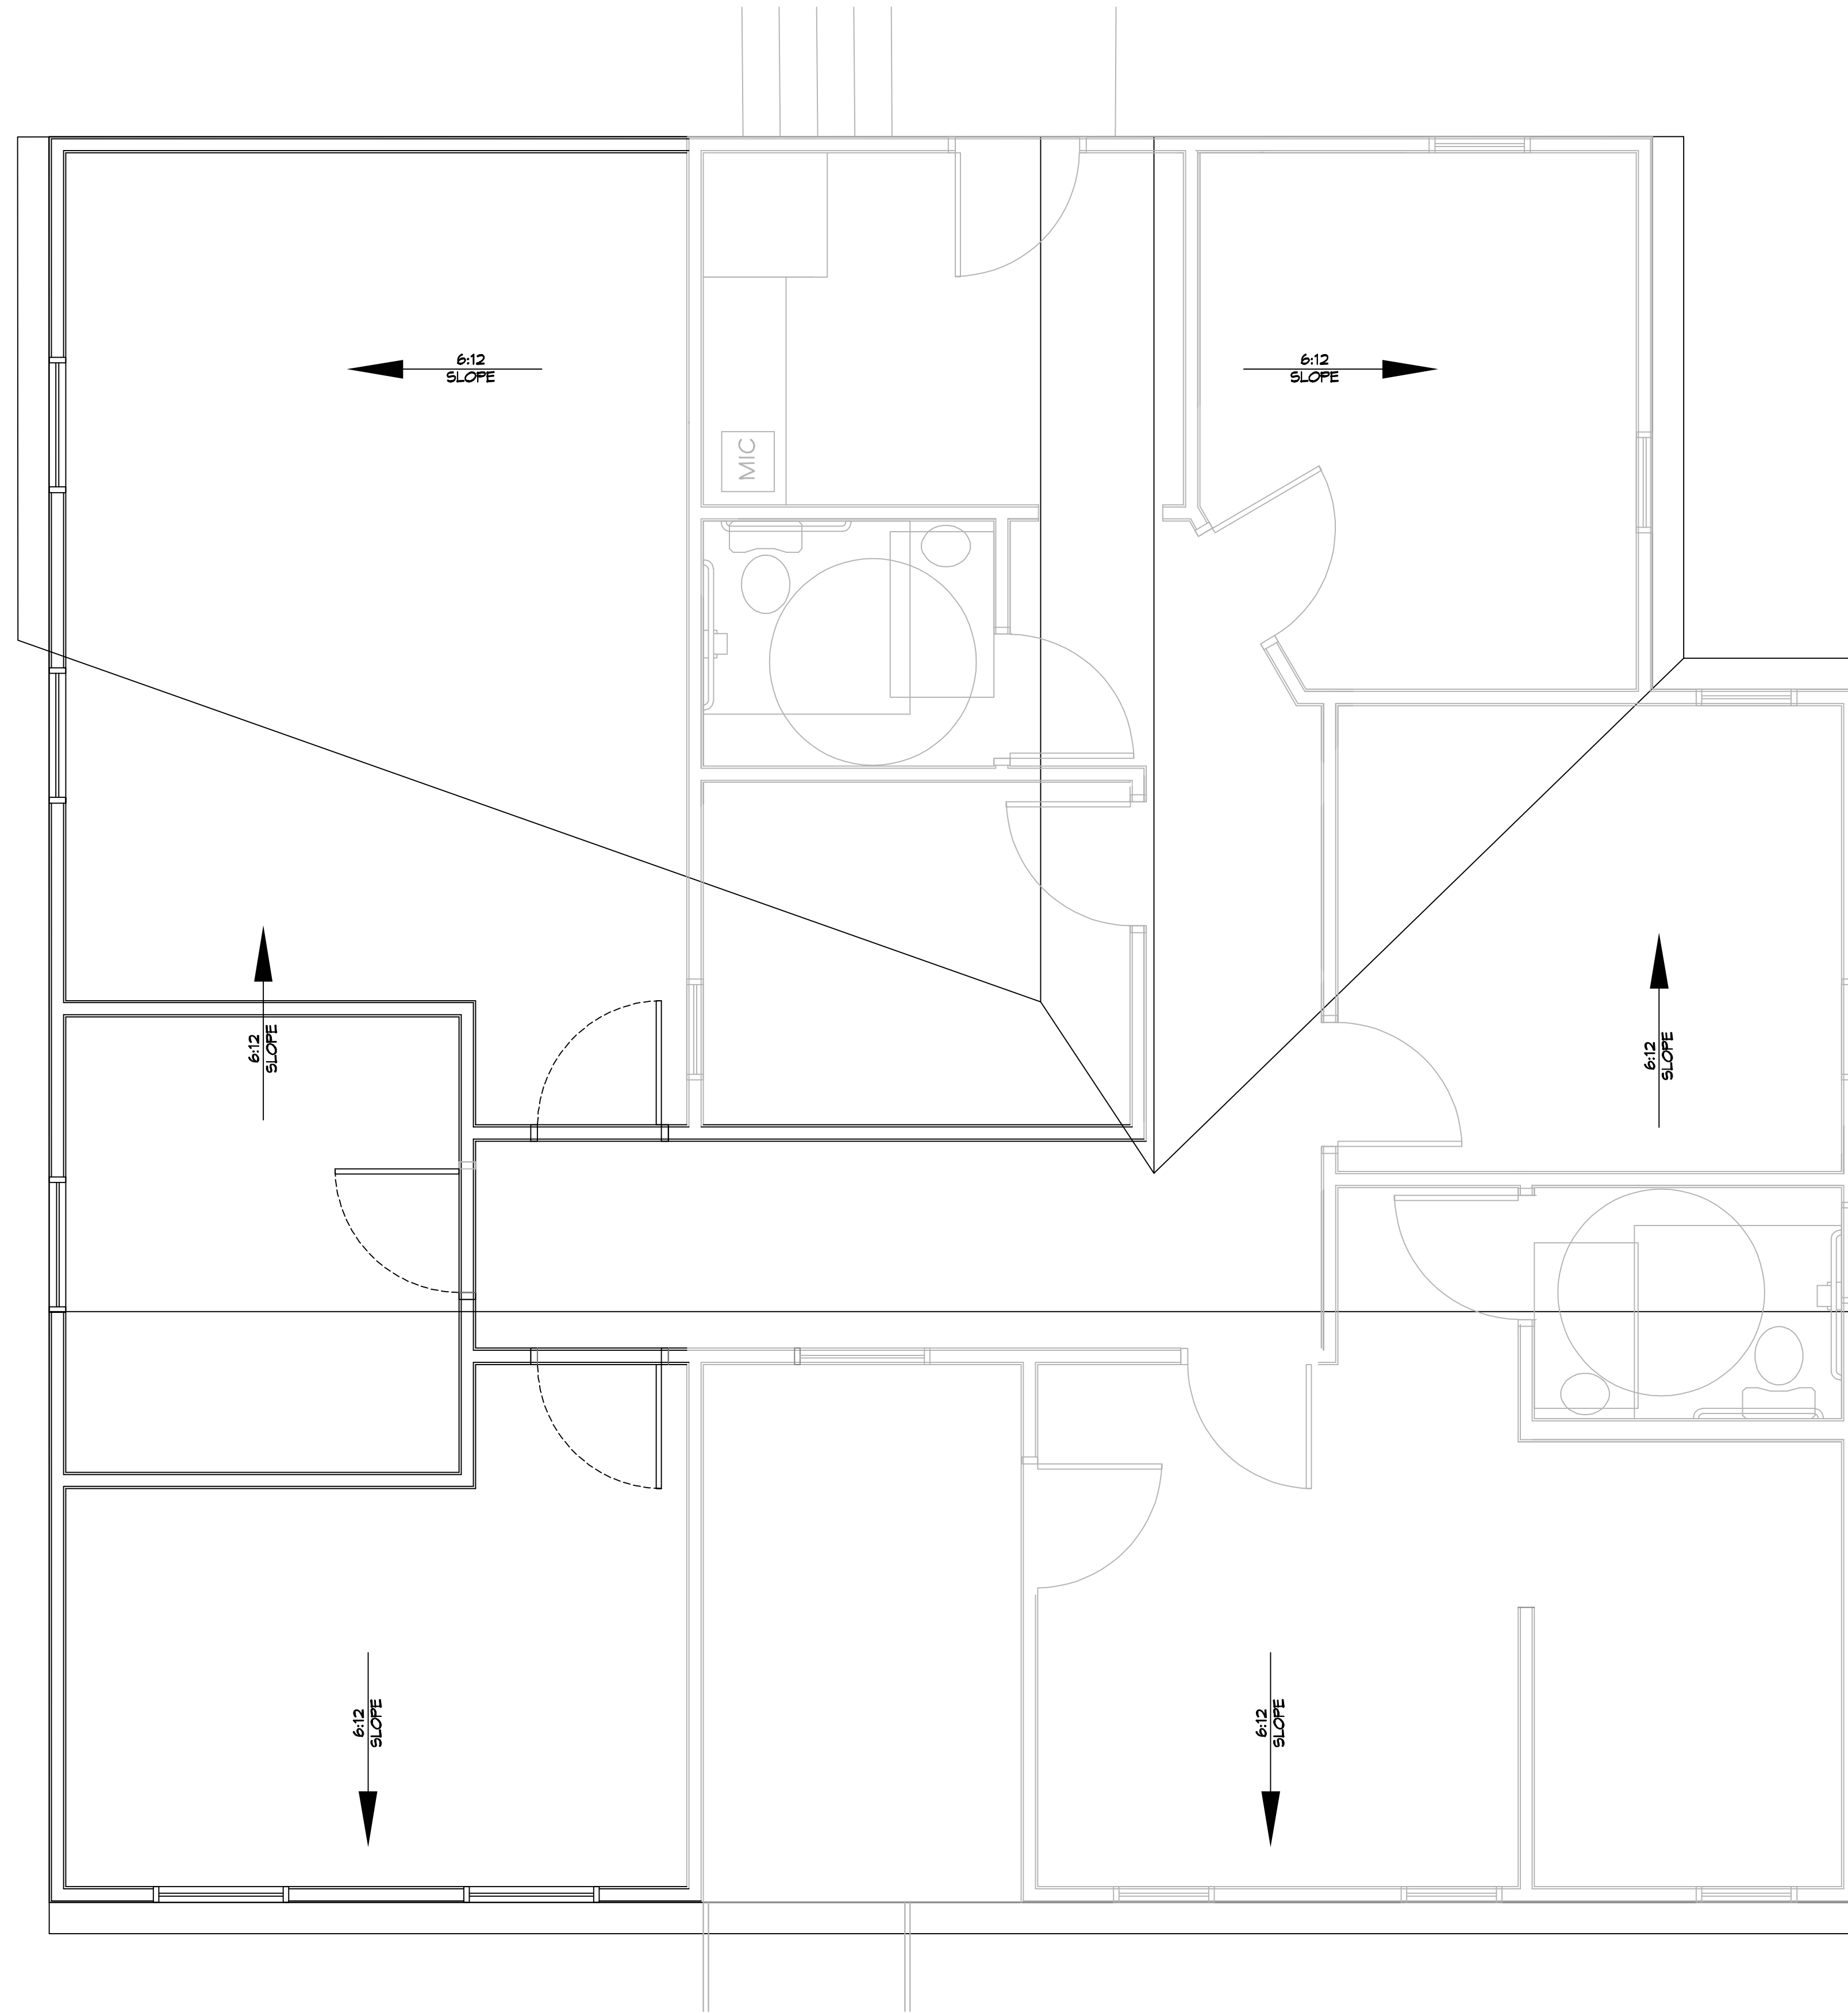

ROOF PLAN
 SCALE: 3/8" = 1'-0"

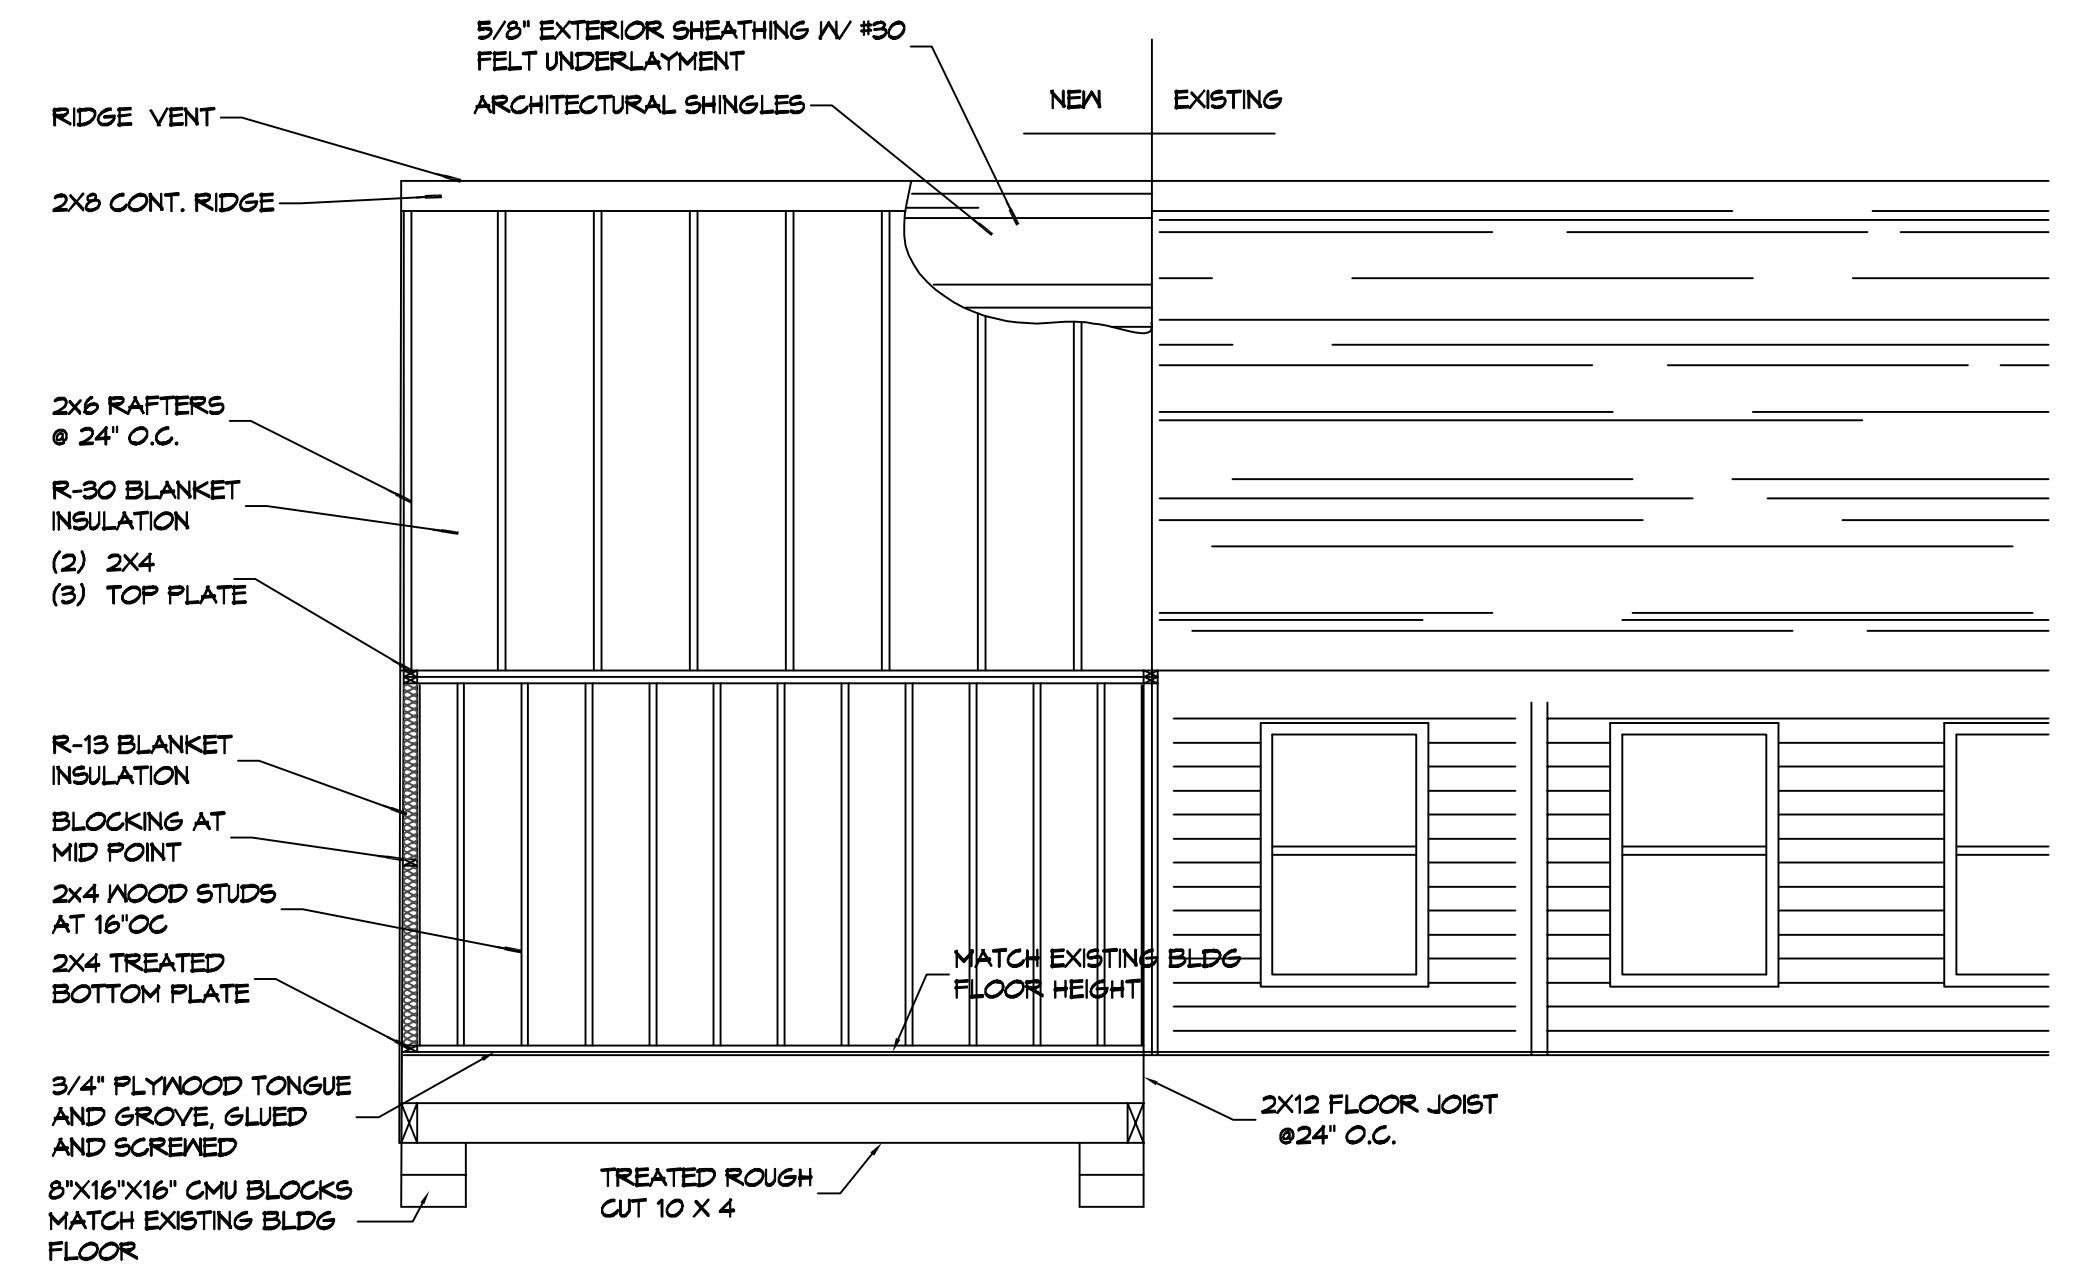

PARTIAL SECTION
 SCALE: 3/8" = 1'-0"

#	DESCRIPTION	DATE

SEAL:

FLEUR DE LIS
FITTE COMPANY
 442 FRENCH AVE
 SLIDELL, LA 70488
 JOB No: 18P-06181
 DATE: 10-06-18
 DRAWN BY: JTL
 CHECKED BY: CKD

SHEET TITLE:
 ROOF PLAN

DRAWING NUMBER:
A200
 SHEET No: 09 of 1