




3 LEVEL THREE LAYOUT
SCALE: 1/4" = 1'-0"
PLUMBING

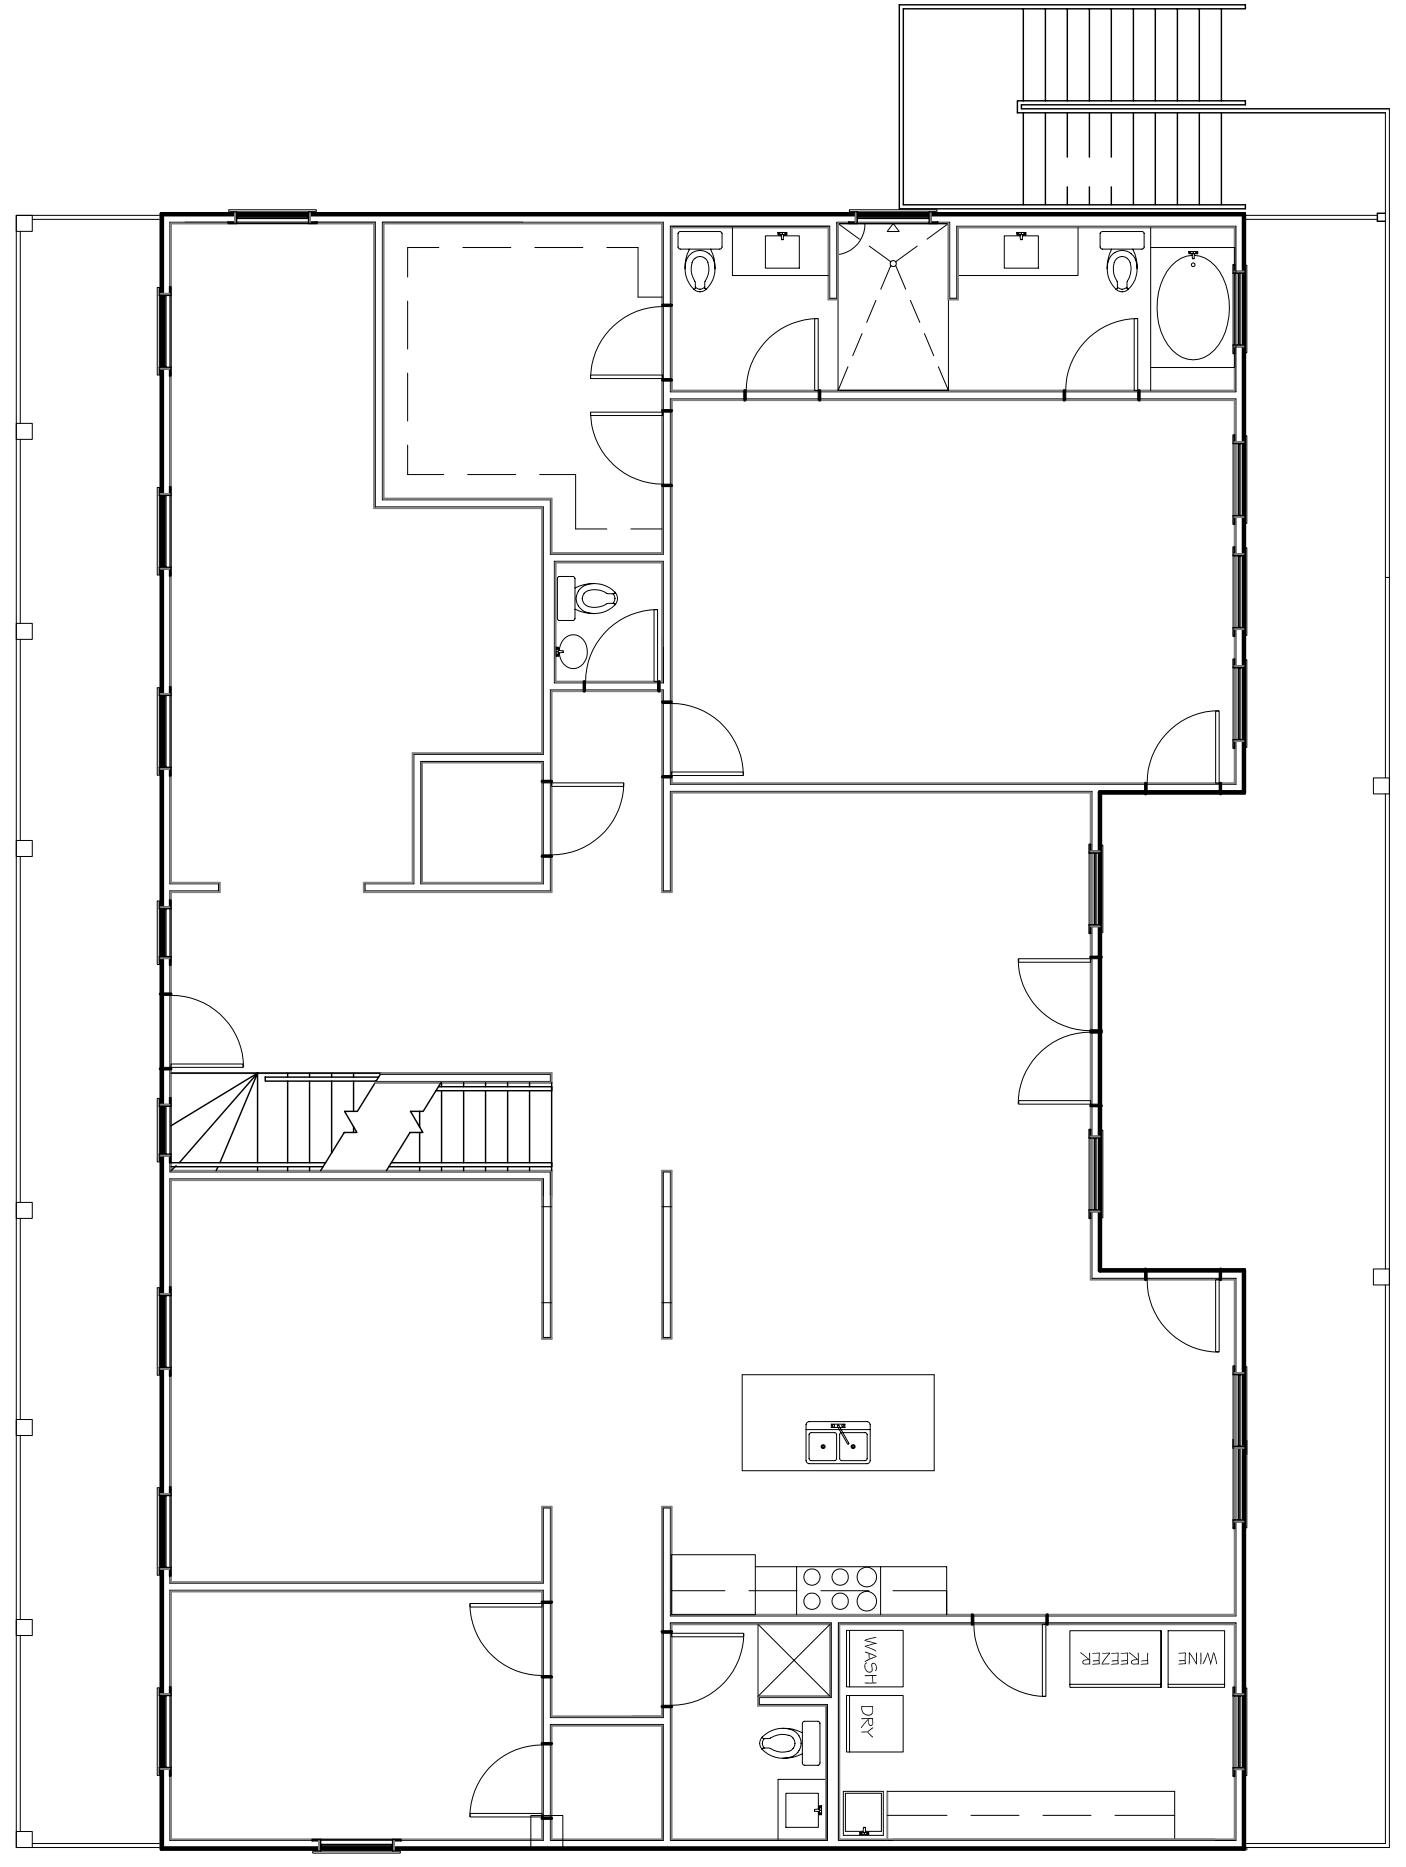

2 LEVEL TWO LAYOUT
SCALE: 1/4" = 1'-0"
PLUMBING

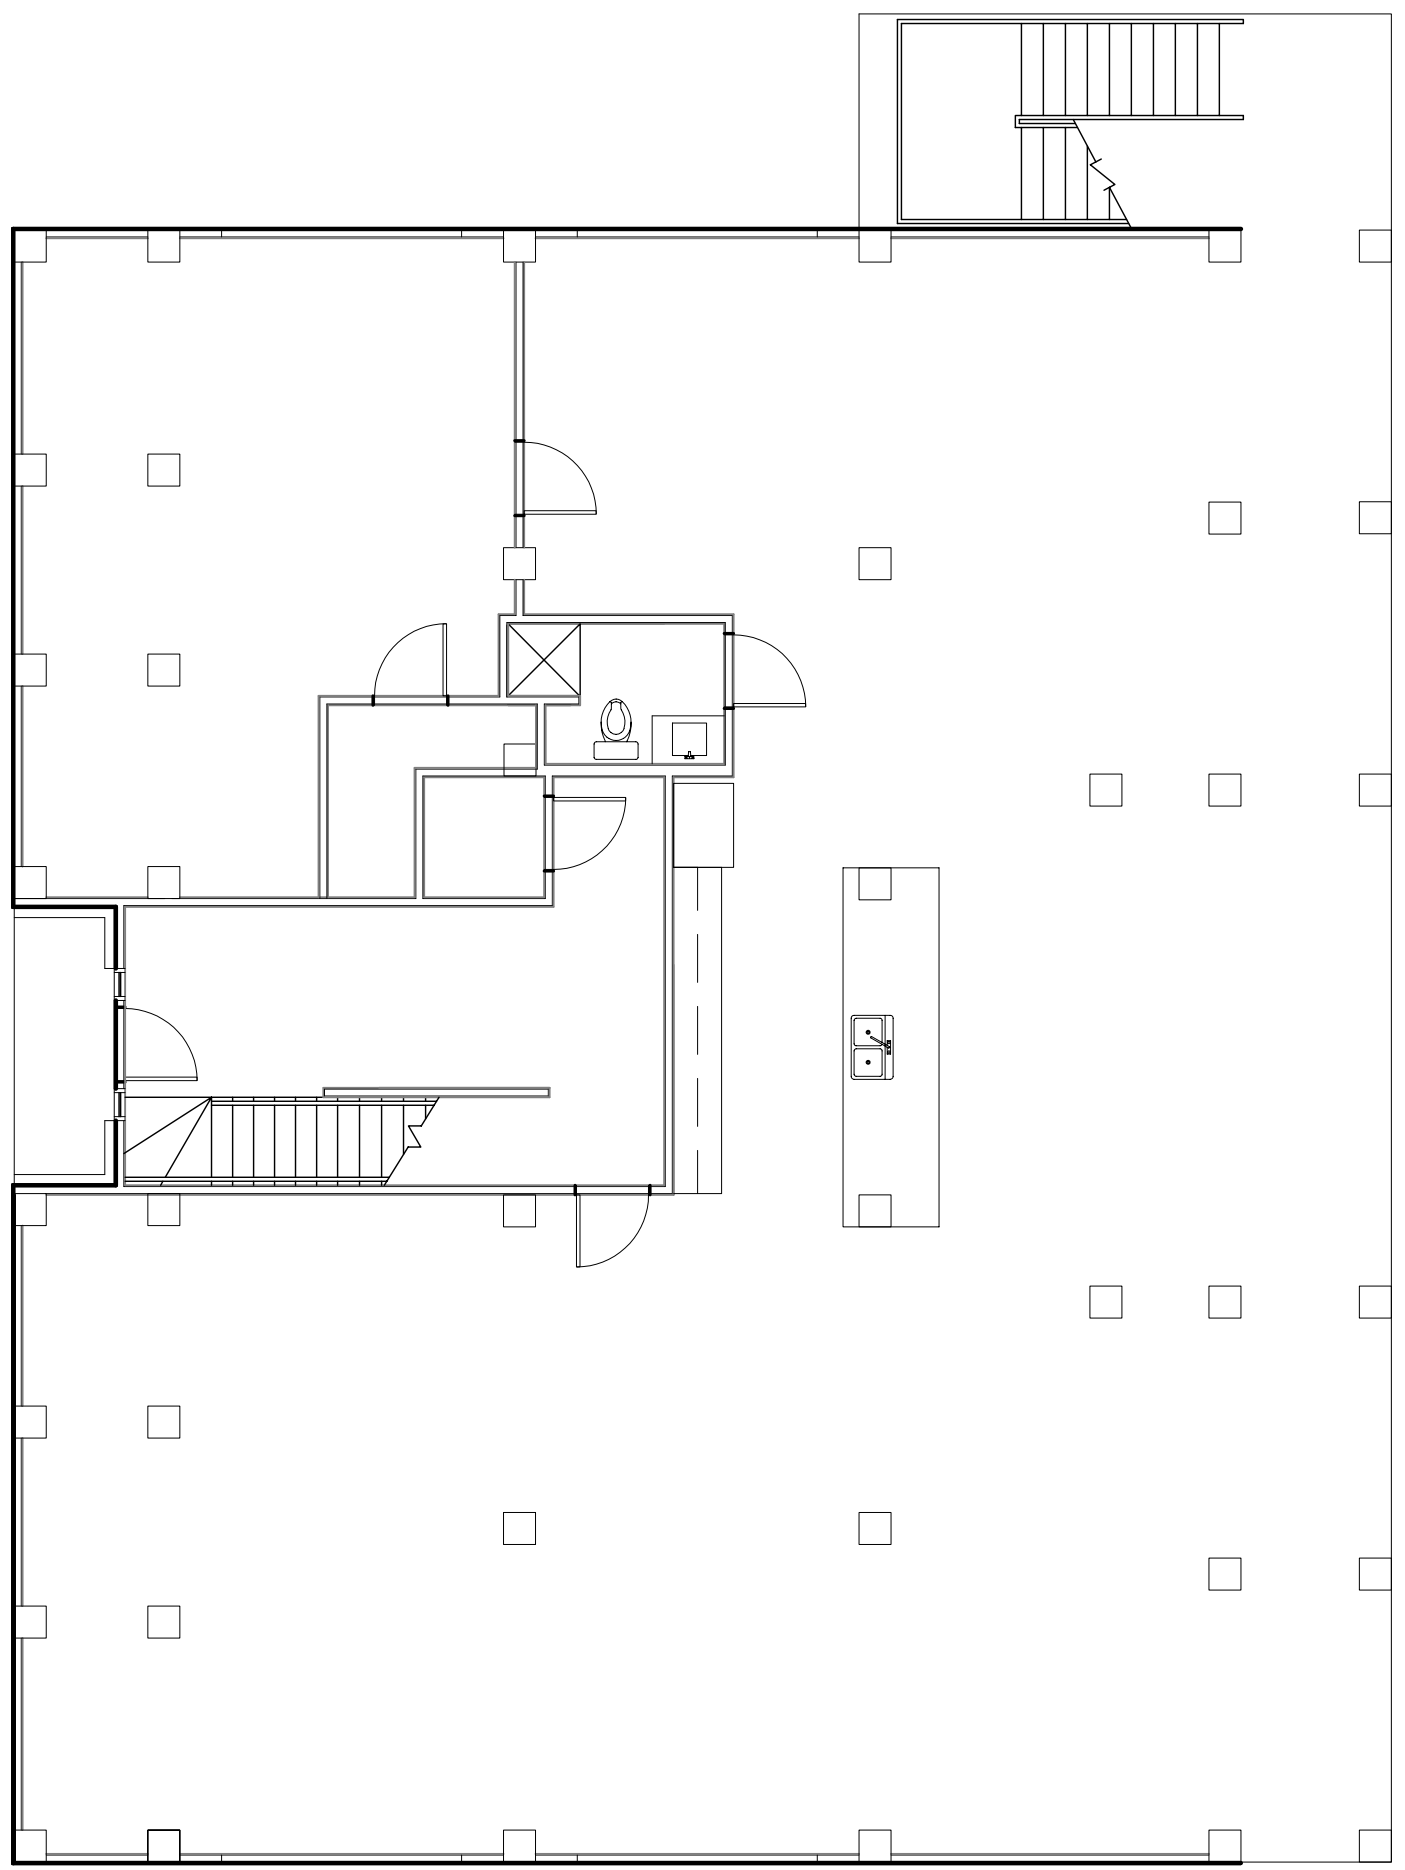

1 LEVEL ONE LAYOUT
SCALE: 1/4" = 1'-0"
PLUMBING

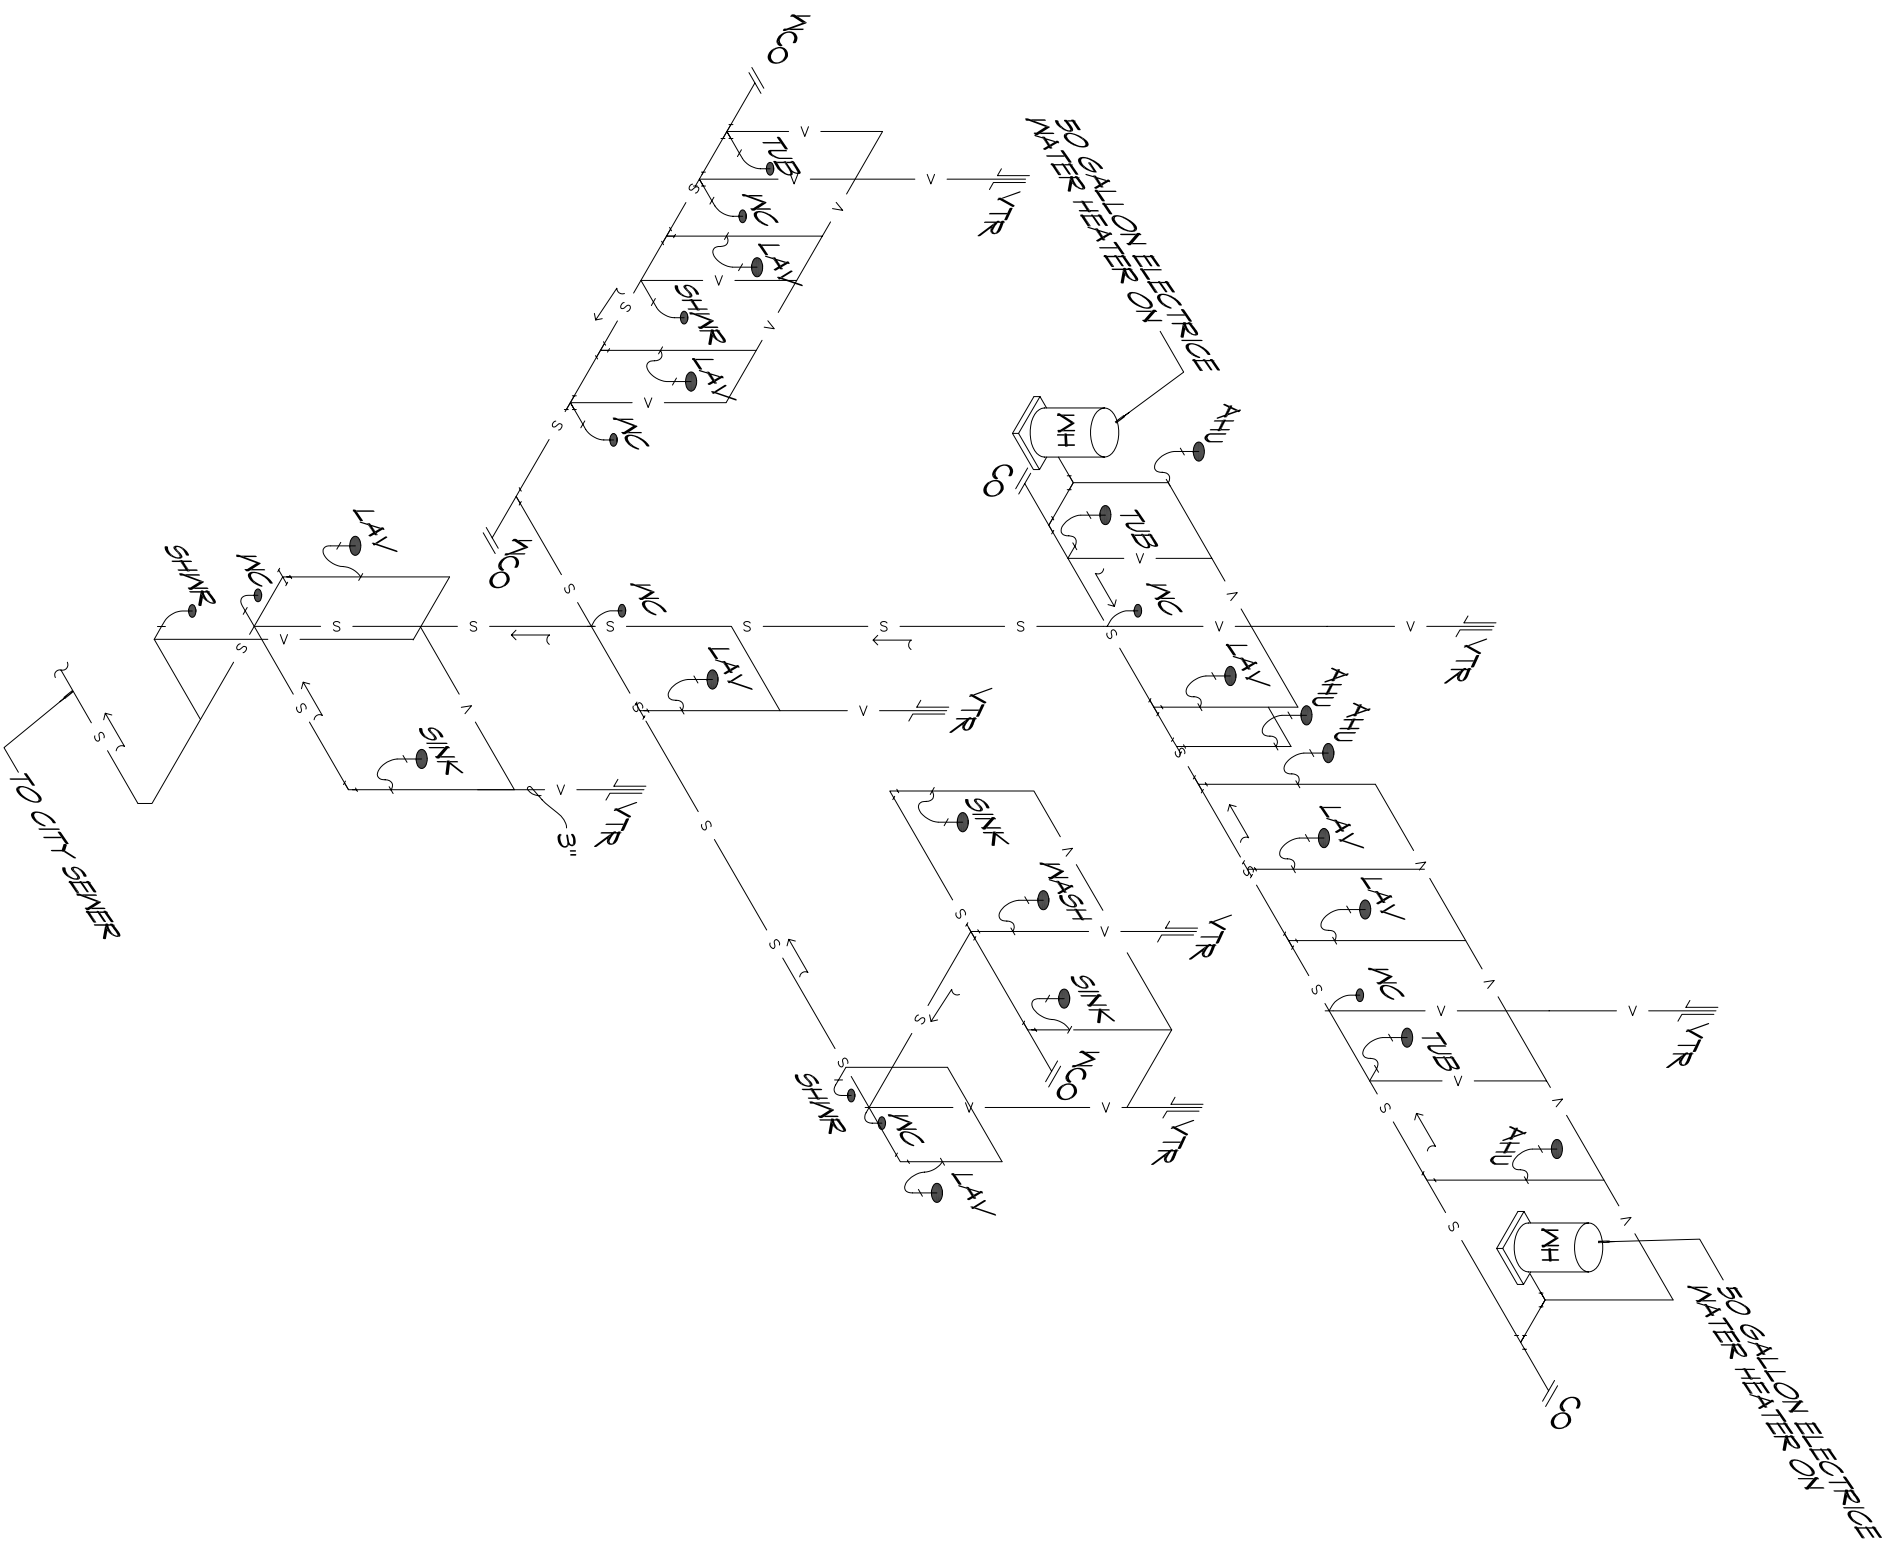

4 PLUMBING RISER
SCALE: 1/4" = 1'-0"
PLUMBING

| # | DESCRIPTION | REVISIONS | |
|---|-------------|-----------|--|
| | | DATE | |
| | | | |
| | | | |
554 Old Spanish Trail
Slidell, LA 70458
PH: 985.649.5832

www.dammonengineering.com
info@dammonengineering.com
Fax: 985.641.5950

NEW ESTATE FOR:
LISA & BRUCE CLEMENT

THREE JENNIFER LANE
SLIDELL, LOUISIANA 70458

JOB No: 2251 DATE: 04-03-15
DRAWN BY: CKD CHECKED BY: BAM

The above drawings and specifications, design and arrangements represented hereby are prepared by the project engineer and shall remain the property of Dammon Engineering, Inc. and shall not be used, reproduced or used in connection with any work or project other than the specific project for which they have been prepared and developed without written consent of Dammon Engineering, Inc. Your contact with these drawings or specifications shall constitute an acknowledgment of the above.

SHEET TITLE:
PLUMBING PLAN & RISER

DRAWING NUMBER:

SHEET NO.:
P101

10 OF 10