



FILE NAME: J:_REVIEWS\1801-2018 - Southside Cafe Dining CAFE - Mechanical.dwg PLOT DATE: 8/1/2018 10:52:52
 PLOTTER: HP DesignJet 2400 Series
 PLOTTING: HP DesignJet 2400 Series

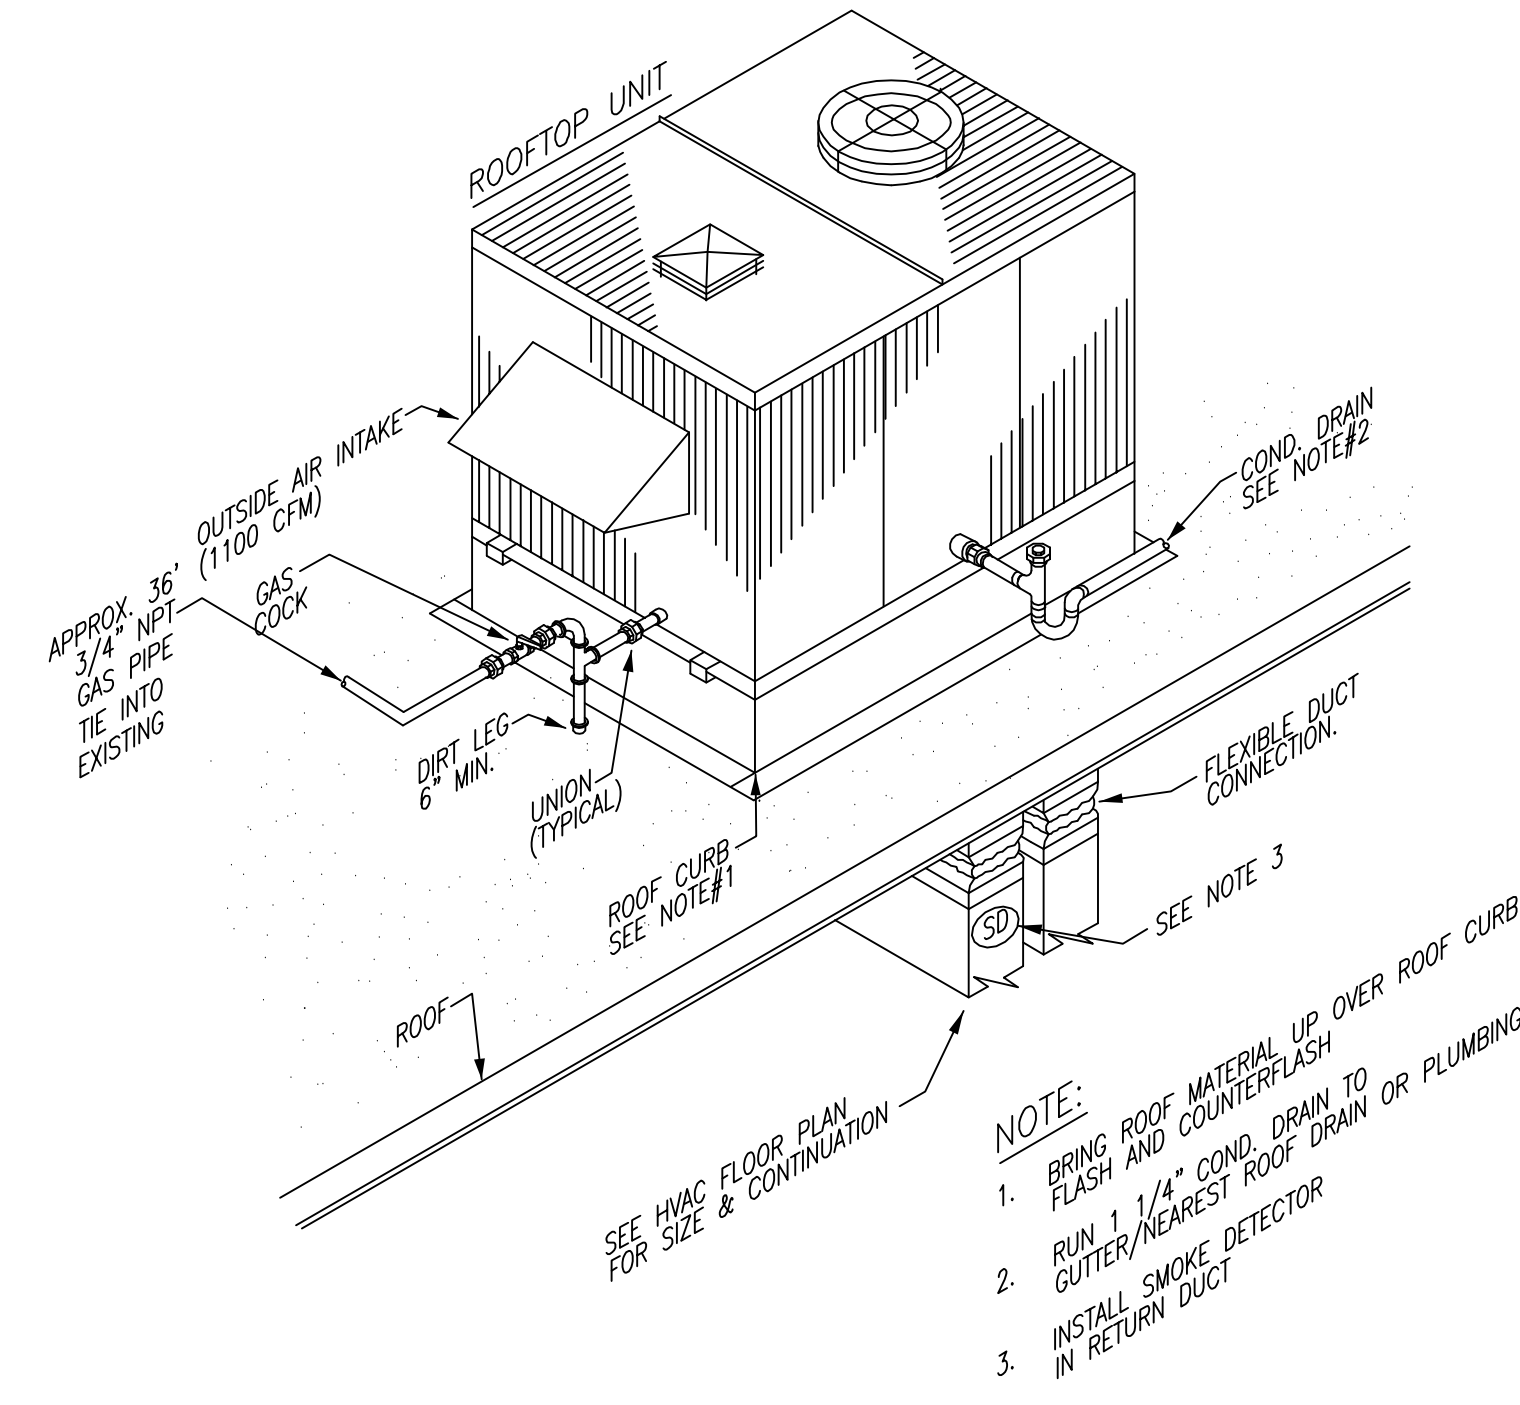

D TYPICAL ROOF TOP INSTALLATION AHU DETAIL

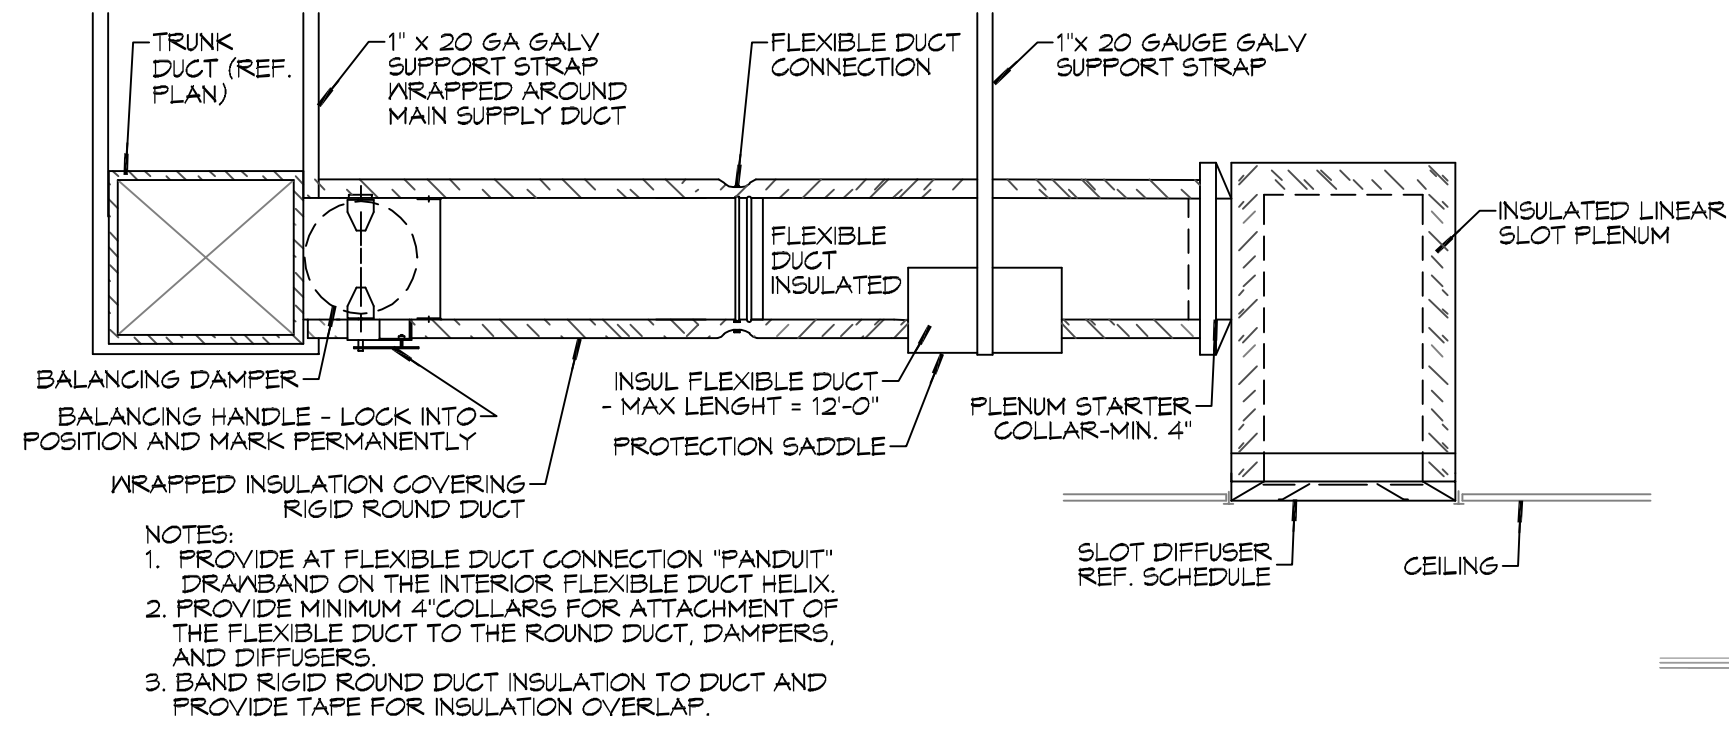

C DIFFUSER CONNECTION DETAIL - FLEX DUCT

B SQUARE ELBOW DETAIL

A SUPPLY DUCT TAKE-OFF DETAIL



18 DETAILS
SCALE: NTS

SPLIT SYSTEM HEAT PUMP SCHEDULE														
TAG	TRANE AIR HANDLER MODEL NO.	NOMINAL TONS	TOTAL CFM	OA CFM	COOLING				POWER			GAS HEAT		REMARKS
					MEH	SHC	Motor HP	ESP (" Hg)	VAC	Ph	MCA	MBH OUTPUT	MAX. AIR TEMP RISE (F)	
RTU-1	YSC12QH3	10	3400	190	121.1	77.1	2.75	0.4	208	3	52.6	120 / 84	5.0	1, 2, 3, 4, 5

- NOTES:**
- Cooling capacities to be rated in accordance with AHRI standard 210/240 for ASHRAE standard design weather conditions in New Orleans, LA.
 - Provide single point power connection, motorized outside air damper (0 - 50%) & condensate overflow switch.
 - Install units in accordance with manufacturer's recommendations.
 - Provide programmable 7/24 thermostat with lockup.
 - Provide new filters after commissioning and final acceptance.

DIFFUSER SCHEDULE				
Mark No.	Service	Neck Size	Description	
A	Supply Air	Ref. Plan	12"x 12" Plaque Face Diffuser, w/damper; Titus OMNI or equal	
B	N/A	N/A	N/A	
C	Supply Air	Ref. Plan	24" x 24" fixed pattern plaque, aluminized steel; Titus OMNI or equal	
D	Return Air	Ref. Plan	Perforated face return w/damper, aluminum; Price mdl 10 or equal	
E	Return Air	Ref. Plan	Perforated face return w/damper, aluminum; Price mdl 10 or equal	


1. Coordinate with Owner for colors and finish.

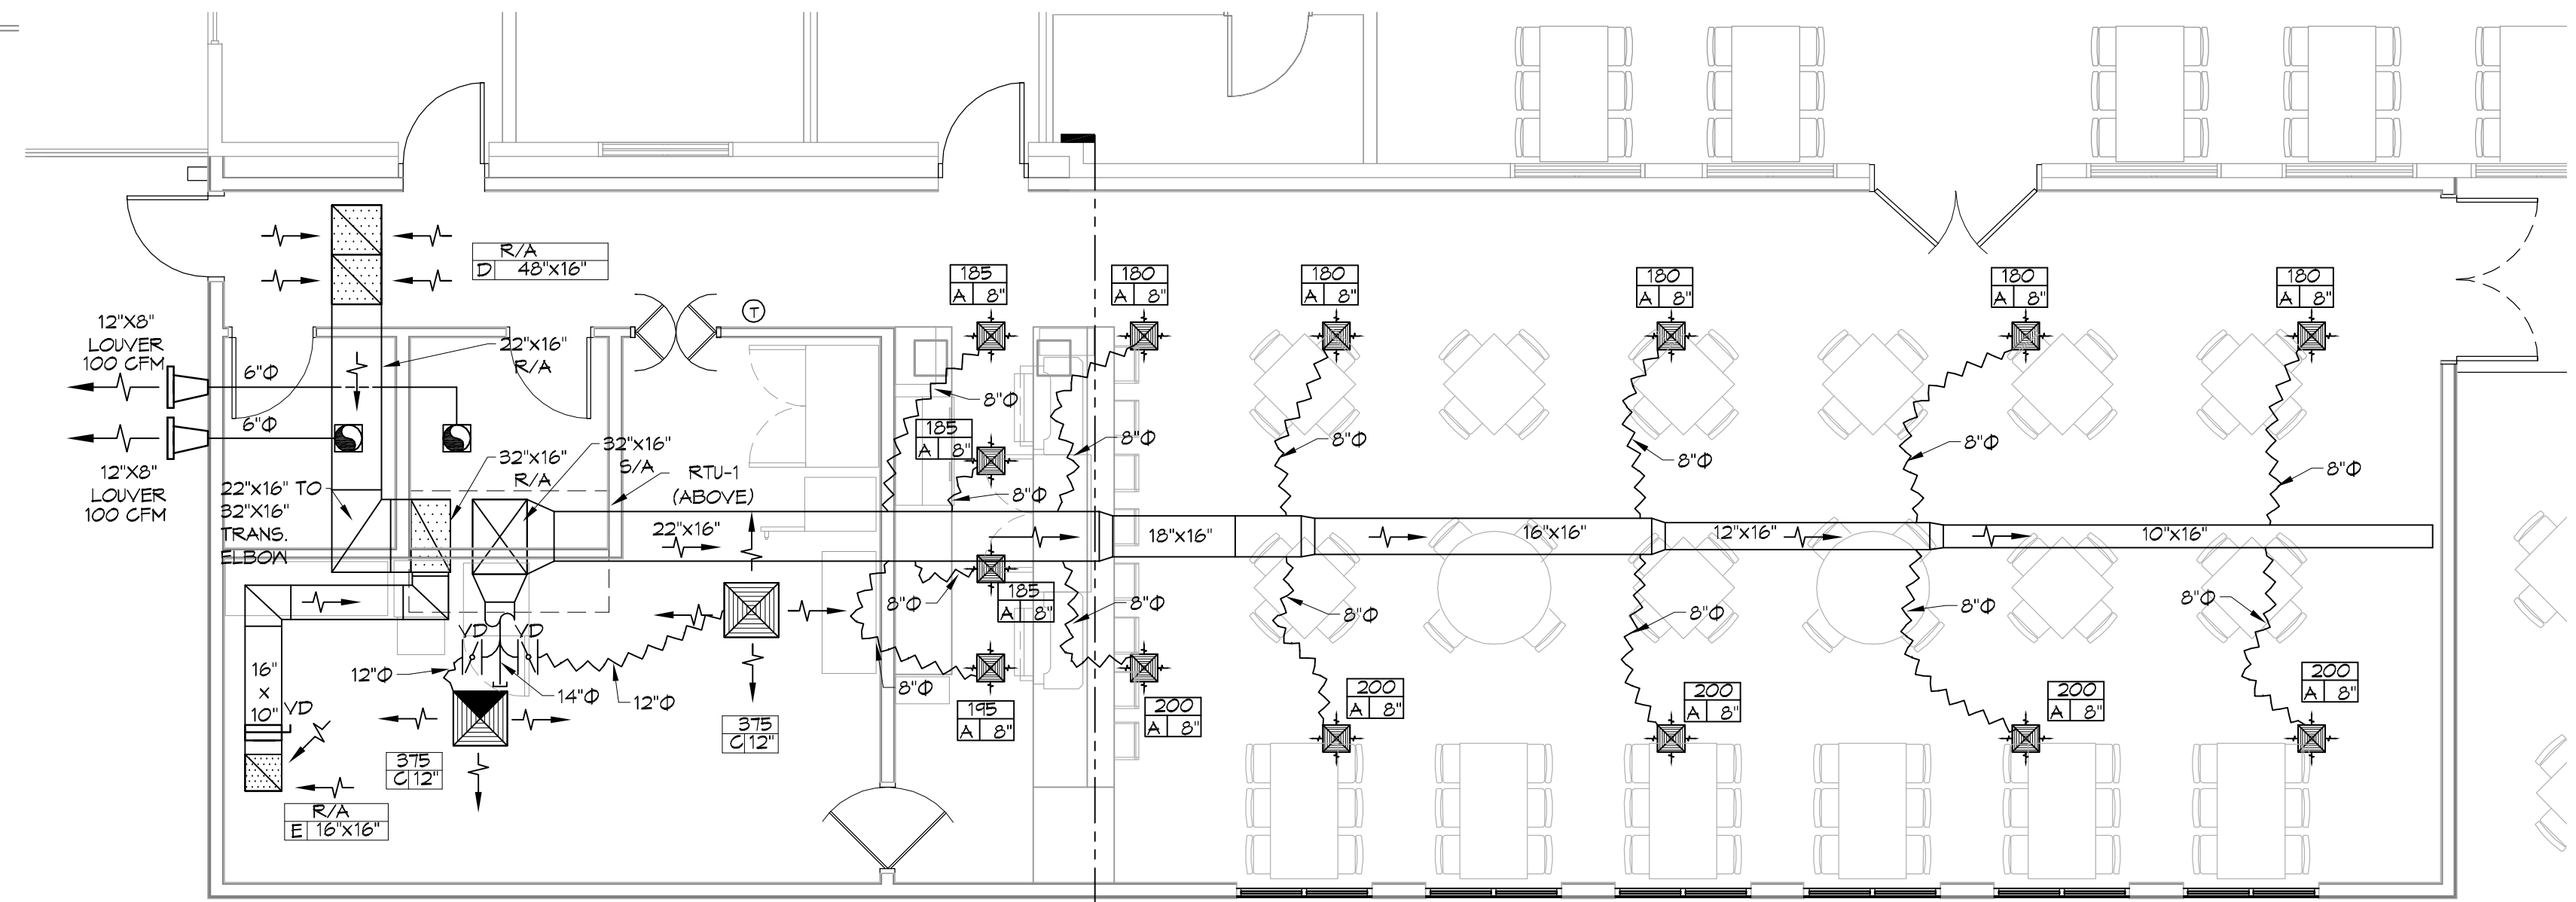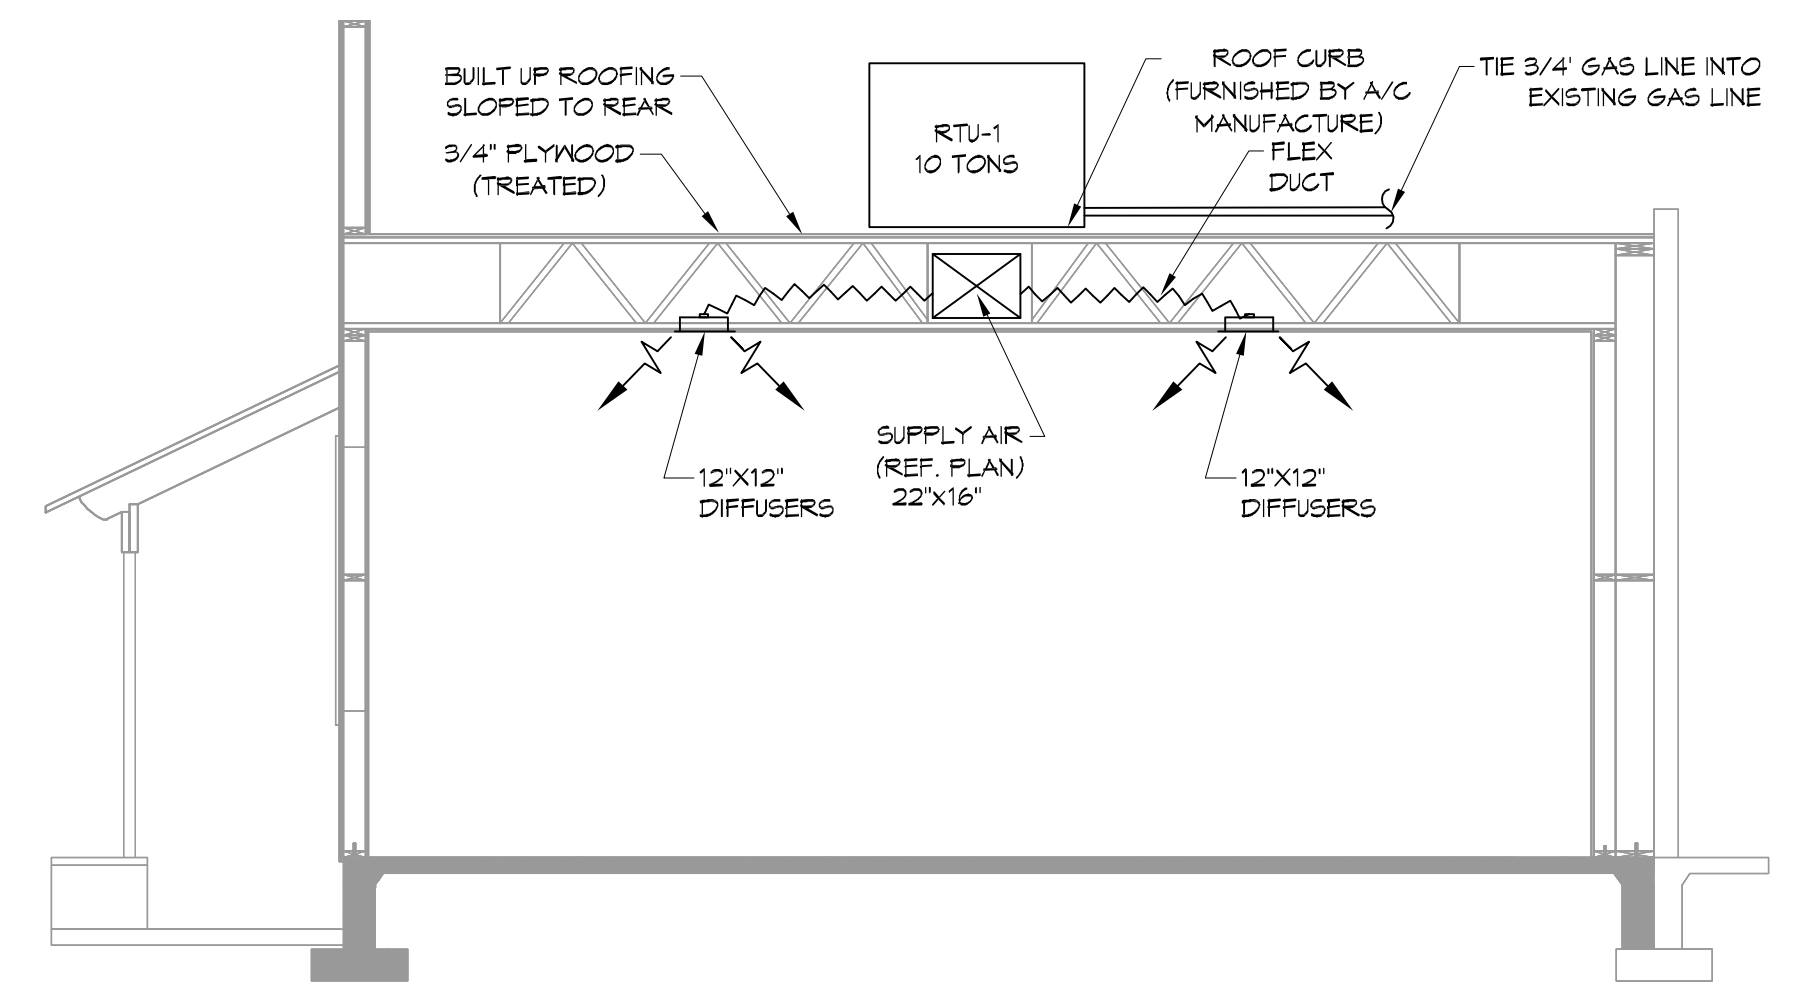

GENERAL HVAC NOTES

- CONCEALED DUCTWORK TO BE GALVANIZED SHEET METAL WRAPPED WITH FIBROUS GLASS DUCT WRAP WITH FSK VAPOR BARRIER, MIN R-6. INSTALLED PER SMACNA STANDARDS. DUCT WORK IMMEDIATELY DOWNSTREAM FROM RTU SHALL BE LINED FOR SOUND ATTENUATION.
- EXPOSED DUCTWORK TO BE GALVANIZED SHEET METAL LINED WITH FIBROUS GLASS DUCT LINER, MIN R-6. INSTALLED PER SMACNA STANDARDS.
- ROUND FLEXIBLE DUCT TO BE UL-181, CLASS 1, AIR DUCT MATERIALS.
- DUCT SIZES SHOWN ARE CLEAR INSIDE DIMENSIONS.
- IN ALL SYSTEMS OVER 2000 CFM AND LESS THAN 15,000 CFM, SMOKE DETECTORS SHALL BE INSTALLED IN ACCORDANCE WITH NFPA 72E IN THE RETURN DUCT DOWNSTREAM OF THE AIR HANDLING UNIT AND ALL FILTERS TO AUTOMATICALLY STOP THE FAN.
- PROVIDE UL LISTED 125 F° FIRESTAT IN RETURN AIR OF EACH SYSTEM UNDER 2000 CFM TO SHUT DOWN THE FAN IN THE EVENT OF FIRE.
- PROVIDE UL RATED FIRE DAMPERS WHERE REQUIRED AT ALL DUCT PENETRATIONS OF FIRE-RATED ASSEMBLIES AND WHERE REQUIRED BY CODE, INCLUDING OUTSIDE AIR INTAKES AND EXHAUST FANS.
- CONDENSATE DRAINS TO BE PVC PIPE RUN TO PLUMBERS P-TRAP WITHIN FIVE FEET OF AIR HANDLING UNITS.
- ALL AIR HANDLING SYSTEMS TO BE BALANCED TO ASSURE PROPER AIR FLOWS PER PLANS.
- ALL THERMOSTATS TO BE AUTOMATIC CHANGEOVER WITH HEAT SWITCH.
- EXHAUST FAN SHALL BE CONTROLLED BY A SWITCH ON THE WALL IN THE SAME LOCATION AS LIGHT SWITCH(S). PROVIDE BACK DRAFT DAMPER.
- PROVIDE AND INSTALL WATER PROOF GRILLE VENT IN PROPER ROOF LOCATION FOR PLUMBING FIXTURE EXHAUST.
- ALL SUPPLY AIR VENTS SHALL BE EQUIPPED WITH AIR CONTROL DAMPERS AT THE REGISTER.
- LOCATE OUTDOOR UNITS AS SHOWN ON ARCHITECTURAL DRAWINGS.
- REFRIGERANT LINES SHALL BE SIZED BY UNIT MANUFACTURER AND INSTALLED ACCORDING TO MANUFACTURER'S INSTRUCTIONS.
- FRESH AIR SHALL BE SUPPLIED TO EACH AIR HANDLER THROUGH EXTERIOR WALL DUCT SUPPLIED WITH A CONTROL DAMPER.
- ALL ELECTRICAL, MECHANICAL, AND PLUMBING PENETRATING FIRE WALLS SHALL BE FIRE CAULKED. (PENETRATIONS THROUGH RATED CONSTRUCTION SHALL BE SEALED WITH A MATERIAL CAPABLE OF PREVENTING THE PASSAGE OF FLAMES AND HOT GASES WHEN TESTED IN ACCORDANCE WITH ASTM-E8-14).
- ALL MECHANICAL SYMBOLS ARE DRAWN DIAGRAMMATICALLY. CONTRACTOR TO VERIFY WITH OWNER LOCATIONS OF VENTS, DAMPERS, REGISTERS, ETC.
- FLEXIBLE DUCTWORK LENGTH NOT TO EXCEED 12'-0".
- REFER TO REFLECTED CEILING PLAN FOR FINAL GRILLE AND DIFFUSER LOCATIONS AND COORDINATE AS REQUIRED.
- FINAL LOCATION OF TEMPERATURE CONTROLS TO BE COORDINATED WITH OWNER AT JOB SITE.
- PROVIDE AND INSTALL SMOKE DETECTORS AS APPROVED BY LOCAL AHS. PLACE NEAR R/A AND S/A OPENINGS OF AHU AND PROVIDE WITH ACCESS PANEL, WIRING BY ELECTRICAL CONTRACTOR.
- FRESH AIR INTAKES ARE REQUIRED TO HAVE MOTORIZED OR GRAVITY DAMPERS TO SHUT OFF WHEN SYSTEM IS NOT RUNNING.
- PROVIDE BIRD SCREENS AT ALL EXTERIOR MECHANICAL PENETRATIONS.
- COORDINATE WALL MOUNTED THERMOSTAT LOCATIONS WITH ALL OWNER FURNISHED ITEMS EITHER WALL MOUNTED OR FLOOR MOUNTED AGAINST PARTITIONS. REFER TO ARCHITECTURAL DRAWINGS.
- SEE ROOF PLAN FOR ALL ROOF PENETRATIONS.
- PROVIDE MIN 18 GA GALVANIZED SHEET METAL TO BLANK-OFF GABLE VENTS WHERE INTAKE/EXHAUST DUCTS OCCUR.

LEGEND

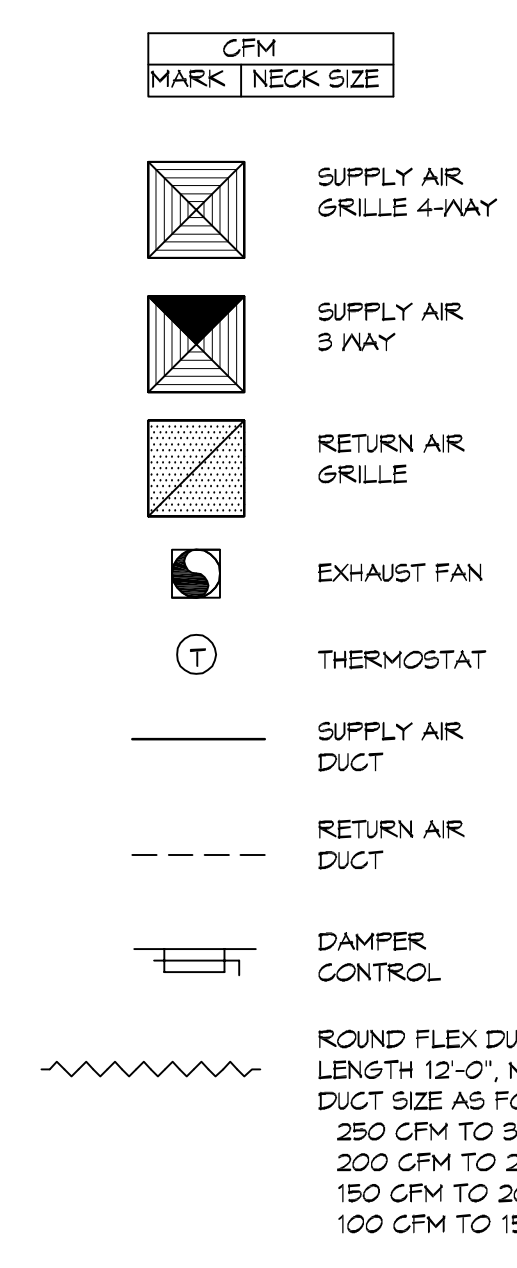

DAMMON ENGINEERING, INC.
 LOUISIANA & MISSISSIPPI
 www.dammonengineering.com
 info@dammonengineering.com
 Chief Engineer: Brian Mischick, PE
 554 Old Spanish Trail
 Slidell, LA 70468
 PH: 985.649.5832

#	DESCRIPTION	DATE
1	REPLACE LINEAR DIFFUSERS	1/18/2018

SEAL:

NEW DINING ADDITION
SOUTHSIDE CAFE
 3154 PONTCHARTRAIN DR
 SLIDELL, LA 70468
 JOB No: 2584 | DATE: 02-01-2018
 DRAWN BY: JAGSM | CHECKED BY: CAC

SHEET TITLE:
MECHANICAL FLOOR PLAN, SCHEDULES AND DETAILS

DRAWING NUMBER:

M101

SHEET No: 14 of 15