



ELECTRICAL PARTIAL-ROOF PLAN
N.T.S.

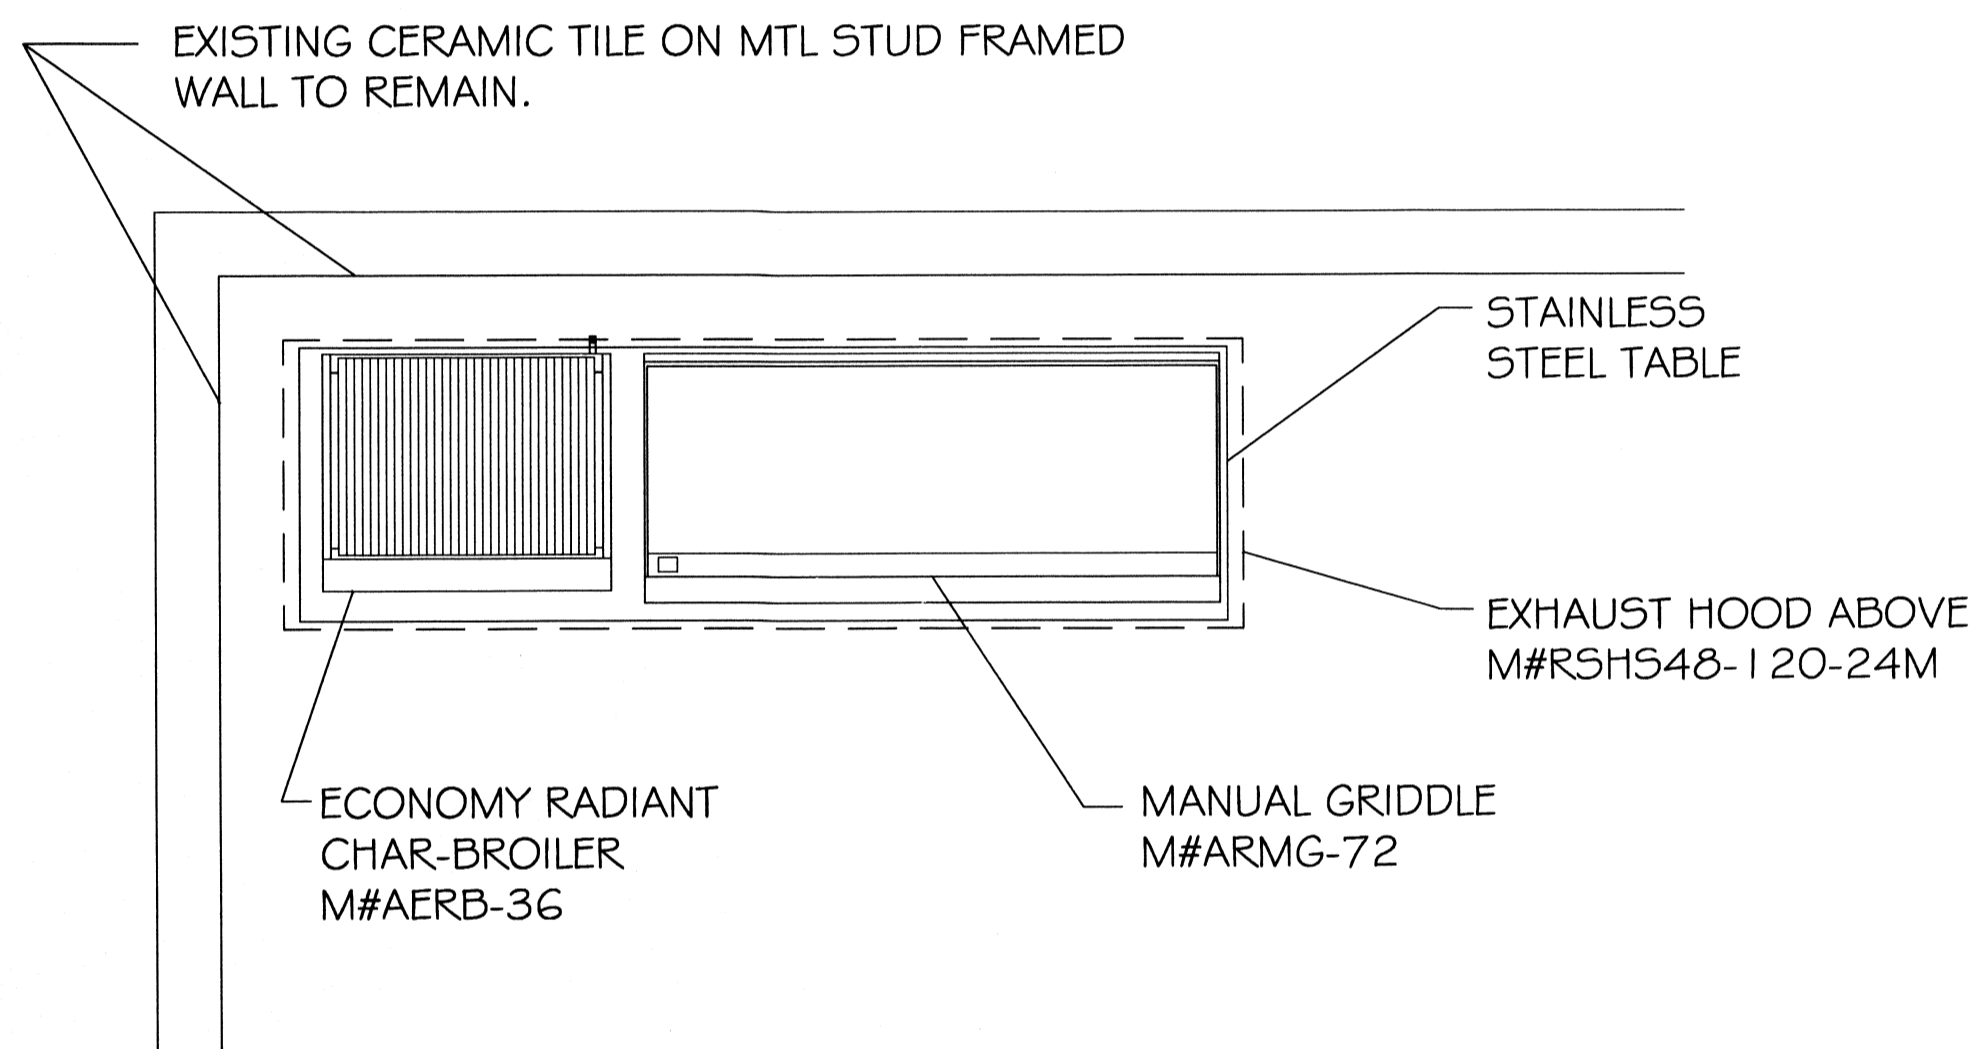


PARTIAL PLAN VIEW OF COOKING EQUIPMENT
N.T.S.

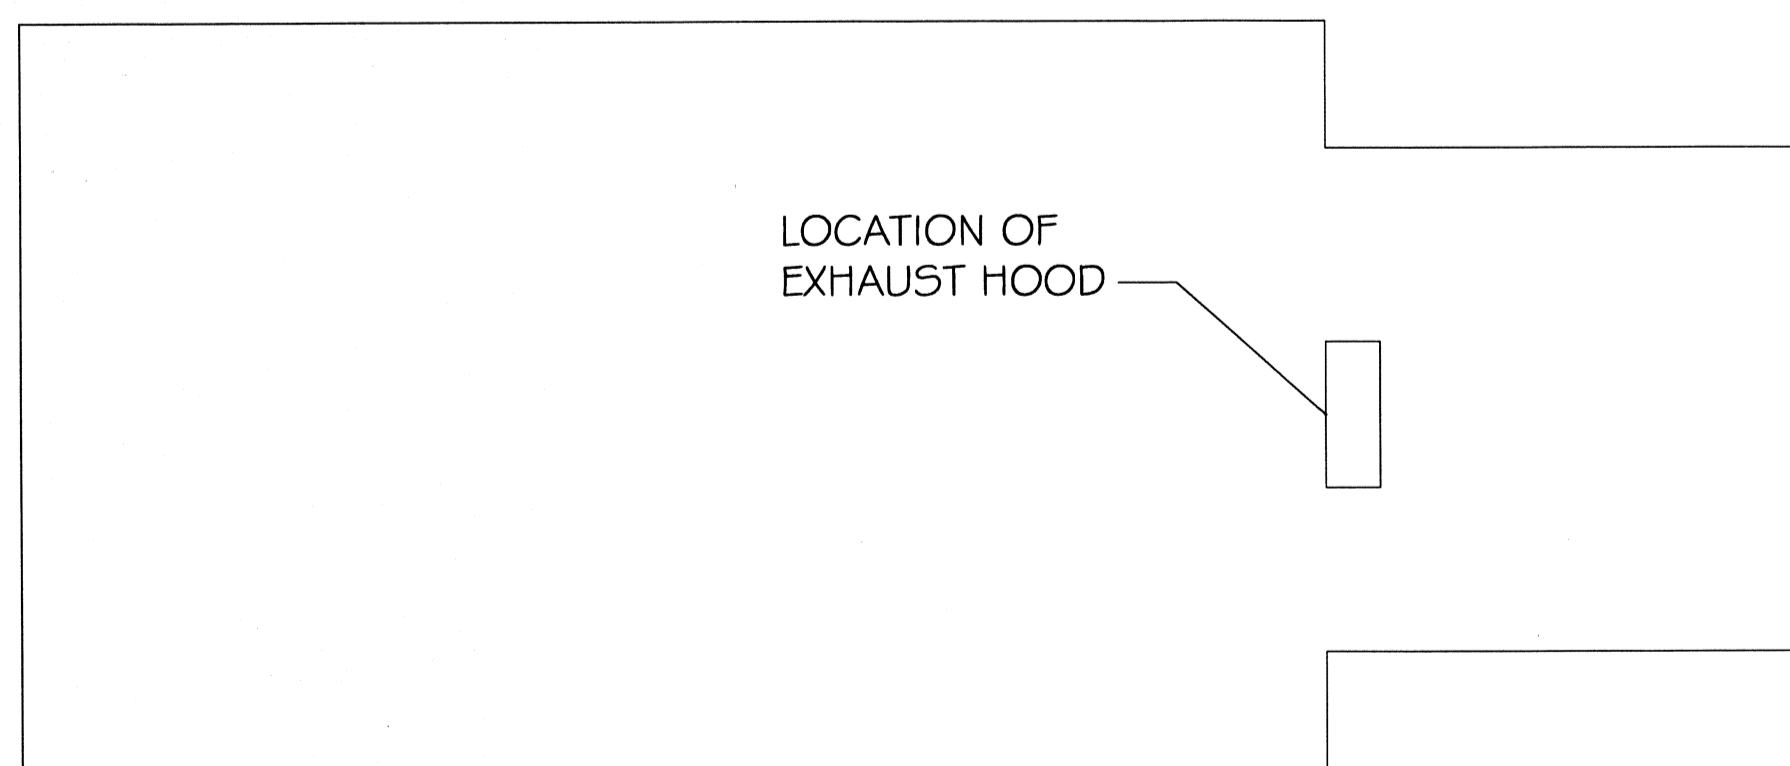

EXISTING BUILDING / EXHAUST HOOD LOCATION
N.T.S.


HOOD INFORMATION TABLE									
MODEL	LGTH	W	L	H	FILTERS	TOTAL CFM	DUCT OPENING	FAN RECOMMEND	
								EXHAUST	MAKEUP AIR 85%
R5H54B-120-24M	10'	48"	120"	24"	5	4000	288 SQ. IN.	BDU-184	5-15 3/4 HP

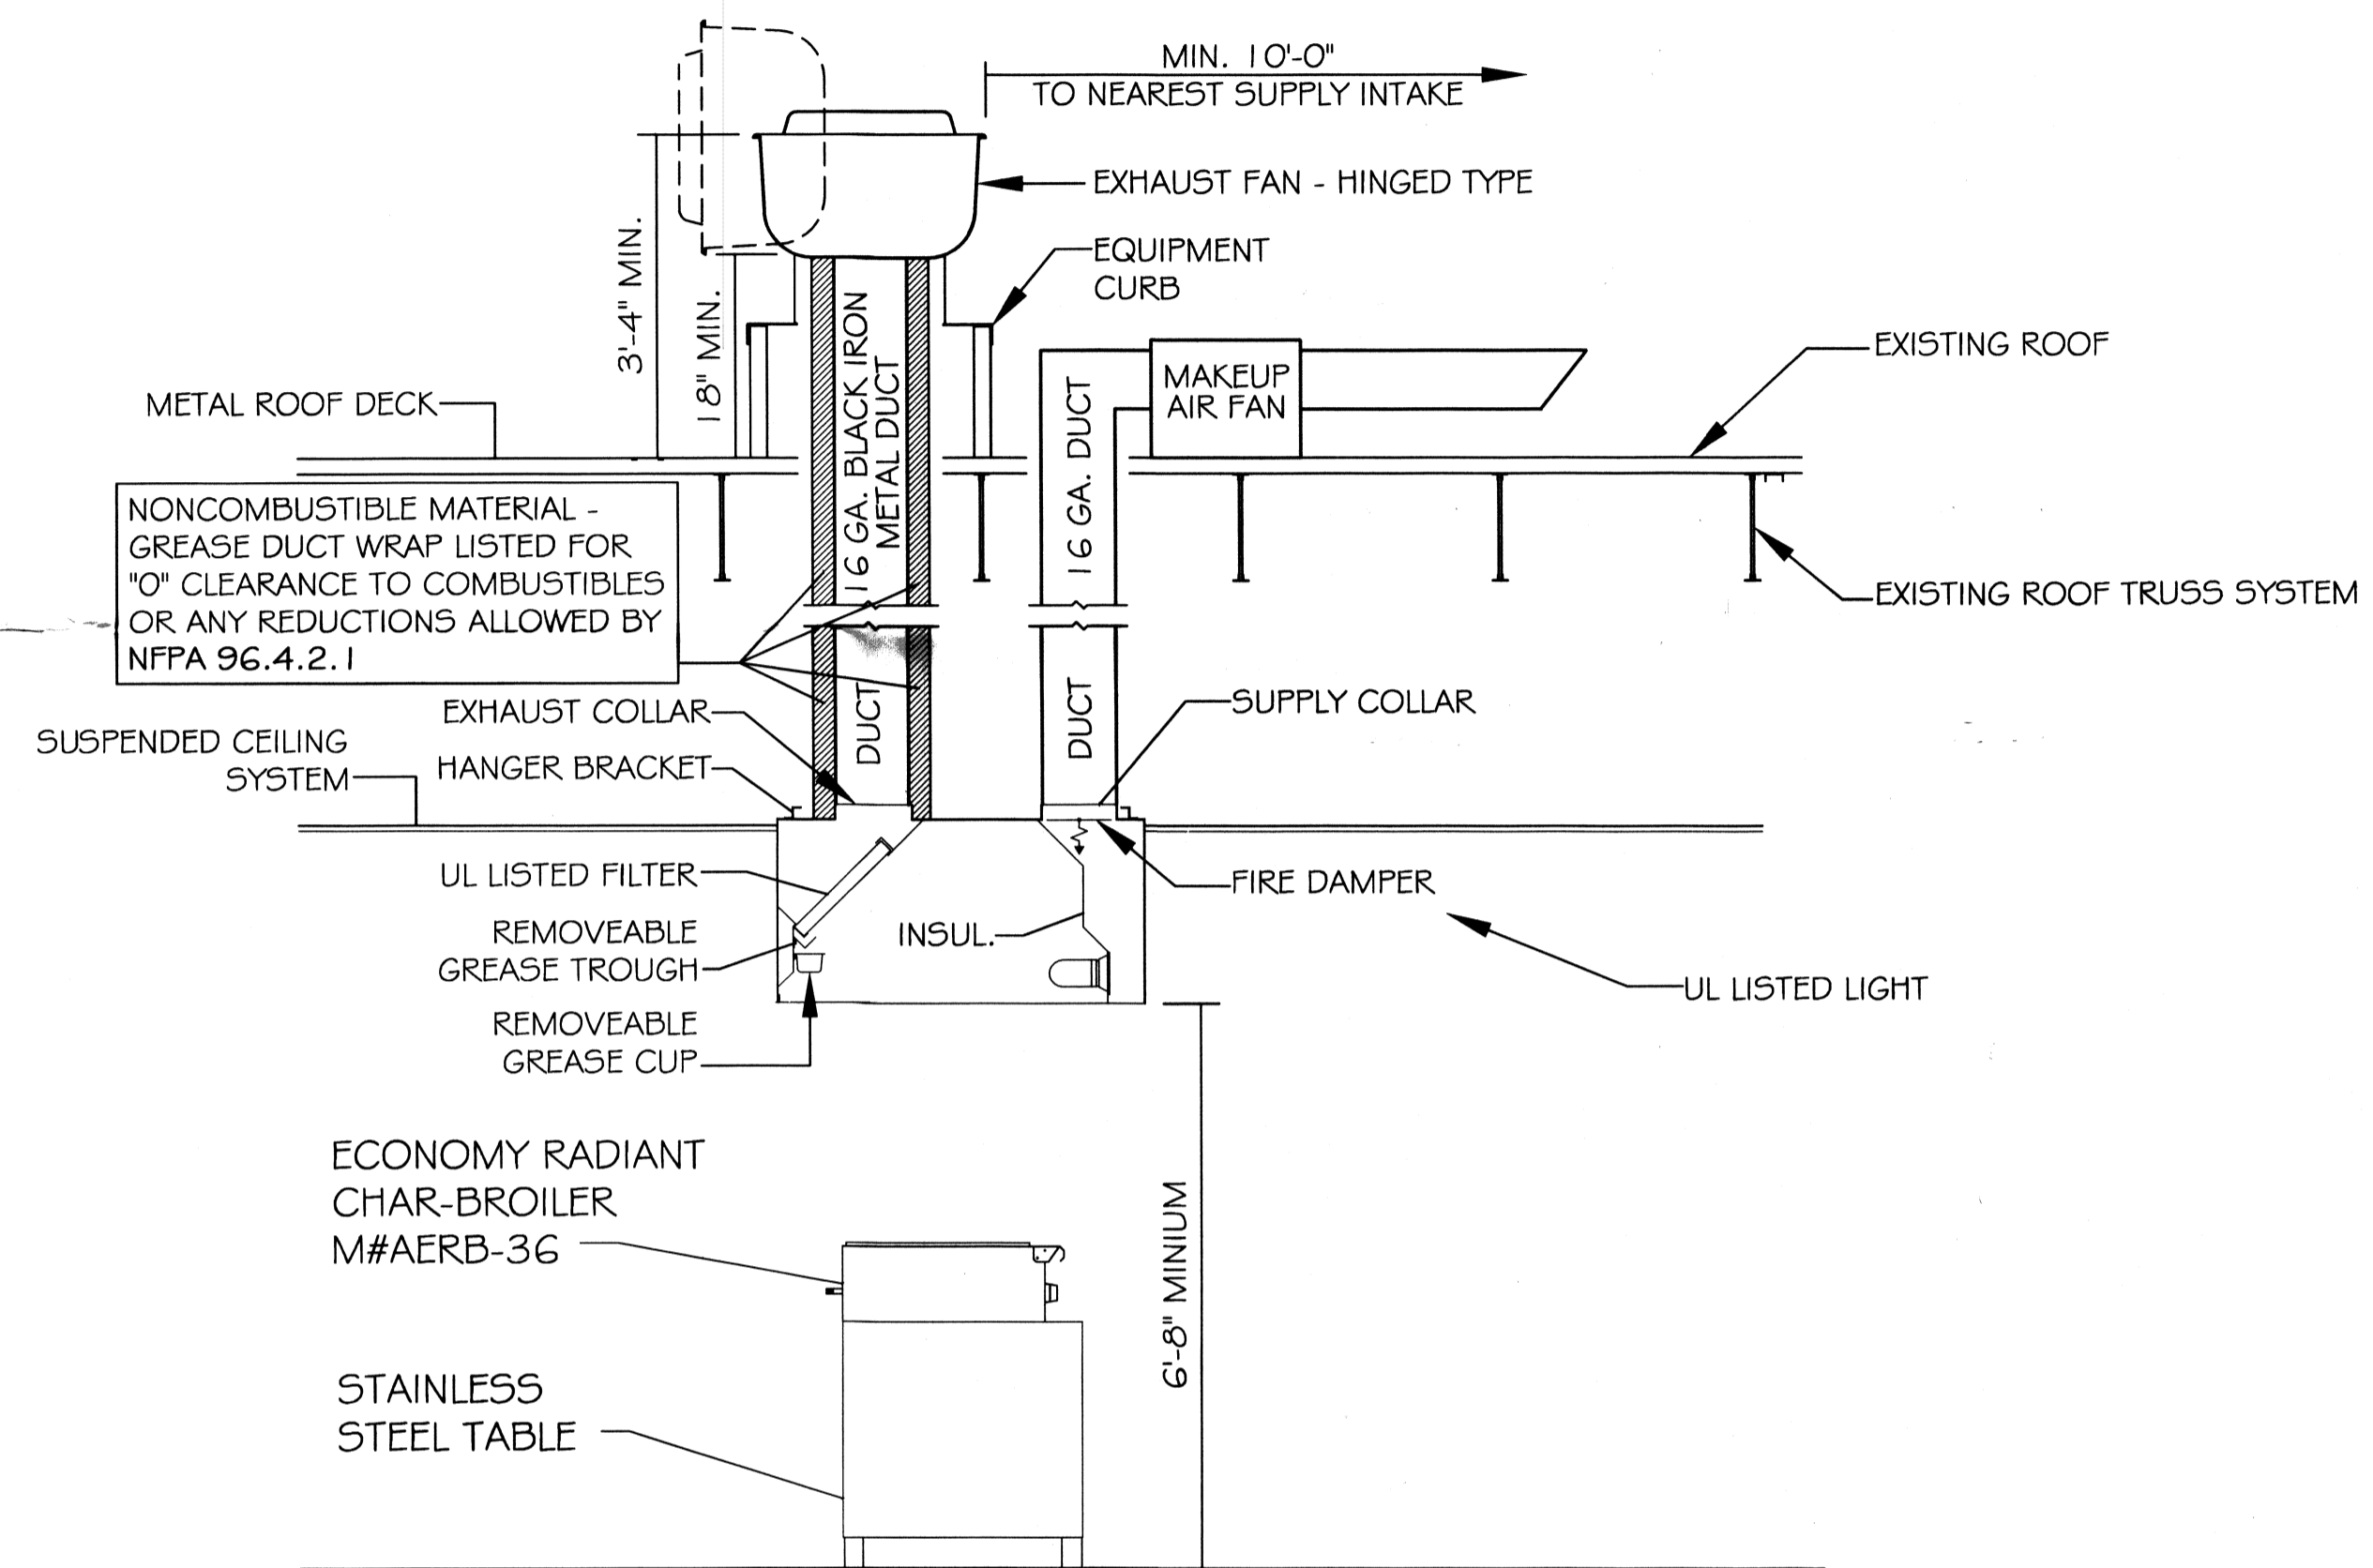

TYPICAL HOOD & DUCT INSTALLATION
W/CLEARANCE REDUCTION MATERIALS TO PROTECT COMBUSTIBLES
NOT TO SCALE

KITCHEN HOOD SYSTEM NOTES

1. DRAWINGS ARE DRAWN DIAGRAMATIC. FIELD VERIFY ALL RELATED CONDUITS & WIRING SIZES, LOCATIONS, GAS ROUTES, AND CONDITIONS PRIOR TO INSTALLATION OF HOOD.
2. REFERENCE SPECIFICATIONS FOR ADDITIONAL REQUIREMENTS.
3. SUBCONTRACTOR TO SUBMIT SHOP DRAWINGS AND REVIEW PACKAGE SUITABLE FOR FIRE MARSHAL KITCHEN HOOD CHEMICAL FIRE SUPPRESSION SYSTEM REVIEW.
3. PROVIDE GAS SHUTOFF VALVE FOR ALL EQUIPMENT UNDER HOOD CONNECTED TO HOOD EXHAUST SYSTEM.
4. PROVIDE SHUNT TRIP BREAKERS FOR ALL EQUIPMENT UNDER HOOD CONNECTED TO HOOD EXHAUST SYSTEM.

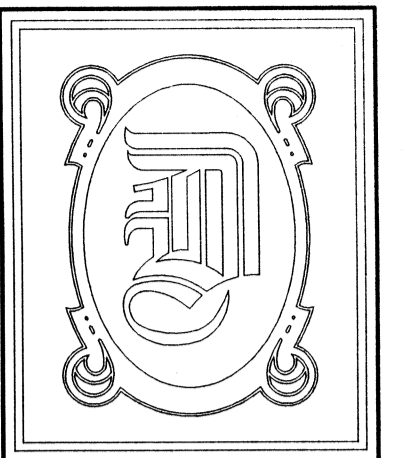

DAMMON ENGINEERING, INC.

CHIEF ENGINEER
EMMETT DAMMON, P.E.

CHIEF ARCHITECT
ROBERT WILTSE

554 OLD SPANISH TRAIL
SLIDELL, LA. 70458
OFFICE: 985-649-5832
FAX: 985-641-5950

WEBSITE:
WWW.DAMMONENGINEERING.COM

EMAIL:
DAMMONENGG@BELLSOUTH.NET

ARCHITECTURE
ENGINEERING
STUDIES
PLANNING
INVESTIGATION
EXPERT WITNESS

CRAZY BUFFETT
1100 ROBERT ROAD
SLIDELL, LA
70458

NEW EXHAUST HOOD,
GRIDDLE &
CHAR-BROILER

Robert Wiltse

REV:

SCALE: AS NOTED

JOB#:

DATE: 07-09-12

SHEET

A-1

OF

State Fire Marshal
Processed as
Exemption No. 418751
By: RWZ
Date: 7/16/12