

**DAMMON**  
ENGINEERING, INC.

CHIEF ENGINEER  
EMMETT  
DAMMON, P.E.  
CHIEF ARCHITECT  
ROBERT  
WILTSE

1095 FLORIDA AVENUE  
SLIDELL, LA. 70458  
OFFICE: 985-649-5632  
FAX: 985-641-5950

WEBSITE:  
WWW.DAMMONENGINEERING.COM  
EMAIL:  
DAMMONENG@Bellsouth.net

ARCHITECTURE  
ENGINEERING  
STUDIES  
PLANNING  
INVESTIGATION  
EXPERT WITNESS

**NEW OFFICE  
COMPLEX**

CHILD DEVELOPMENT  
COUNCIL OF  
ACADIANA, INC.  
OPELOUSAS, LA

UTILITY  
PLAN

REV: 12-7-09 CONST.

SCALE: AS NOTED


JOB#: 2030

DATE: 10-19-09

SHEET 6

**C-5**

OF 26

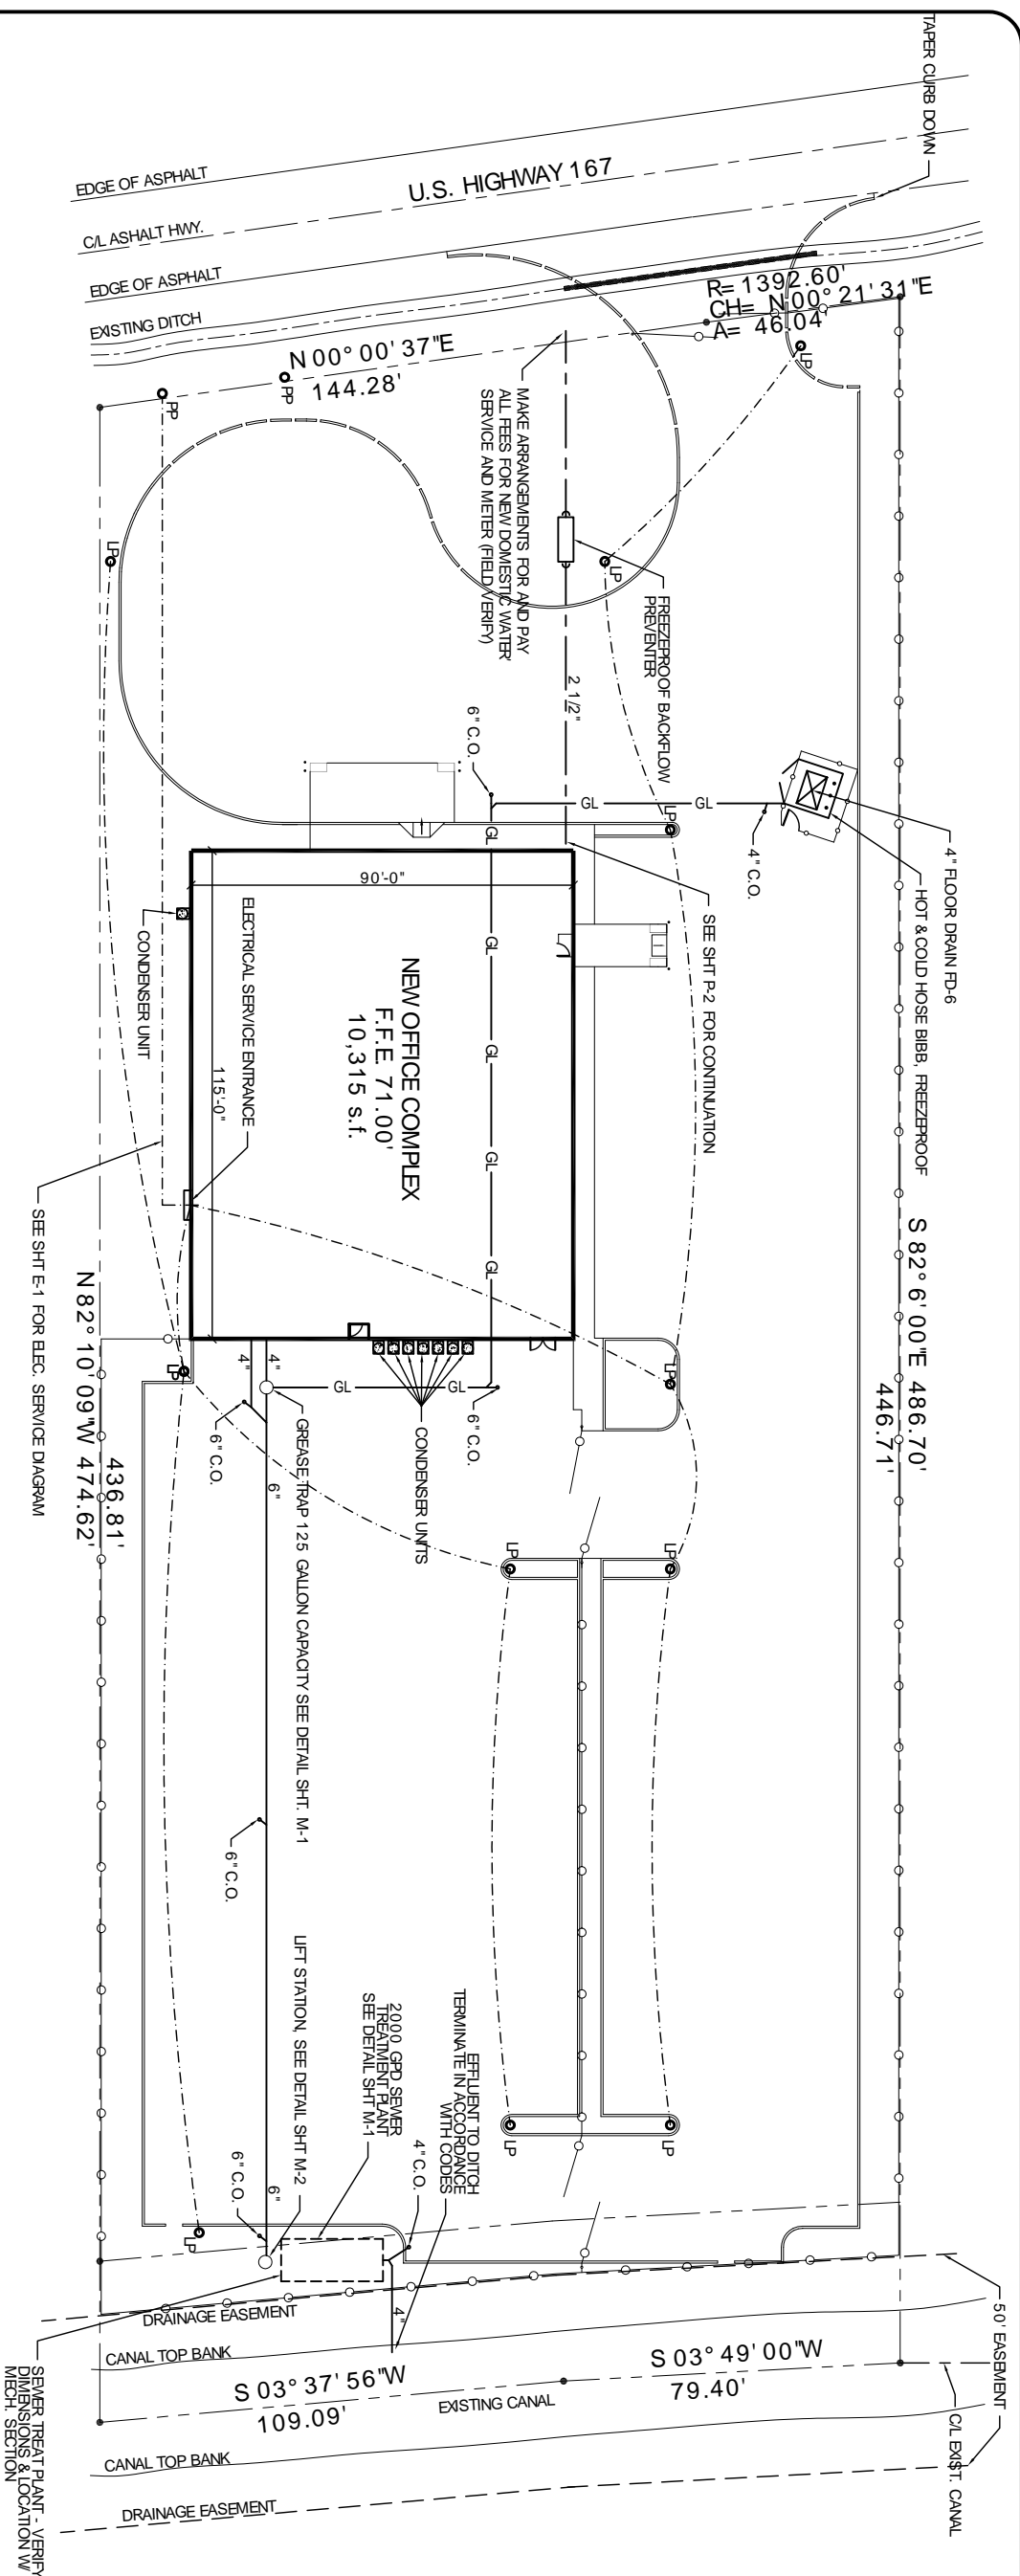

UTILITY PLAN  
SCALE: 1"=20'-0"

- LEGEND**
- - - - - PROPERTY LINE
  - NEW BUILDING OUTLINE
  - - - - - NEW SECURITY FENCE
  - - - - - COLD WATER PIPING LINE
  - - - - - GREASE LINE PIPING
  - - - - - SOIL & WASTE PIPING LINE
  - - - - - POWER LINE