



LOFT PLAN
SCALE: 1/8" = 1'-0"

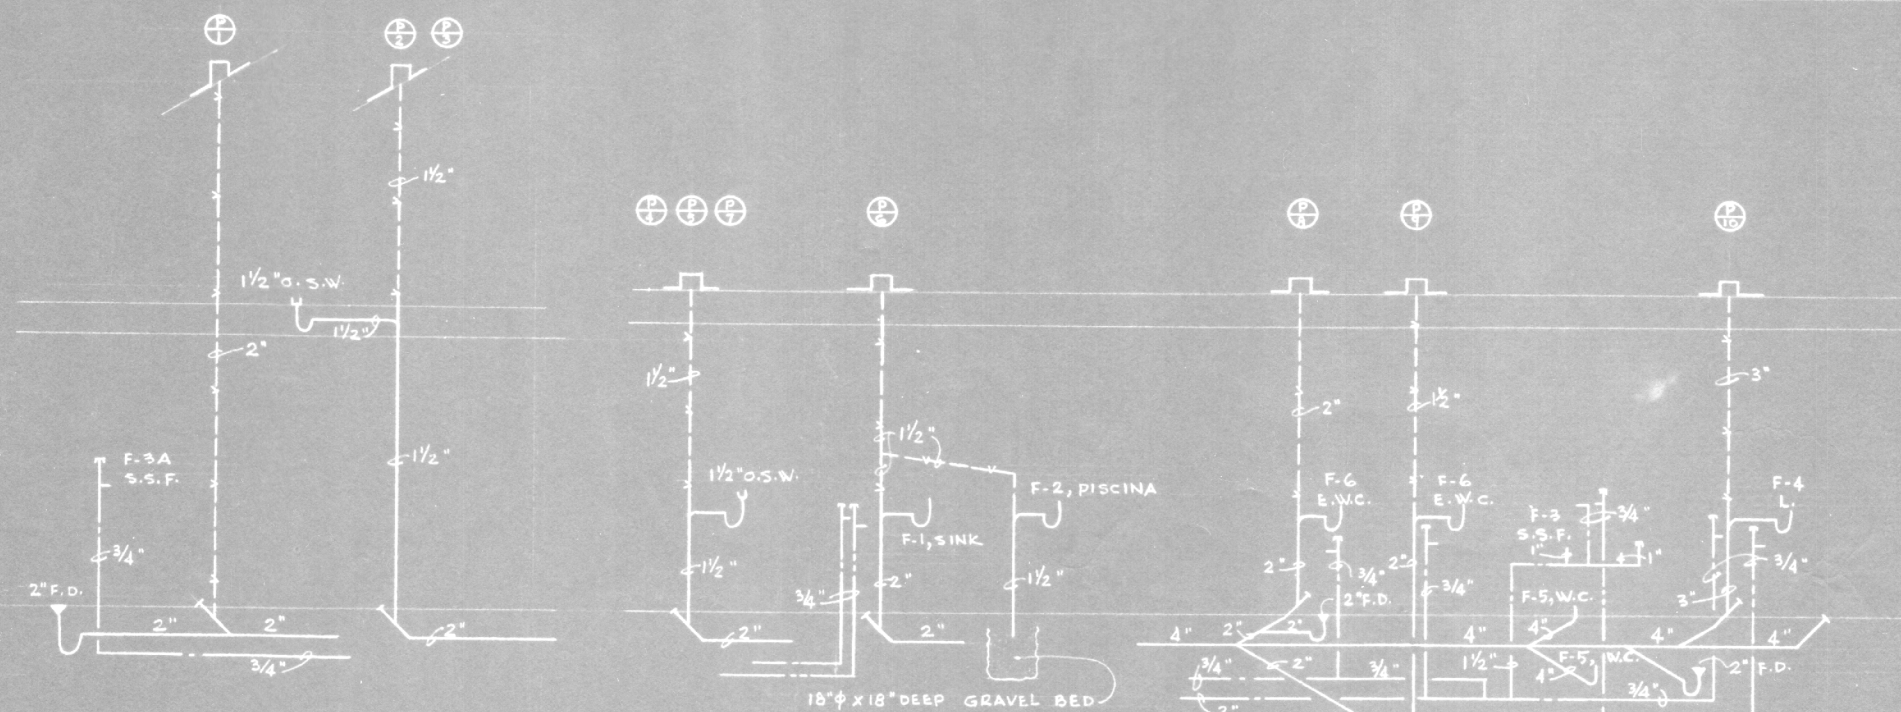


RISER DIAGRAM

SYMBOLS

- F-1 PLUMBING FIXTURE, F. NO. REFERS TO SPECS.
- COLD WATER PIPING
- HOT WATER PIPING
- GAS PIPING
- WASTE PIPING
- VENT PIPING

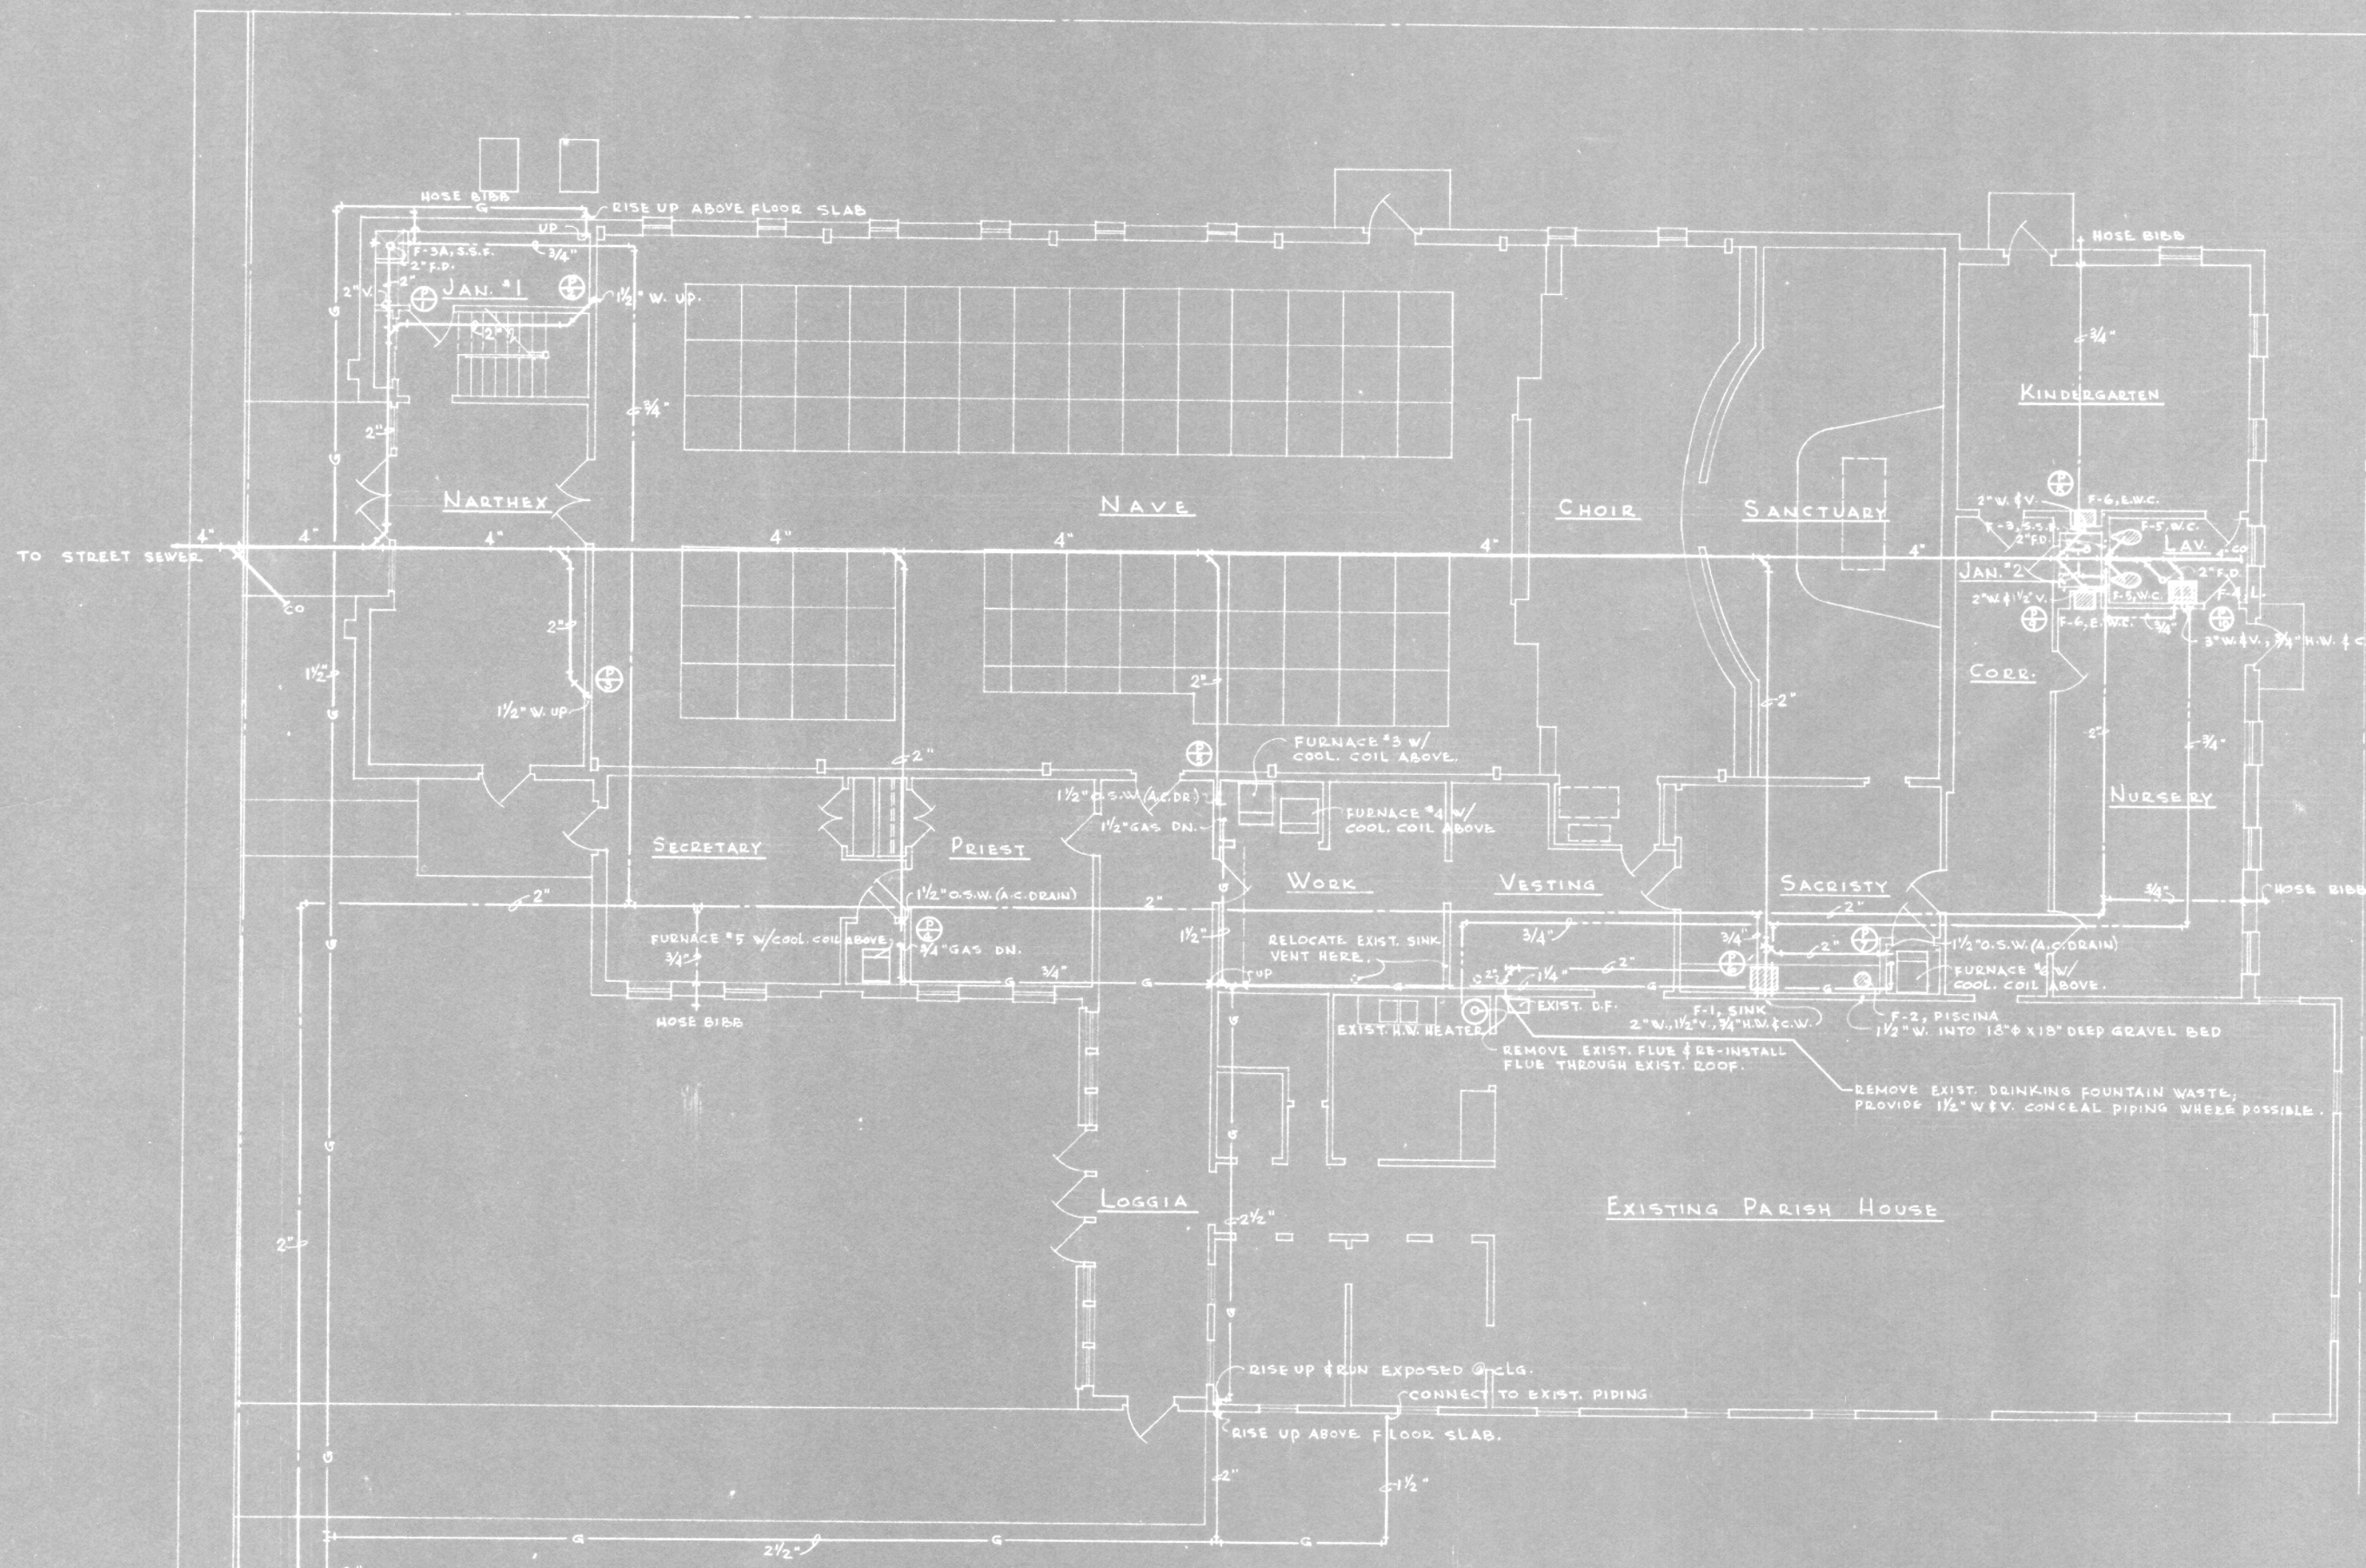

FLOOR PLAN — PLUMBING
SCALE: 1/8" = 1'-0"

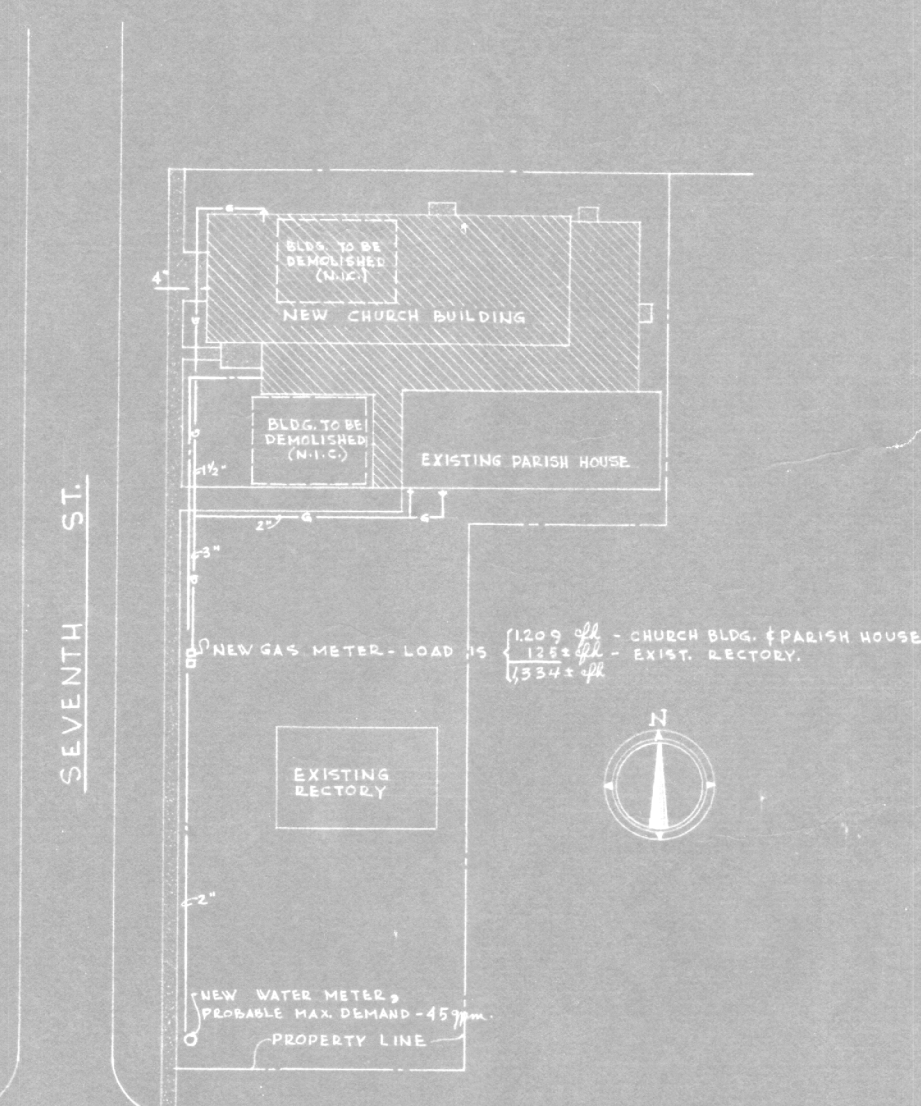

PLOT PLAN
SCALE: 1" = 40'-0"

CHURCH BUILDING FOR CHRIST EPISCOPAL CHURCH SLIDELL, LOUISIANA			COMM. NO. 885
FREEBET AND WOLF - ARCHITECTS 910 CHARLES ST. - NEW ORLEANS, LA.			DATE: 22 APRIL, 1965 REVISED: 30 APRIL, 1965
			SHEET NO. P-1 OF 1