


PLAN OF LOFT

SYMBOLS


- ⊙ CEILING MOUNTED FIXTURE; CAPITAL LETTER INDICATES FIXTURE TYPE - SEE SPECIFICATIONS; SUBSCRIPT LETTER INDICATES SWITCH CONTROLLING FIXTURE.
 - ⊖ WALL MOUNTED FIXTURE.
 - ⊠ FLUORESCENT FIXTURE.
 - ⊕ CONVENIENCE RECEPTACLE.
 - ⊕ CONVENIENCE RECEPTACLE - WEATHERPROOF TYPE.
 - ⊖ TELEPHONE OUTLET.
 - ⊕ SINGLE POLE TOGGLE SWITCH.
 - ⊕ THREE WAY SWITCH.
 - ⊕ THERMAL TRIP SWITCH.
- WIRING RUN CONCEALED IN WALLS AND/OR CEILINGS.
 - - - WIRING RUN CONCEALED IN FLOOR SLAB.
 - - - TELEPHONE CONDUITS.

ELECTRIC PANEL - FLUSH MOUNTED, 200 AMP. PANEL MAIN BUS'S ONLY. NEUTRAL BAR, REARRANGED FOR 120/240 VOLT SINGLE PHASE, THREE WIRE SERVICE. BRANCHES AS FOLLOWS:
 30 - 20A, 1/2 C.B. - CIRCUITS 1 THRU 20, 22 THRU 31 & SPARES
 1 - 20A, 1/2 C.B. - CIRCUIT 21.


PANEL 'X' - 2-20A, 1/2 C.B.

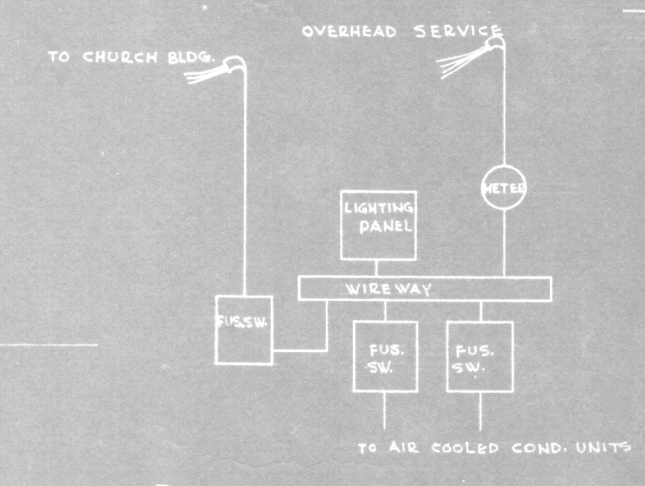

EXISTING SERVICE WIRING

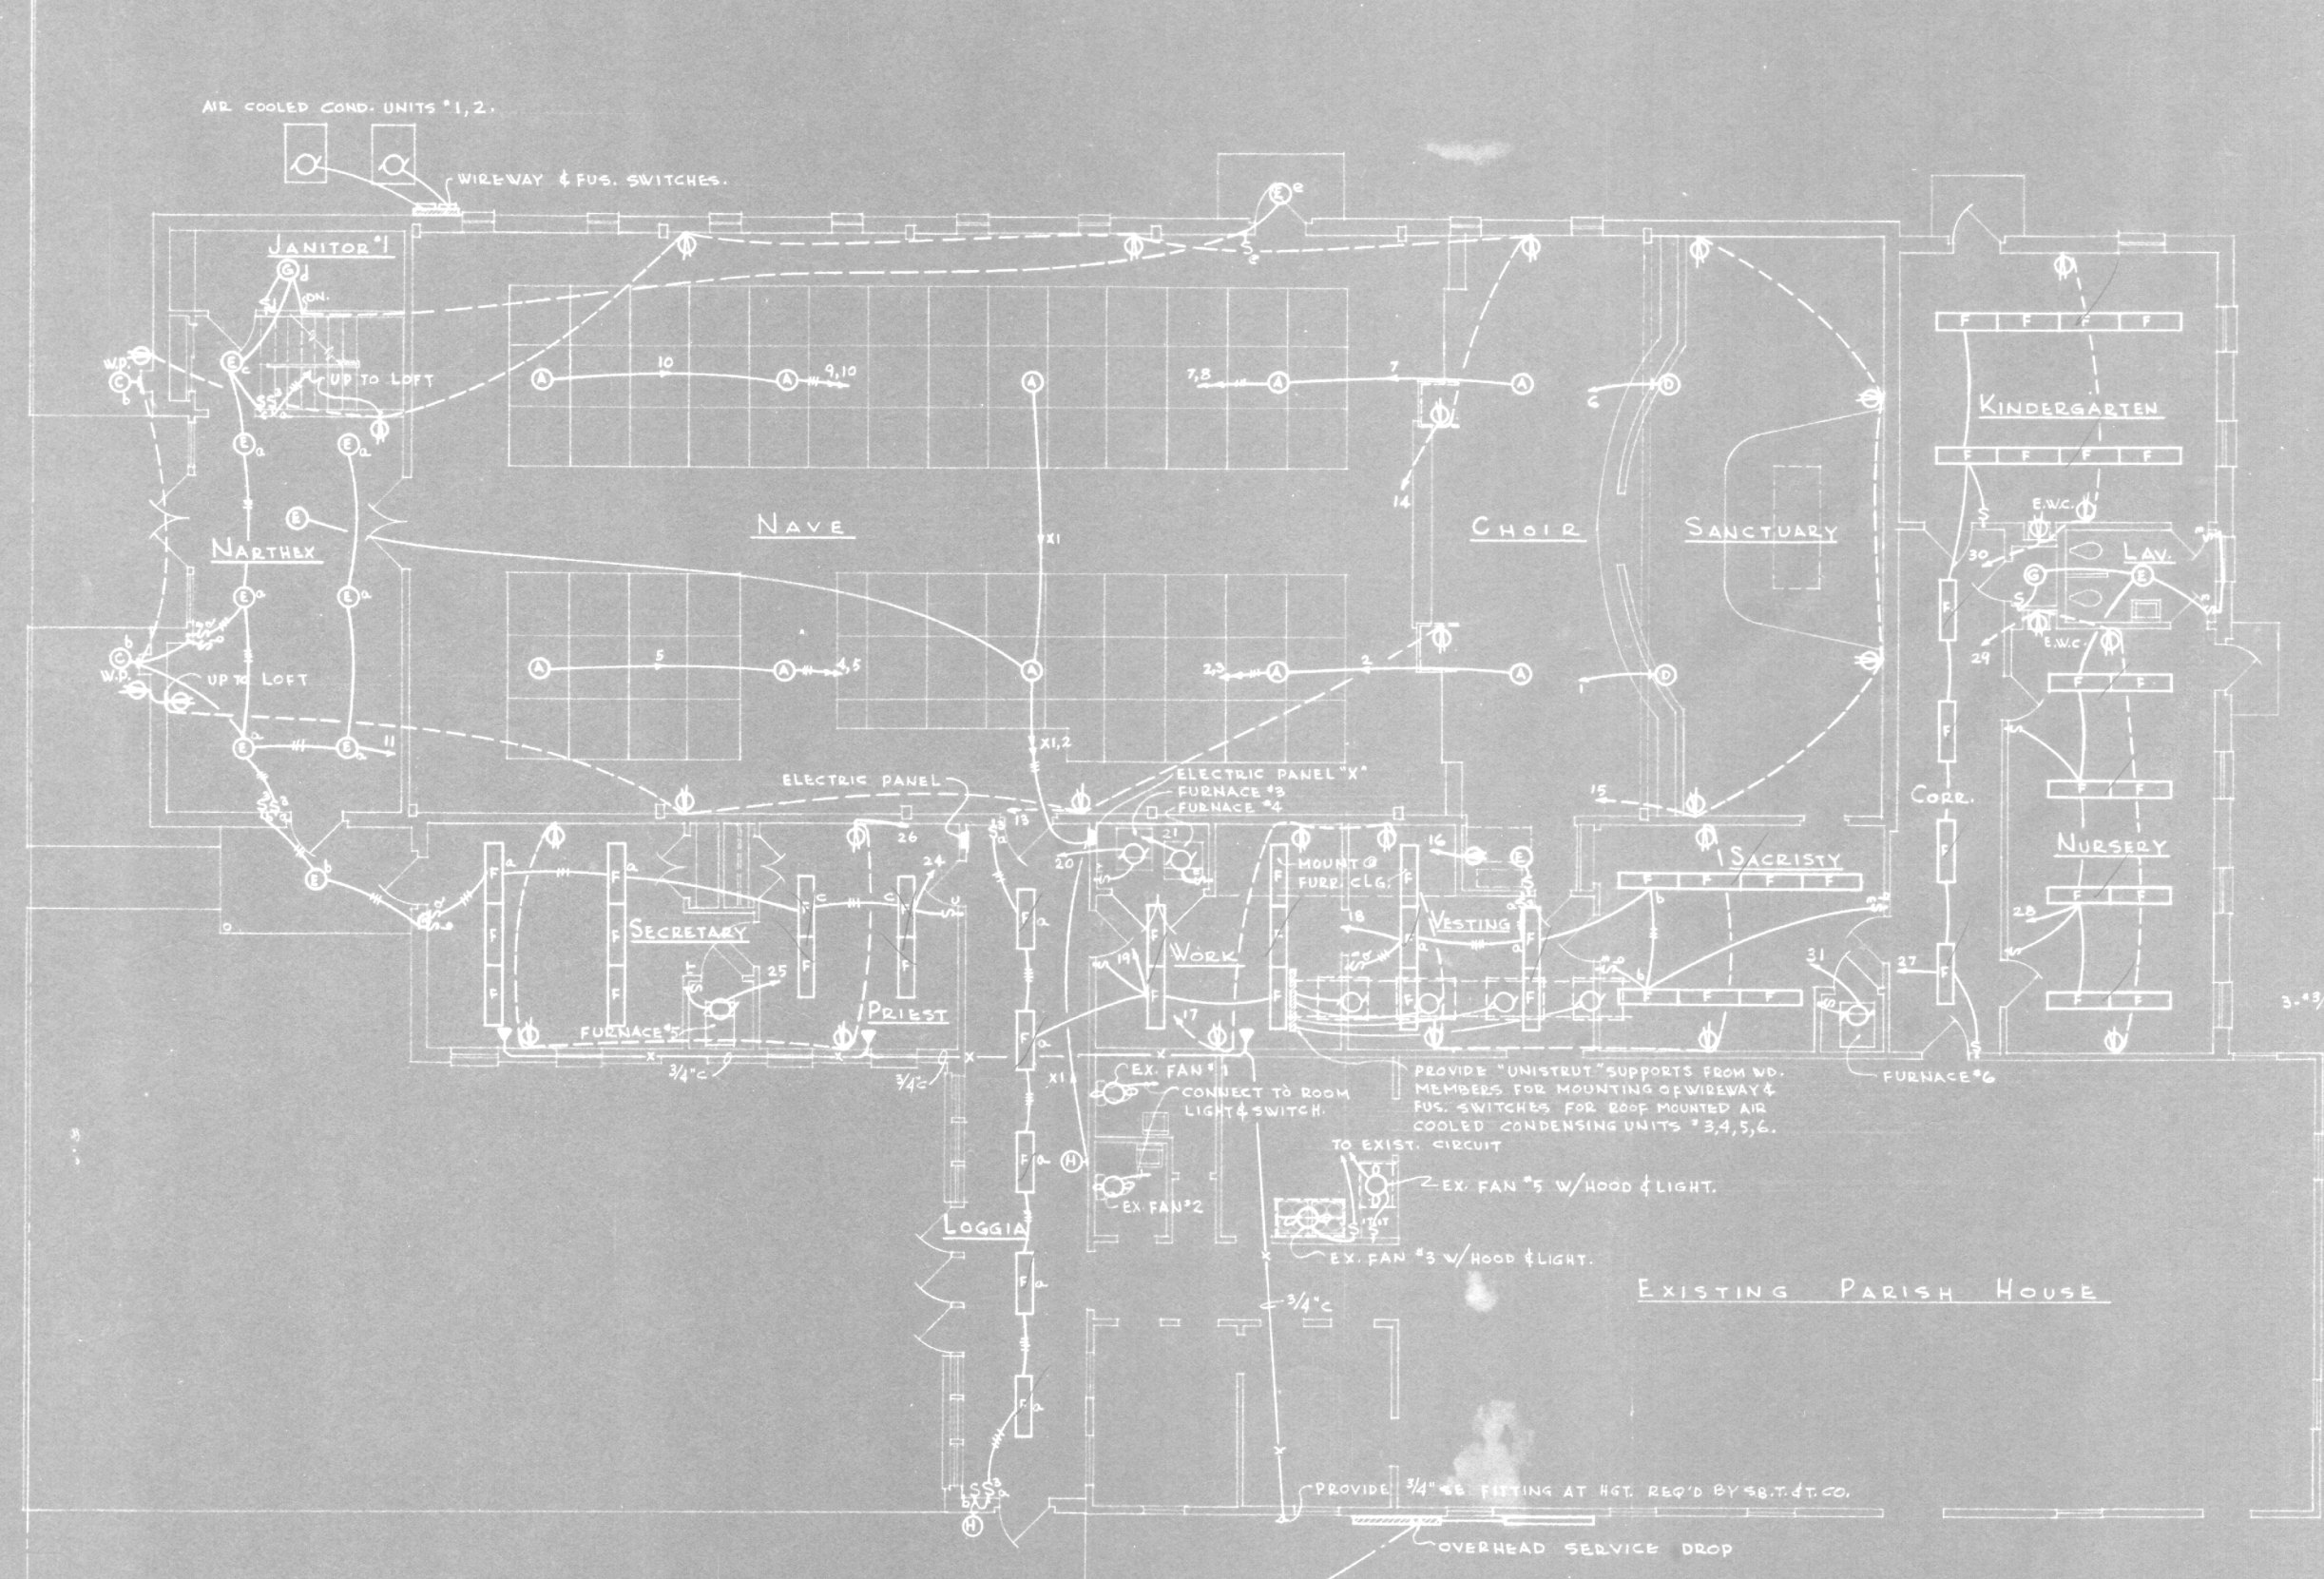

FLOOR PLAN - ELECTRICAL
 SCALE: 1/8" = 1'-0"

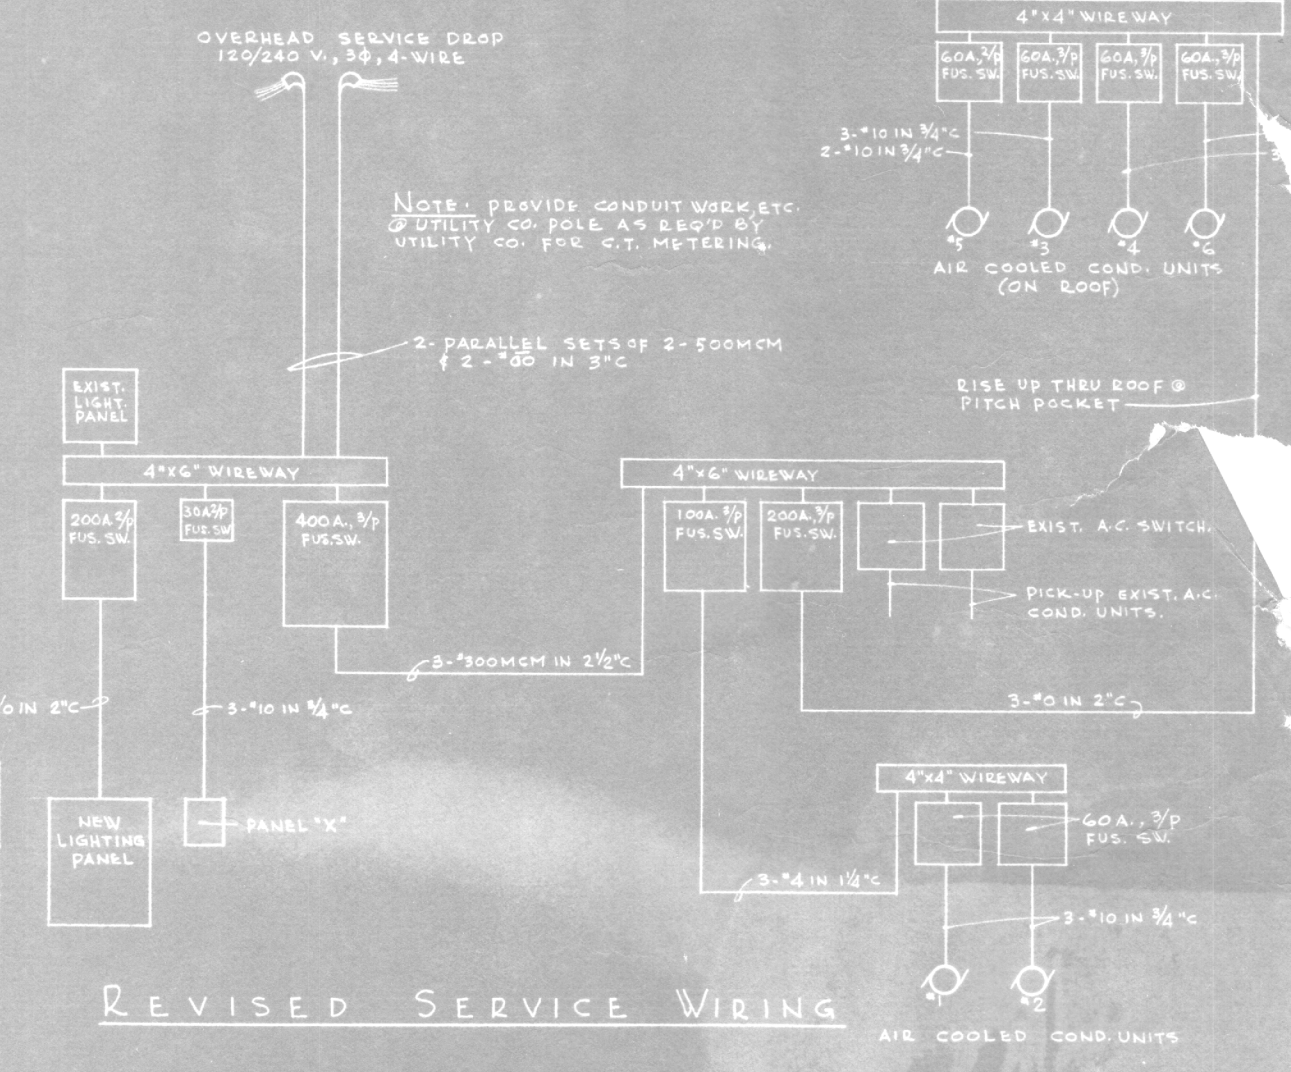

REVISED SERVICE WIRING

CHURCH BUILDING FOR CHRIST EPISCOPAL CHURCH SLIDELL, LOUISIANA	COMM. NO. 885
FREEST AND WOLF, ARCHITECTS 910 CHARLES ST. NEW ORLEANS, LA.	DATE: 21 APRIL, 1950
	REVISED: 30 APRIL, 1950
	SHEET NO. E-1 OF 1