


R I S E R D I A G R A M M


**SYMBOLS**

- F-1 PLUMBING FIXTURE, F. NO. REFERS TO SPECS.
- COLD WATER PIPING
- HOT WATER PIPING
- GAS PIPING
- WASTE PIPING
- VENT PIPING

LOFT P PLAN  
SCALE: 1/8" = 1'-0"

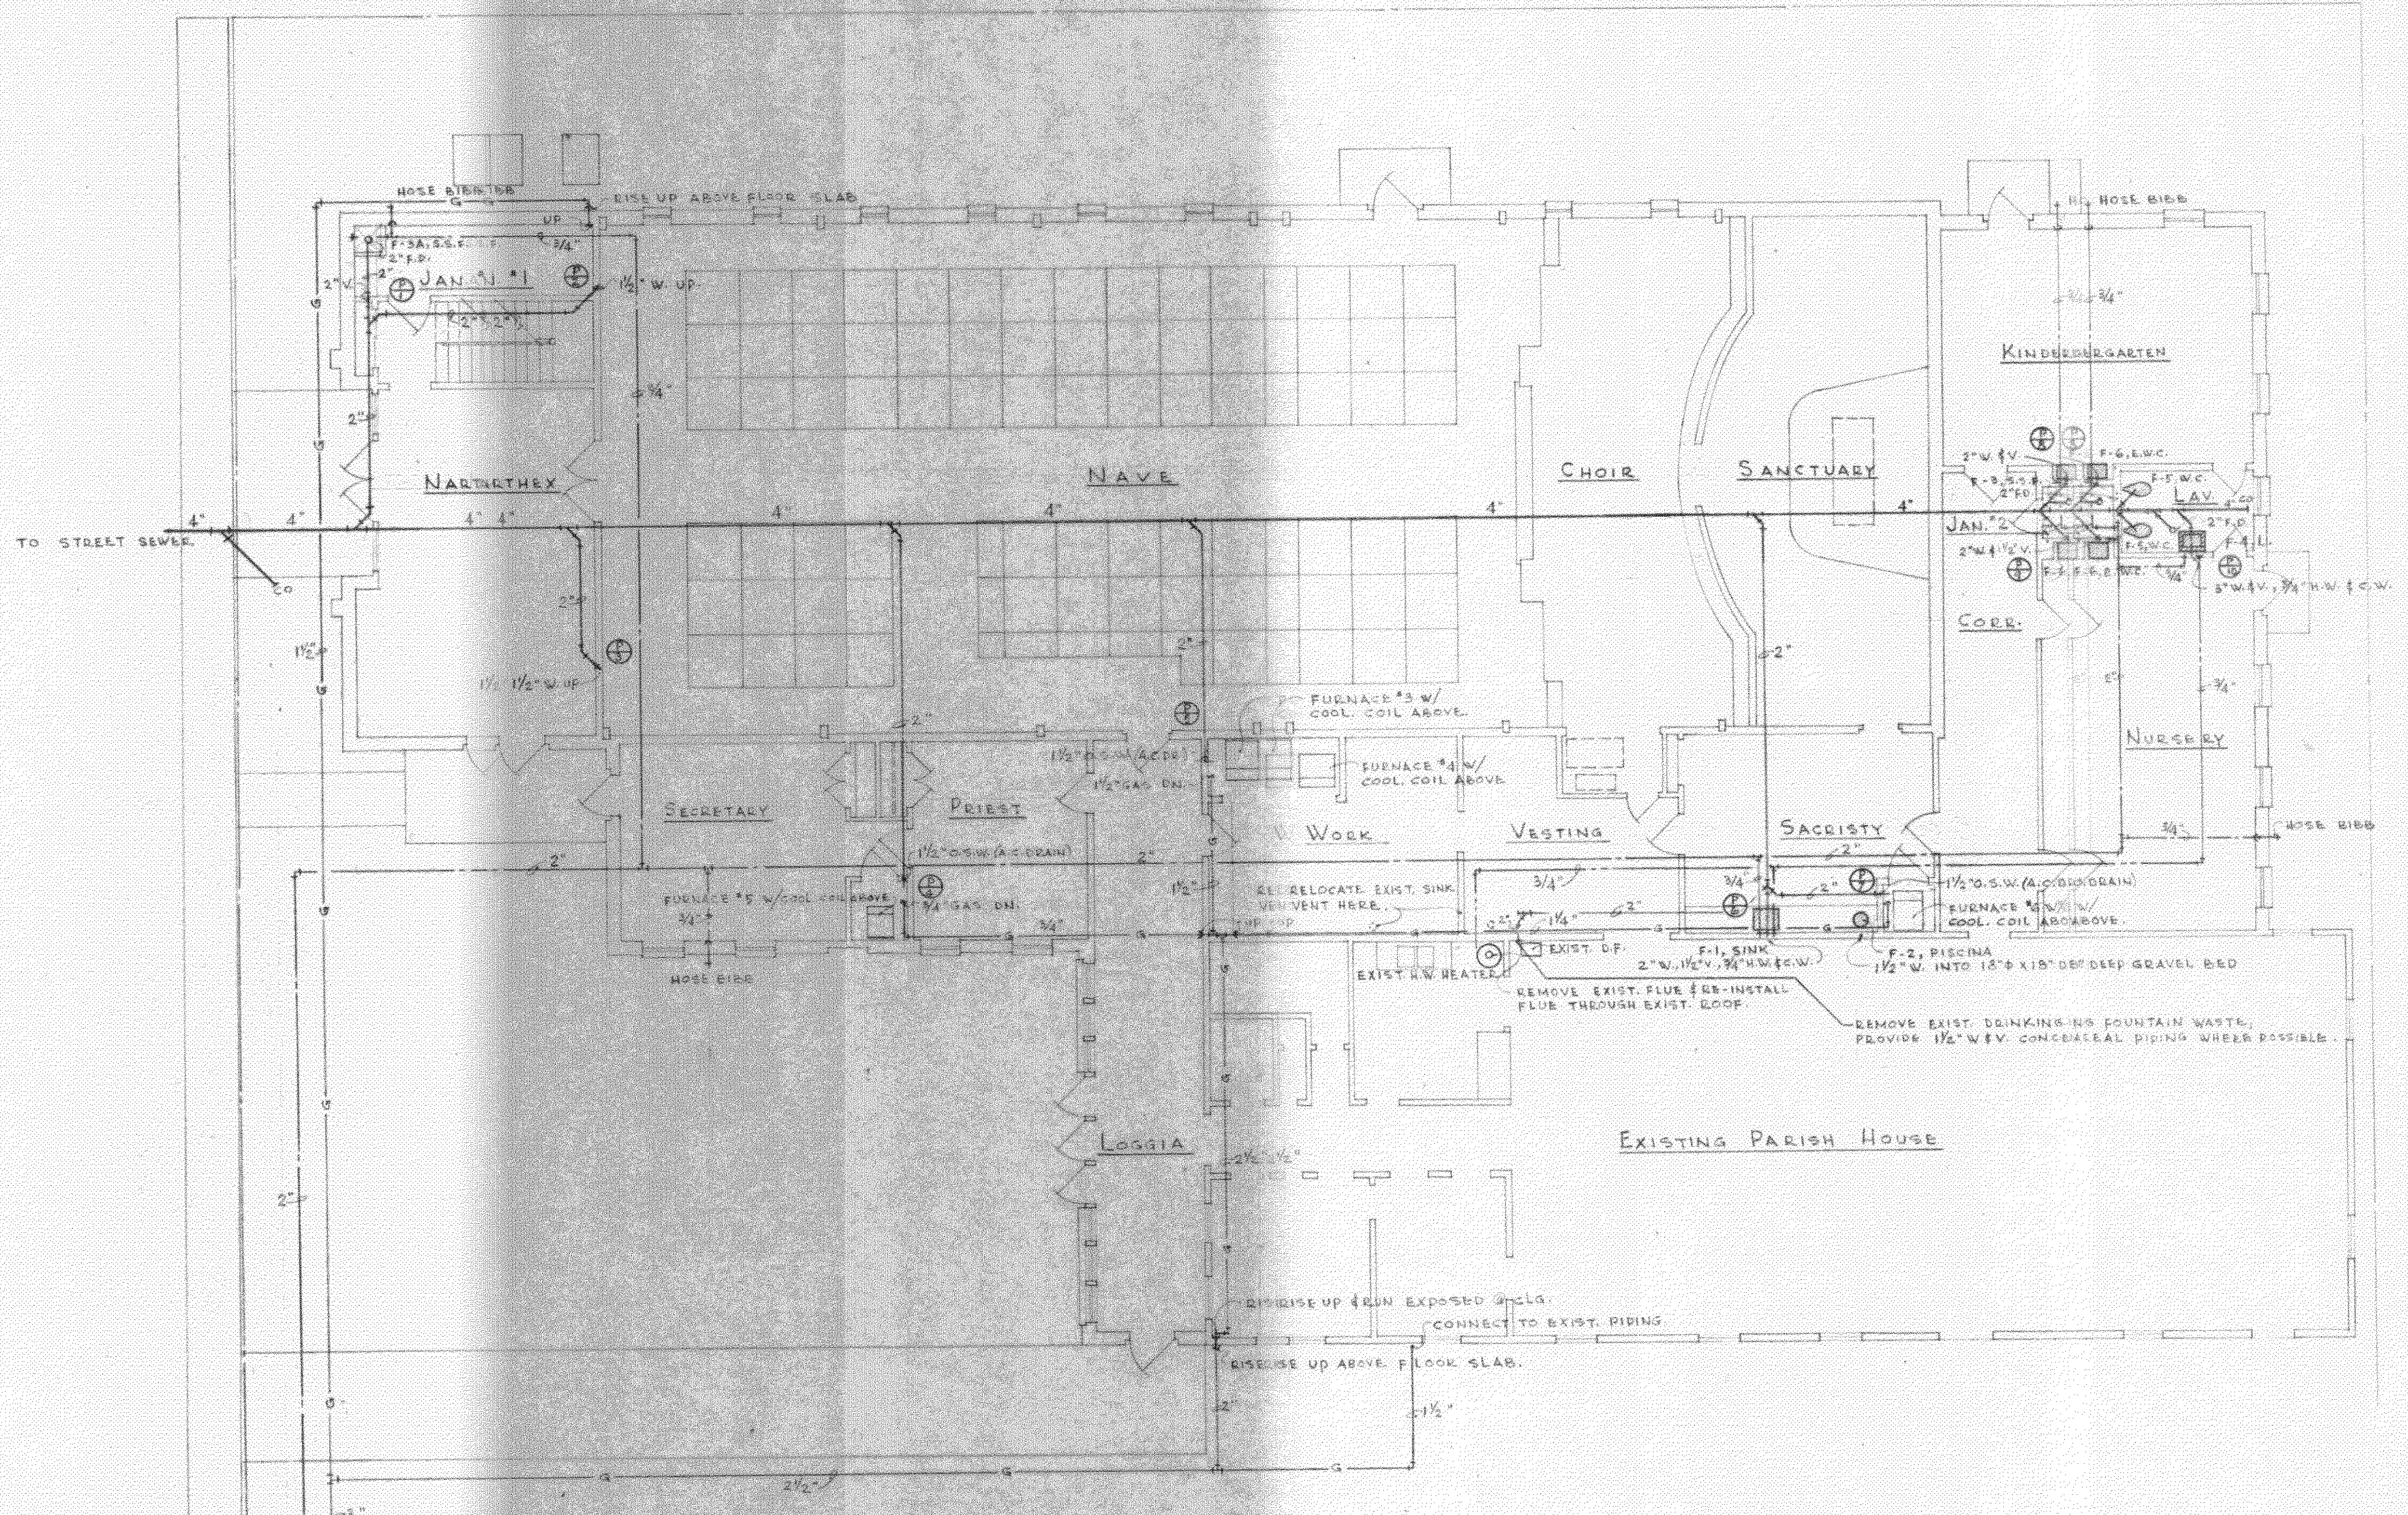

FLOOR PLAN — PLUMBING  
SCALE: 1/8" = 1'-0"

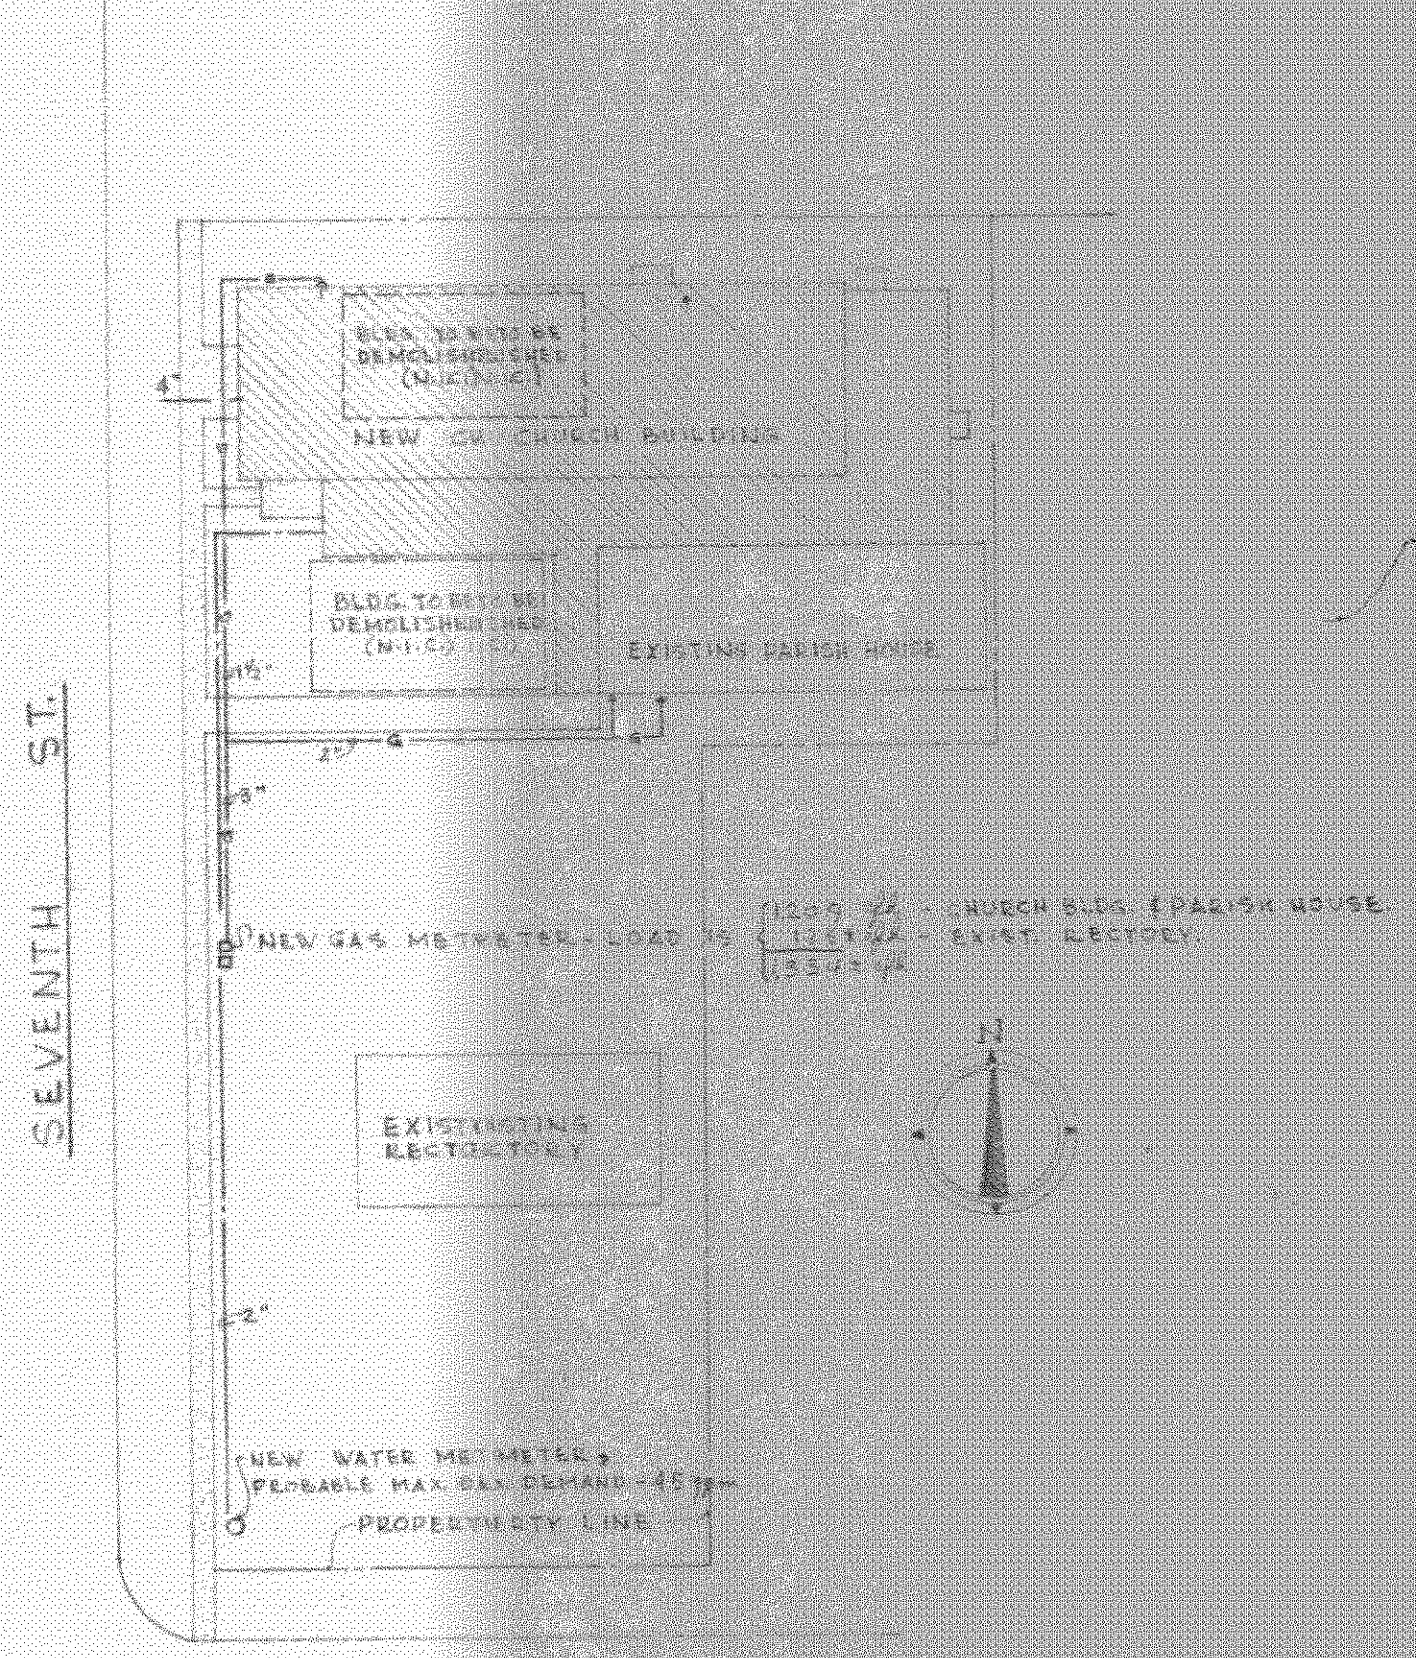

PENNSYLVANIA AVE  
SEVENTH ST.  
PLOT PLAN  
SCALE: 1" = 40'-0"

CHURCH BUILDING FOR <b>CHRIST EPISCOPAL CHURCH</b> SLIDELL, LOUISIANA	COMM NO. 285
	DATE: 22 APRIL, 1965
FRERET AND WOLFF - ARCHITECTS 910 CHARTRES ST. - NEW ORLEANS, LA.	REVISED: 30 APRIL, 1965
	SHEET NO. P-1 of 1