



ACCESS CONTROL  
SINGLE DOOR WITH CARD READER,  
MAGNETIC LOCK, REX, JUNCTION  
BOX, DOOR CONTACT

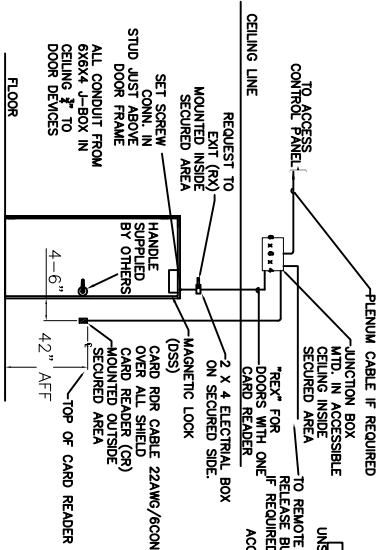


**CONDUIT DOOR LAYOUT  
SINGLE DOOR MAG LOCK**

ACCESS CONTROL DOUBLE DOOR  
WITH CARD READER, MAGNETIC  
LOCK, REX, JUNCTION BOX, DOOR  
CONTACT



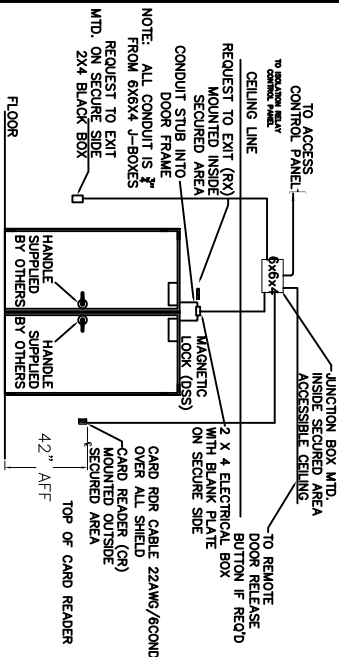


**CONDUIT DOOR LAYOUT  
DOUBLE DOOR MAG LOCK**

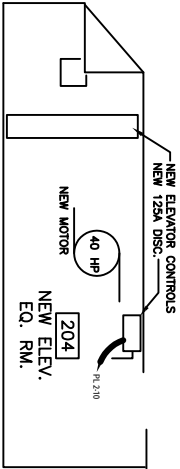

**NEW WEST ELEVATOR M/C ROOM DETAIL**

N. T. S.

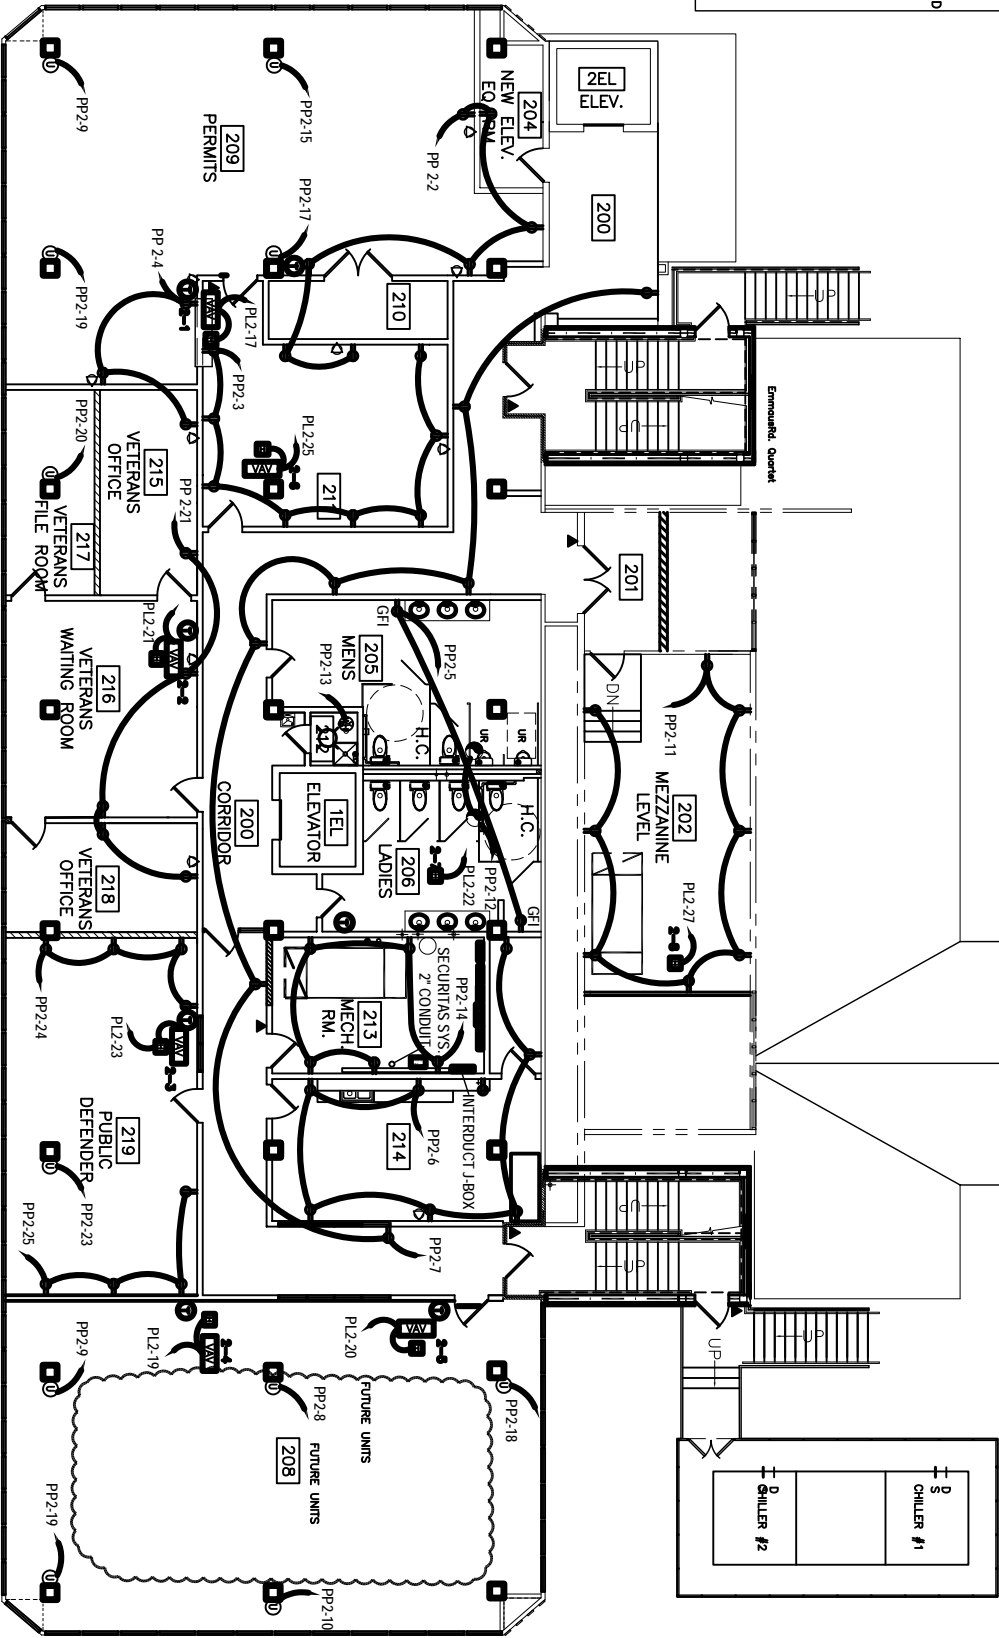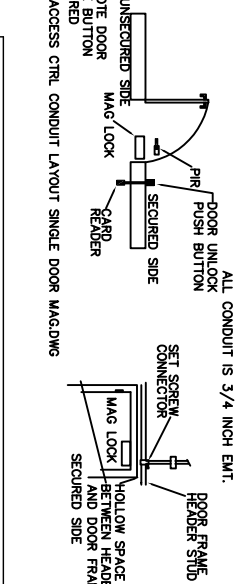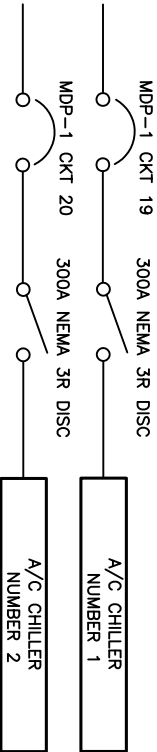

**SECOND FLOOR POWER PLAN**


SCALE: 1/8" = 1'-0"




**LEGEND**

- NEW DUPLEX RECEPTACLE
- EXHAUST FAN
- SECURITY ACCESS DOOR (SCANNER BY OTHERS)
- COMM DATA WALL PORT
- COLUMN MOUNTED UTILITY
- FUTURE TELEPHONE DATA & POWER FLOES BY OTHERS

**NOTES**  
ALL NEW POWER PANELS ARE TO BE MOUNTED ON THE NORTH WALL OF THE MECHANICAL ROOMS

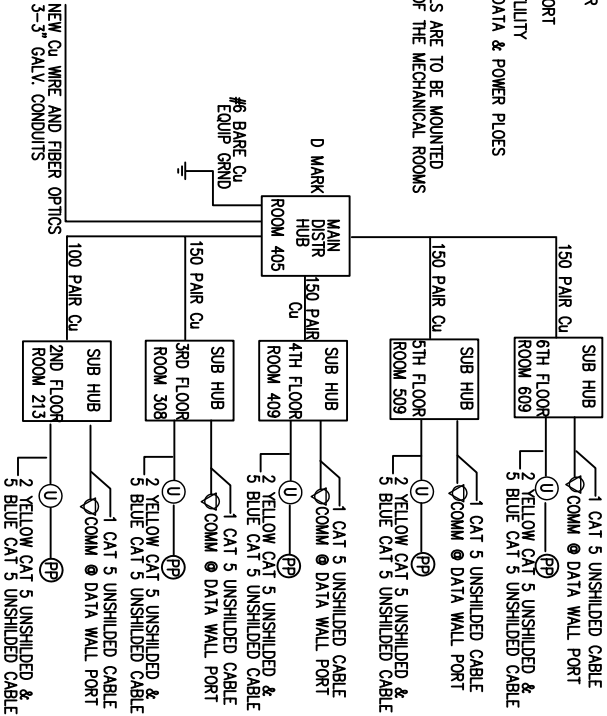

**TYPICAL COMMUNICATIONS DATA & POWER  
ONE LINE DIAGRAM**

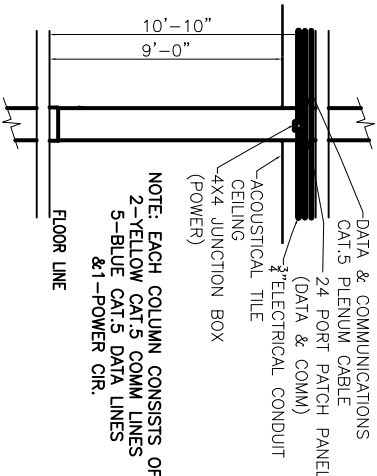

**COLUMN MOUNTED UTILITY DETAIL**

SCALE: NTS

NOTE: EACH COLUMN CONSISTS OF  
2-YELLOW CAT.5 COMM LINES  
5-BLUE CAT.5 DATA LINES  
& 1-POWER CIR.

HVAC REVISED: 11/05/07gdb  
REVISED: 03/07/07gdb  
REVISED: 01/23/07

CONTRACT SET- 10/10/07

RENOVATE OFFICE BUILDING  
**DAMMON ENGINEERING. INC.**  
1095 FLORIDA AVENUE 985-649-6832 SLIDELL, LA. 70468  
DAMMONENGINEERING.COM

**2ND FLOOR POWER PLAN**

ST. TAMMANY PARISH ADMIN. COMPLEX  
OLD SPANISH TRAIL  
SLIDELL, LOUISIANA

SHEET  
**E2P**  
OF

SCALE: AS NOTED  
FILE:  
JOB NO. 1729  
DATE: 1-8-07