



DAMMON
ENGINEERING, INC.

CHIEF ENGINEER
EMMETT
DAMMON, P.E.
CHIEF ARCHITECT
ROBERT
WILTSE

1095 FLORIDA AVENUE
SLIDELL, LA. 70458
OFFICE: 985-649-5832
FAX: 985-641-5950

WEBSITE:
WWW.DAMMONENGINEERING.COM
EMAIL:
DAMMONENG@BELLSOUTH.NET

ARCHITECTURE
ENGINEERING
STUDIES
PLANNING
INVESTIGATION
EXPERT WITNESS


NEW
APARTMENT
COMPLEX

CROSSWINDS
APARTMENTS
HAMMOND, LA

BLDG. 3
OVERALL
ELECTRICAL
PLAN


REV:
SCALE: AS NOTED
JOB#: 08112.13
DATE: 12-16-09
SHEET

E-4
OF

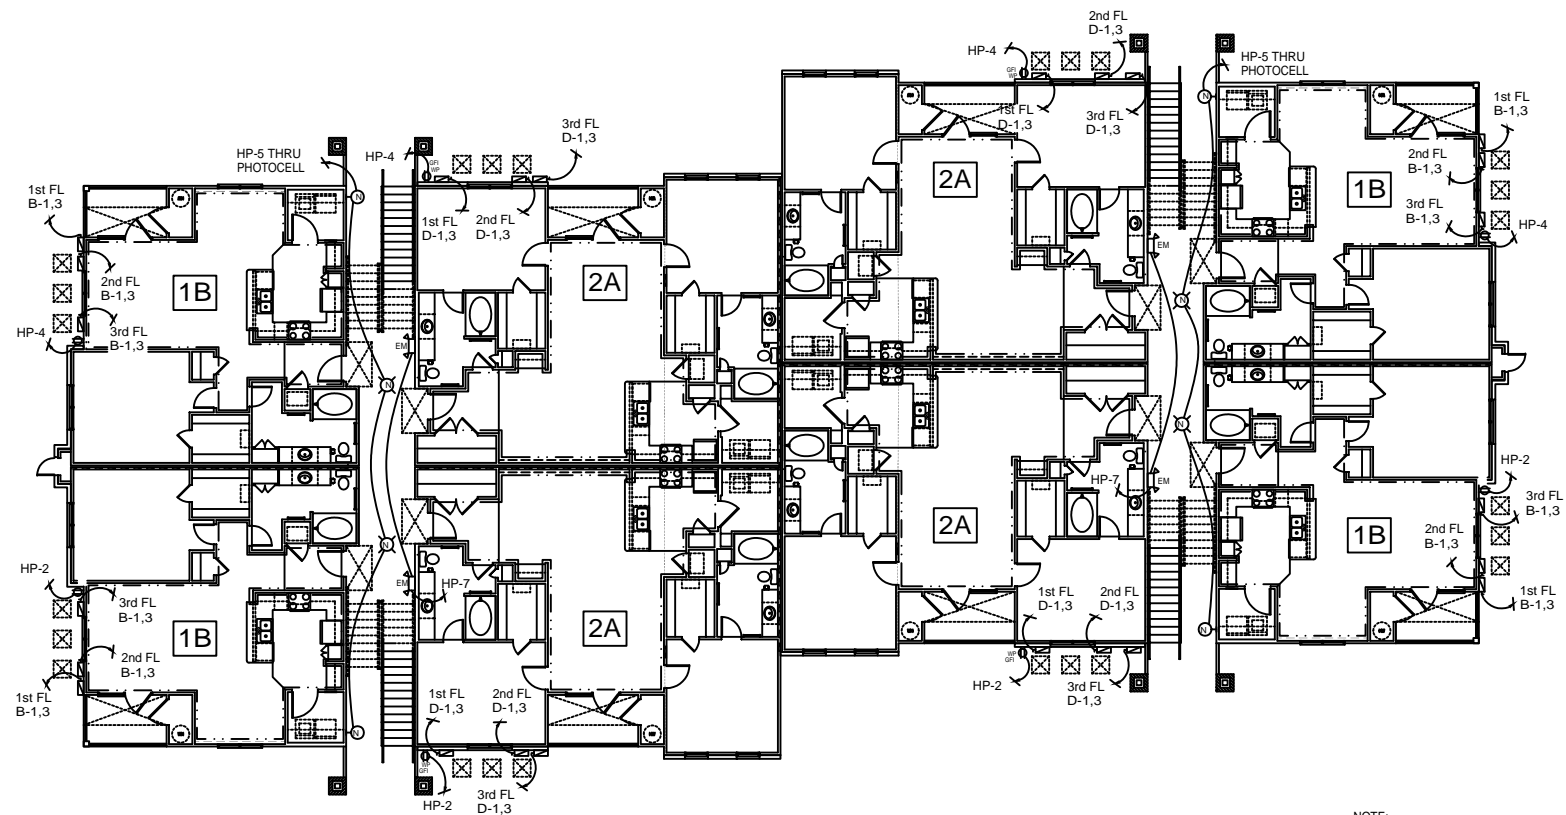

BLDG. 3 1ST FLOOR OVERALL
ELECTRICAL PLAN
SCALE: 1/8" = 1'-0"

NOTE:
SEE DRAWINGS E-5 & E-6 ELECTRICAL
PLANS FOR UNIT POWER AND
LIGHTING.

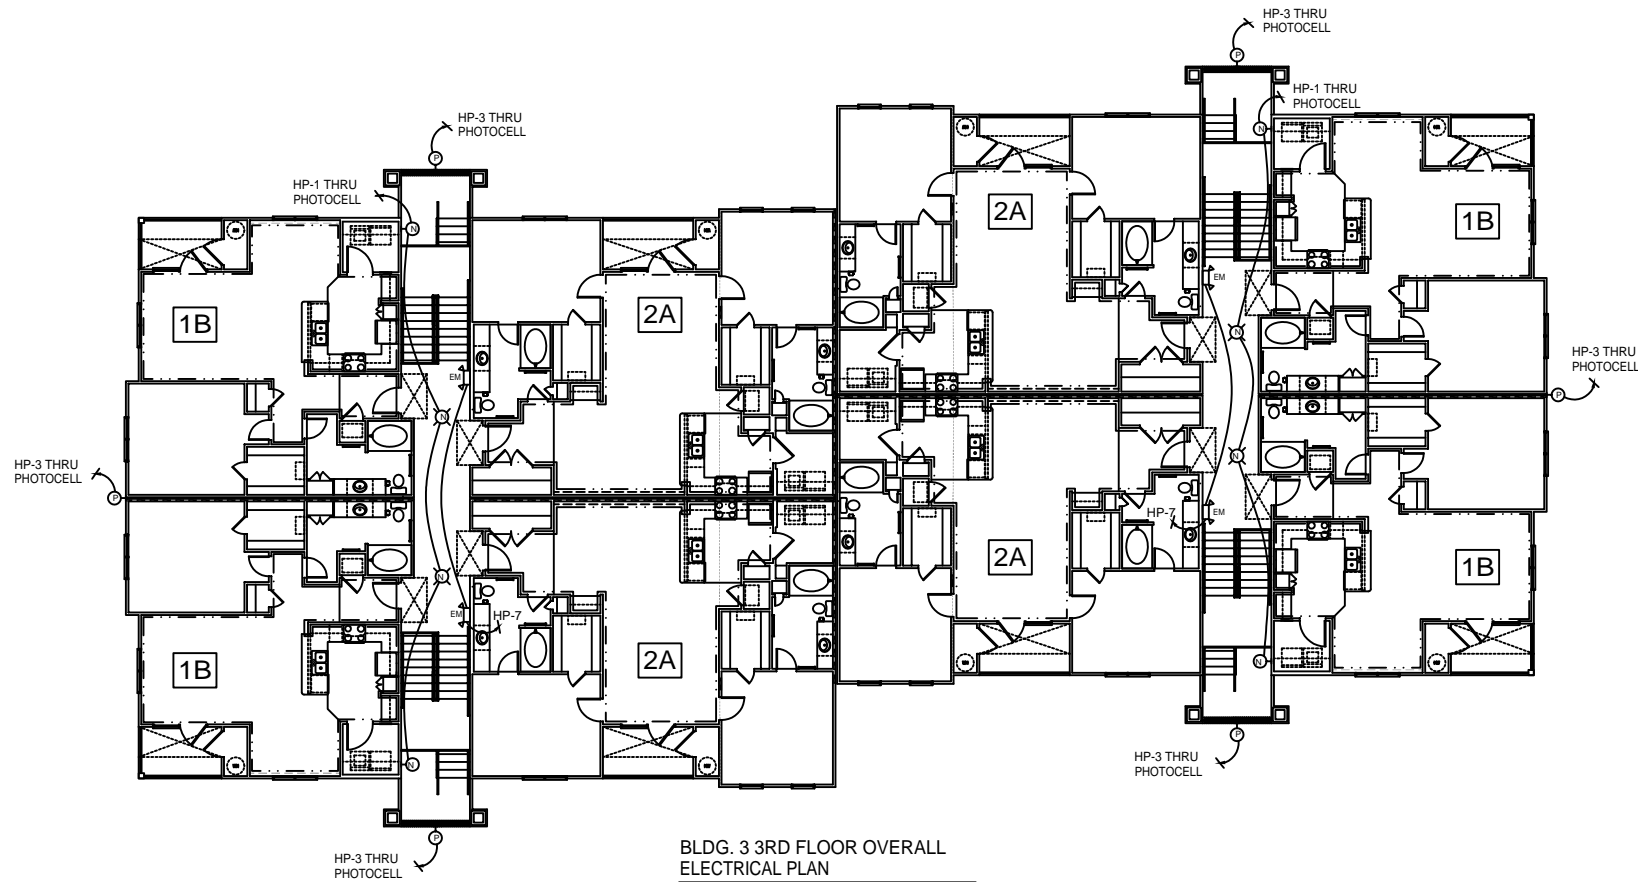

BLDG. 3 3RD FLOOR OVERALL
ELECTRICAL PLAN
SCALE: 1/8" = 1'-0"

NOTE: 2ND FLOOR IS SIMILAR TO 3RD FLOOR.