



DAMMON  
ENGINEERING, INC.

CHIEF ENGINEER  
EMMETT  
DAMMON, P.E.

CHIEF ARCHITECT  
ROBERT  
WILTSE

1095 FLORIDA AVENUE  
SLIDELL, LA. 70458  
OFFICE: 985-649-5832  
FAX: 985-641-5950

WEBSITE:  
WWW.DAMMONENGINEERING.COM  
EMAIL:  
DAMMONENG@BELLSOUTH.NET

ARCHITECTURE  
ENGINEERING  
STUDIES  
PLANNING  
INVESTIGATION  
EXPERT WITNESS

NEW  
APARTMENT  
COMPLEX

CROSSWINDS  
APARTMENTS  
HAMMOND, LA

LEASING BLDG./  
CLUBHOUSE  
FIRST FLOOR  
MECHANICAL PLAN

REV:

SCALE: AS NOTED


JOB#: 08112.13

DATE: 12-16-09

SHEET

M-5


OF

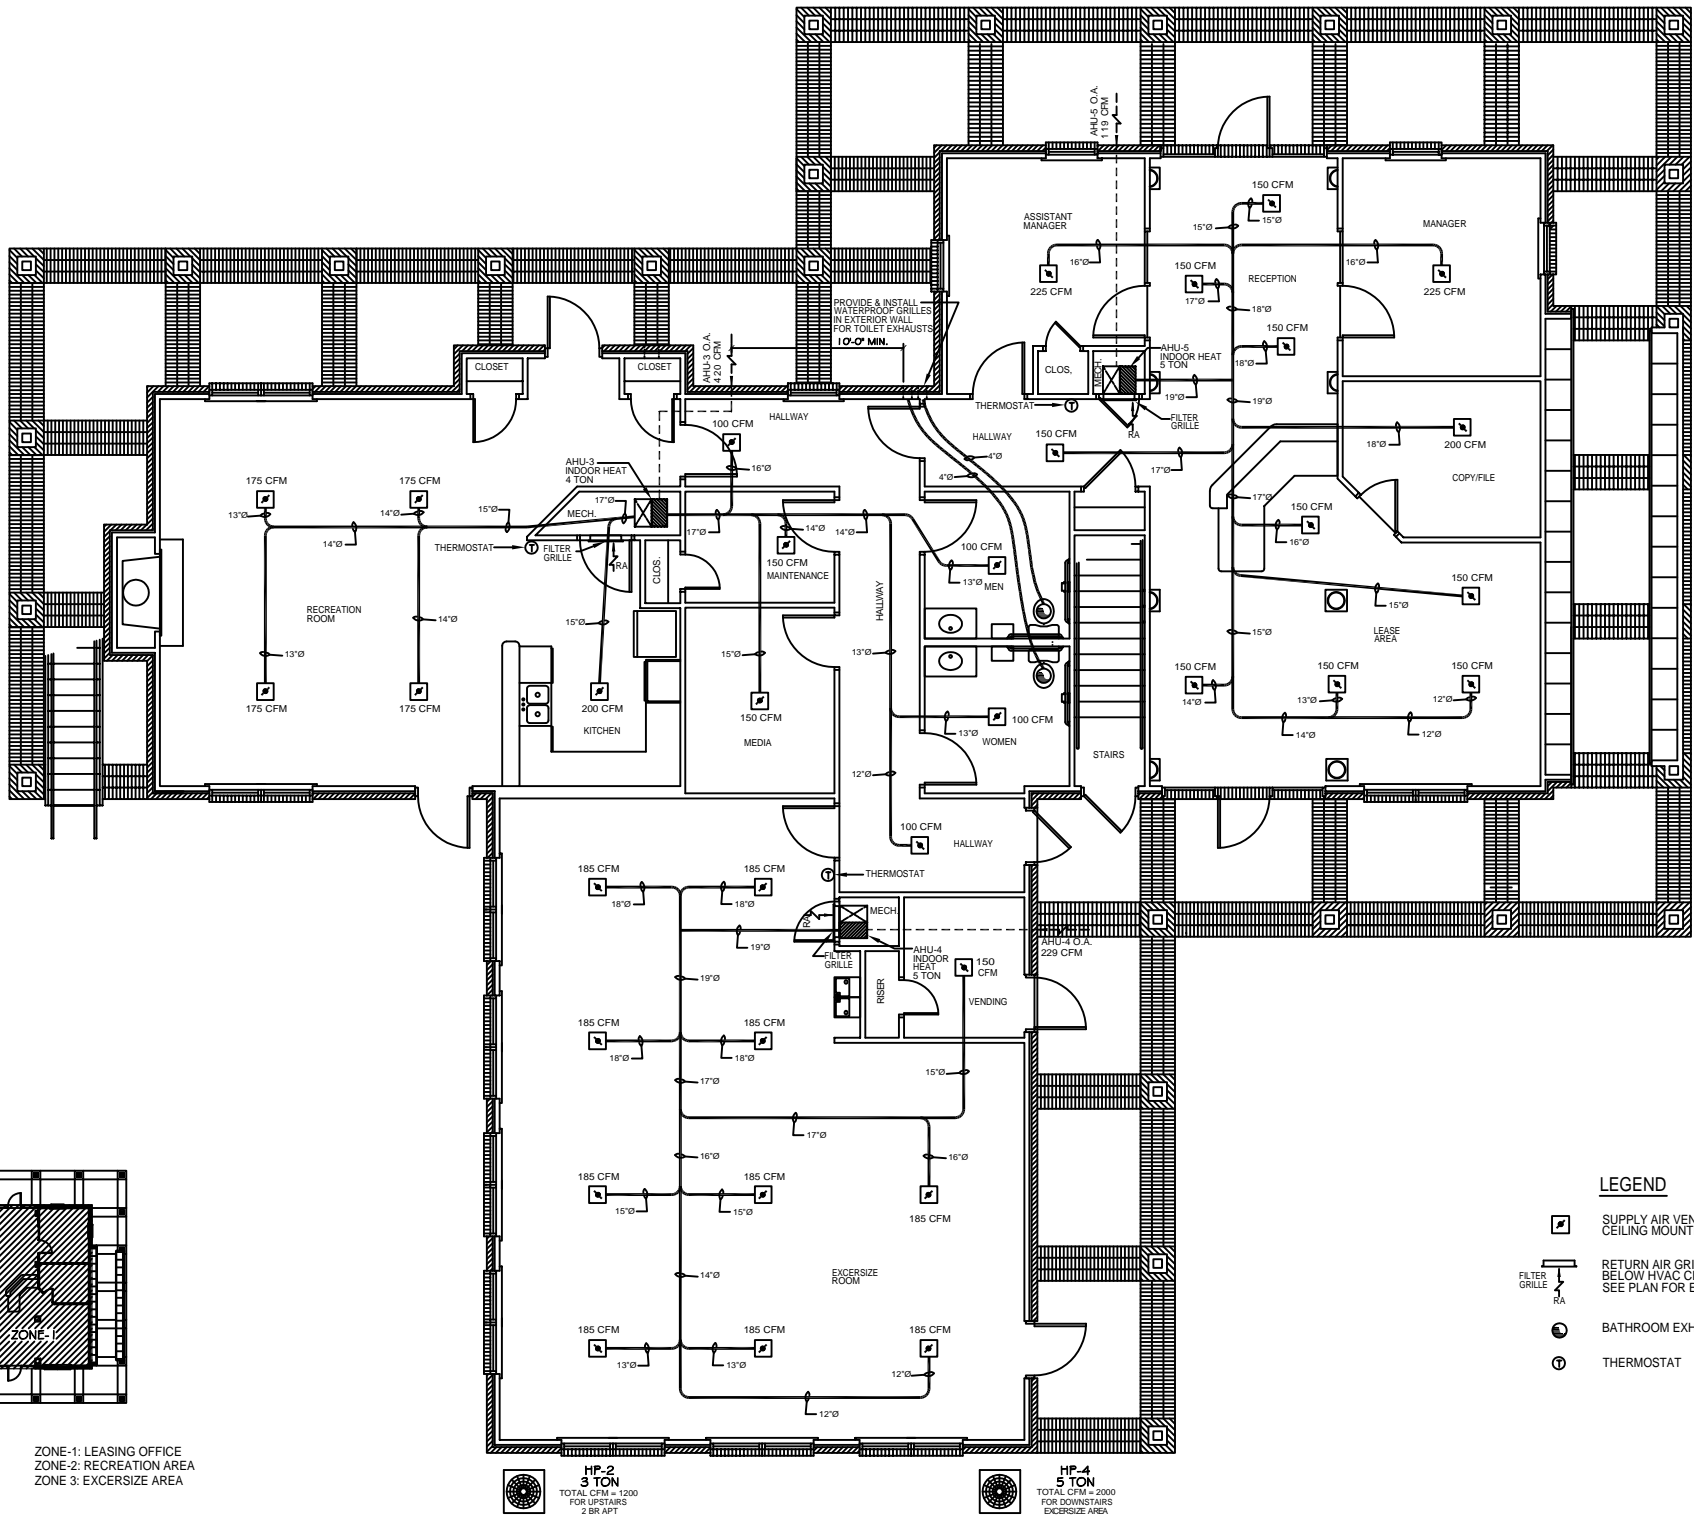

- HP-5  
5 TON**  
TOTAL CFM = 2000  
FOR DOWNSTAIRS  
LEASE OFFICE
- HP-1  
2 TON**  
TOTAL CFM = 800  
FOR UPSTAIRS  
1BR APT
- HP-3  
4 TON**  
TOTAL CFM = 1800  
FOR DOWNSTAIRS  
RECREATION/KITCHEN

LEGEND

- SUPPLY AIR VENT WITH FIRE DAMPER,  
CEILING MOUNTED
- RETURN AIR GRILLE, WALL MOUNTED  
BELOW HVAC CLOSET DOOR, TYP.  
SEE PLAN FOR EXACT LOCATION
- BATHROOM EXHAUST
- THERMOSTAT

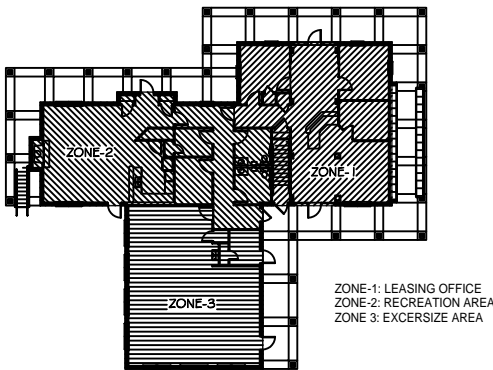

LEASING BLDG./CLUBHOUSE  
1ST FLOOR MECHANICAL KEY PLAN  
SCALE: NTS

LEASING BLDG./CLUBHOUSE  
1ST FLOOR MECHANICAL PLAN  
SCALE: 1/4" = 1'-0" 3,767 SQ. FT.

