



DAMMON
ENGINEERING, INC.

CHIEF ENGINEER
EMMETT
DAMMON, P.E.

CHIEF ARCHITECT
ROBERT
WILTSE

1095 FLORIDA AVENUE
SLIDELL, LA. 70458
OFFICE: 985-649-5832
FAX: 985-641-5950

WEBSITE:
WWW.DAMMONENGINEERING.COM
EMAIL:
DAMMONENG@BELL.SOUTH.NET

ARCHITECTURE
ENGINEERING
STUDIES
PLANNING
INVESTIGATION
EXPERT WITNESS

NEW
APARTMENT
COMPLEX

CROSSWINDS
APARTMENTS
HAMMOND, LA

LEASING BLDG./
CLUBHOUSE
SECOND FLOOR
MECHANICAL PLAN

REV:

SCALE: AS NOTED


JOB#: 08112.13

DATE: 12-16-09

SHEET

M-6


OF

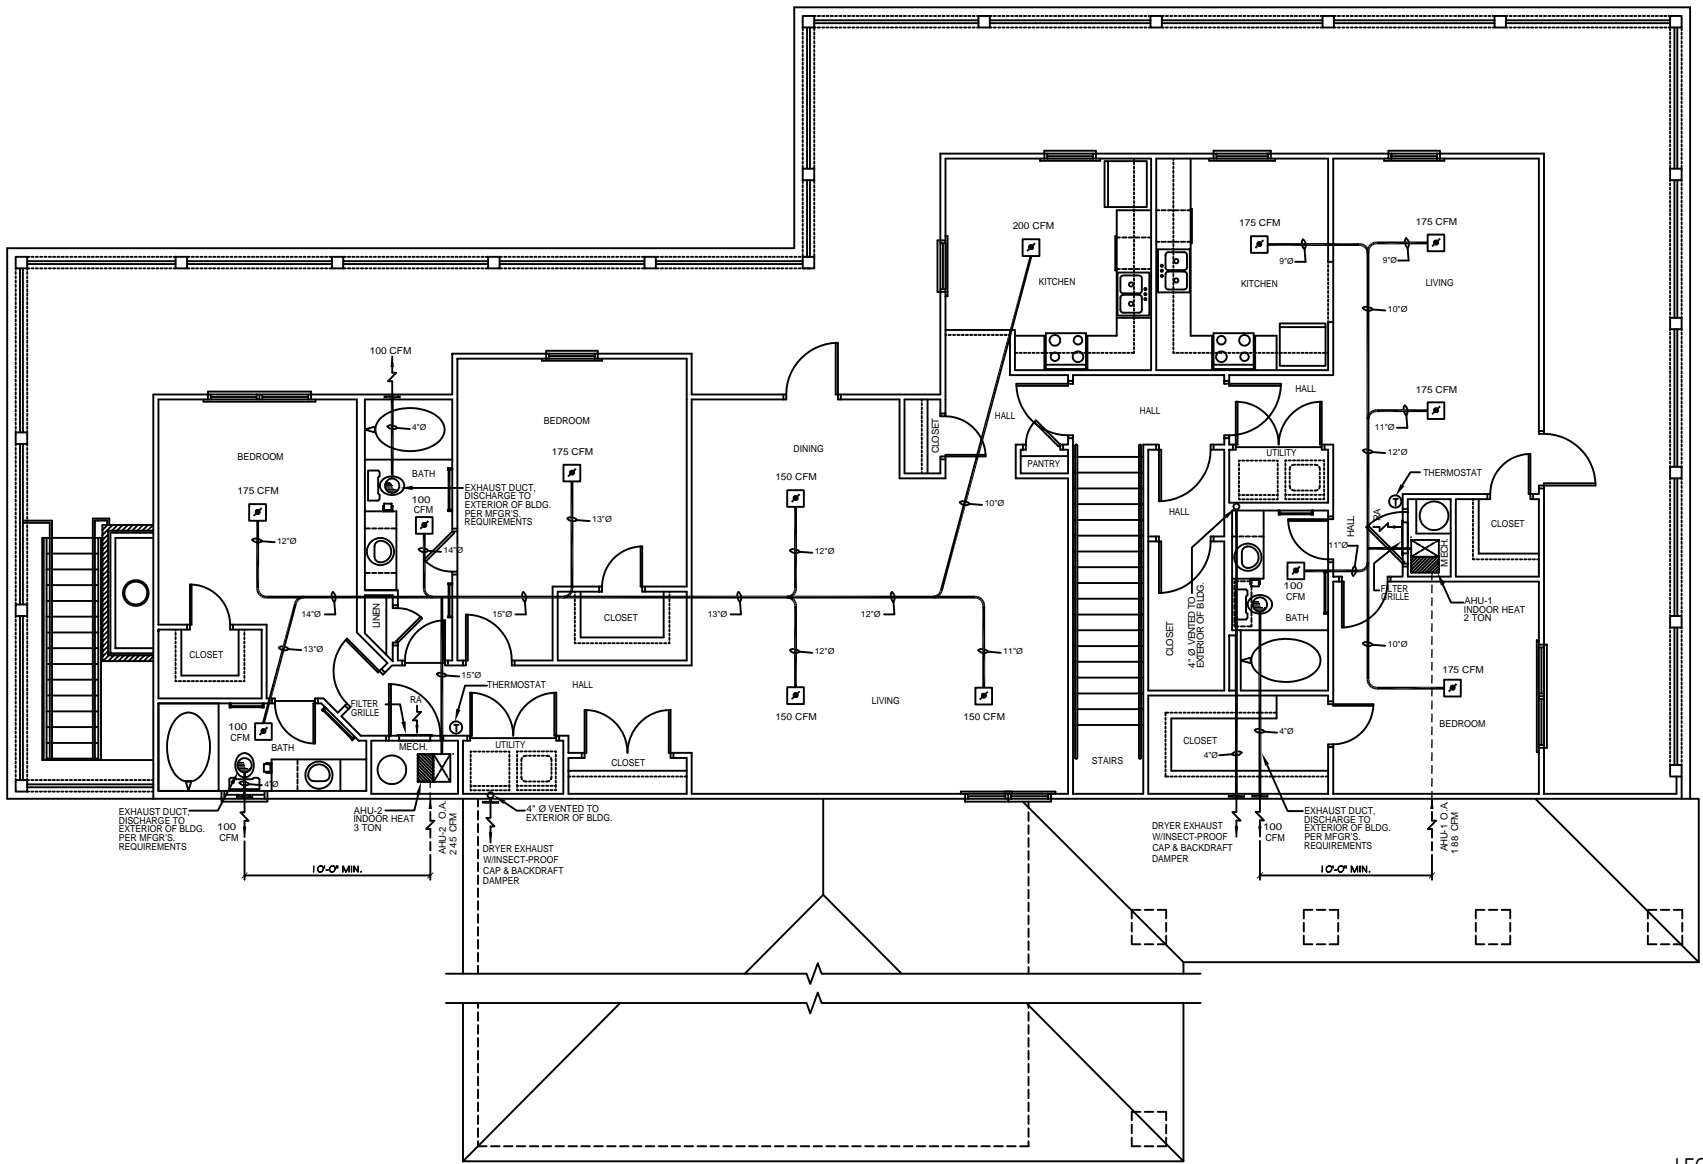

LEGEND

- SUPPLY AIR VENT WITH FIRE DAMPER, CEILING MOUNTED
- RETURN AIR GRILLE, WALL MOUNTED BELOW HVAC CLOSET DOOR, TYP. SEE PLAN FOR EXACT LOCATION
- BATHROOM EXHAUST
- THERMOSTAT

LEASING BLDG./CLUBHOUSE
2ND FLOOR MECHANICAL PLAN
SCALE: 1/4" = 1'-0" 2,447 SQ. FT.

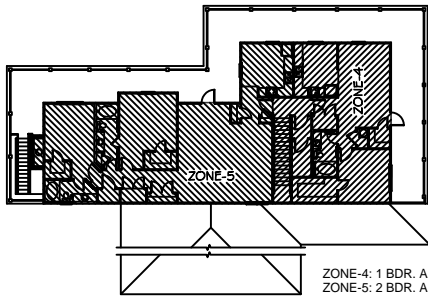

LEASING BLDG./CLUBHOUSE
2ND FLOOR MECHANICAL KEY PLAN
SCALE: NTS