



DAMMON  
ENGINEERING, INC.

CHIEF ENGINEER  
EMMETT  
DAMMON, P.E.

CHIEF ARCHITECT  
ROBERT  
WILTSE

1095 FLORIDA AVENUE  
SLIDELL, LA. 70458  
OFFICE: 985-649-5832  
FAX: 985-641-5950

WEBSITE:  
WWW.DAMMONENGINEERING.COM  
EMAIL:  
DAMMONENG@BELLSOUTH.NET

ARCHITECTURE  
ENGINEERING  
STUDIES  
PLANNING  
INVESTIGATION  
EXPERT WITNESS

NEW  
APARTMENT  
COMPLEX

CROSSWINDS  
APARTMENTS  
HAMMOND, LA

BLDGS. 1, 2, 3,  
5 & 6  
PLUMBING PLAN

REV:

SCALE: AS NOTED


JOB#: 08112.13

DATE: 12-16-09


SHEET

P-2

OF

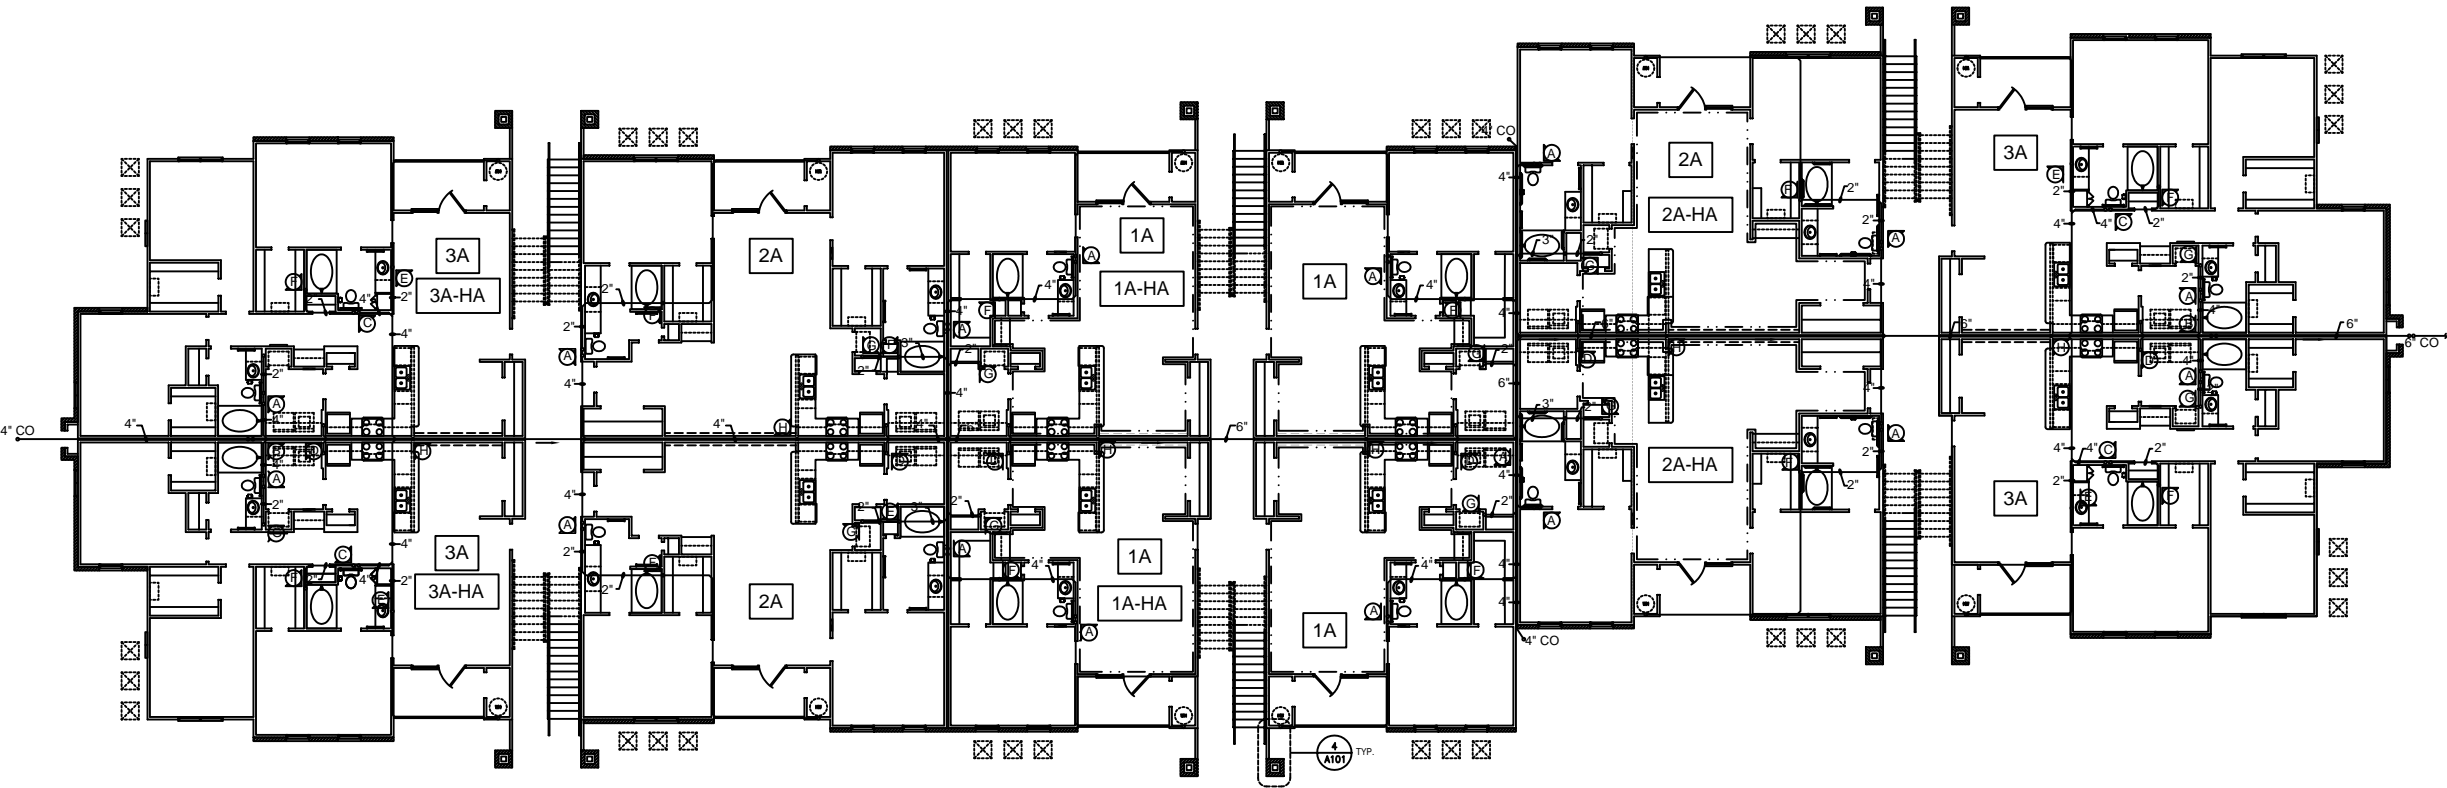

BLDGS. 1, 2, 5 & 6 1ST  
FLOOR PLUMBING PLAN  
SCALE: 1/8" = 1'-0"

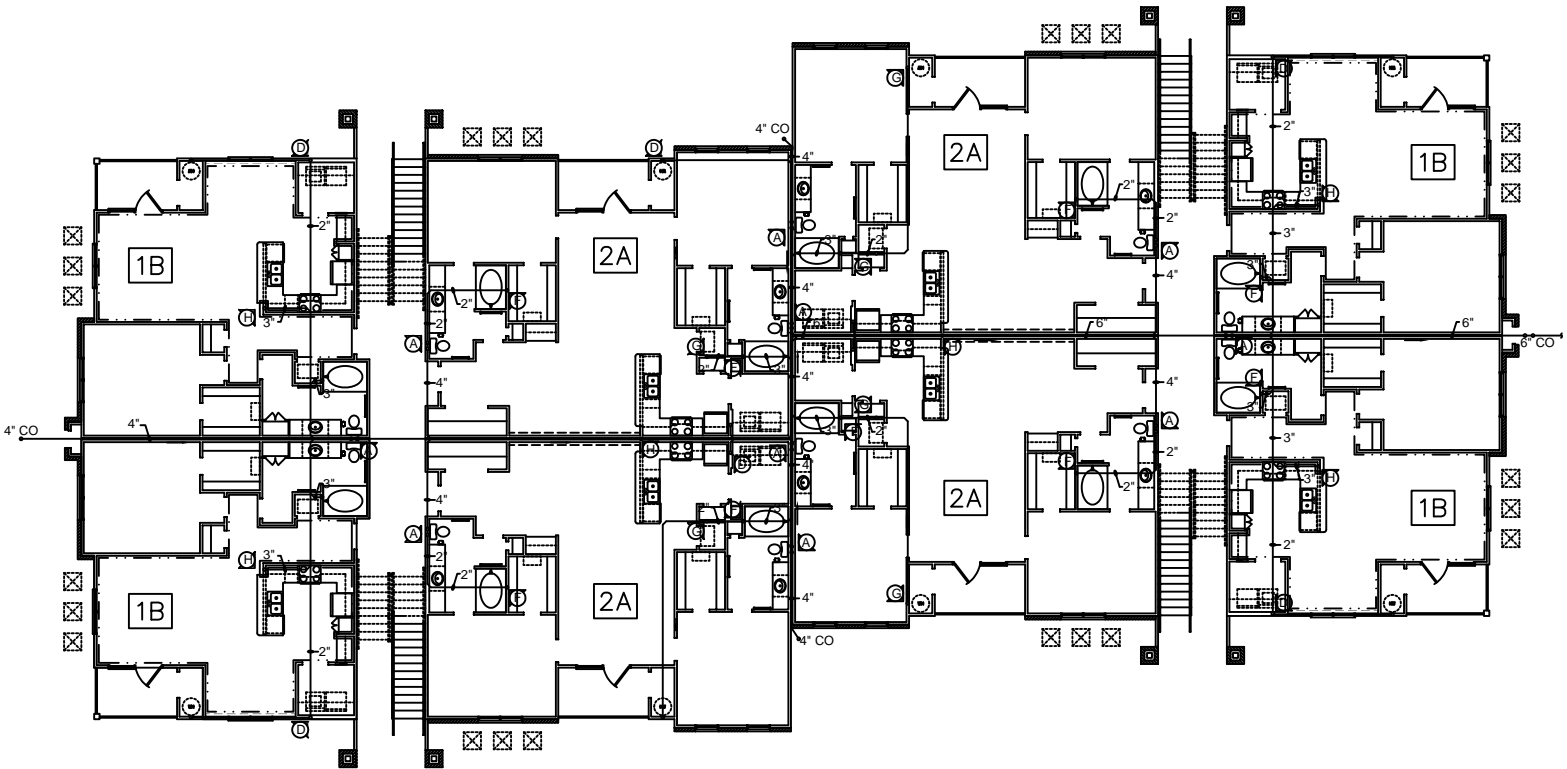

BLDG. 3 1ST FLOOR  
PLUMBING PLAN  
SCALE: 1/8" = 1'-0"

LEGEND

☒ TYPICAL VENT RISER DESIGNATION,  
SEE DWG P-5