



ARCHITECT  
ROBERT  
WILTSE

1095 FLORIDA AVENUE  
SLIDELL, LA. 70458  
985-649-5832

WEBSITE:  
WWW.DAMMONENGINEERING.CO  
EMAIL:  
DAMMONENG@BELLSOUTH.NET

ARCHITECTURE  
ENGINEERING  
STUDIES  
PLANNING  
INVESTIGATION  
EXPERT WITNESS

CENTURY PARK  
UNIVERSITY OF  
SOUTHERN  
MISSISSIPPI

IDN-ACME INC.  
1504 JUSTIN RD.  
METAIRIE, LA 70003

## CAMERA AND CABLING DETAILS

REV: #1 10/30/09

SCALE: AS NOTED

JOB#: 2028

DATE:6-29-2009


SHEET: 3

**SEC-0-2**

The diagram illustrates three configurations for exit signs, labeled A, B, and C, showing their connection to a ceiling and various input/output ports.

- Configuration A: EXIT SIGN W/ SINGLE CAMERA FRONT MOUNTED**
  - Labels: VIDEO OUTPUT, DC 12V INPUT: (GNTX POS), RG59 W/18/2, WELDEX DDC COLOR BOARD CAMERA, MODULE NO: WDC-32005, TYP. ALL EXIT SIGNS W/ CAMERAS.
- Configuration B: EXIT SIGN W/ DOUBLE CAMERAS FRONT & BACK MOUNTED**
  - Labels: VIDEO OUTPUT, DC 12V INPUT: (CAMERA), RG59 W/18/2, WELDEX DDC COLOR BOARD CAMERA, MODULE NO: WDC-32005, TYP. ALL EXIT SIGNS W/ CAMERAS.
- Configuration C: EXIT SIGN WITHOUT CAMERAS**
  - Labels: VIDEO OUTPUT, DC 12V INPUT: (CAMERA), RG59 W/18/2, WELDEX DDC COLOR BOARD CAMERA, MODULE NO: WDC-32005, TYP. ALL EXIT SIGNS W/ CAMERAS.



**NOTE:** ELECTRICIAN TO MOUNT WEATHERPROOF OCTAGONAL BOX AT 14' AFF.; INSTALL ½" CONDUIT FROM 1st FLOOR CEILING; INSTALL RGS59-W/18/2 TO SECURITY CLOSET. INSTALL WEATHERPROOF COVER OVER OCTAGONAL BOX FOR ALL FUTURE LOCATIONS.

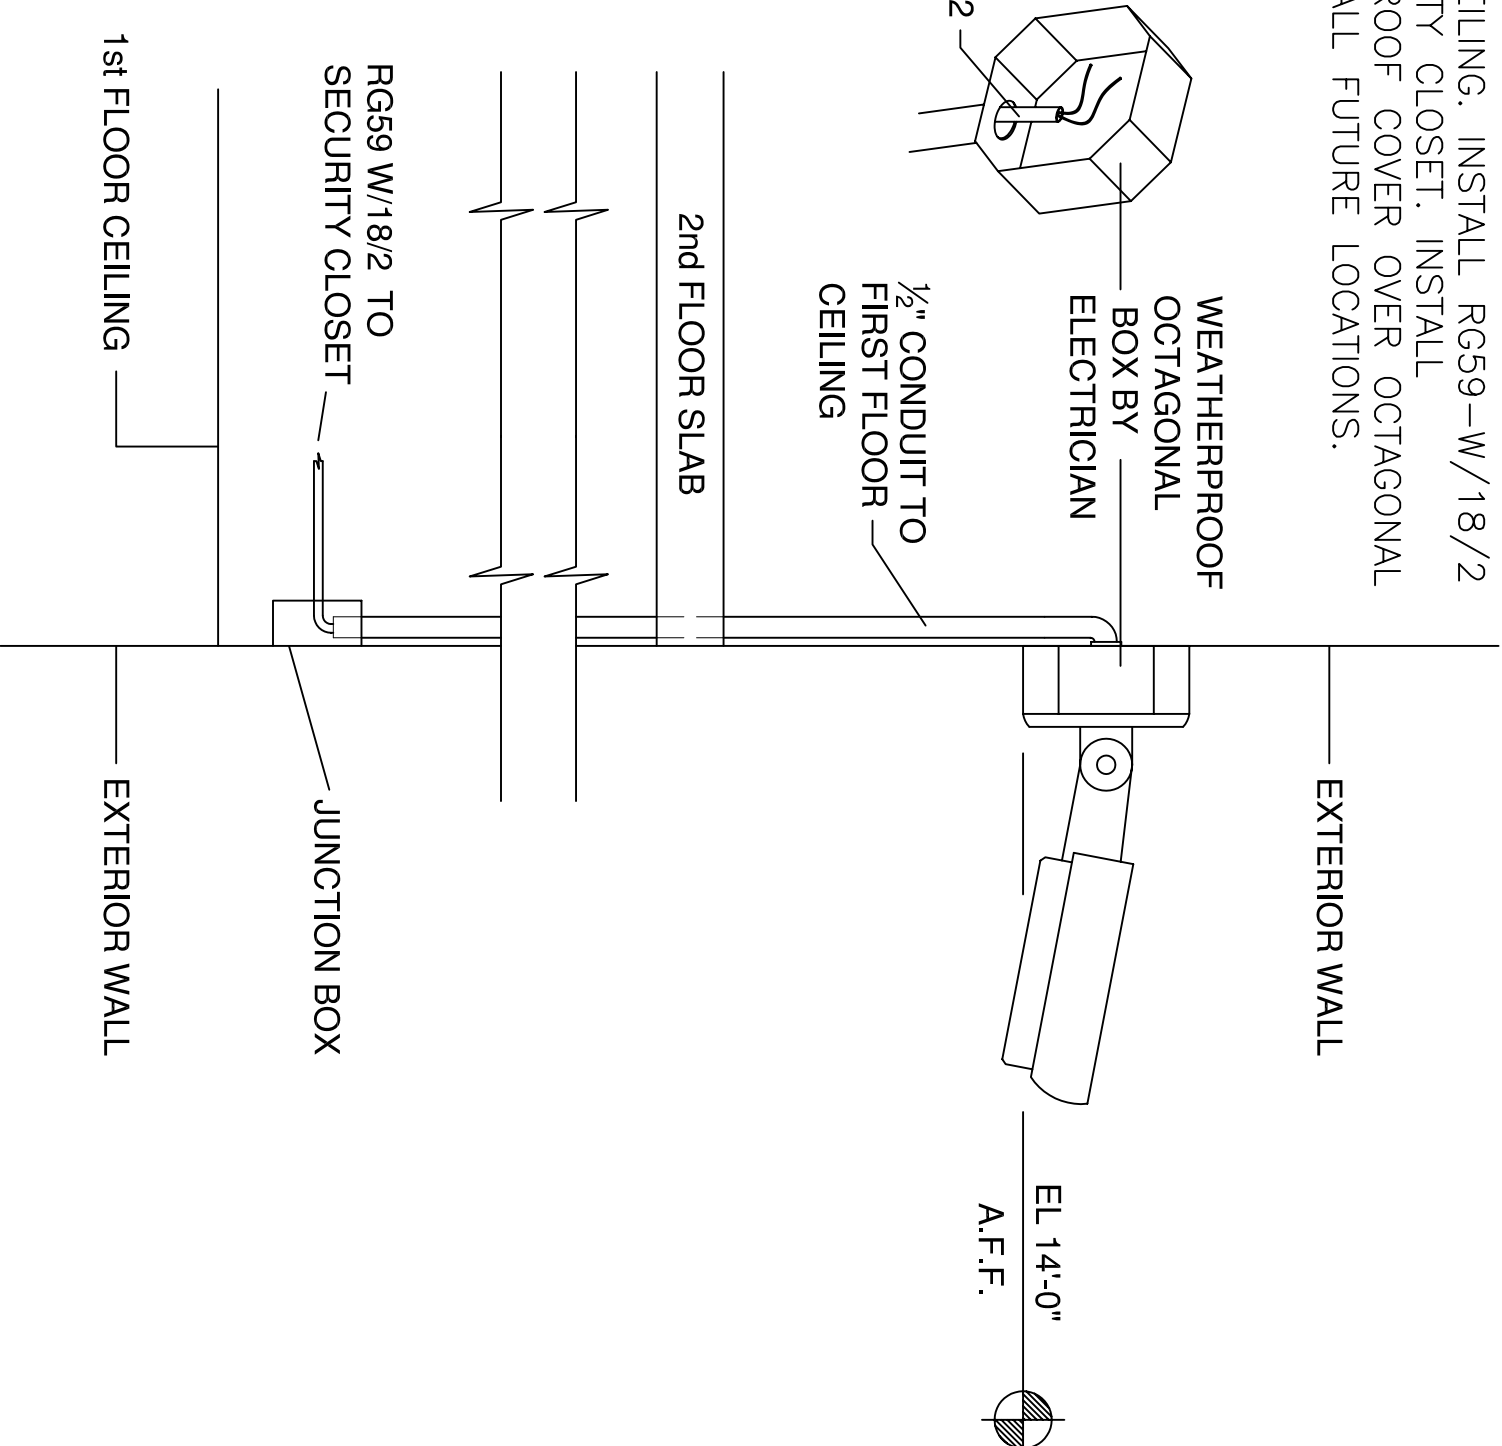

**IR MAX ENVIROCAM DETAIL**



---

N.T.S.

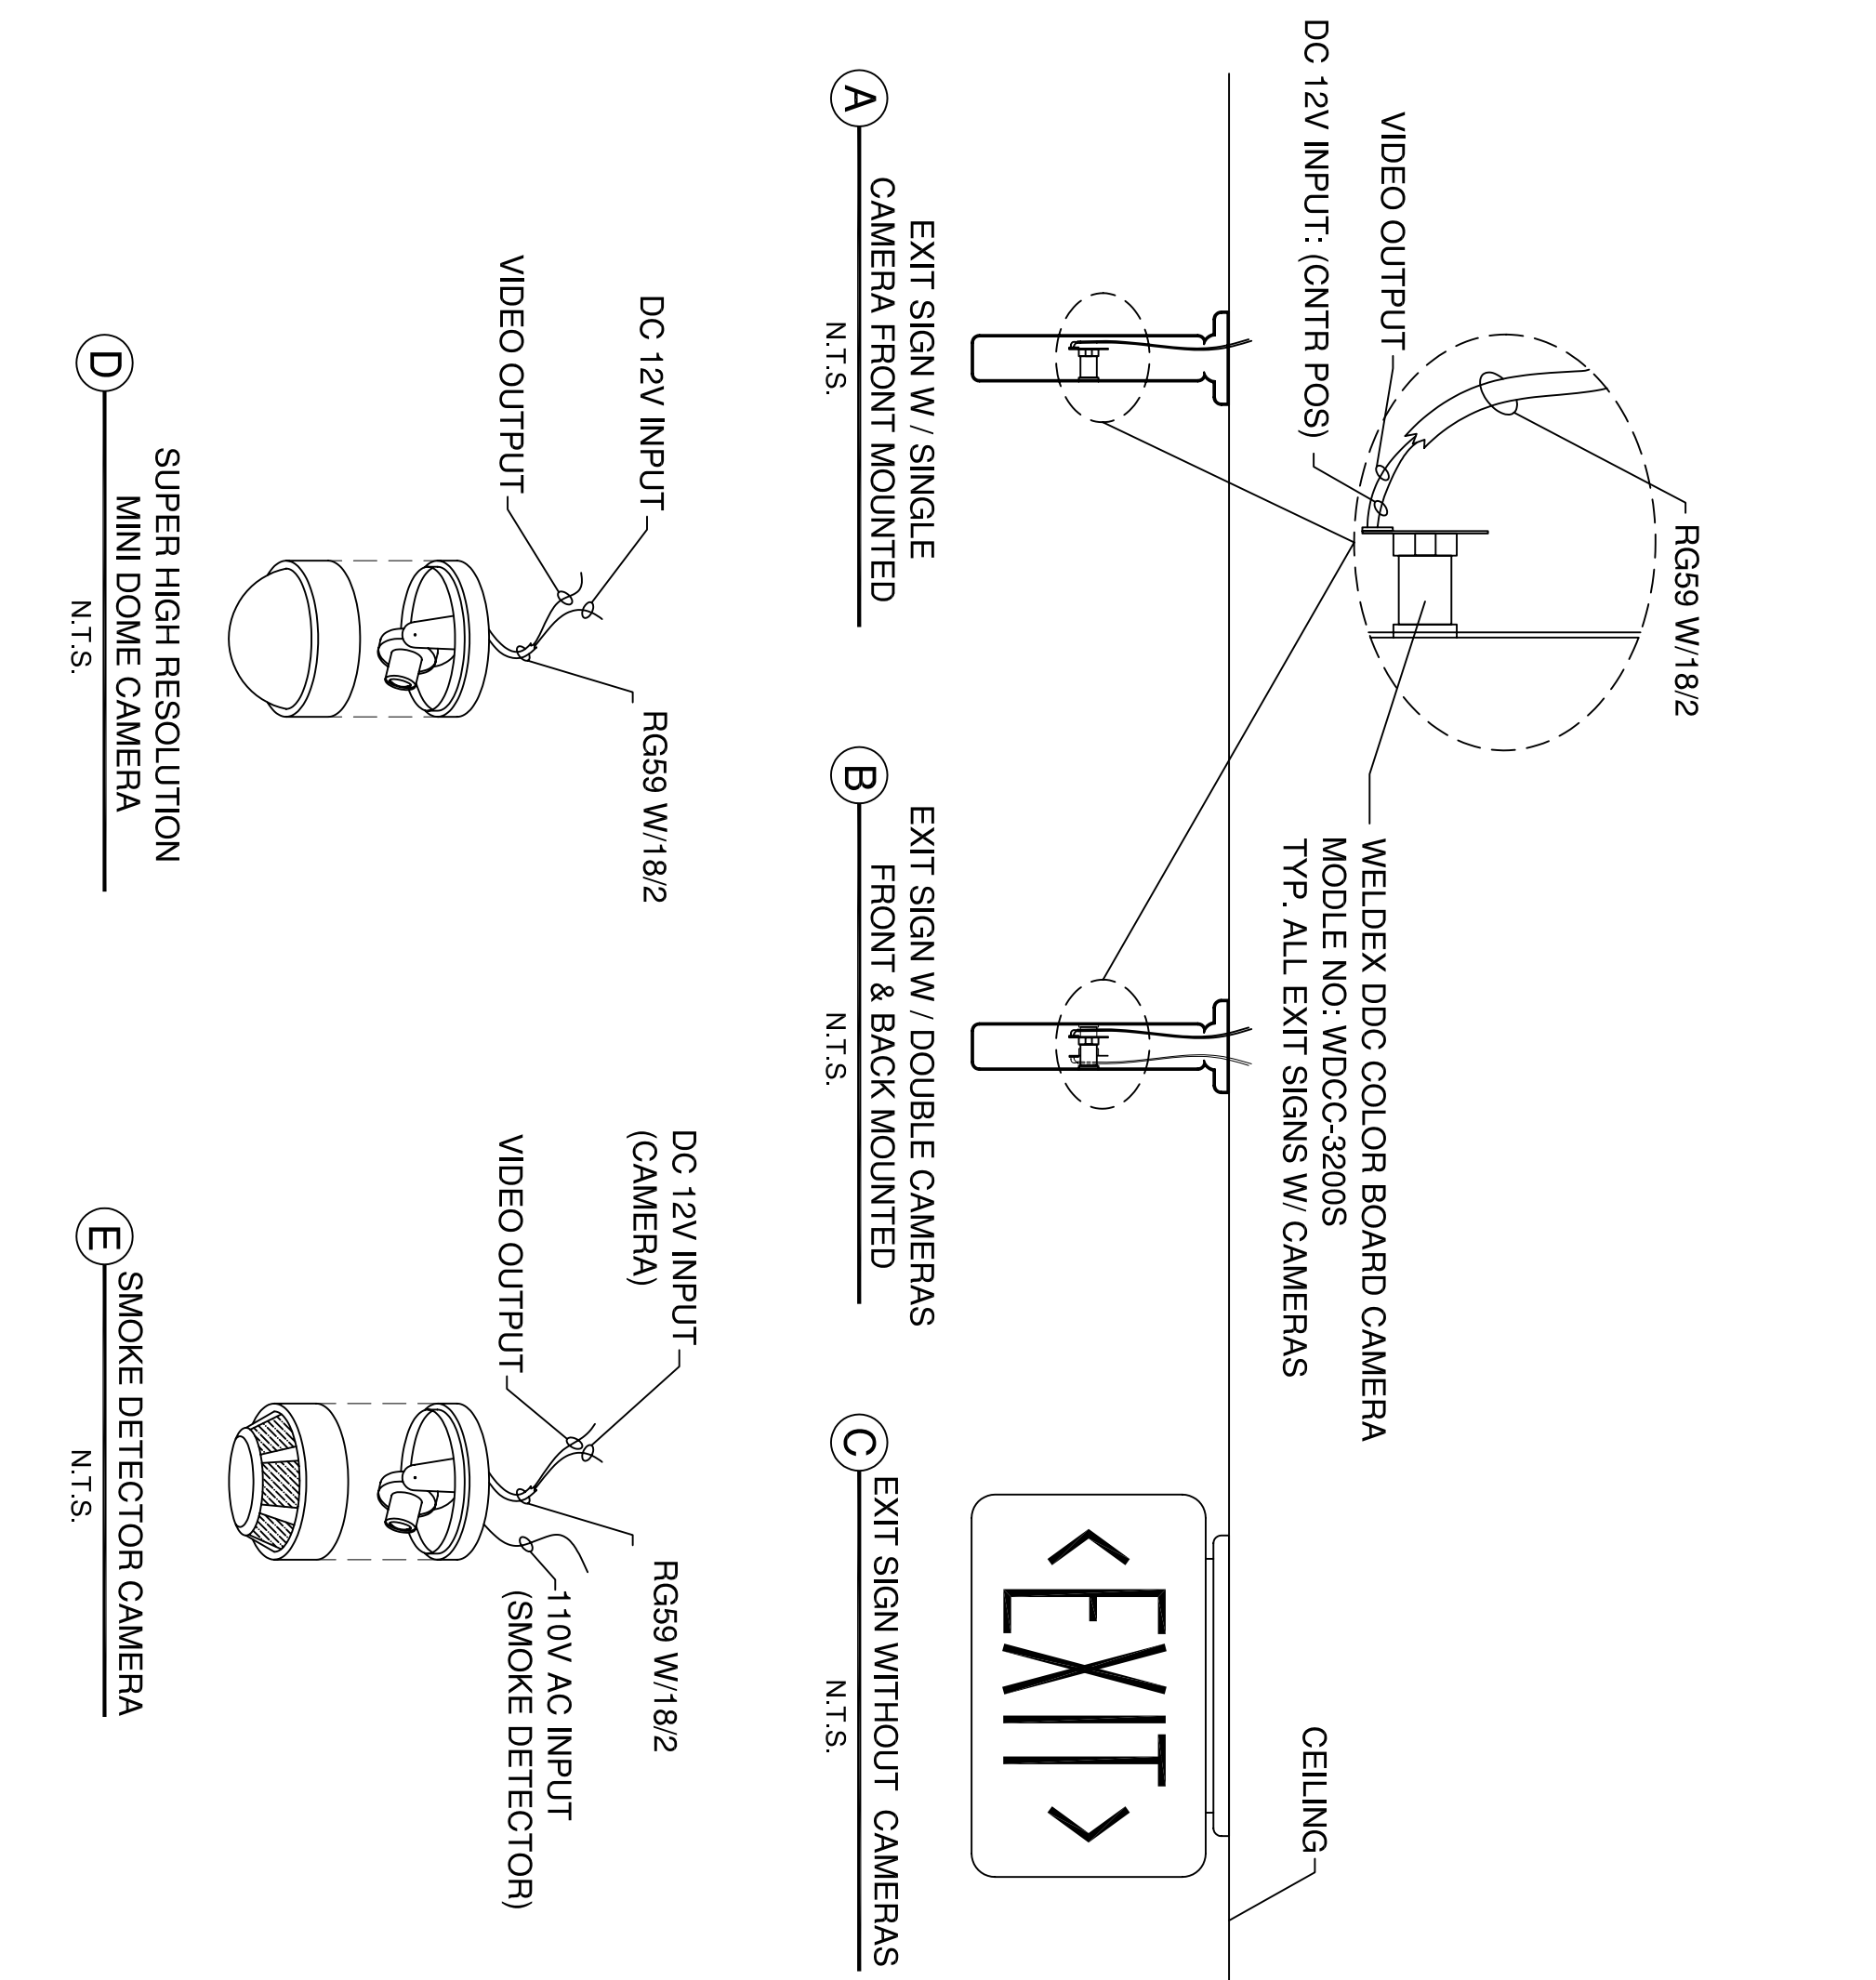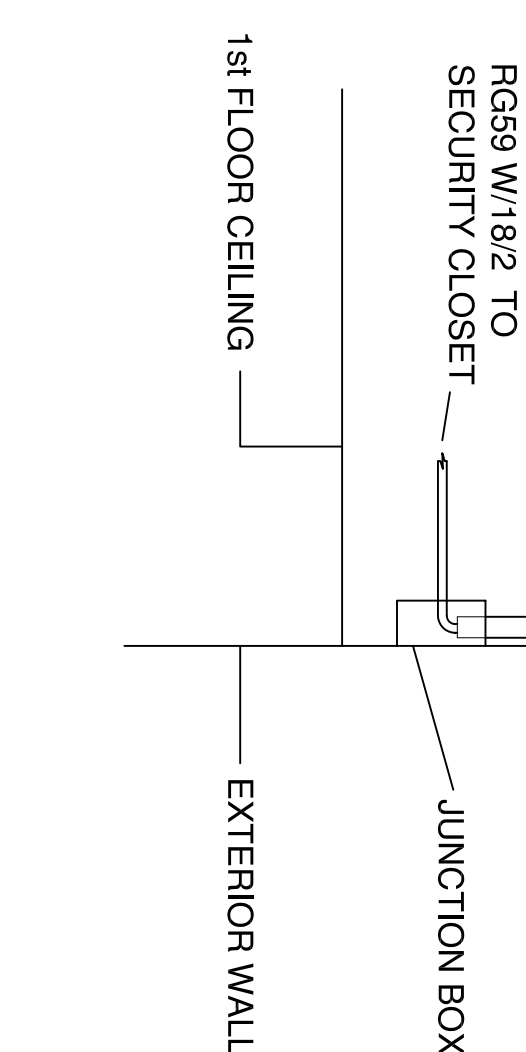

**E** SMOKE DETECTOR CAMERA  
N.T.S.

**D** SUPER HIGH RESOLUTION  
MINI DOME CAMERA  
N.T.S.

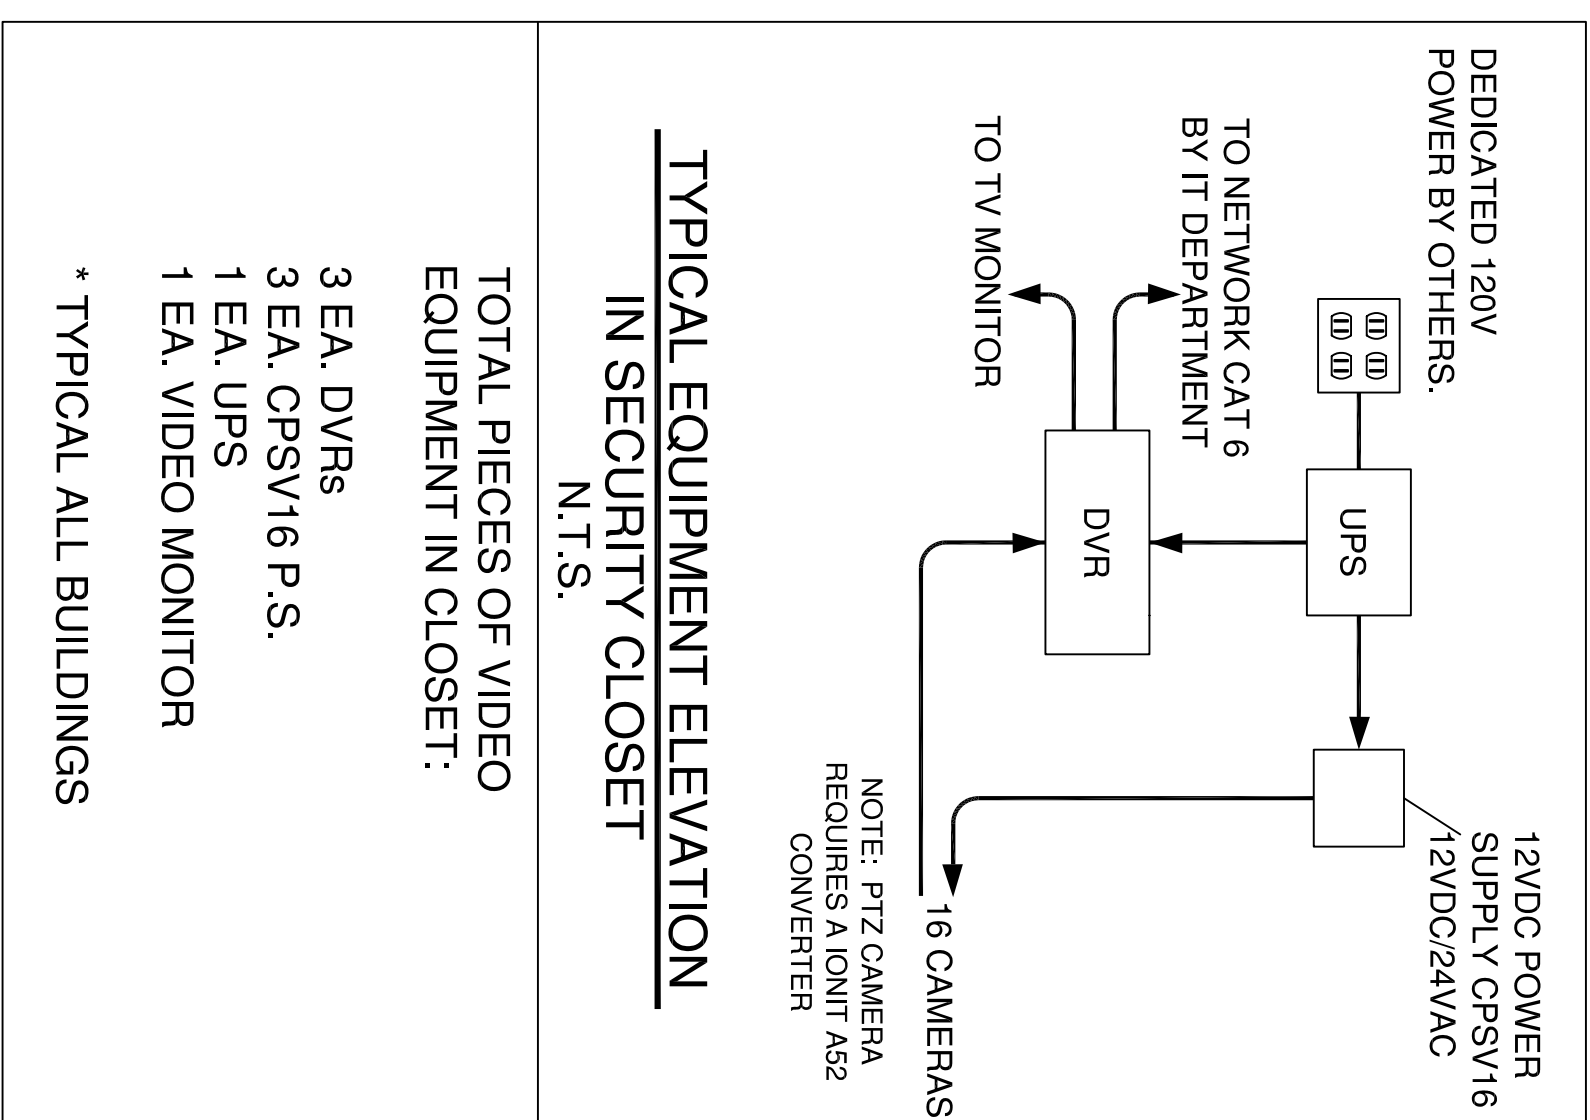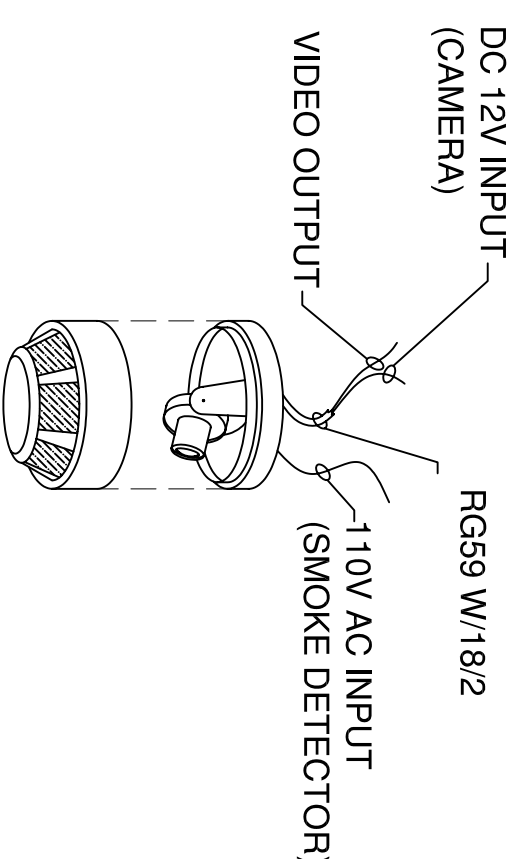


**TYPICAL EQUIPMENT ELEVATION  
IN SECURITY CLOSET  
N.T.S.**


**TOTAL PIECES OF VIDEO EQUIPMENT IN CLOSET:**

3 EA. DVRs  
3 EA. CPSPV16 P.S.  
1 EA. UPS  
1 EA. VIDEO MONITOR  
\* TYPICAL ALL BUILDING


\* TYPICAL ALL BUILDINGS

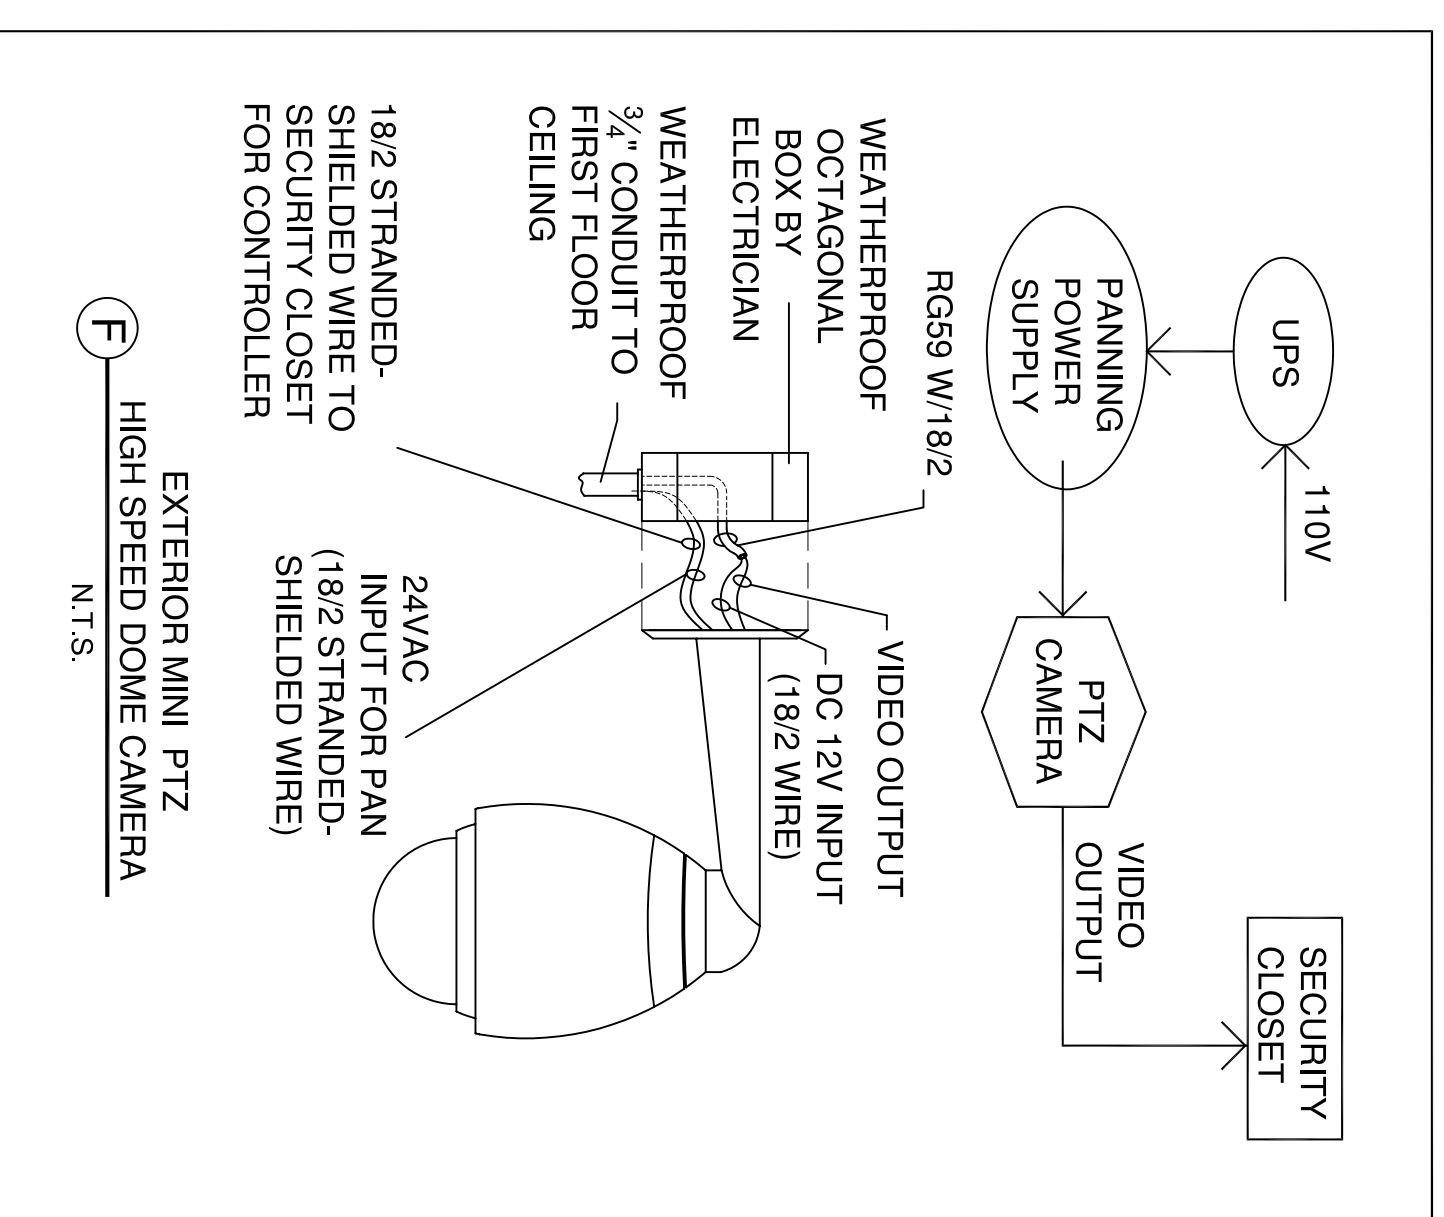

EXTERIOR MINI PTZ  
HIGH SPEED DOME CAMERA  
N.T.S.

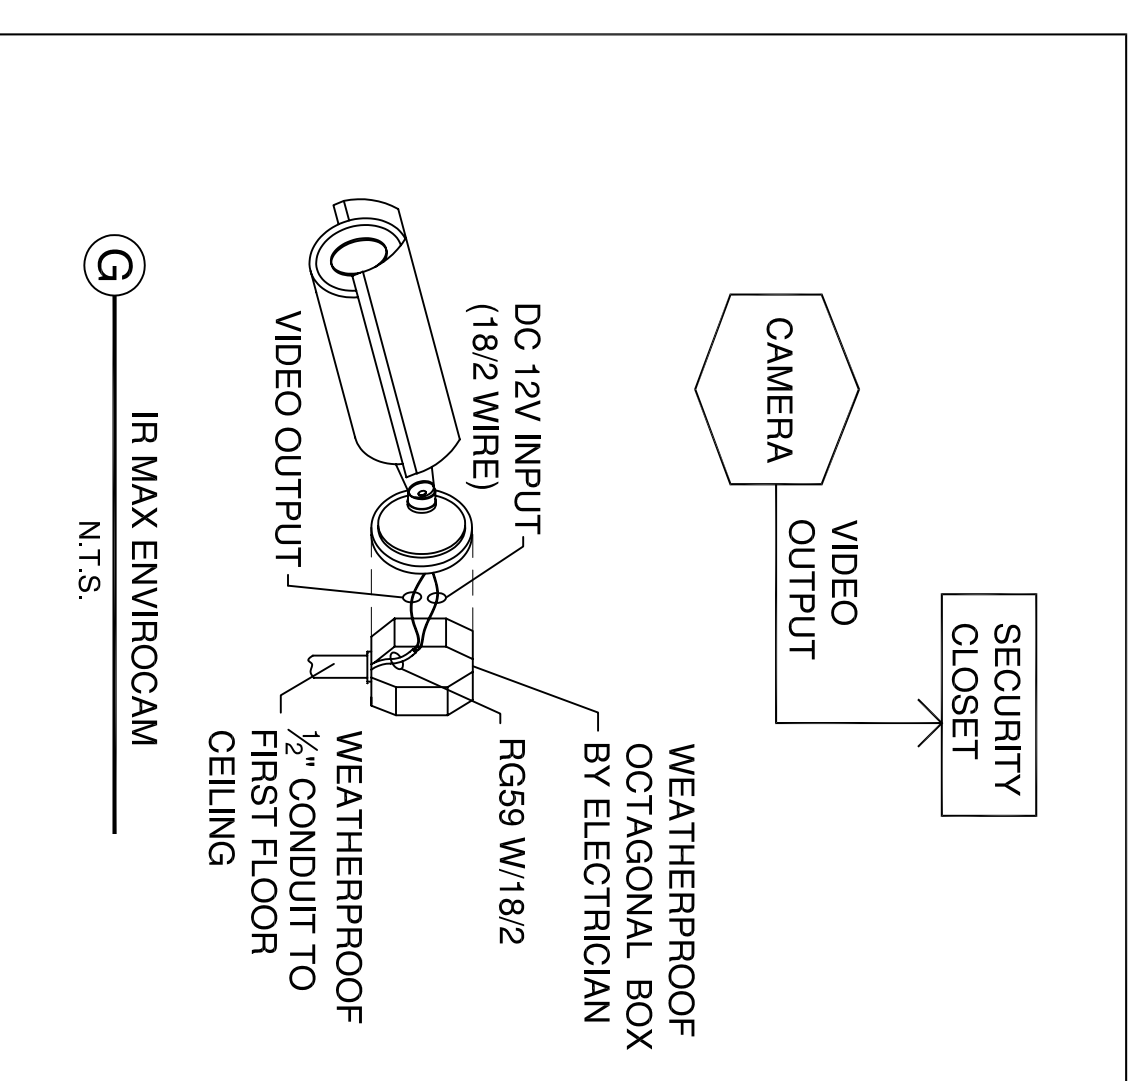

.....  
G  
N.T.S


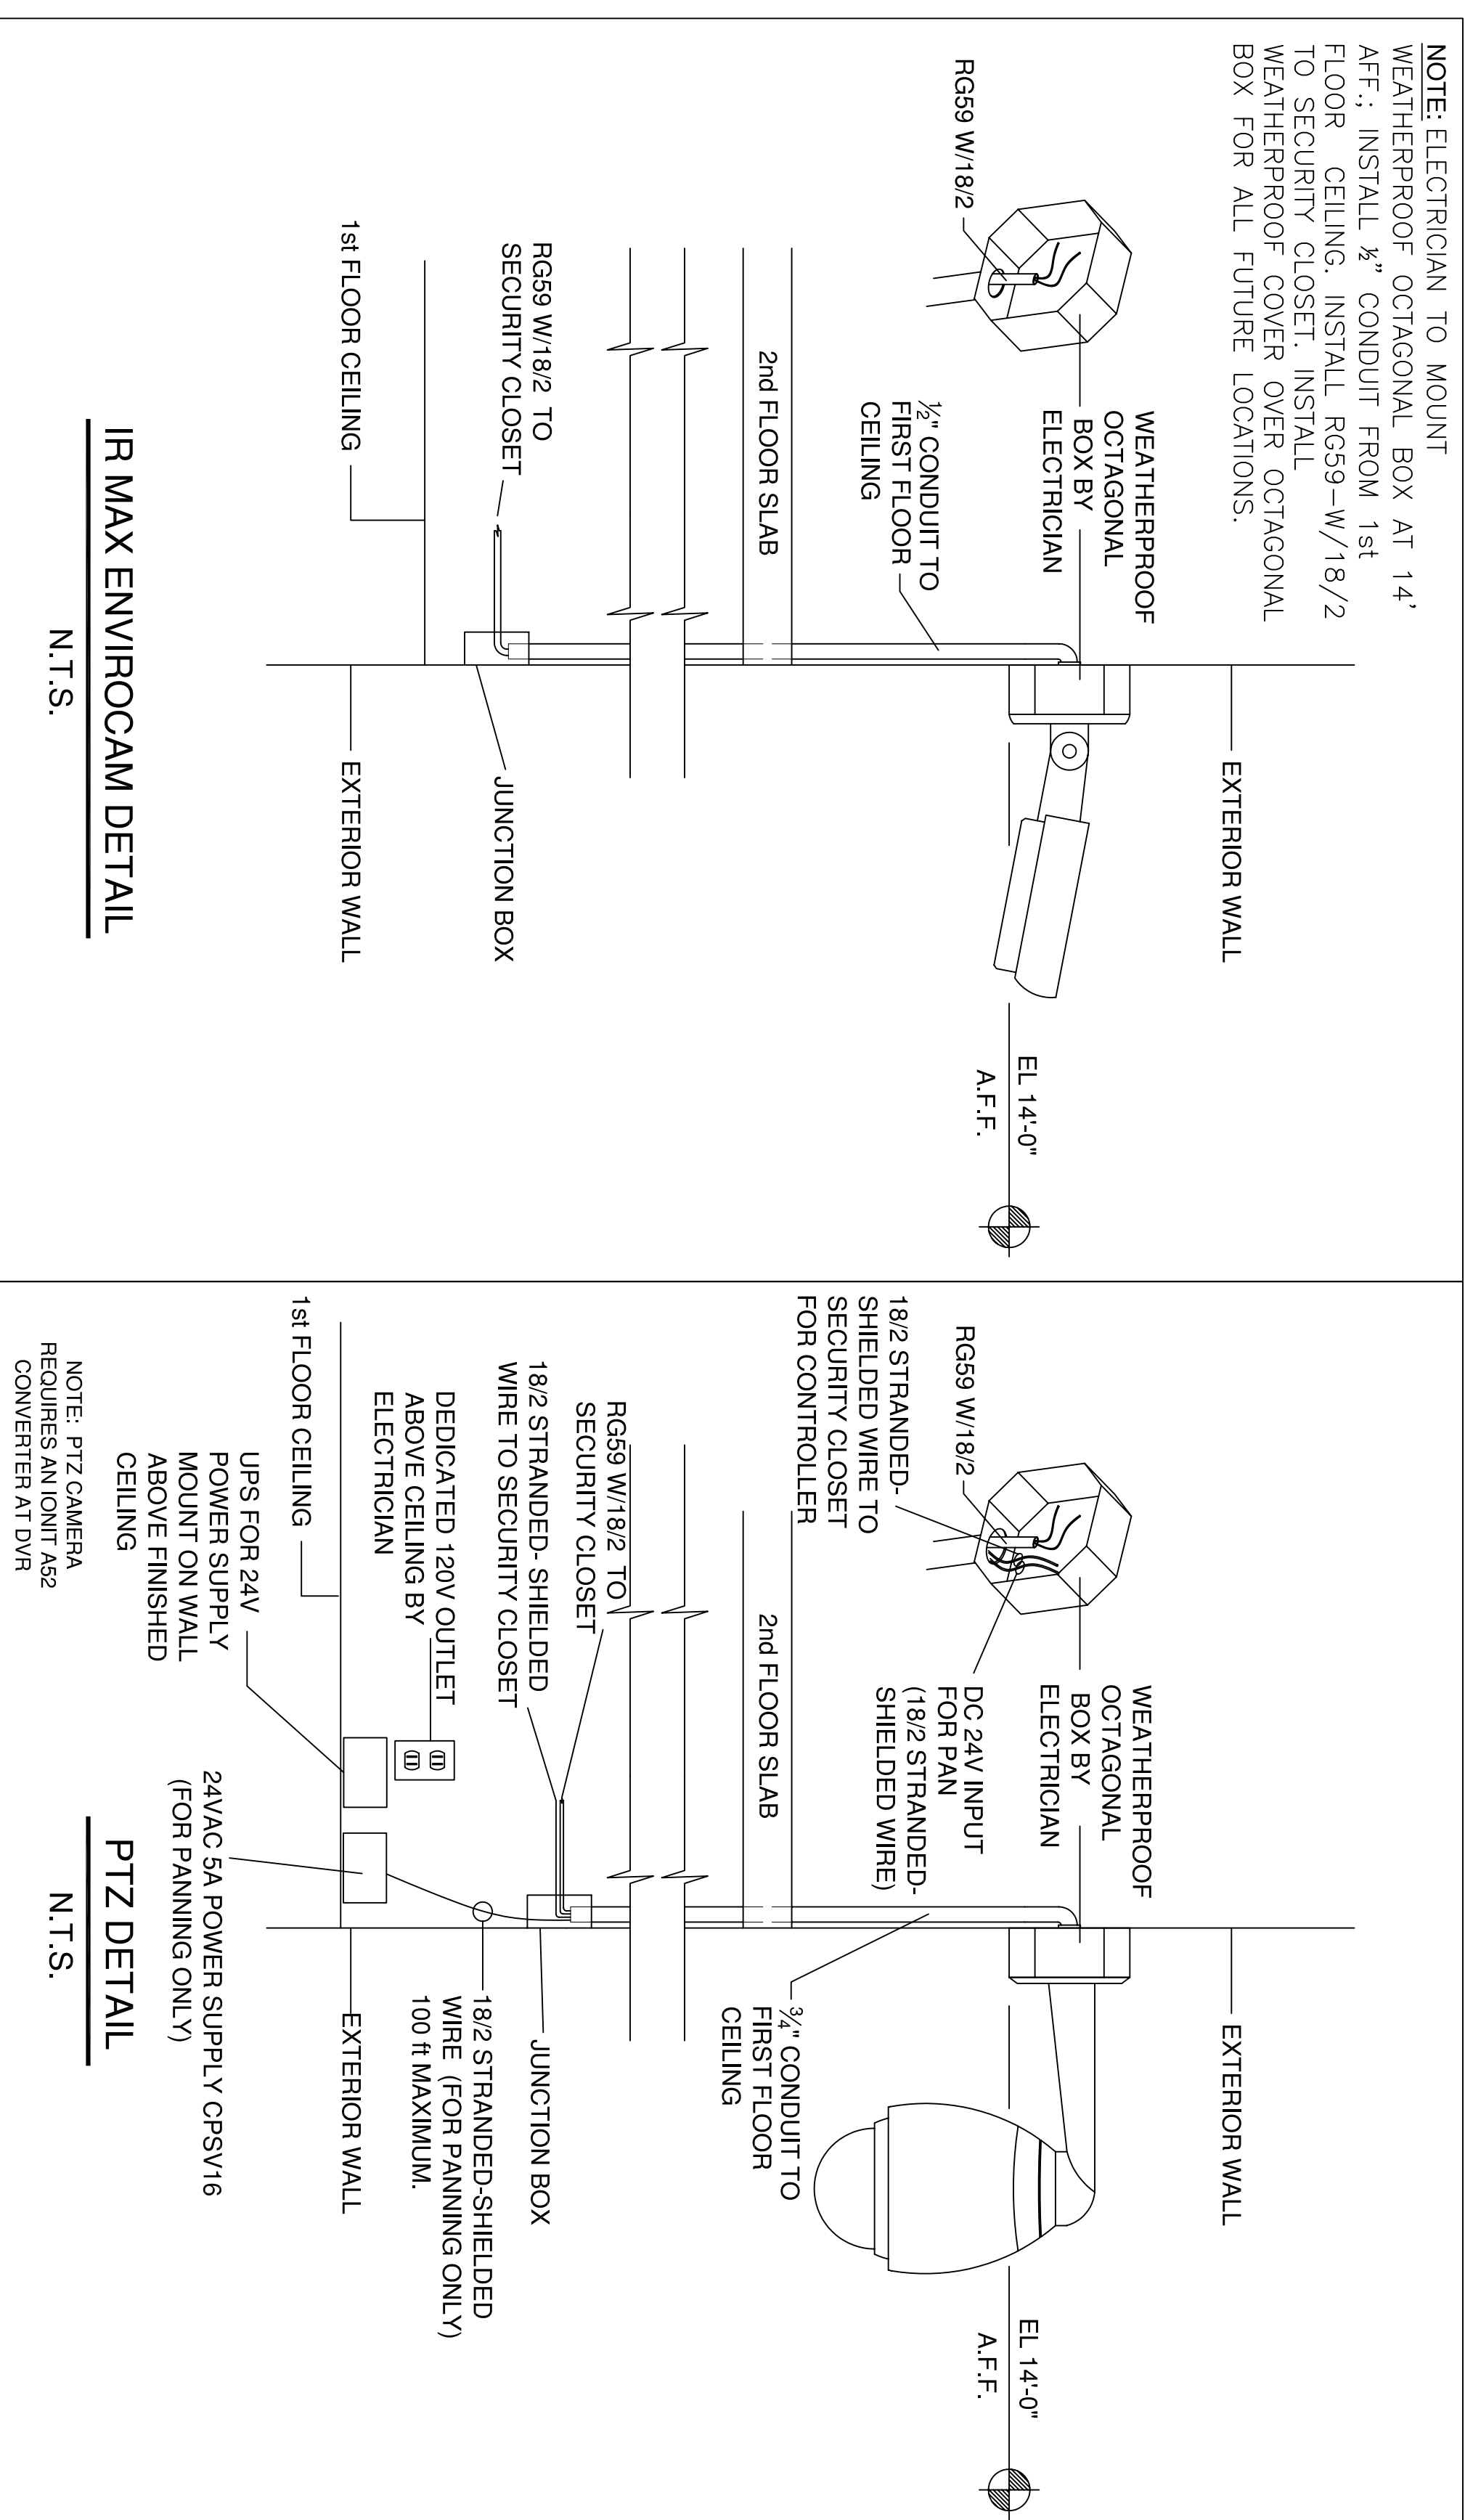


PTZ DETAIL

---

N.T.S.

NOTE: PTZ CAMERA  
REQUIRES AN IONIT A55  
CONVERTER AT DVR

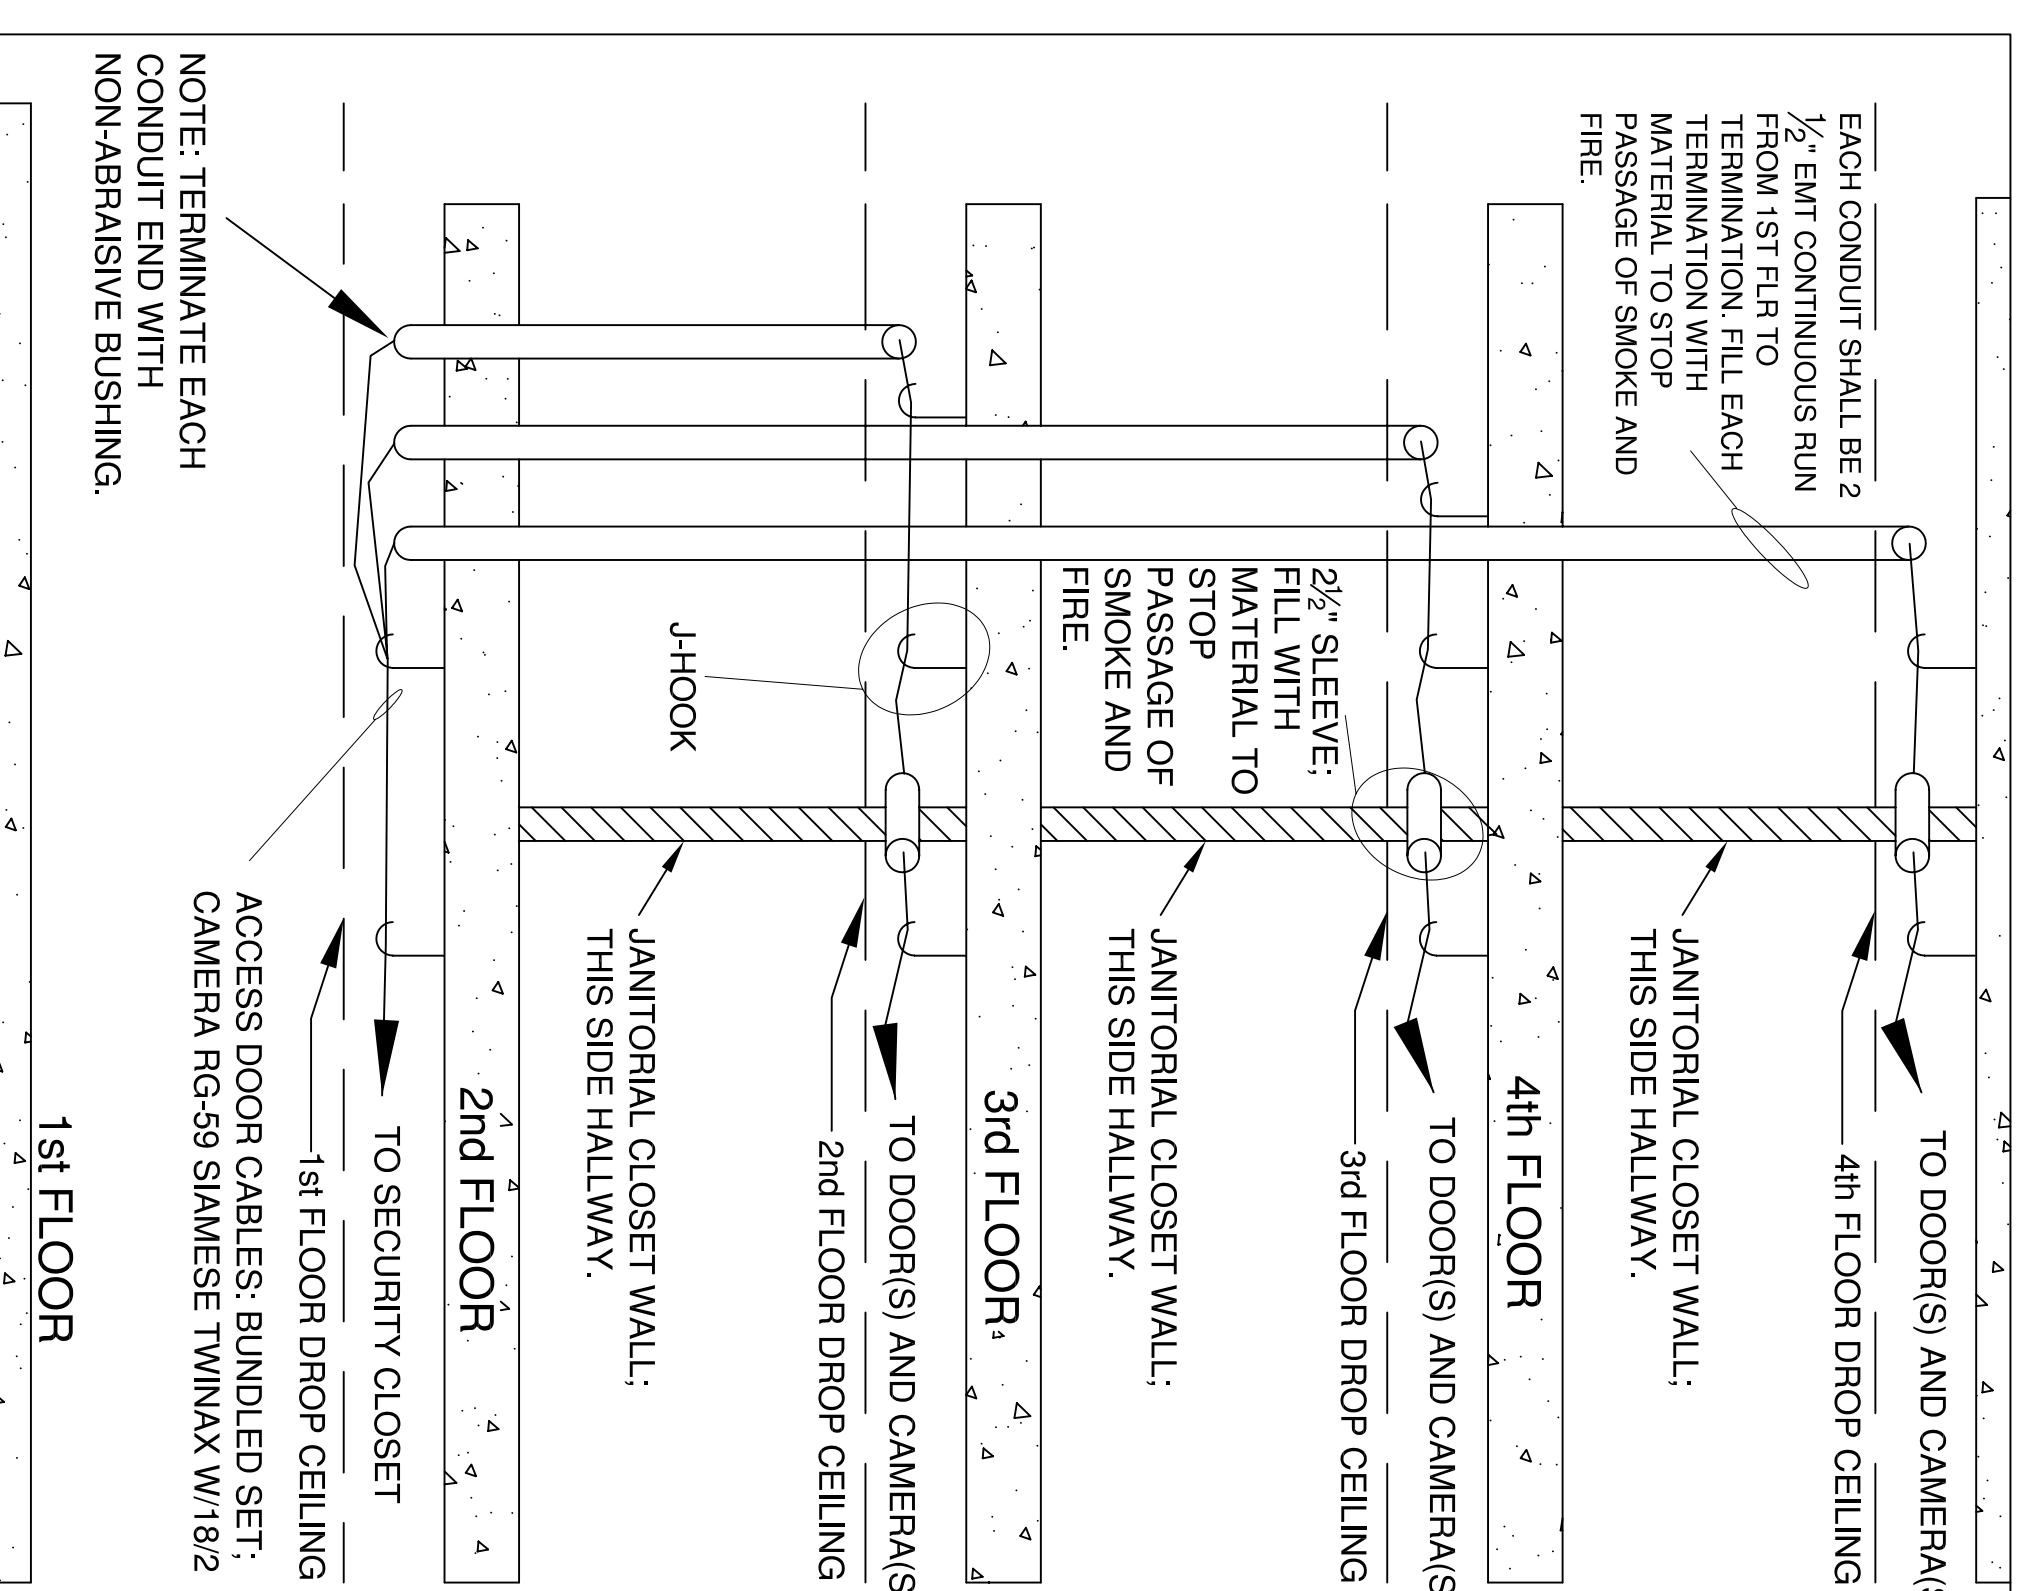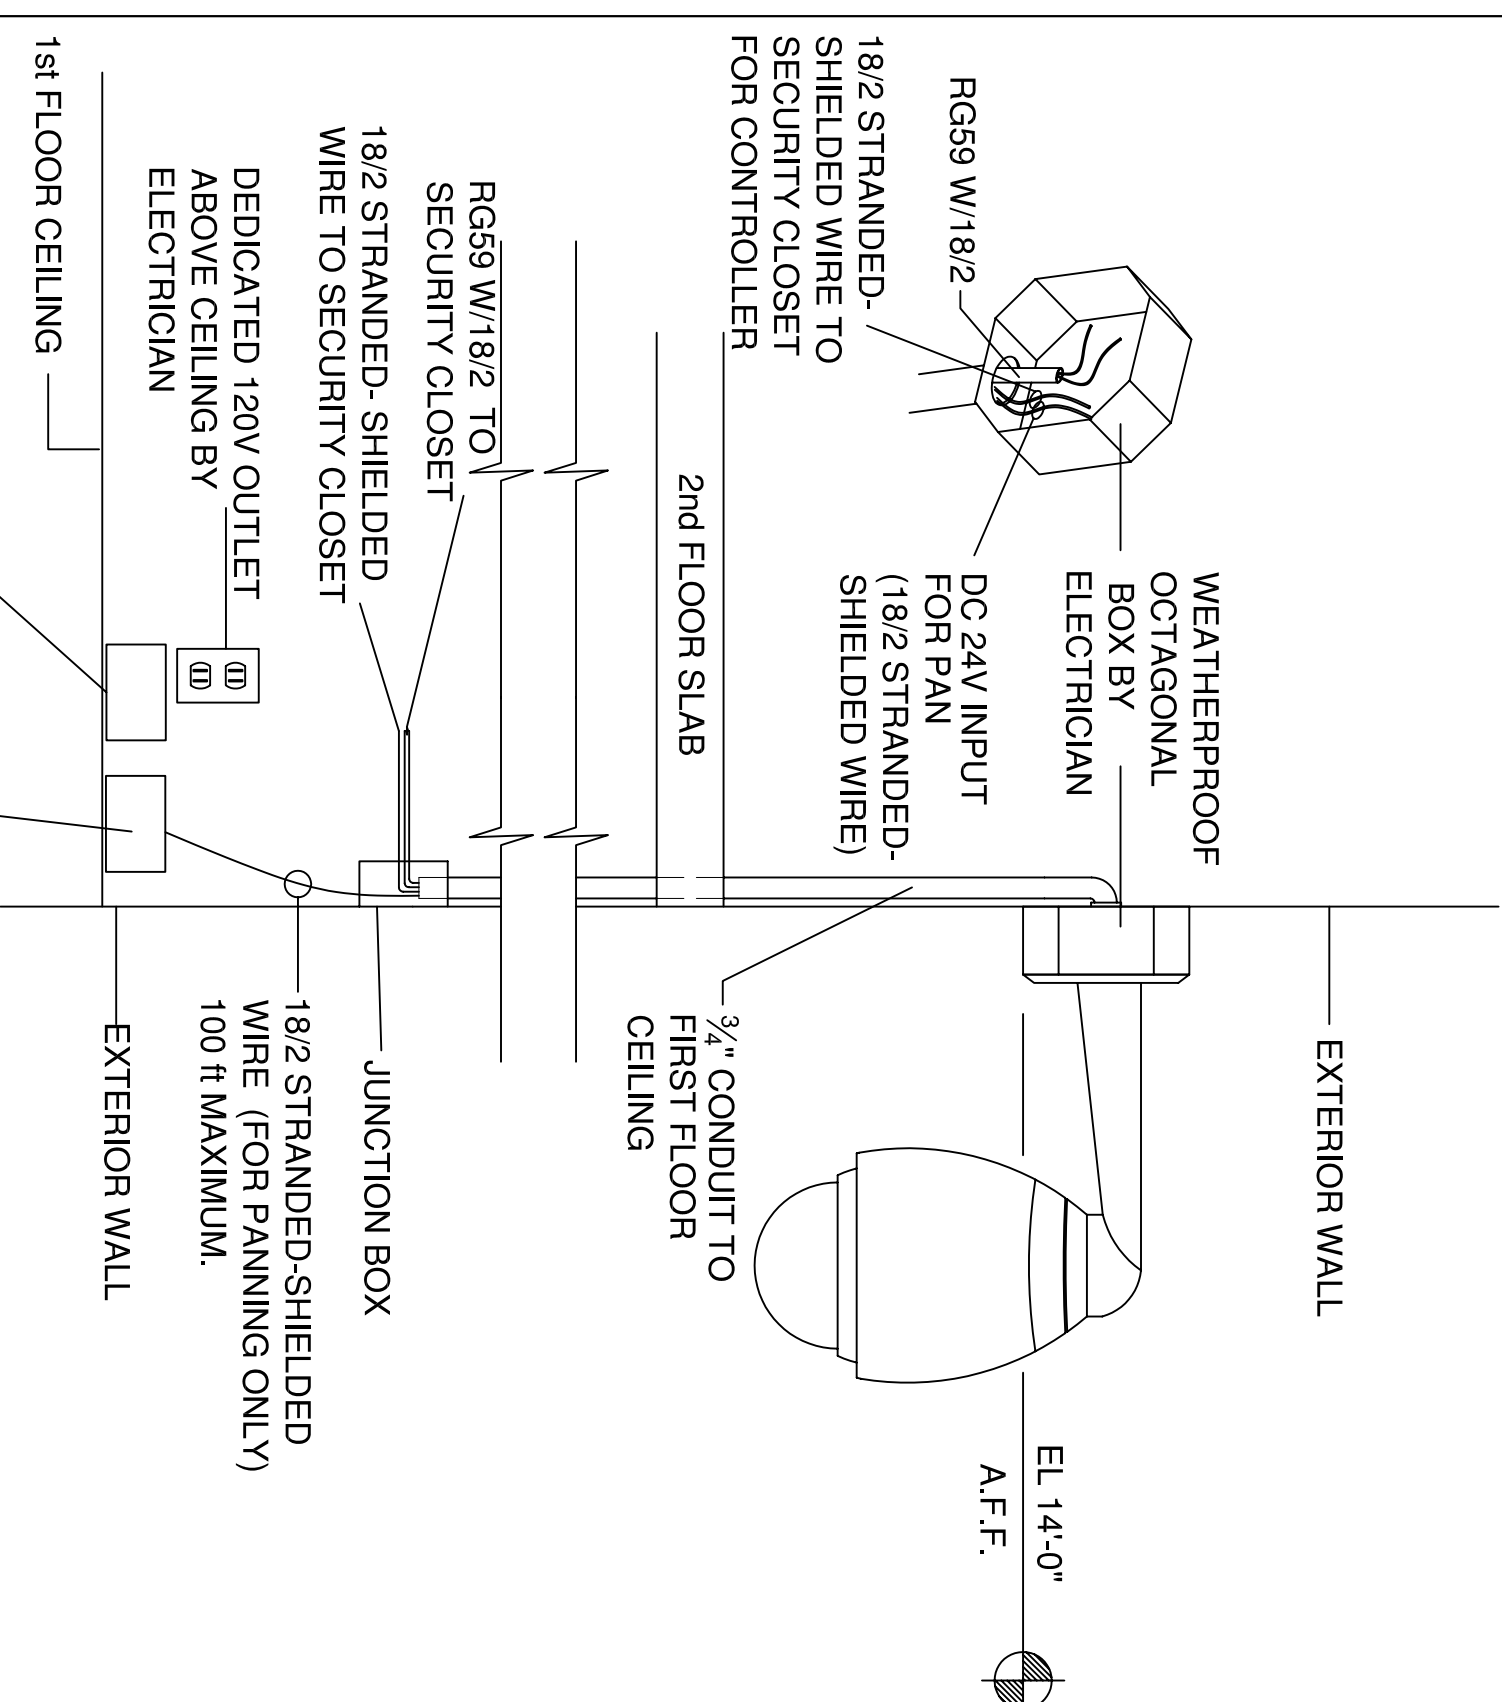

NOTE: TERMINATE EACH CONDUIT END WITH NON-ABRAISIVE BUSHING