


GYMNASIUM HVAC REPLACEMENT @ BOYET JUNIOR HIGH SCHOOL

ST. TAMMANY PARISH SCHOOL BOARD
STPSB PROJECT NO. P0428

ST. TAMMANY PARISH LOUISIANA

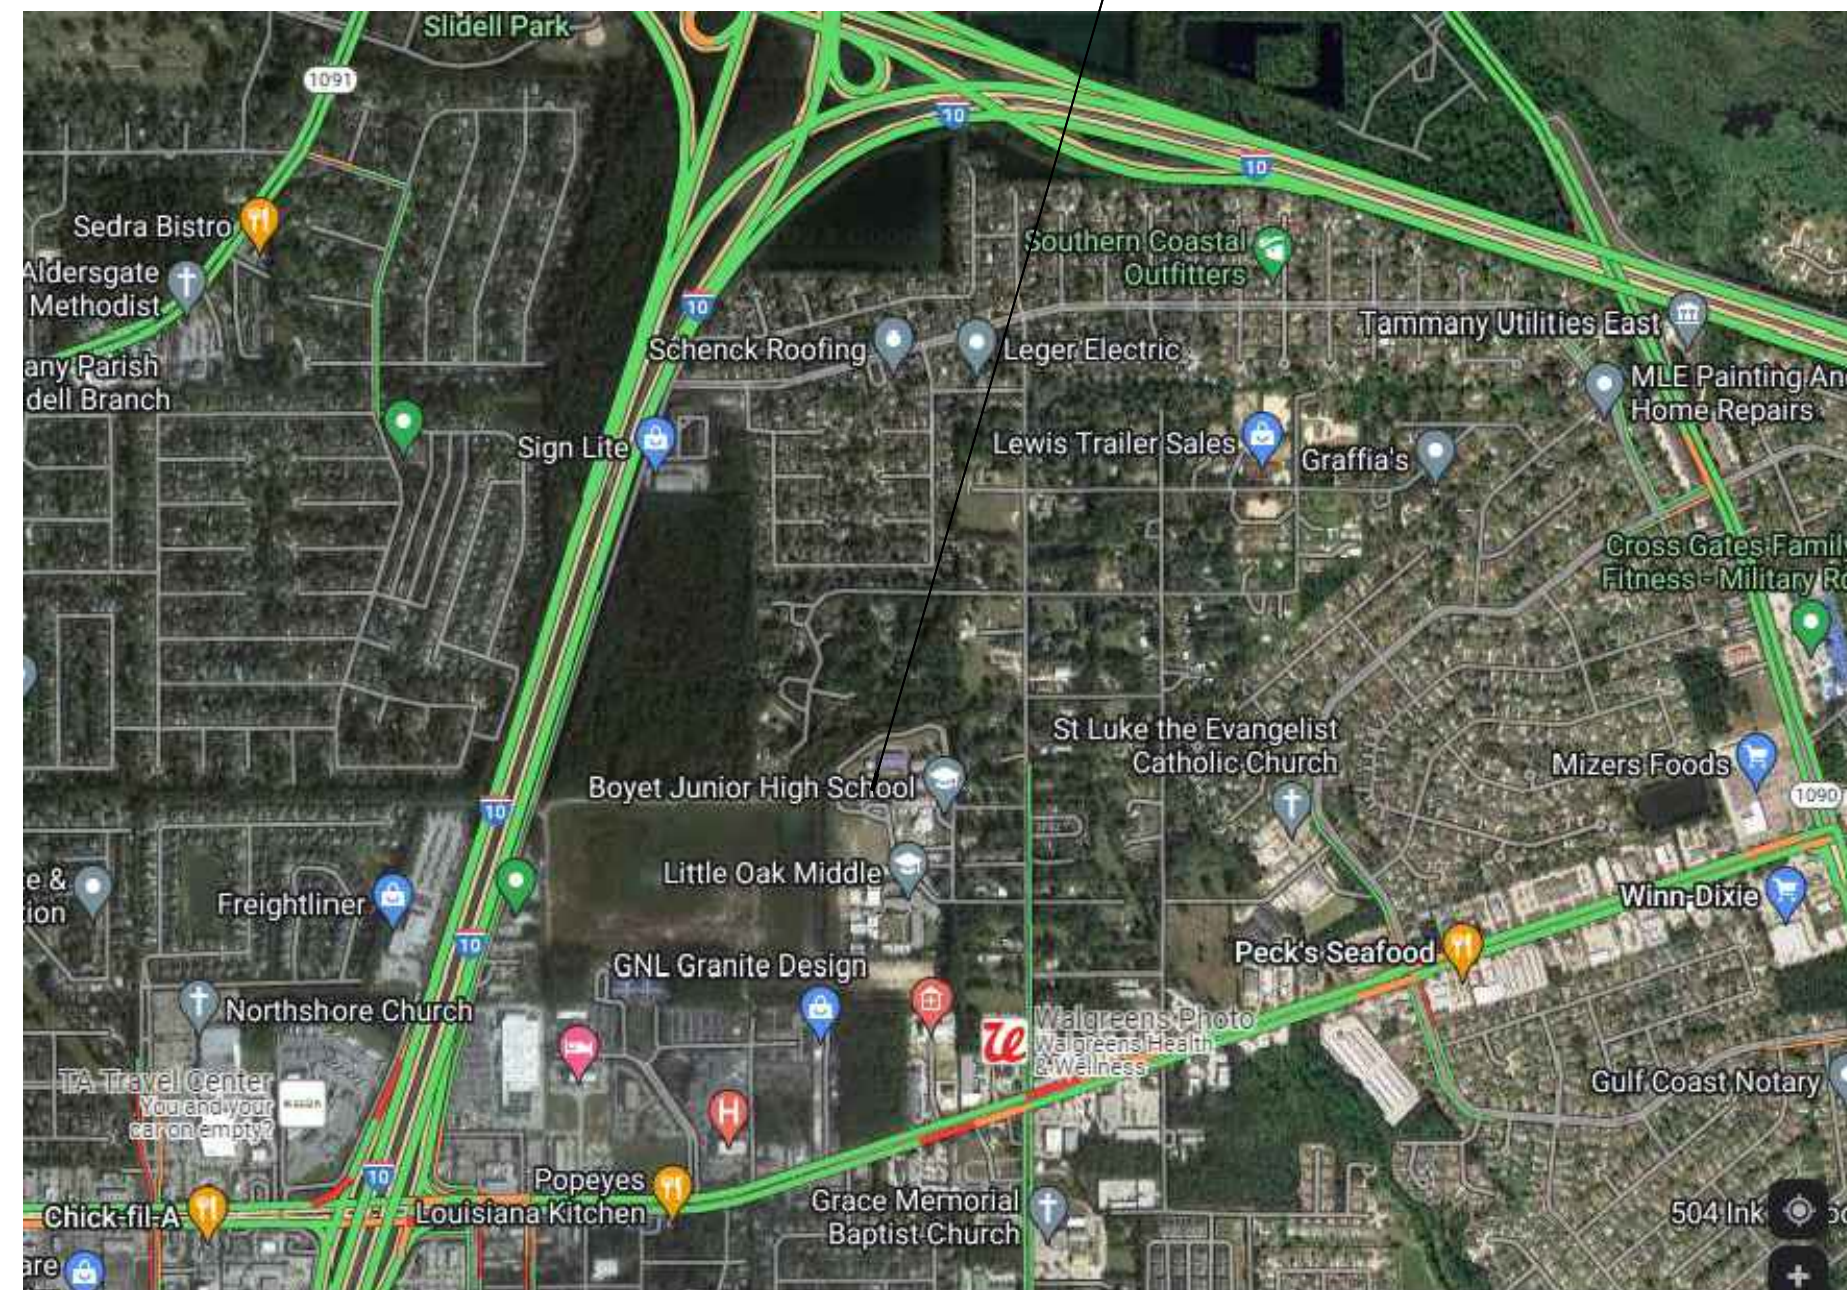

VICINITY MAP



SITE PLAN
SCALE: 1" = 100'-0"

SHEET INDEX

SHEET #	SHEET TITLE
G101	COVER SHEET
D101	DEMO PLAN
S101	STRUCTURAL PLAN
S102	STRUCTURAL DETAILS
M101	MECHANICAL PLAN
M102	ROOF PLAN
M103	MECHANICAL DETAILS
E101	ELECTRICAL PLAN
E102	ELECTRICAL PANEL SCHEDULES

DAMMON
ENGINEERING, INC.
LOUISIANA & MISSISSIPPI

www.dammonengineering.com
info@dammon.com
PH: 985.646.5832

Chief Engineer: Brian Mistich, PE
50245 Rebel Dr.
Sldell, LA 70461

#	DESCRIPTION	DATE

SEAL:

BAM

MECHANICAL RENOVATIONS
BOYET JUNIOR HIGH SCHOOL

50245 Rebel Dr.
Sldell, LA 70461
JOB No: 2465 DATE: 9-11-2023
DRAWN BY: CHECKED BY:

SHEET TITLE:
COVER SHEET

DRAWING NUMBER:
G101

SHEET No: 1 of 1