


MATCHLINE SHT "M-4"

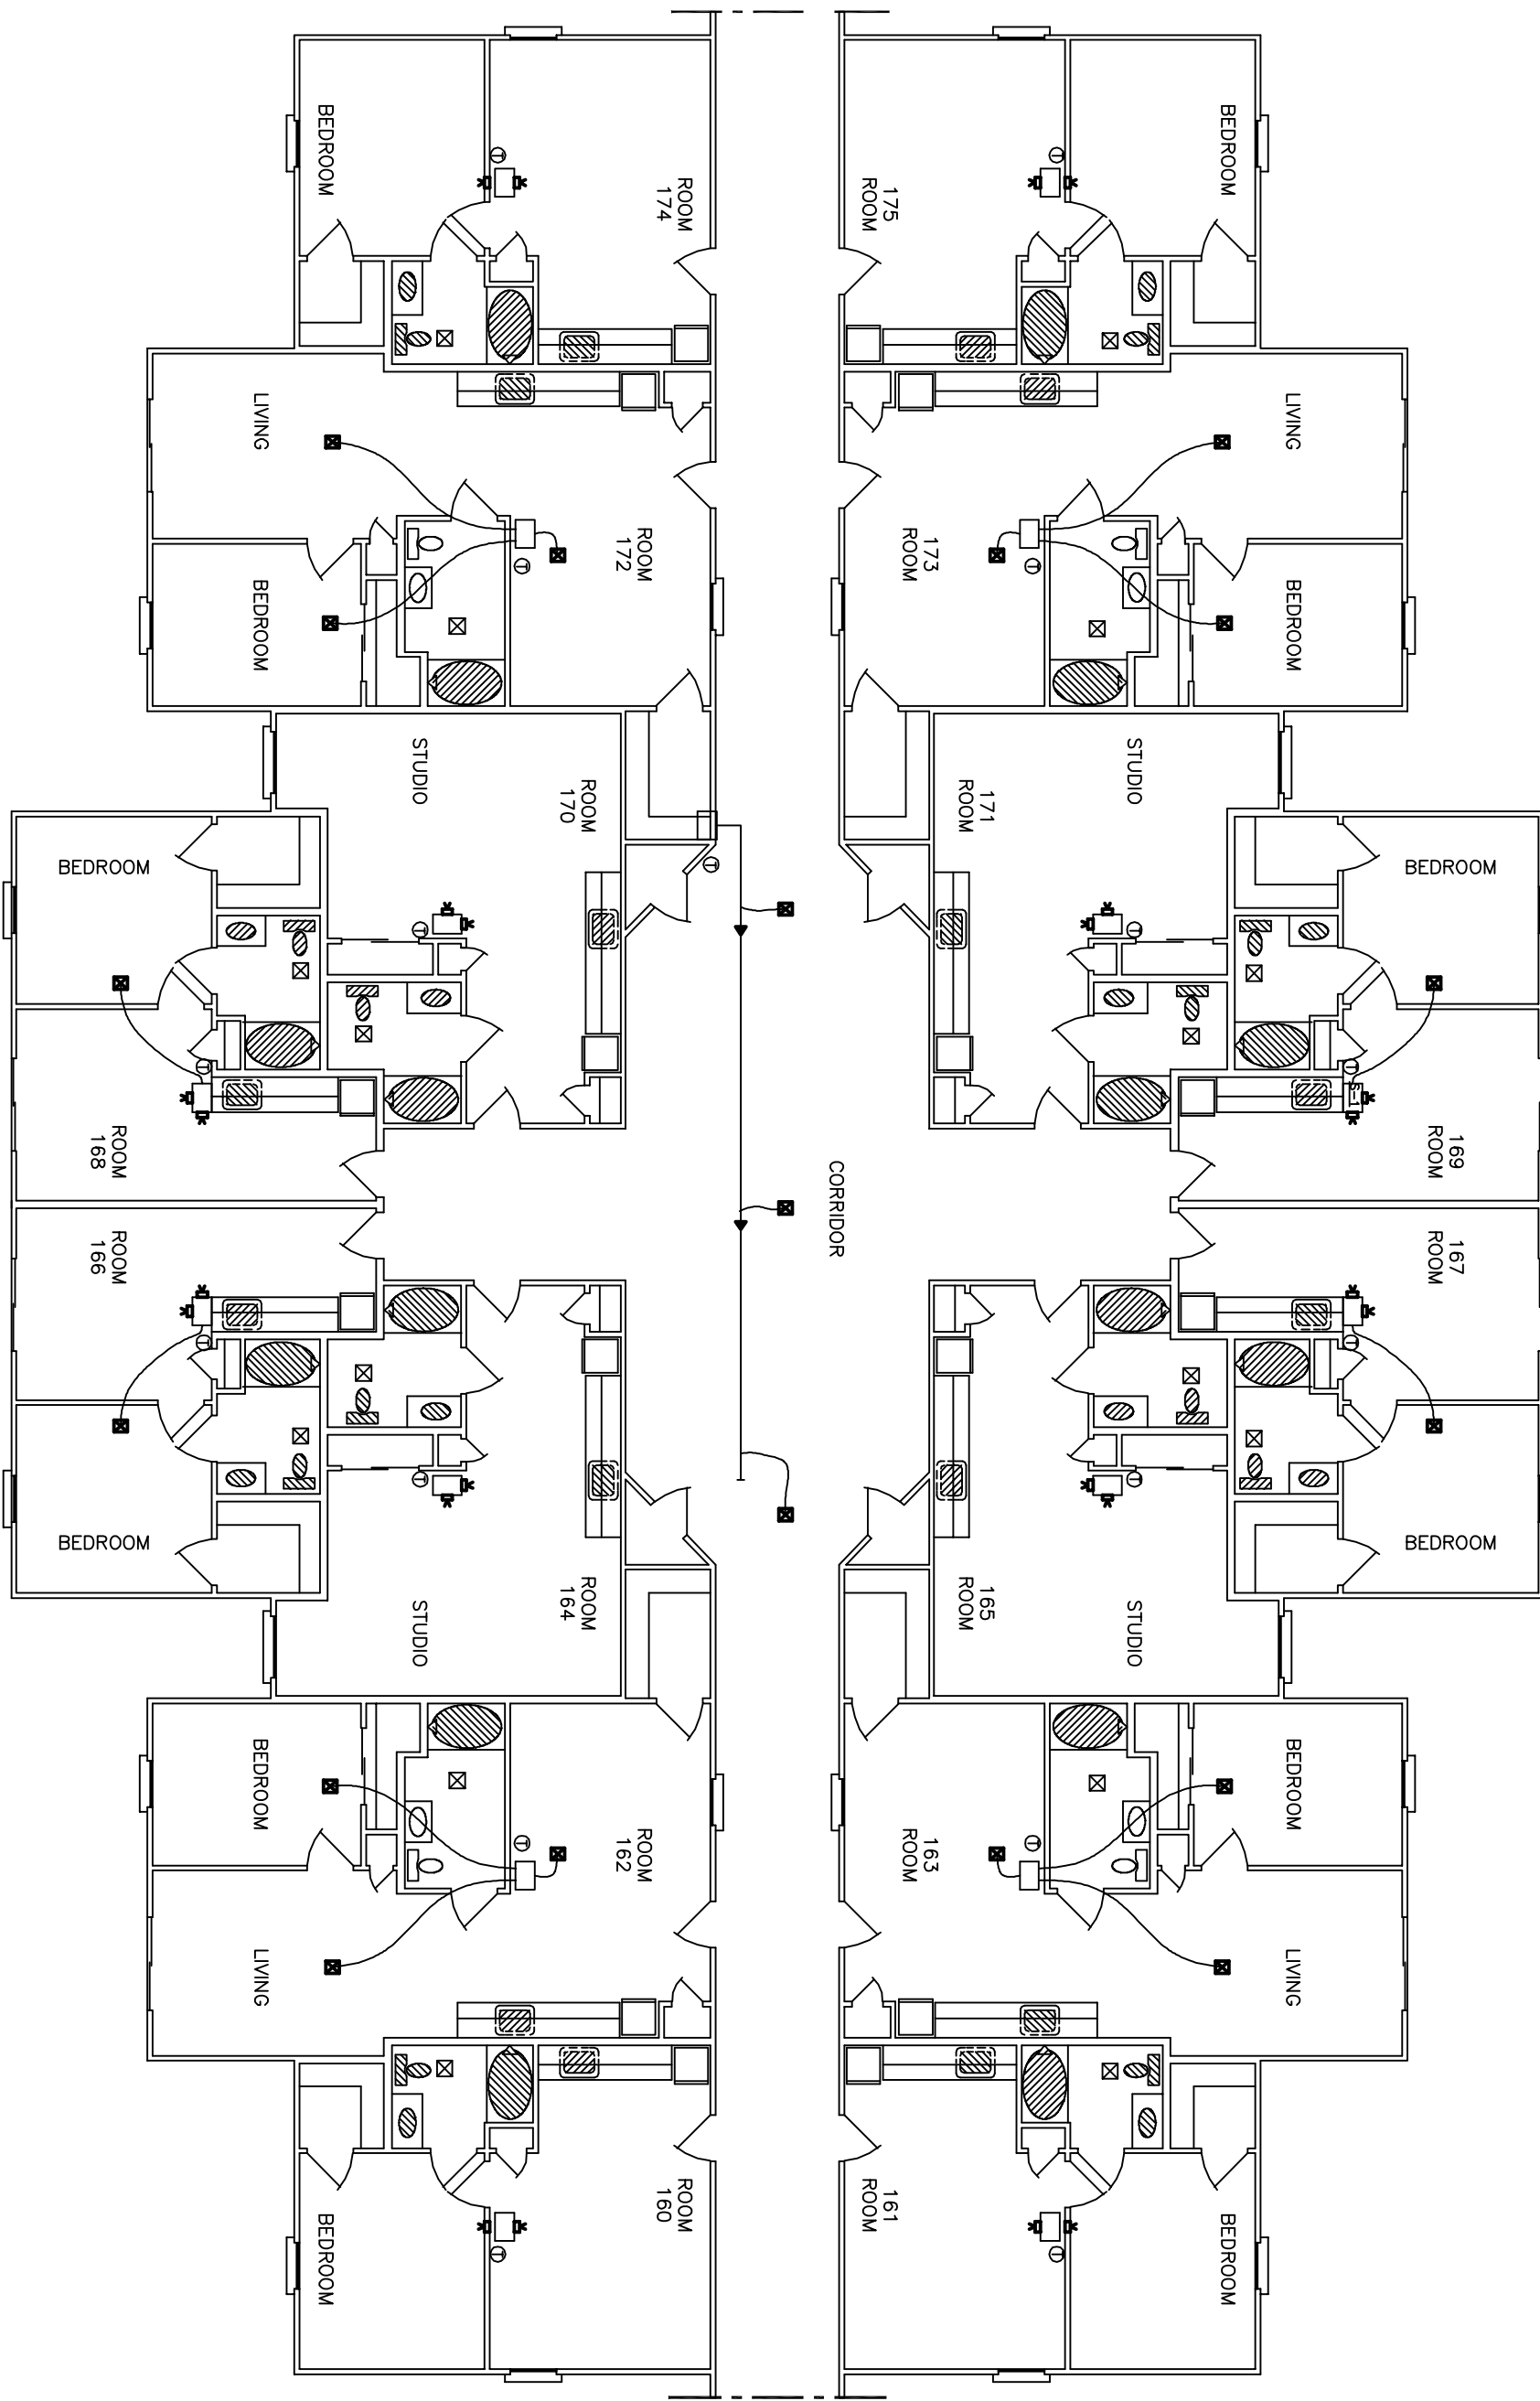

MATCHLINE SHT "M-6"

BLDG. #4  
 HVAC PLAN VIEW  
 SCALE: 3/16" = 1'-0"

REVISED 01/03/01

SCALE: AS NOTED	FILE: -	JOB No.: -	DATE: 07/28/00	SHEET	OF -
				M-5	

"CAMELLIA GARDENS"

**DAMMON ENGINEERING, INC.**

ARCHITECTS - ENGINEERS

819 ROBERT ROAD      SLIDELL LA. 70458

**MARK DEVELOPMENT, LLC.**

CAMELLIA GARDENS  
 POSSUM HOLLOW ROAD  
 SLIDELL, LA