



TYPICAL APARTMENT  
ONE LINE DIAGRAM

SCALE: NONE

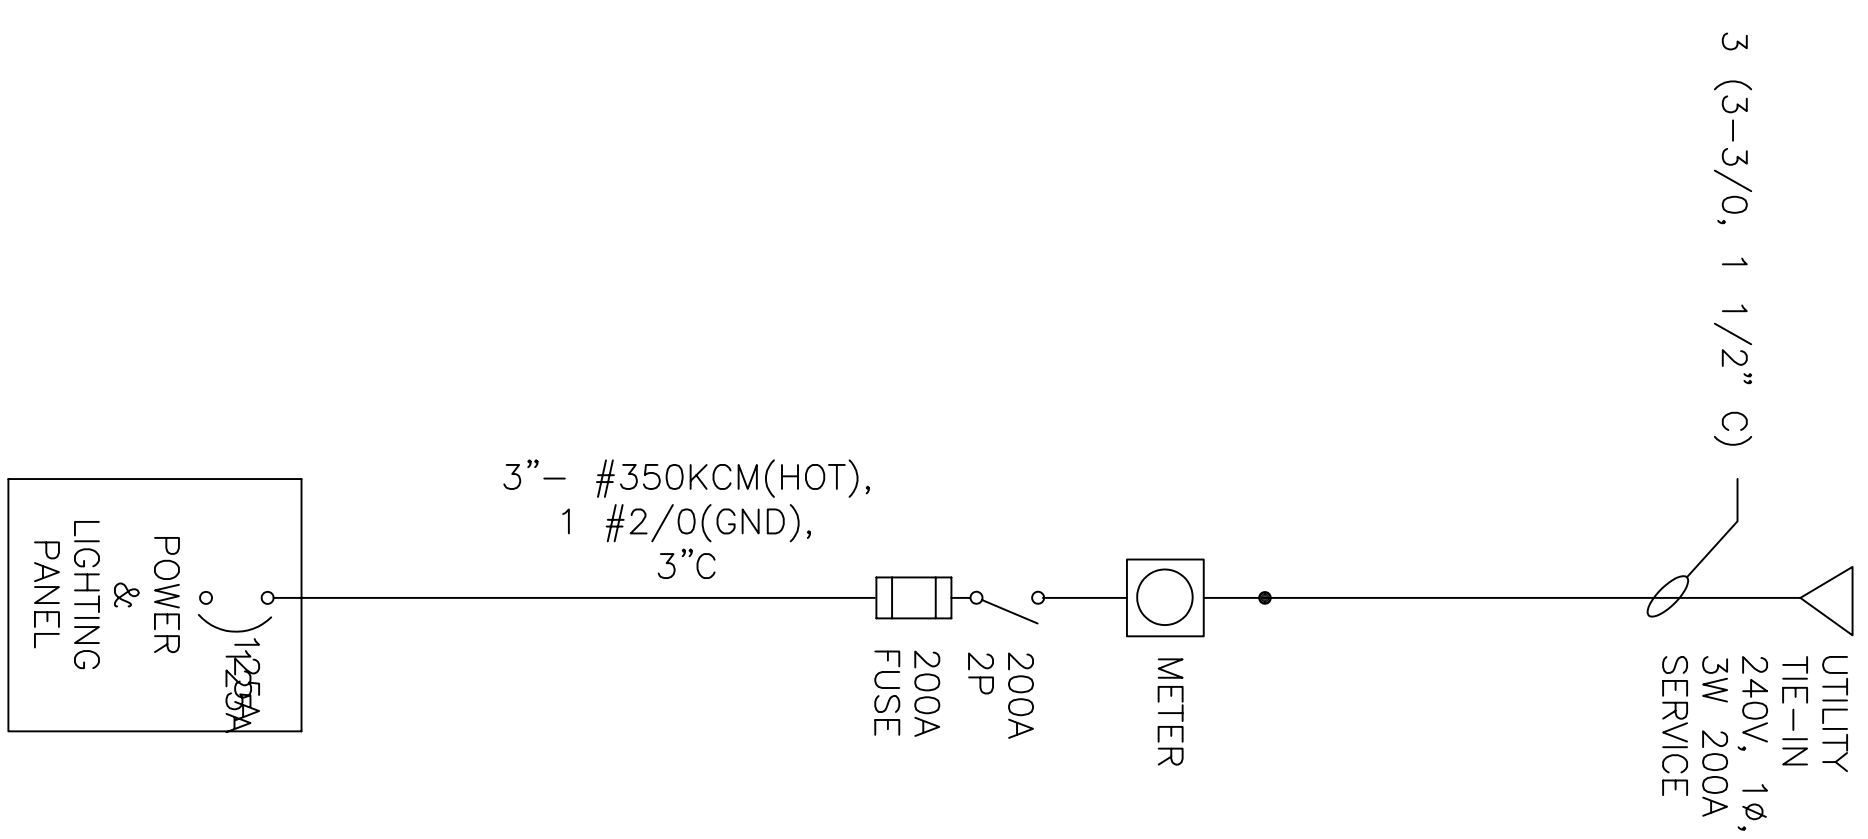

ONE LINE DIAGRAM - LEASING OFFICE

SCALE: NONE

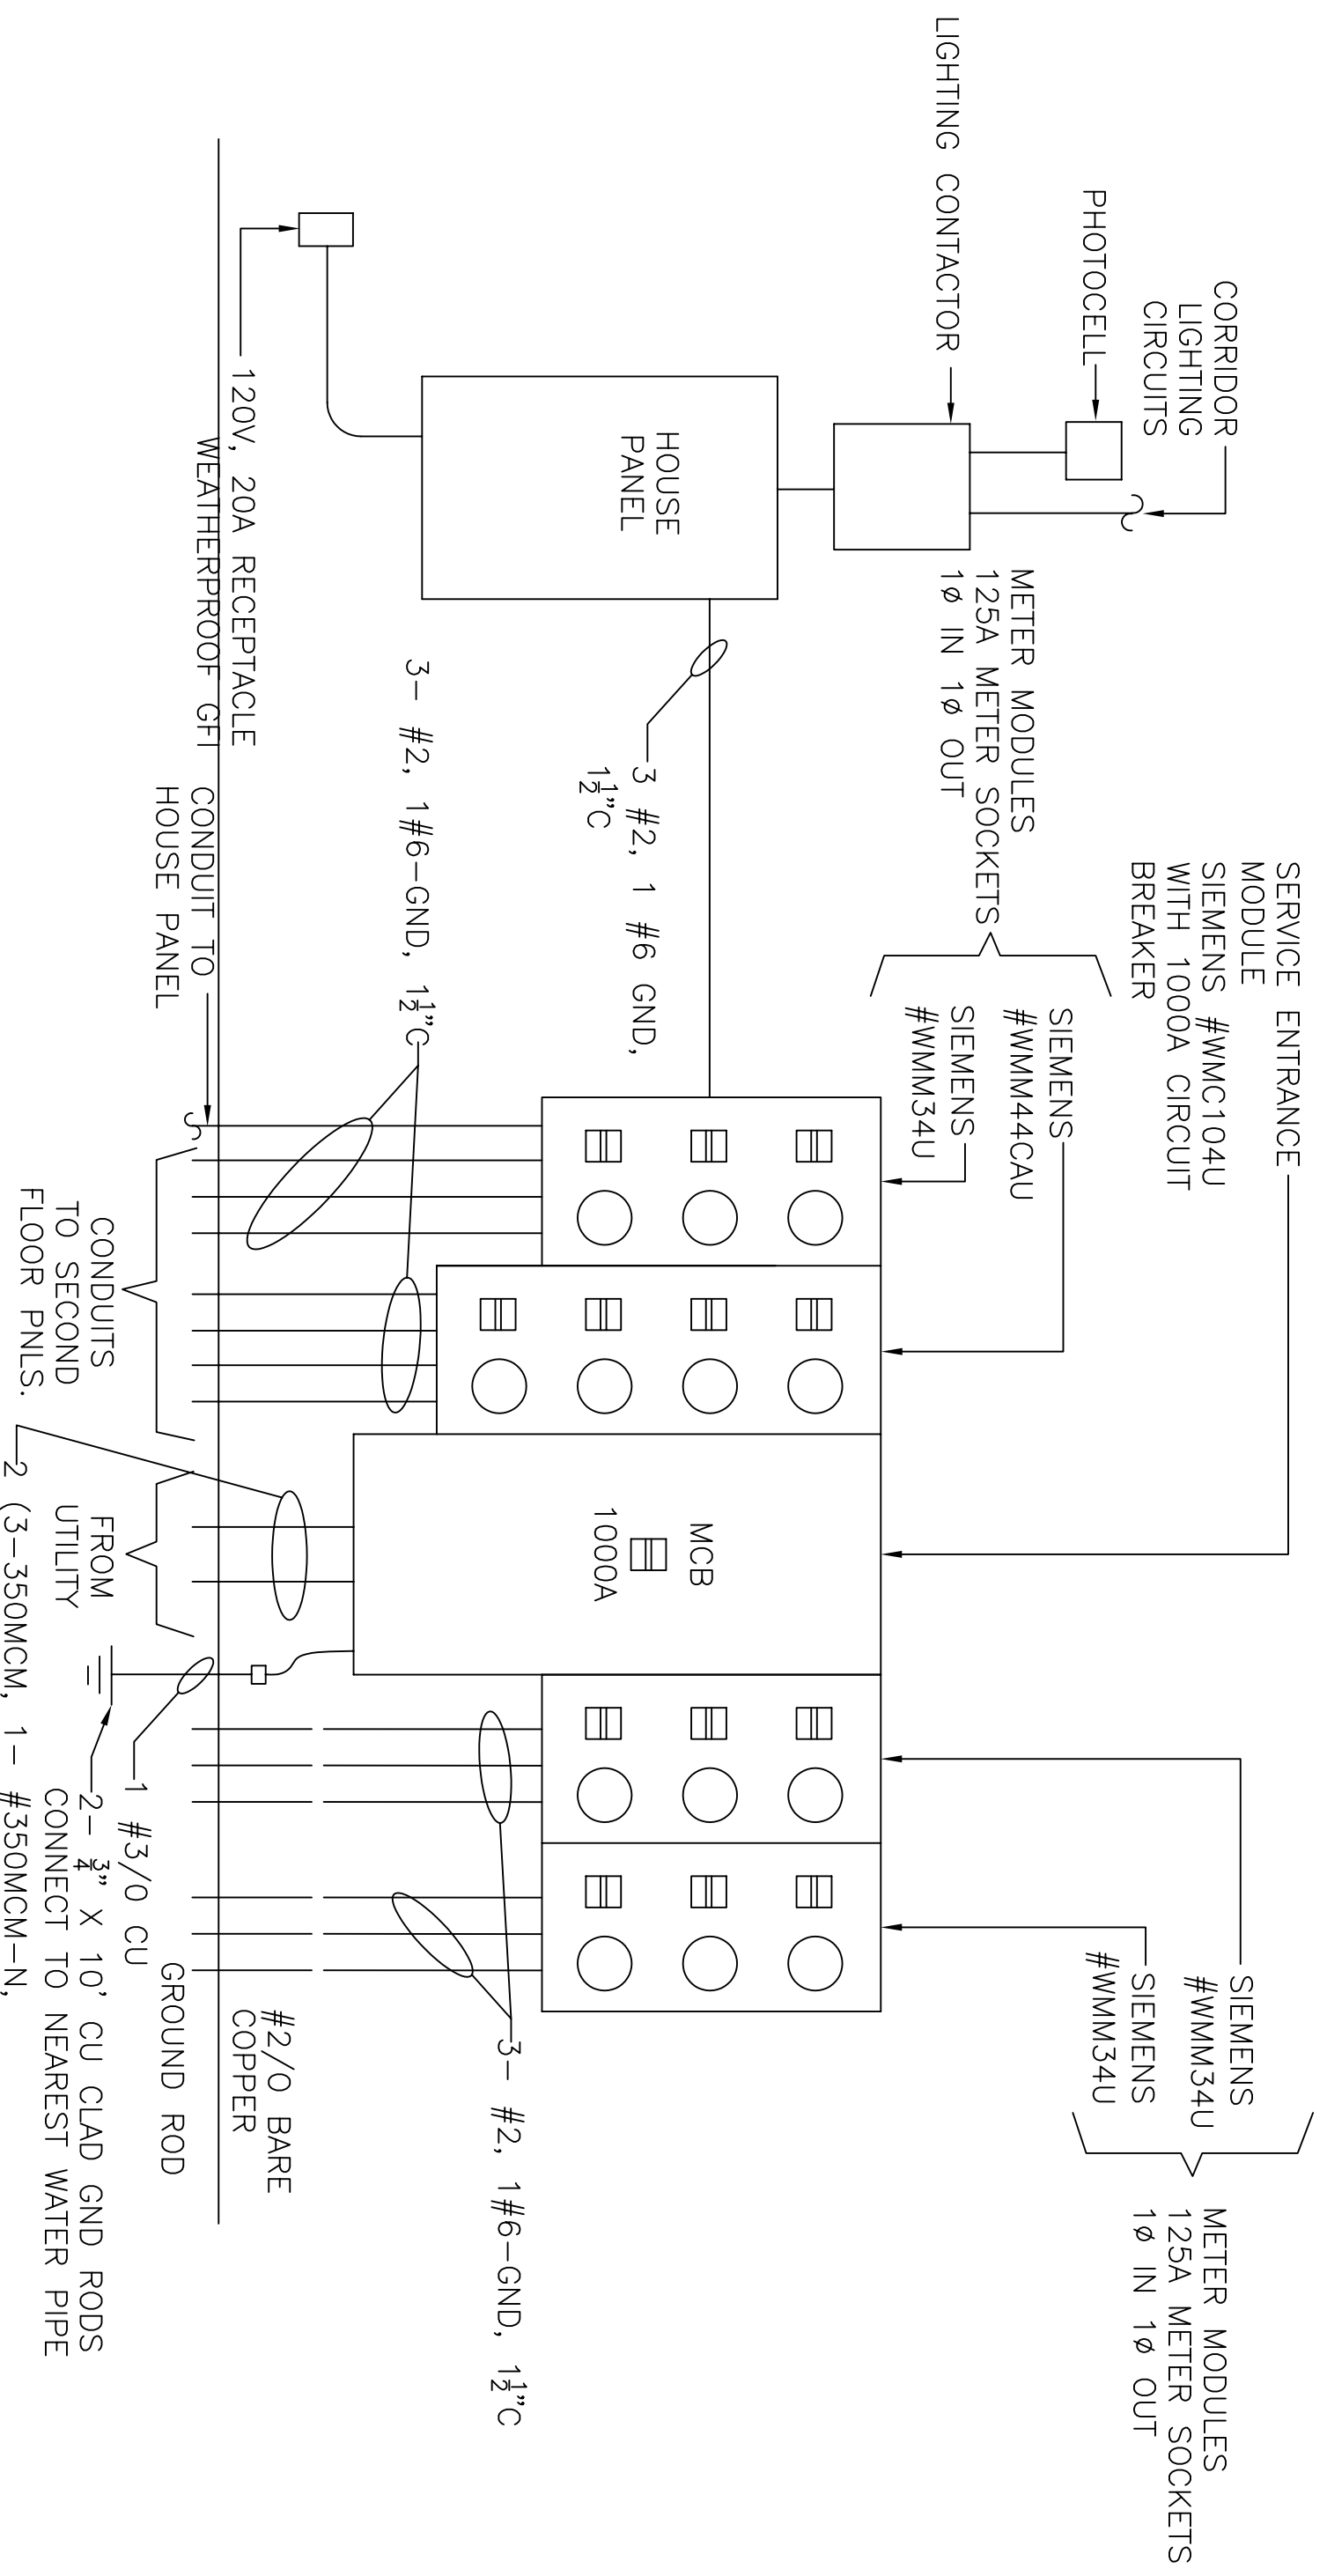

ELEVATION - SERVICE ENTRANCE - TYPICAL APARTMENT

ONE LINE DIAGRAMS

REFLECTIONS OF ISLAND PARK  
APARTMENT COMMUNITY  
SHREVEPORT, LOUISIANA

REFLECTIONS OF ISLAND PARK  
**DAMMON ENGINEERING. INC.**  
1095 FLORIDA AVENUE 985-649-5832 SLIDELL, LA. 70458  
DAMMONENGINEERING.COM

SCALE:AS NOTED

FILE:

JOB NO. 1817

DATE:01-12-07

SHEET

E. 13

OF