
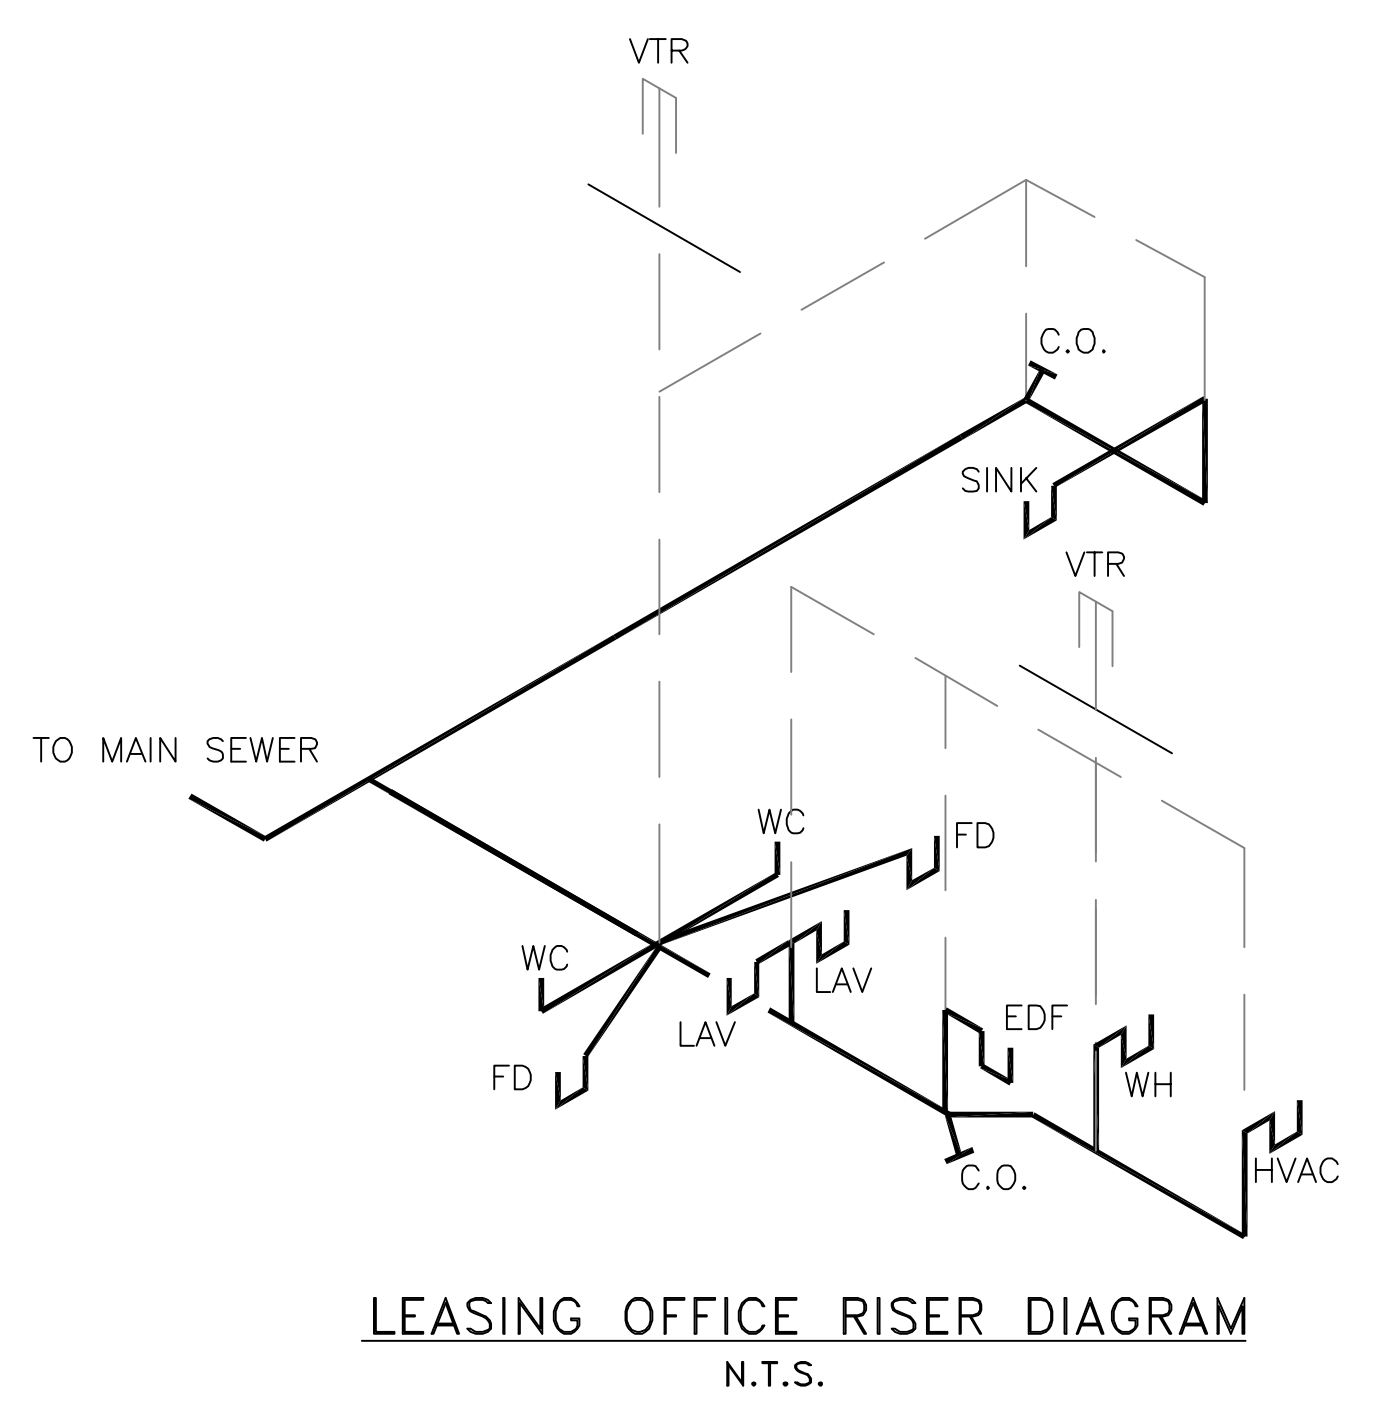


LEGEND
 — s — s — SANITARY SEWER
 - - - - - PLUMBING VENT

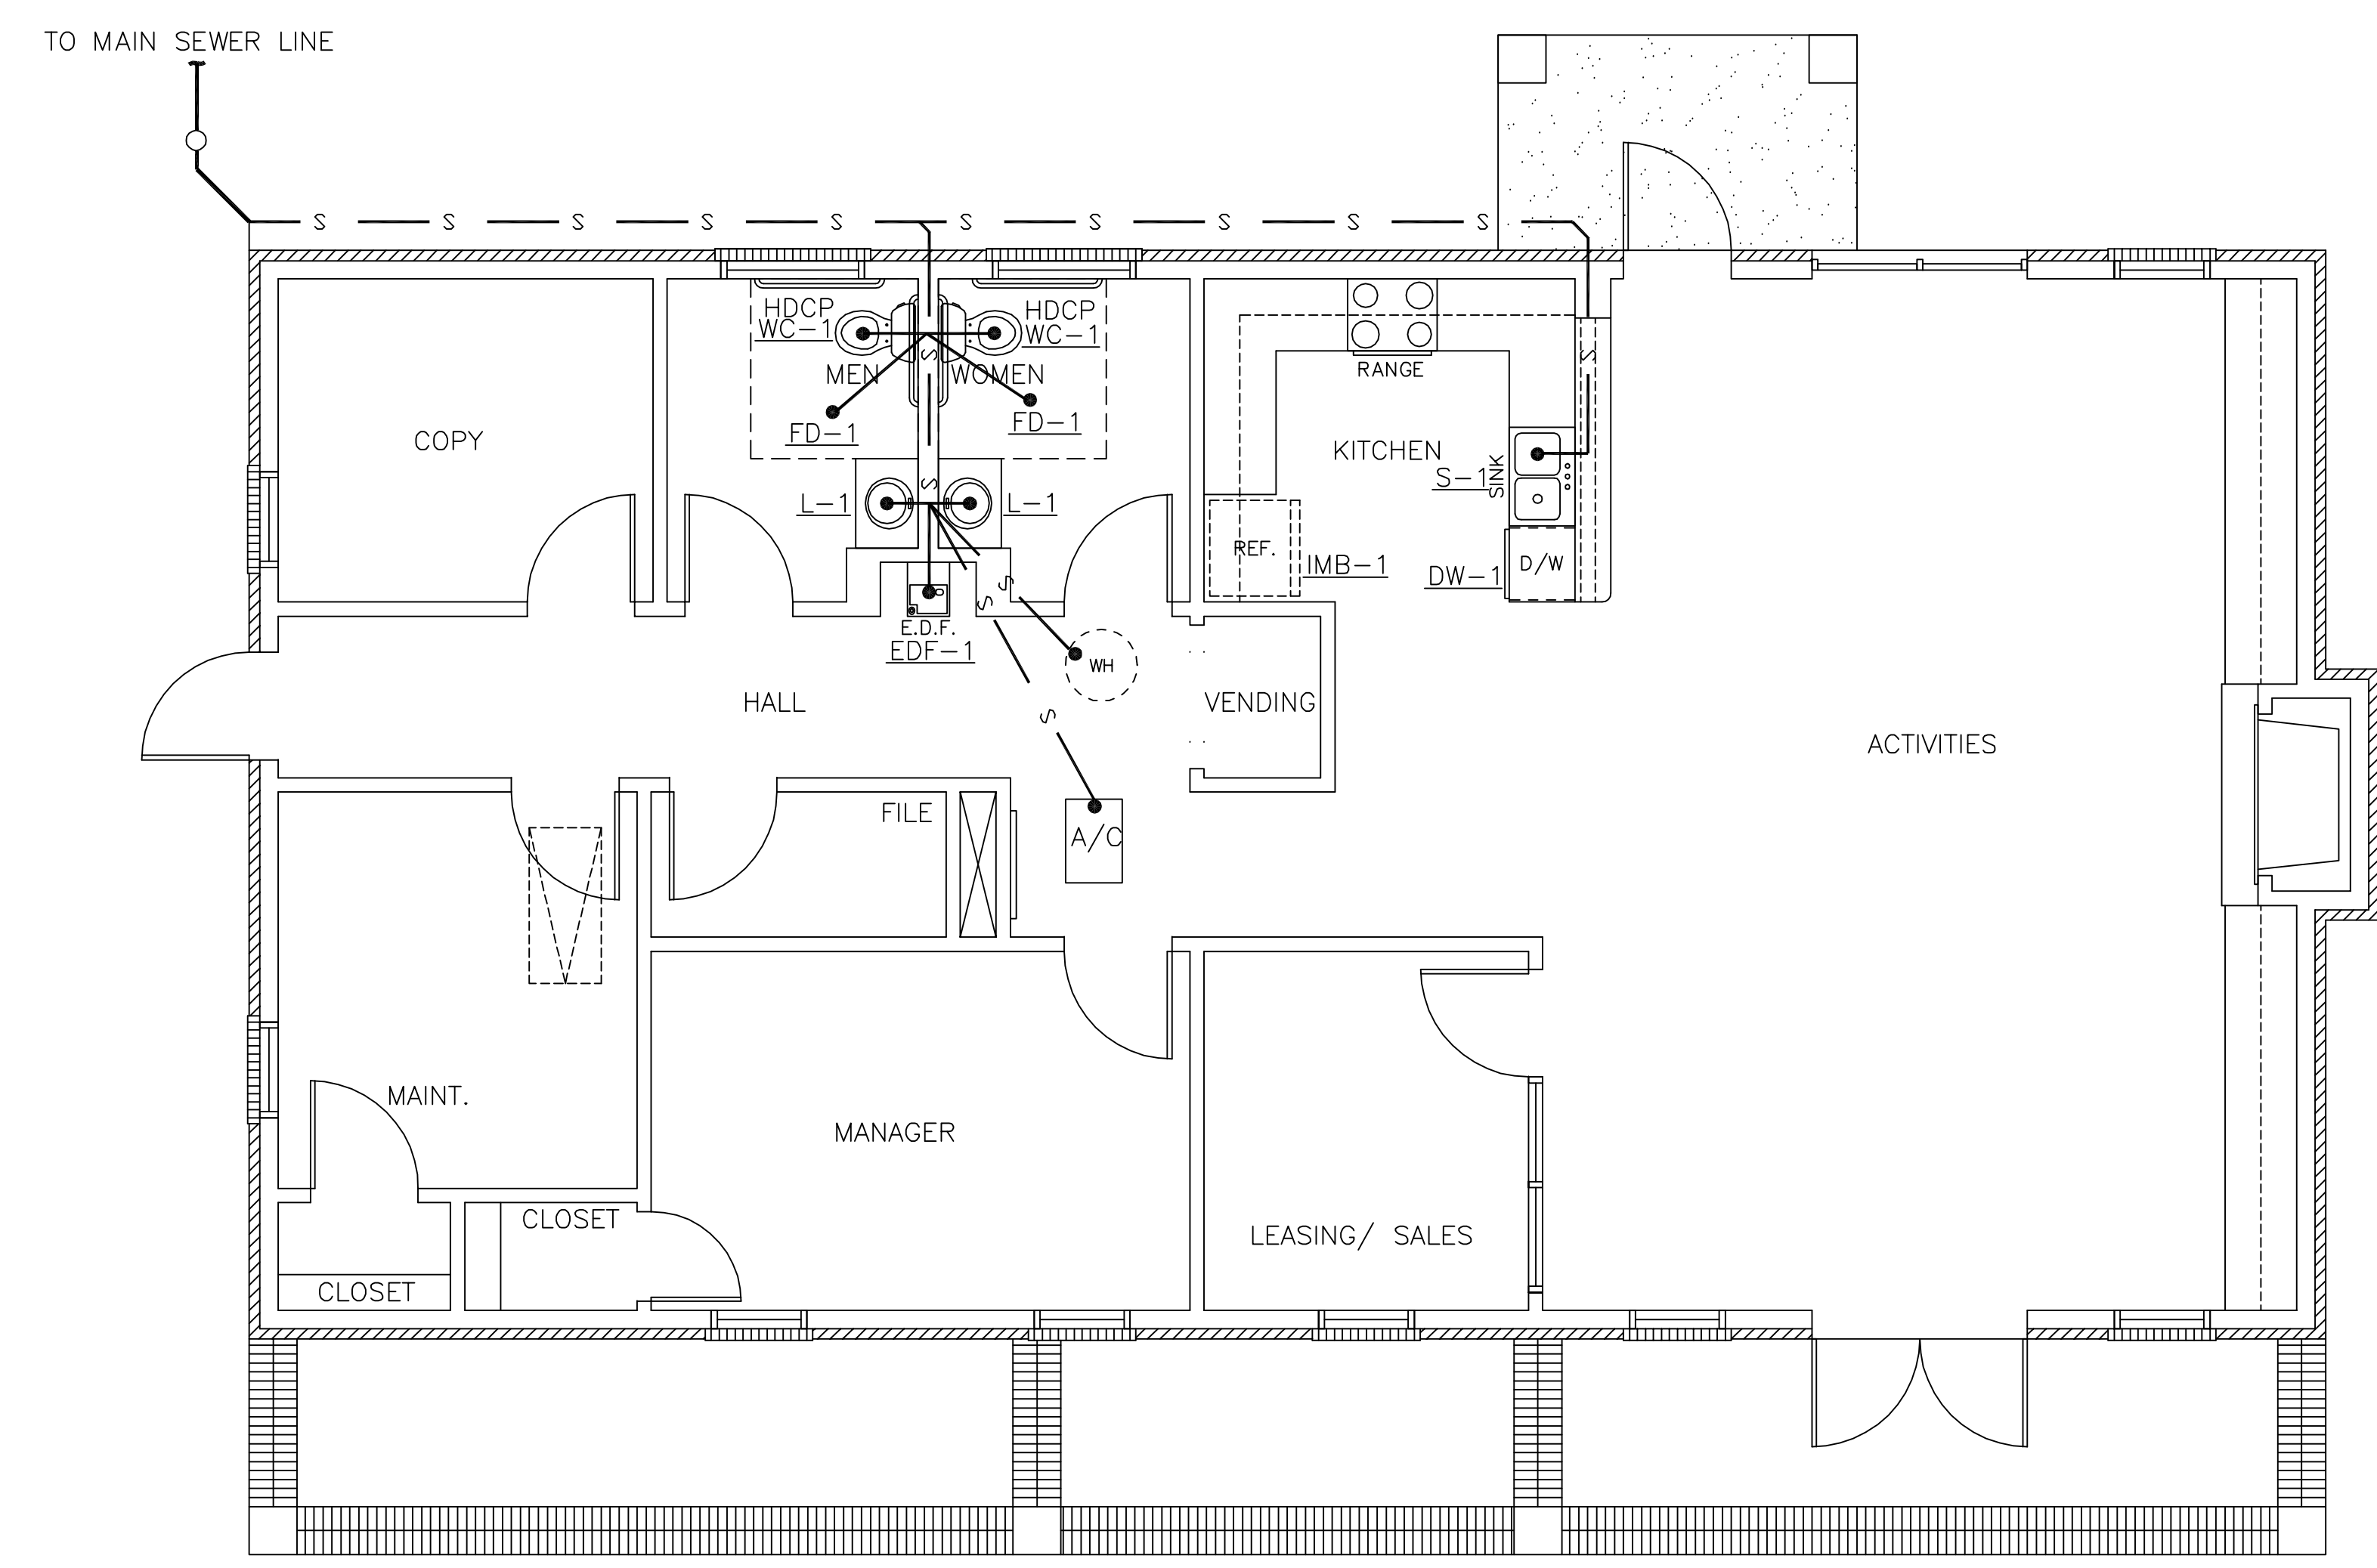


LEASING OFFICE PLUMBING PLAN
 SCALE: 1/4" = 1'-0"

PLUMBING NOTES:

- 1 WASTE AND VENT PIPING TO BE SCHEDULE 40 PVC.
- 2 WATER PIPING TO BE QUESTPEX FLEXIBLE TUBING
- 3 ALL WORK AND MATERIAL SHALL STRICTLY CONFORM TO THE LATEST LOCAL CITY, PARISH, STATE AND NATIONAL GOVERNING CODES.
- 4 ALL PLUMBING SHALL BE CLOSELY COORDINATED WITH STRUCTURAL SYSTEM, MECHANICAL SYSTEM AND ELECTRICAL SYSTEM TO INSURE PROPER COMPLIANCE WITH CODES AND INSURE THAT WORK OF ALL TRADES NOT CONFLICT WITH EACH OTHER.
- 5 ALL SANITARY SEWER PIPING RUN BELOW GROUND SHALL BE RUN AT 1/8" PER FOOT SLOPE UNLESS OTHERWISE NOTED.
- 6 DO NOT SCALE DRAWINGS. SEE ARCHITECTURAL DRAWINGS FOR EXACT LOCATIONS OF DOORS, WINDOWS, WALLS, FIXTURES, ETC.
- 7 ALL SEWER PIPING SHOWN IS BELOW GROUND, UNLESS OTHERWISE NOTED.
- 8 ALL WATER PIPING NOT SHOWN FOR CLARITY, ALL LOCATIONS FIELD VERIFIED.
- 9 ALL WATER MAINS AND FITTINGS ABOVE THE FLOOR SHALL BE INSULATED WITH 1/2" THICK FIBERGLASS INSULATION ON MAINS ONLY. PIPING INSIDE UNITS SHALL NOT BE INSULATED.
- 10 FIRE LOOP & BUILDING FEEDS SIZES TO BE VERIFIED BY SPRINKLER CONTRACTOR.
- 11 ALL WATER HEATER INSIDE UNITS LOCATED IN CLOSET ON SHELF PROVIDED BY OTHERS

PLUMBING FIXTURE SCHEDULE						
MARK	DESCRIPTION	ROUGH-IN-SIZES				REMARKS
		CW	H.W.	WASTE	VENT	
WC-1	WATER CLOSET, FLR. MTD. TANK TYPE	1/2"	-	4"	4"	
L-1	COUNTER MOUNTED LAVATORY	1/2"	1/2"	2"	2"	
BT-1	TUB/ SHOWER/ SURROUND	1/2"	1/2"	2"	2"	W/ PRESSURE BALANCING VALVE.
S-1	KITCHEN SINK - 2 COMPARTMENT	1/2"	1/2"	2"	2"	PROVIDE PIPING TO DISHWASHER.
WMB-1	WASHING MACHINE BOX	1/2"	1/2"	2"	2"	
IMB-1	ICE MAKER BOX	1/2"	-	-	-	
HB-1	HOSE BIB	3/4"	-	-	-	W/ VACUUM BREAKER.
DF-1	DRINKING FOUNTAIN	1/2"	-	2"	2"	WALL MOUNTED
VTR	VENT THRU ROOF	-	-	-	4"	
FD-1	FLOOR DRAIN	-	-	2"	2"	INSTALL CONTINUOUS DRIP ON ALL FLOOR DRAINS.


PLUMBING FIXTURE MODEL NUMBERS		
DESCRIPTION	MAKE	MODEL #
TOILET SEAT	CHURCH	400
SAVOY 1.6 GALLON TOILET	ELJER	091-0120
HDCP 17" 1.6 GALLON TOILET	ELJER	091-1175
WATER HEATER	RUUD	LOW BODY PES40-2
LARGE WASHER BOX	WATER-TITE	85710
COUNTERTOP LAVATORY	AMERICAN STANDARD	3003.605
LAVATORY FAUCETS	AMERICAN CRAFT	9612-TP
STAINLESS STEEL DOUBLE BOWL SINK	STERLING	PRO 3322-6-4
KITCHEN FAUCETS	DELTA	2102
5' TUB/SHOWER	STERLING	OC-AP-TS
SHOWER VALVE	MIXET MASTER	993 ST DLX
DUAL TEST BATHWASTE	LSP	TS-8,CHROME / PVC,LIFT&TURN 1 HOLE
TILE WALL SURROUND SYSTEM	STERLING	V-OV-6042-HG

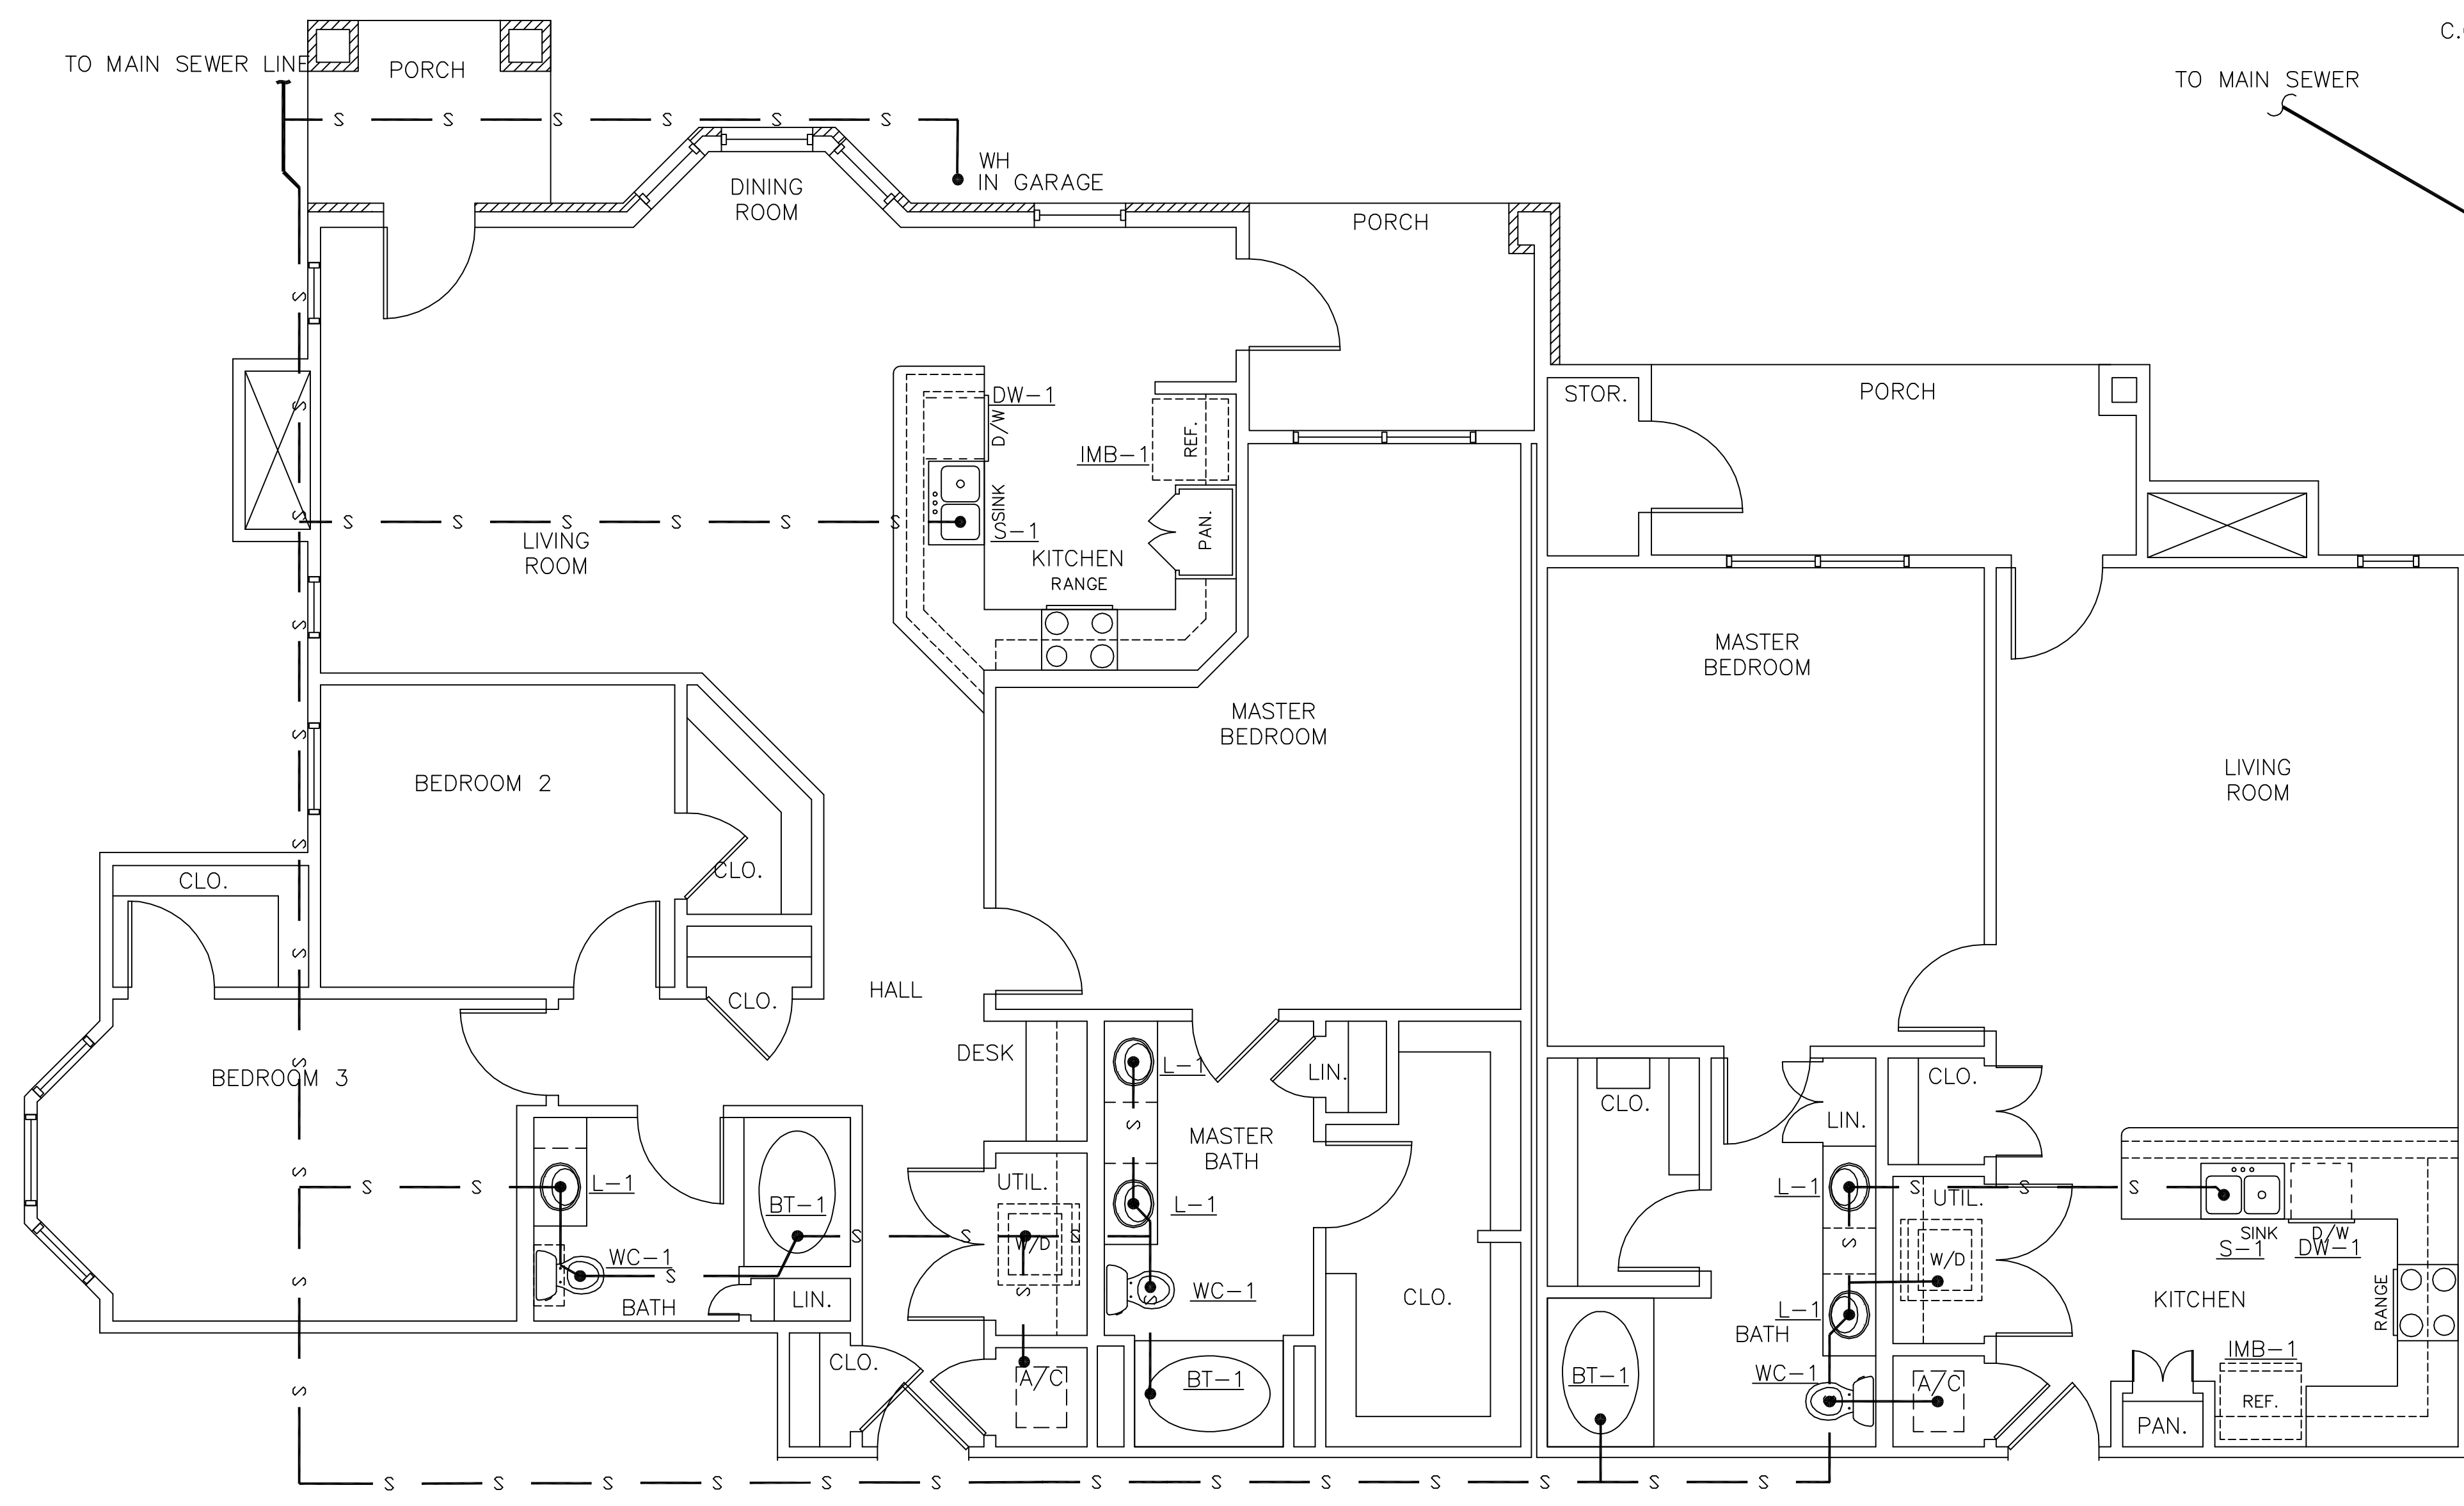

UNIT 'A'

UNIT 'B'

UNITS A & B PLUMBING PLAN
SCALE: 1/4" = 1'-0"

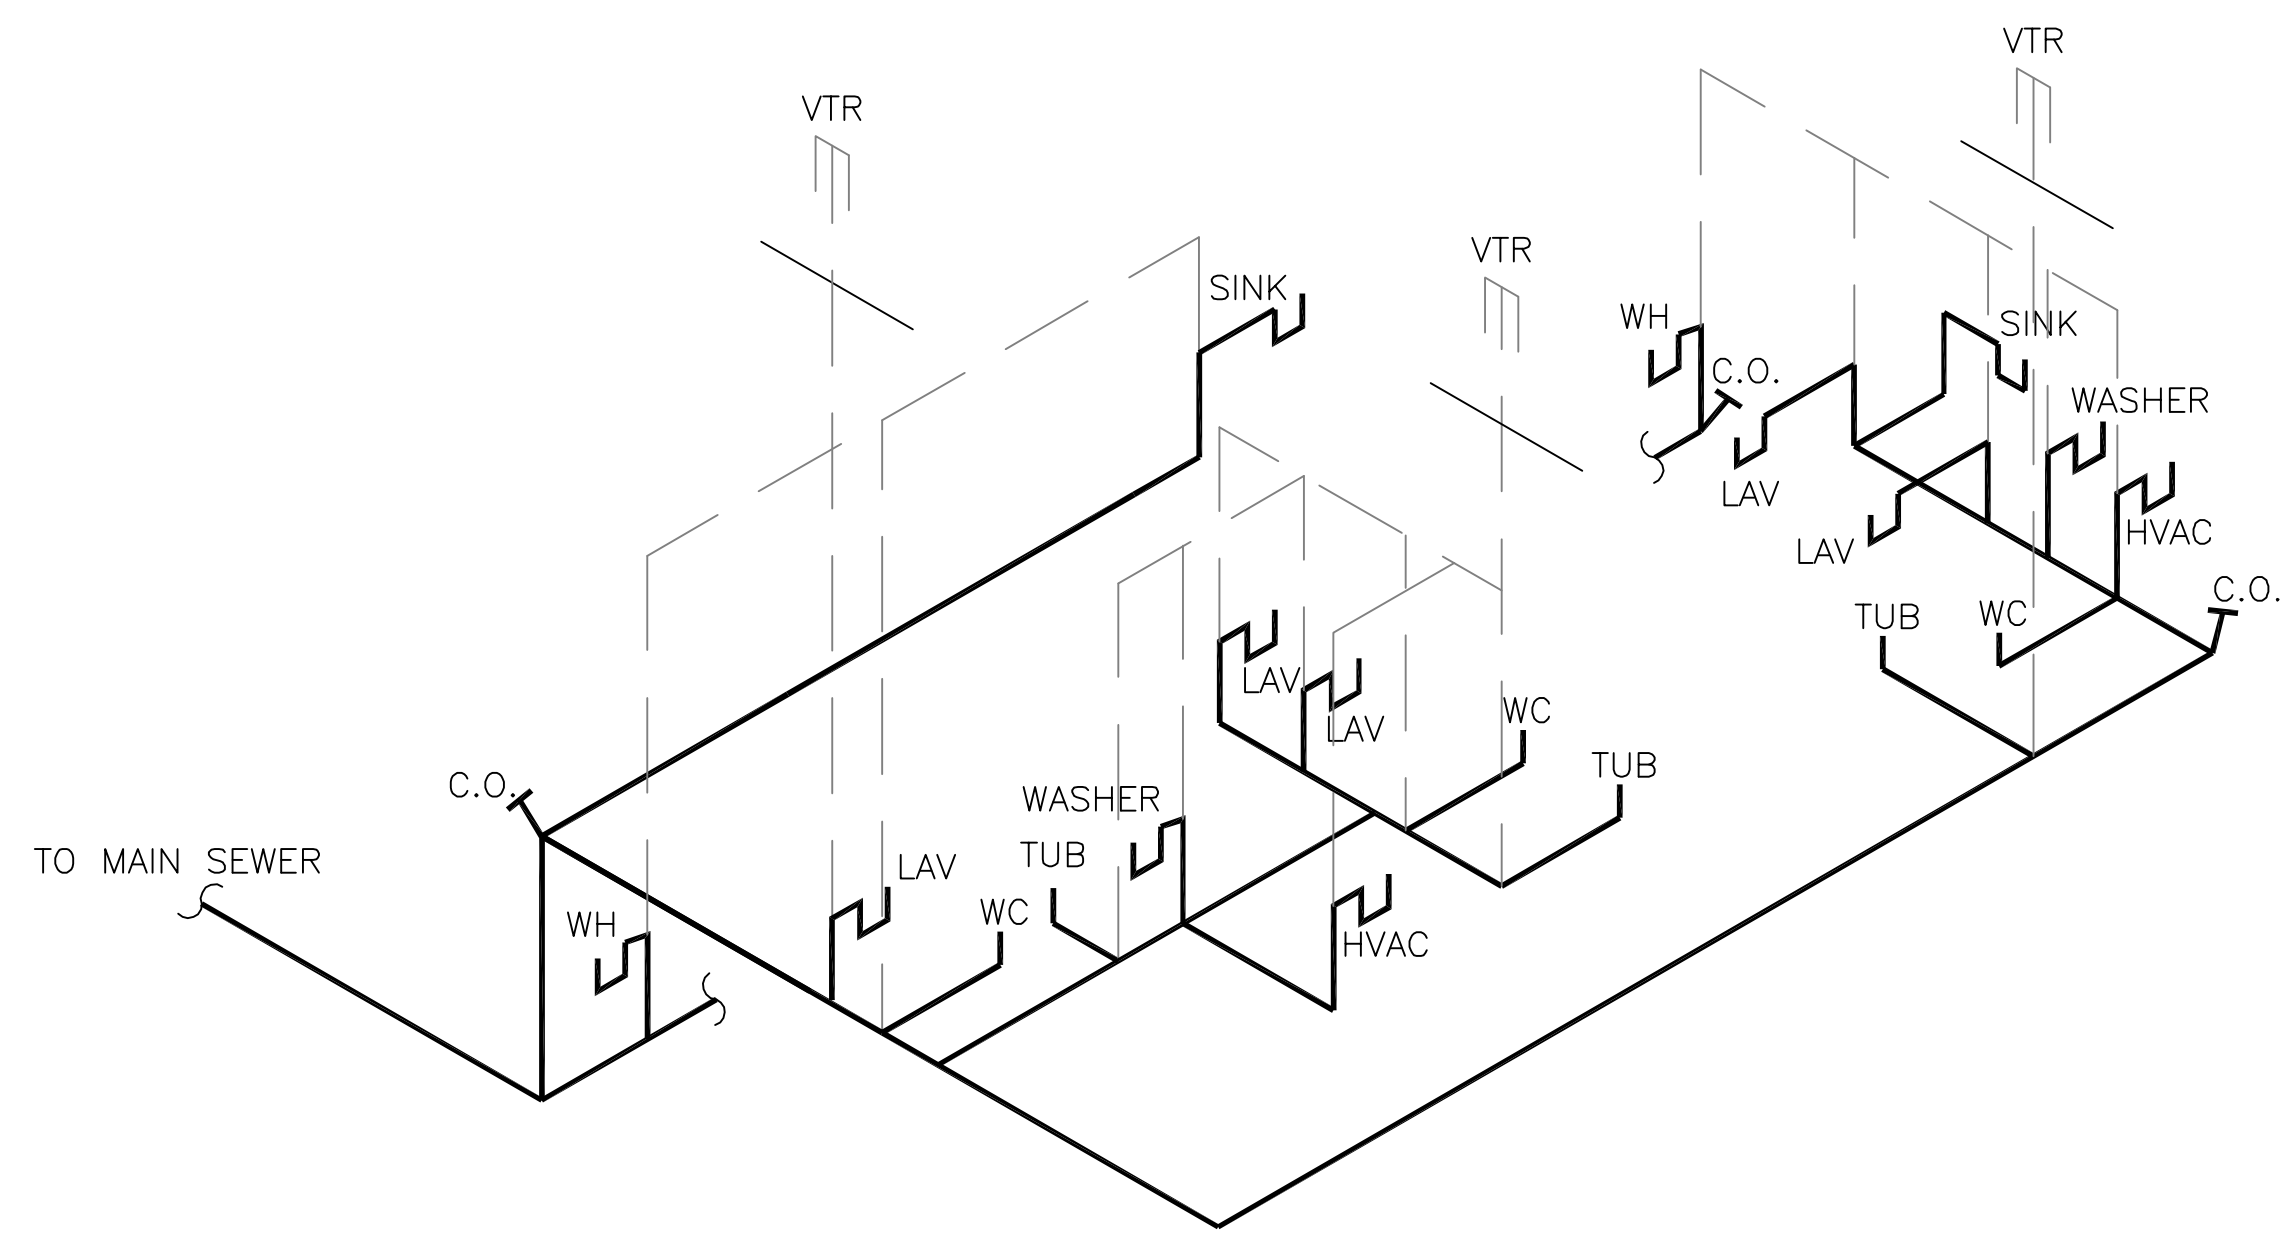

RISER DIAGRAM
N.T.S.

LEGEND
 — s — s — SANITARY SEWER
 - - - - - PLUMBING VENT

UNITS A & B PLUMBING PLAN
 REFLECTIONS OF ISLAND PARK
 APARTMENT COMMUNITY
 SHREVEPORT, LOUISIANA

REFLECTIONS OF ISLAND PARK
DAMMON ENGINEERING, INC.
 1095 FLORIDA AVENUE 985-649-5832 SLIDELL, LA. 70458
 DAMMONENGINEERING.COM

SCALE: AS NOTED

FILE:


JOB NO. 1817

DATE: 01-12-07

SHEET

P-2


OF

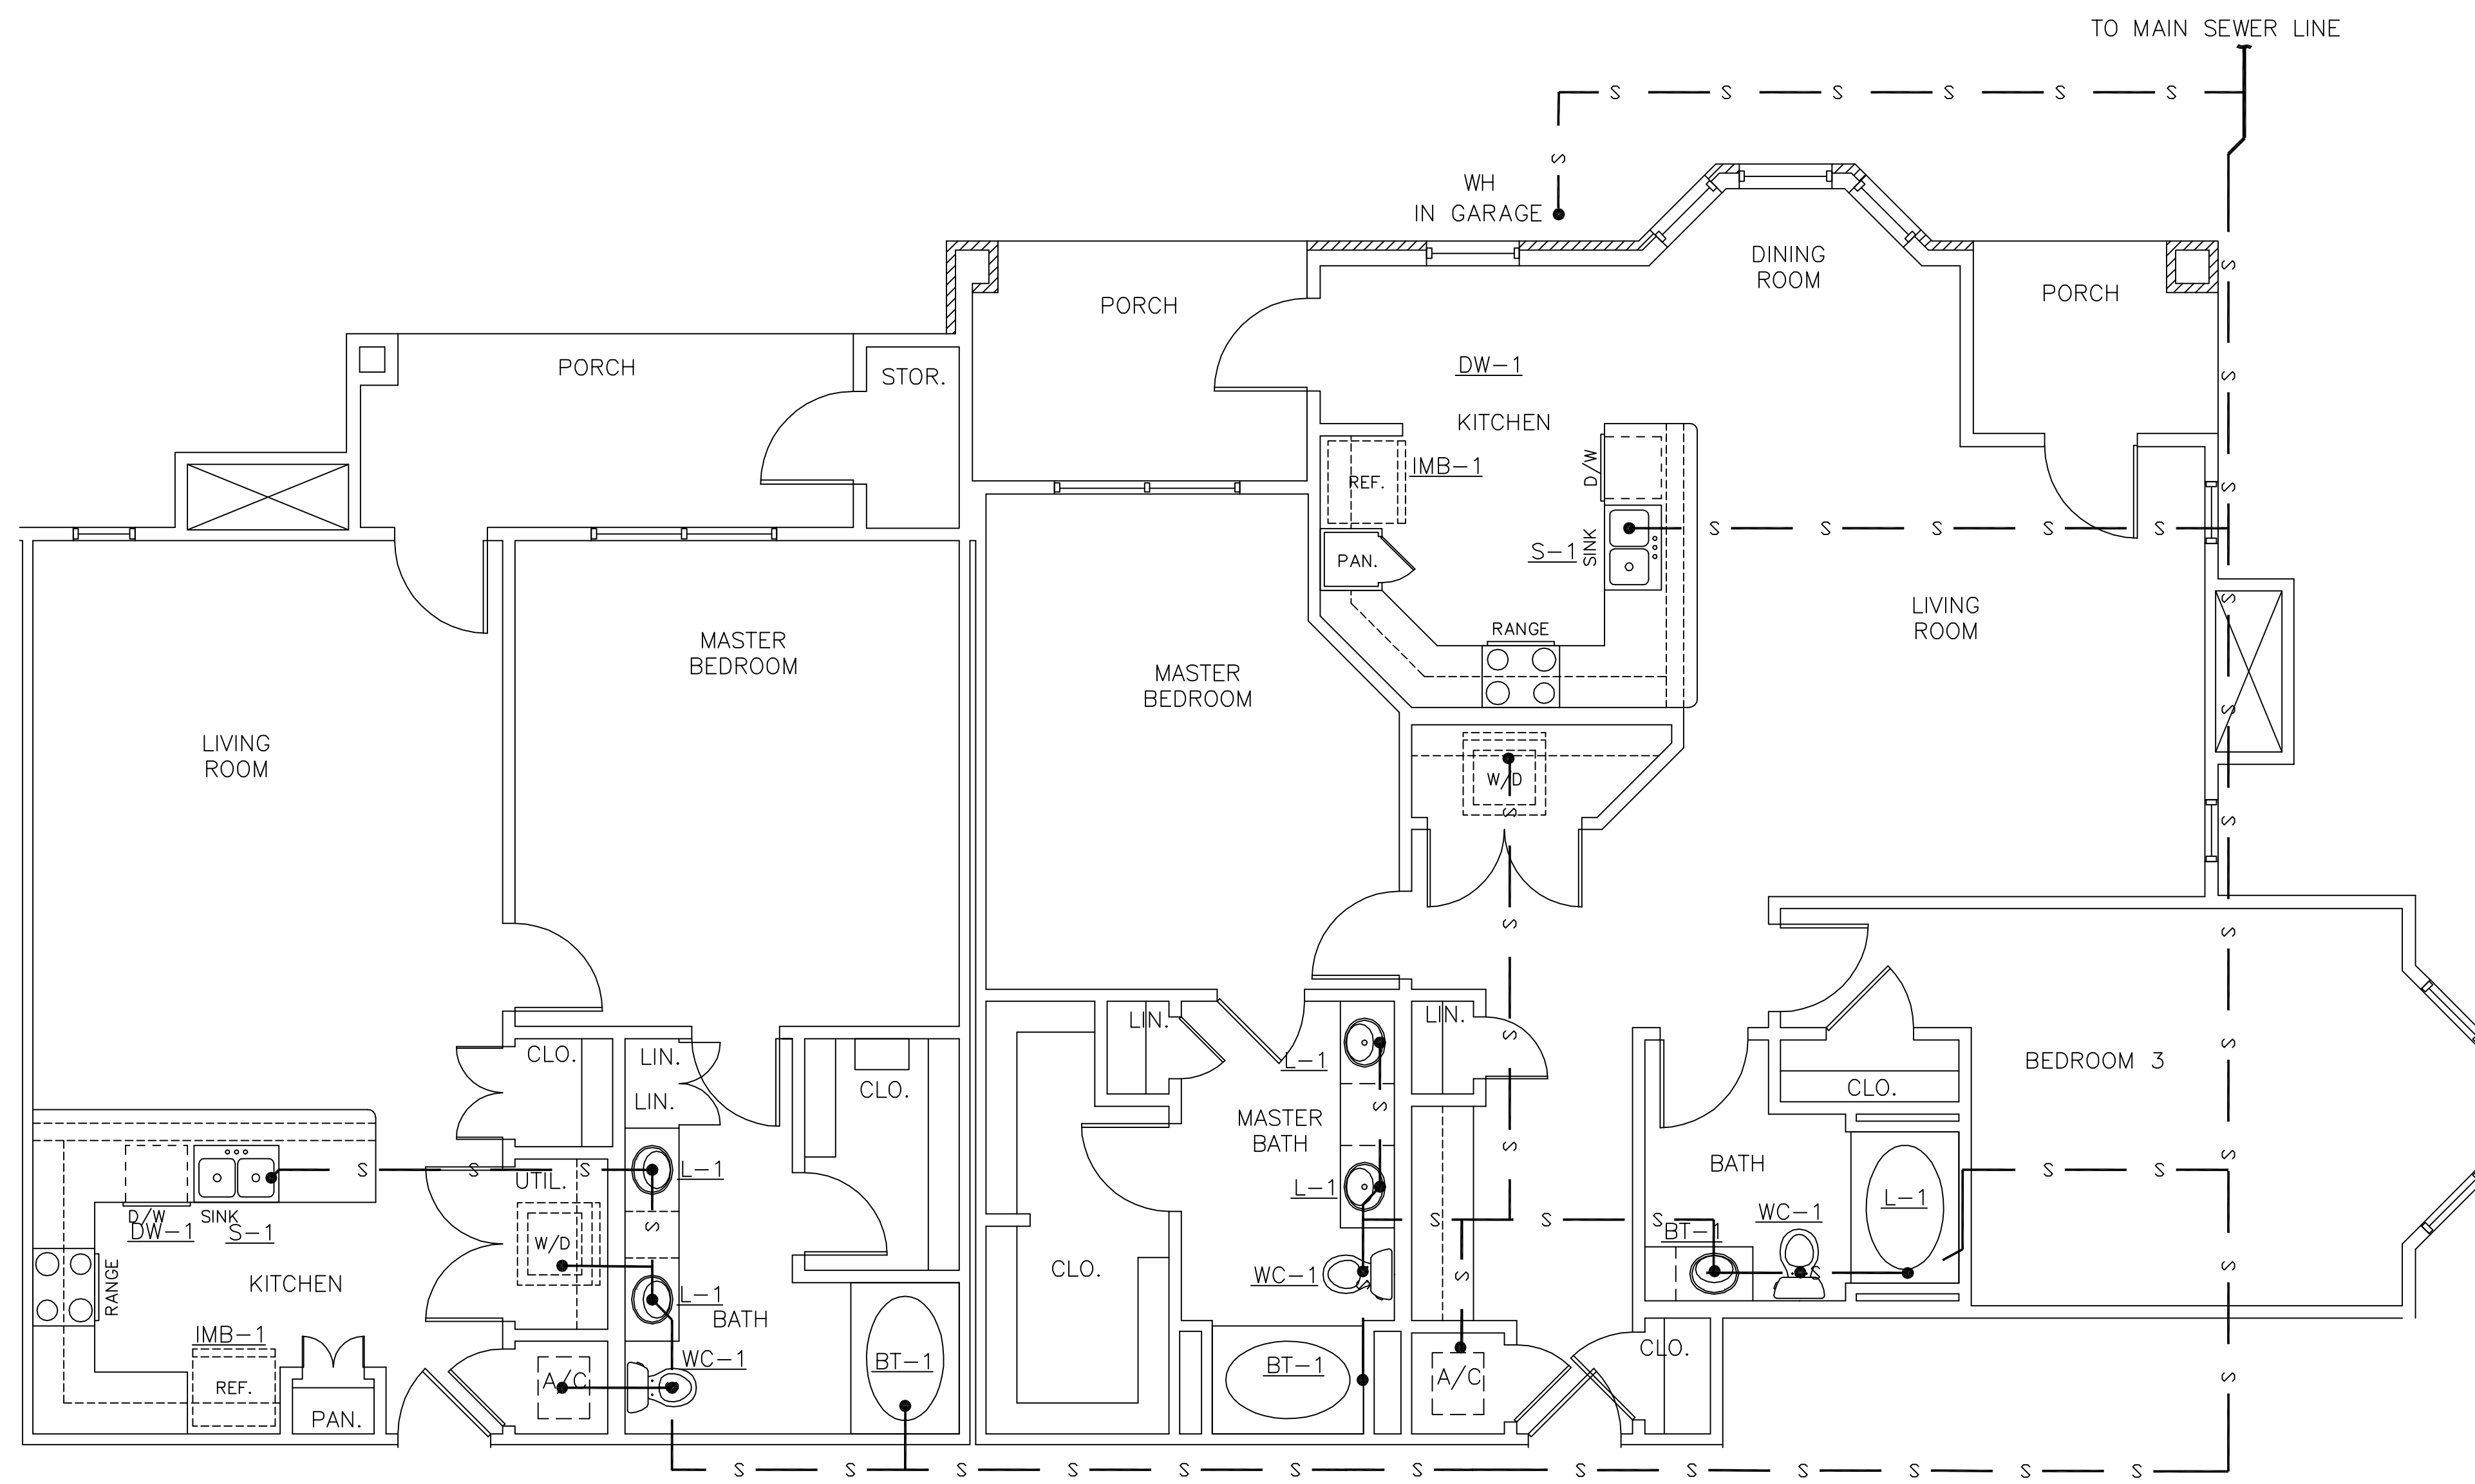

UNIT 'C'

UNIT 'D'

UNITS C & D PLUMBING PLAN
SCALE: 1/4" = 1'-0"

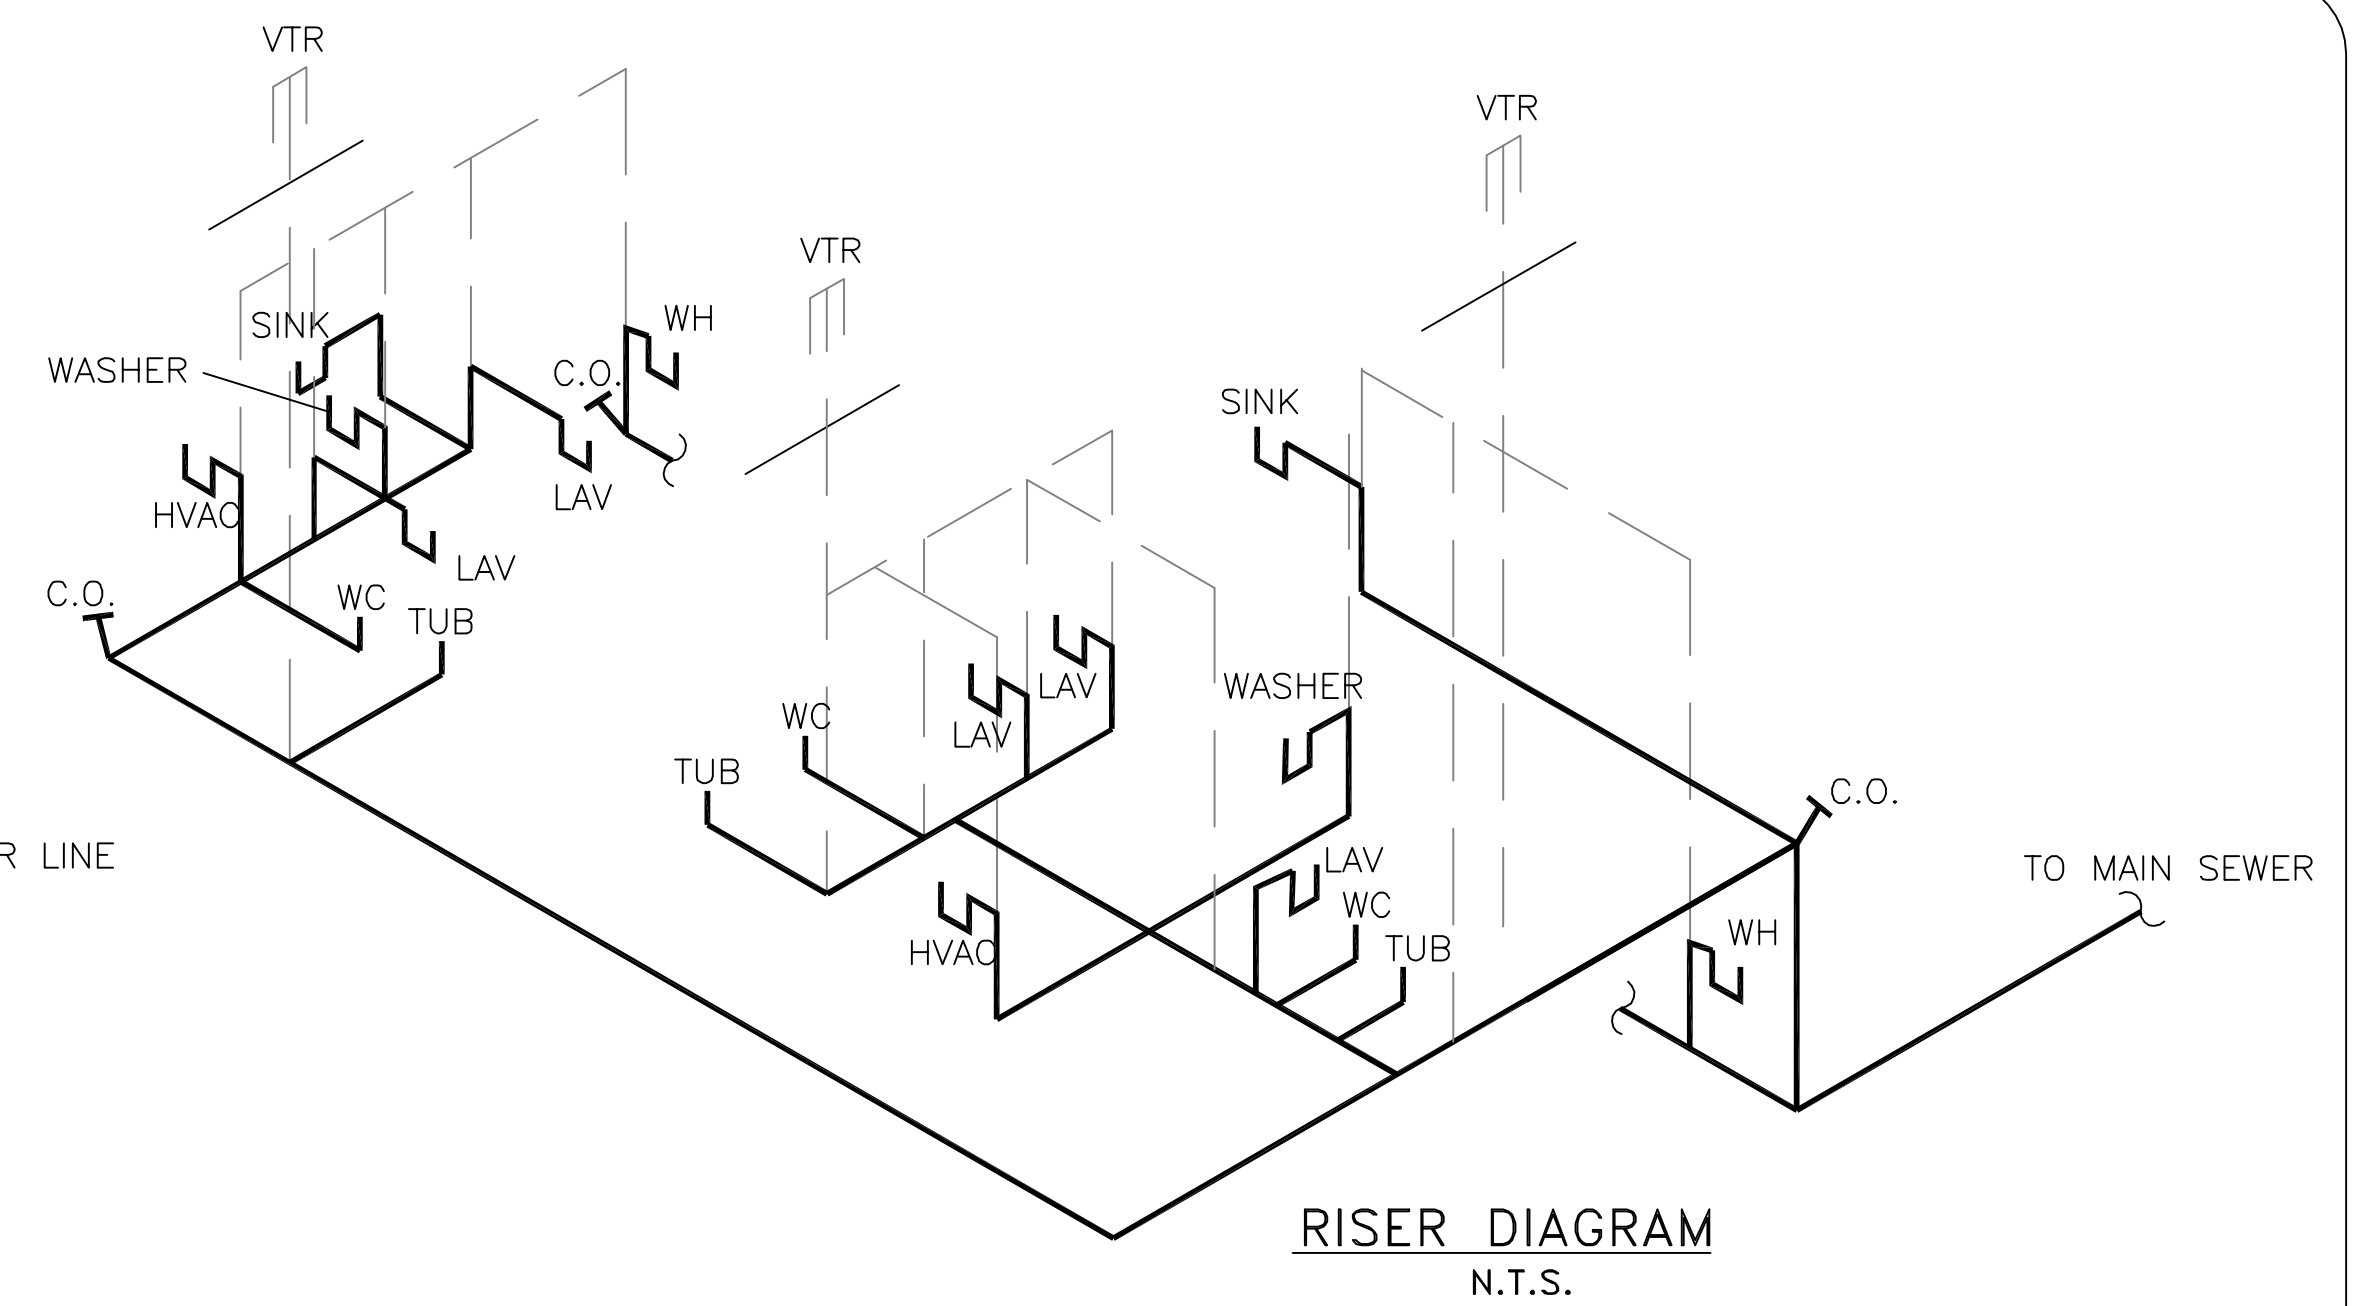

LEGEND
 — s — s — SANITARY SEWER
 - - - - - PLUMBING VENT

UNITS C & D PLUMBING PLAN
 REFLECTIONS OF ISLAND PARK
 APARTMENT COMMUNITY
 SHREVEPORT, LOUISIANA

REFLECTIONS OF ISLAND PARK
DAMMON ENGINEERING, INC.
 1095 FLORIDA AVENUE 985-649-5832 SLIDELL, LA. 70458
 DAMMONENGINEERING.COM

SCALE: AS NOTED

FILE:


JOB NO. 1817

DATE: 01-12-07

SHEET

P - 3

OF

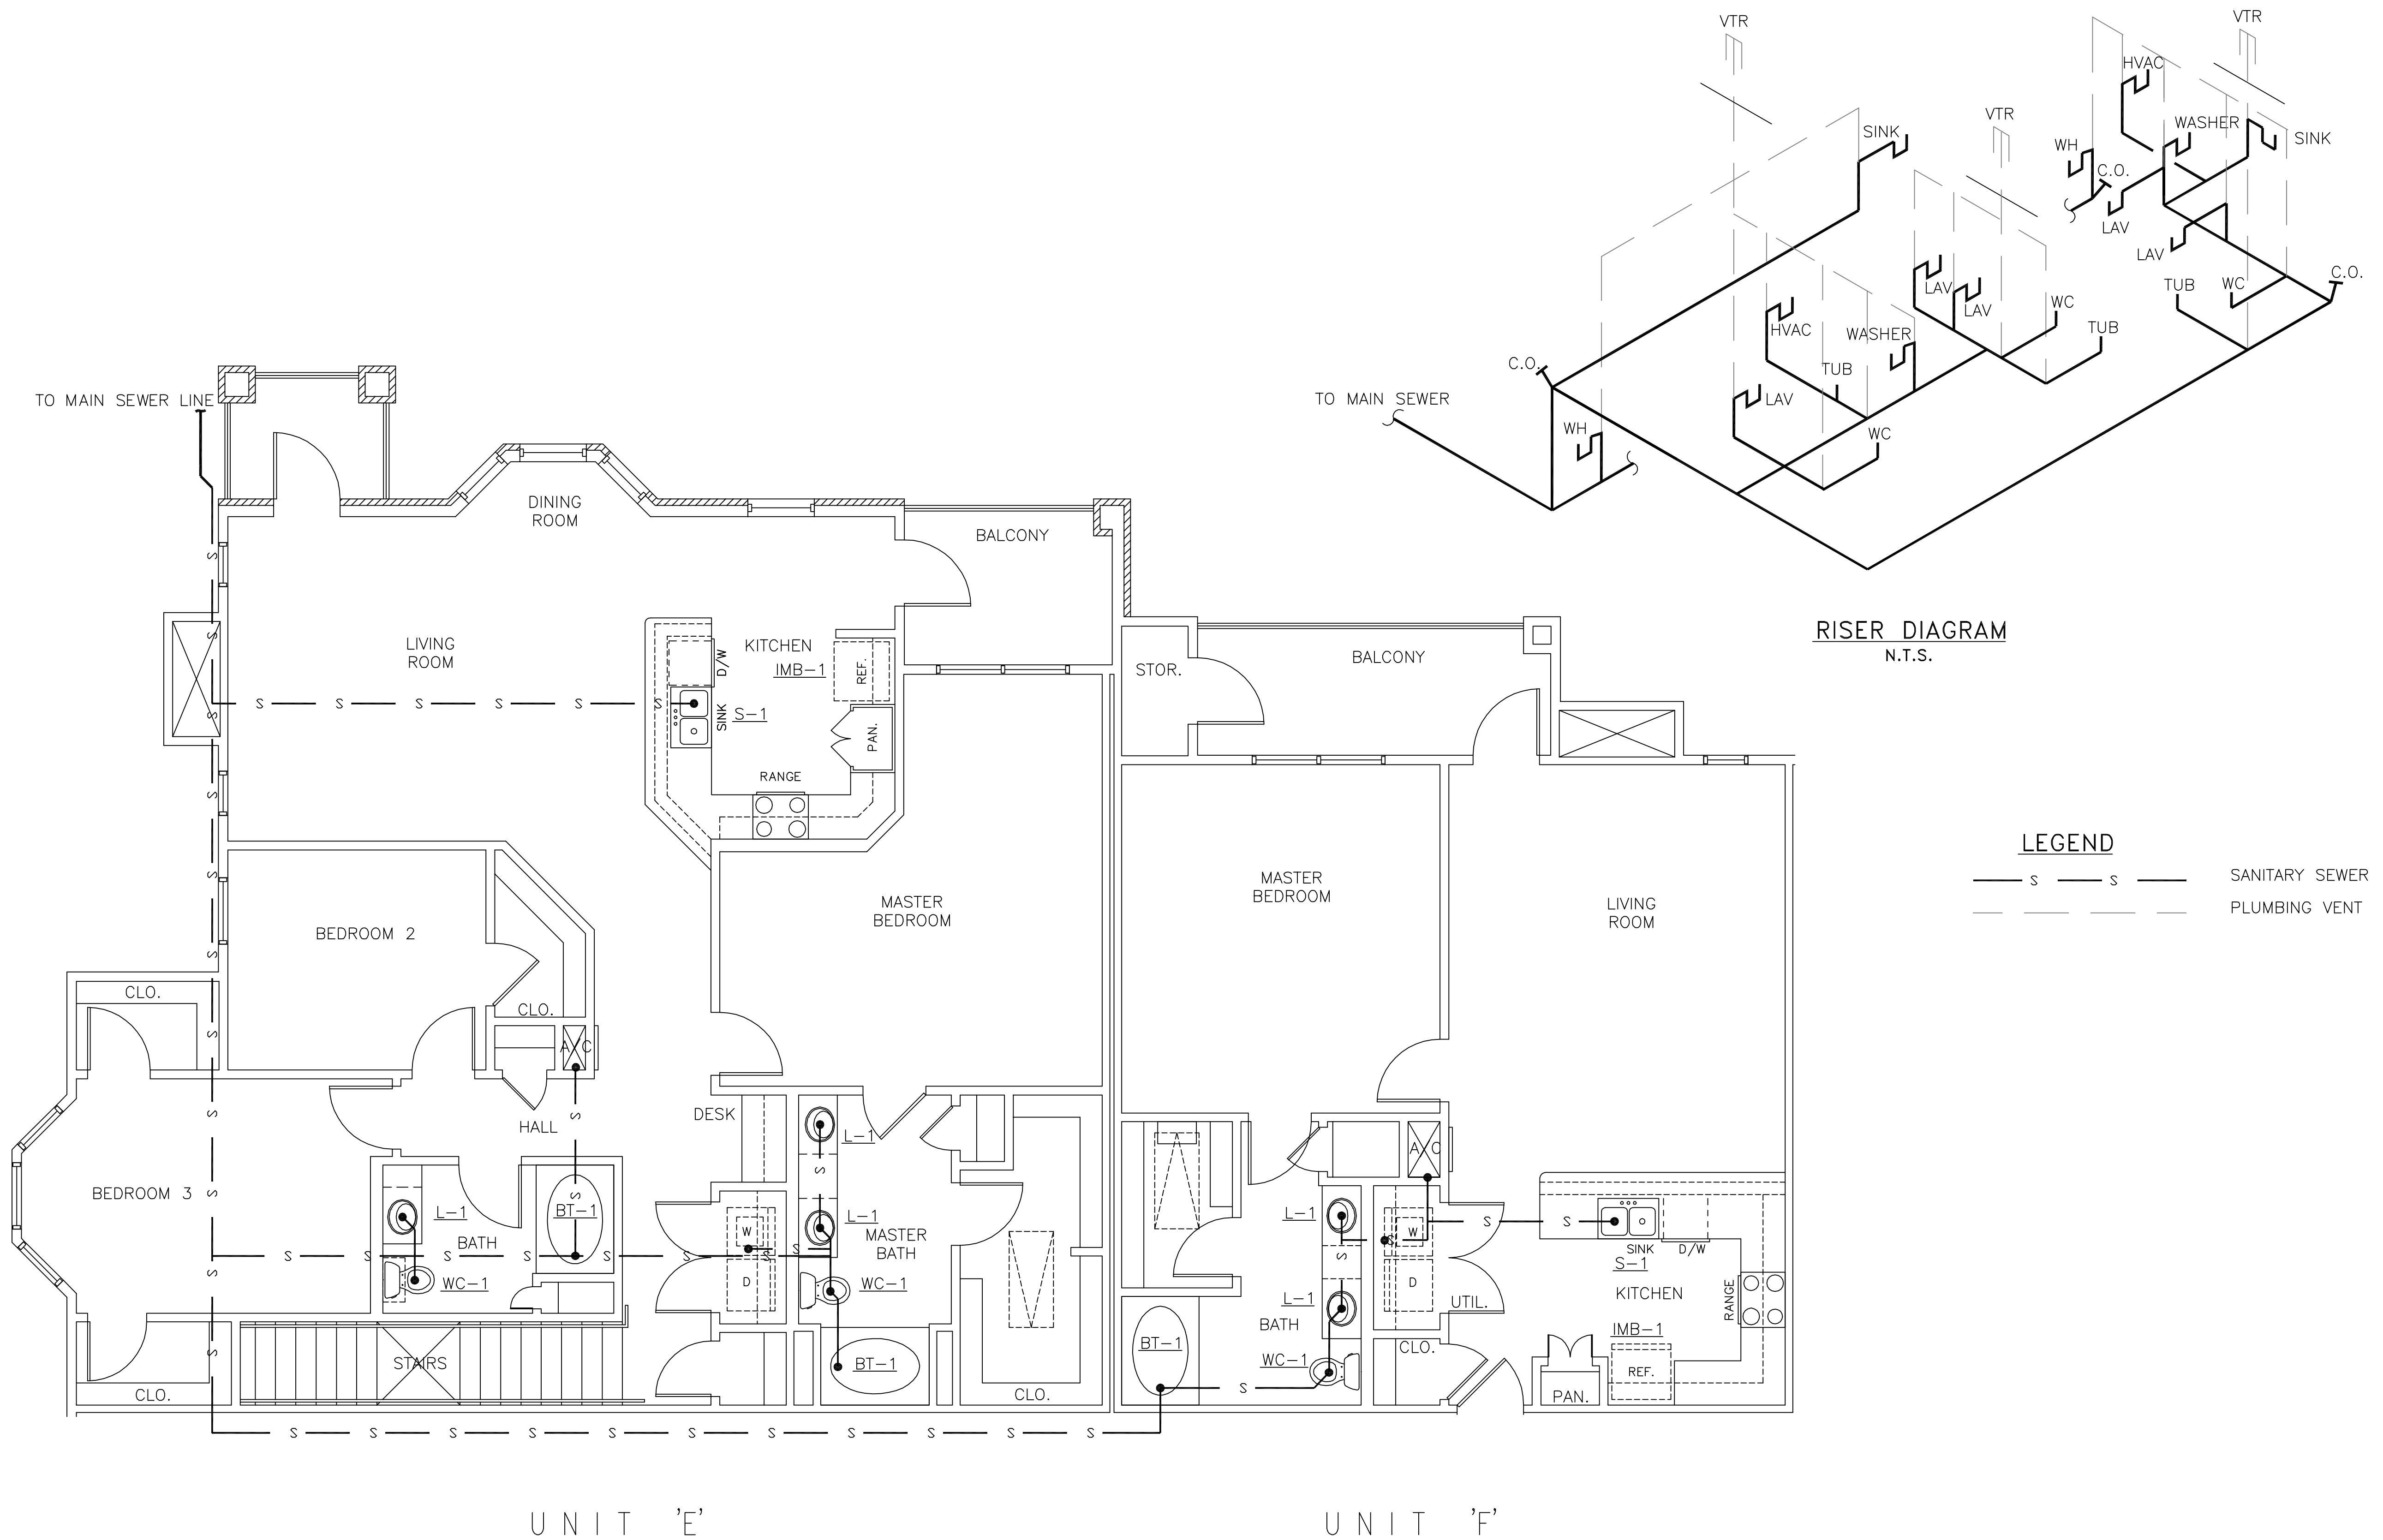

UNIT 'E'

UNIT 'F'

UNITS E & F PLUMBING PLAN
SCALE: 1/4" = 1'-0"

RISER DIAGRAM
N.T.S.

LEGEND
 — s — s — SANITARY SEWER
 - - - - - PLUMBING VENT

UNITS E & F PLUMBING PLAN
 REFLECTIONS OF ISLAND PARK
 APARTMENT COMMUNITY
 SHREVEPORT, LOUISIANA

REFLECTIONS OF ISLAND PARK
DAMMON ENGINEERING, INC.
 1095 FLORIDA AVENUE 985-649-5832 SLIDELL, LA. 70458
 DAMMONENGINEERING.COM

SCALE: AS NOTED

FILE:


JOB NO. 1817

DATE: 01-12-07

SHEET

P - 4

OF

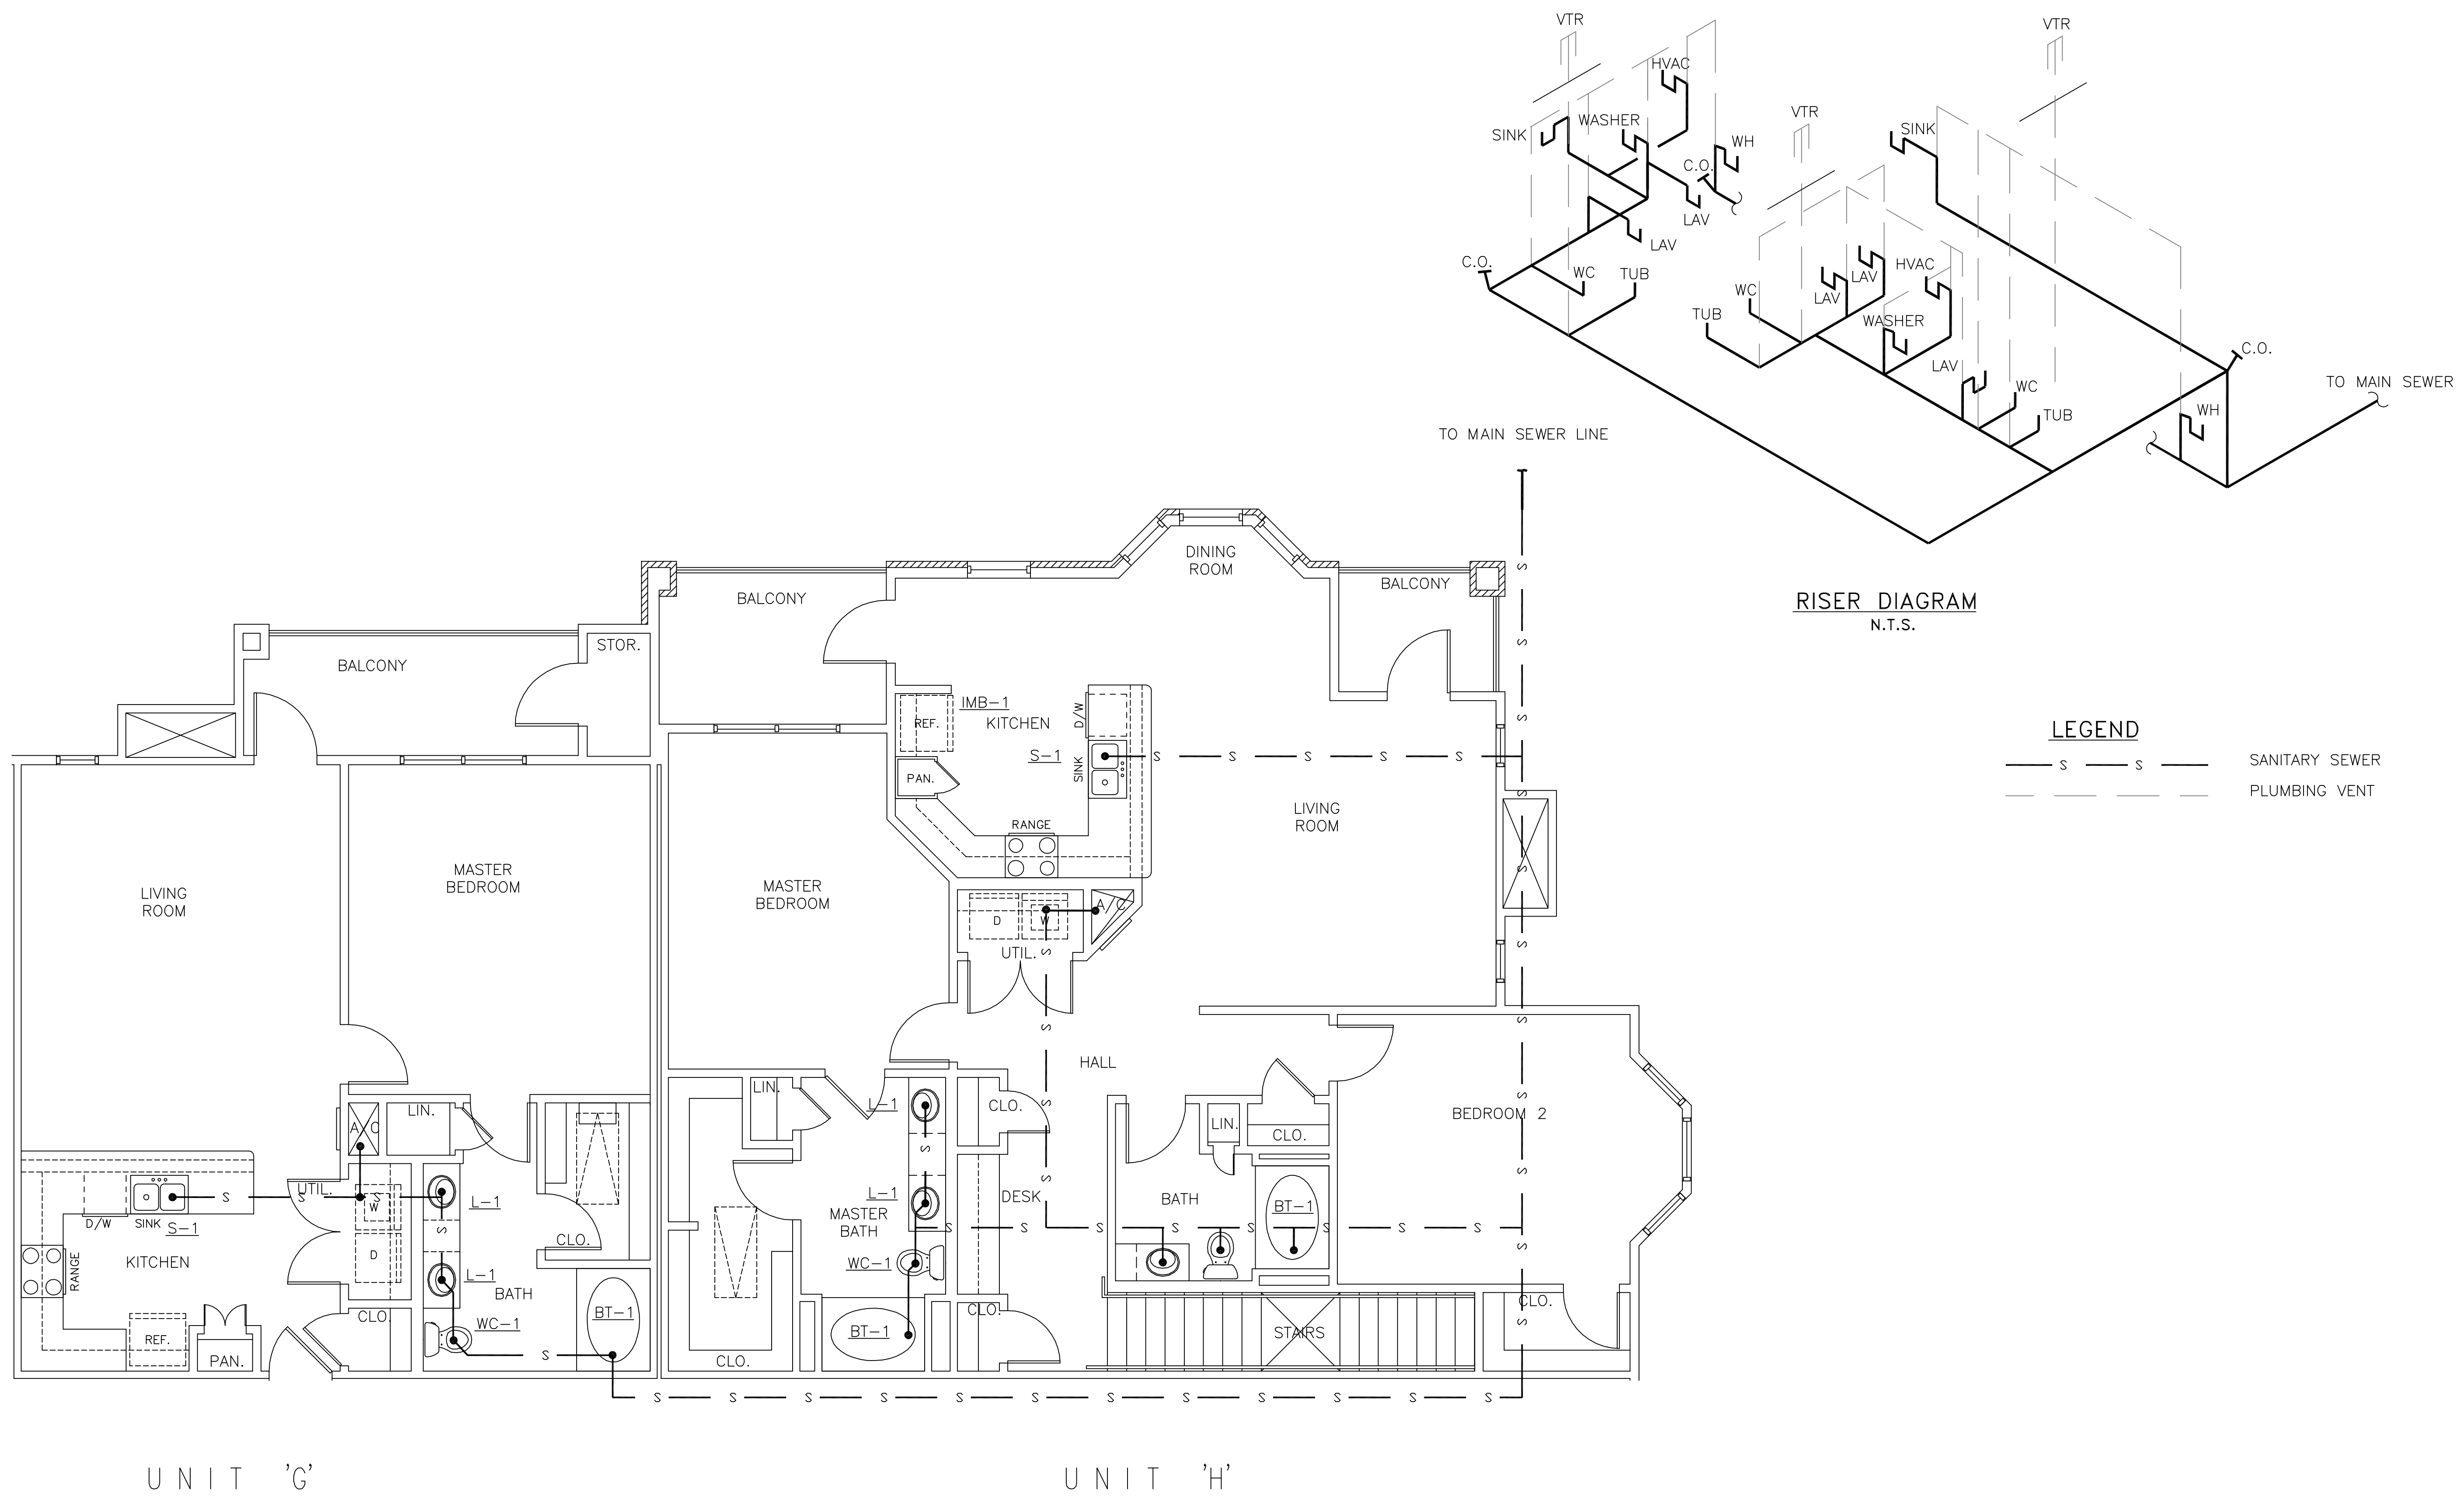

UNIT 'G'

UNIT 'H'

UNITS G & H PLUMBING PLAN

SCALE: 1/4" = 1'-0"

RISER DIAGRAM
N.T.S.

LEGEND

- s — s — SANITARY SEWER
- - - s - - - PLUMBING VENT

SCALE: AS NOTED

FILE:



JOB NO. 1817

DATE: 01-12-07


SHEET

P-5

OF

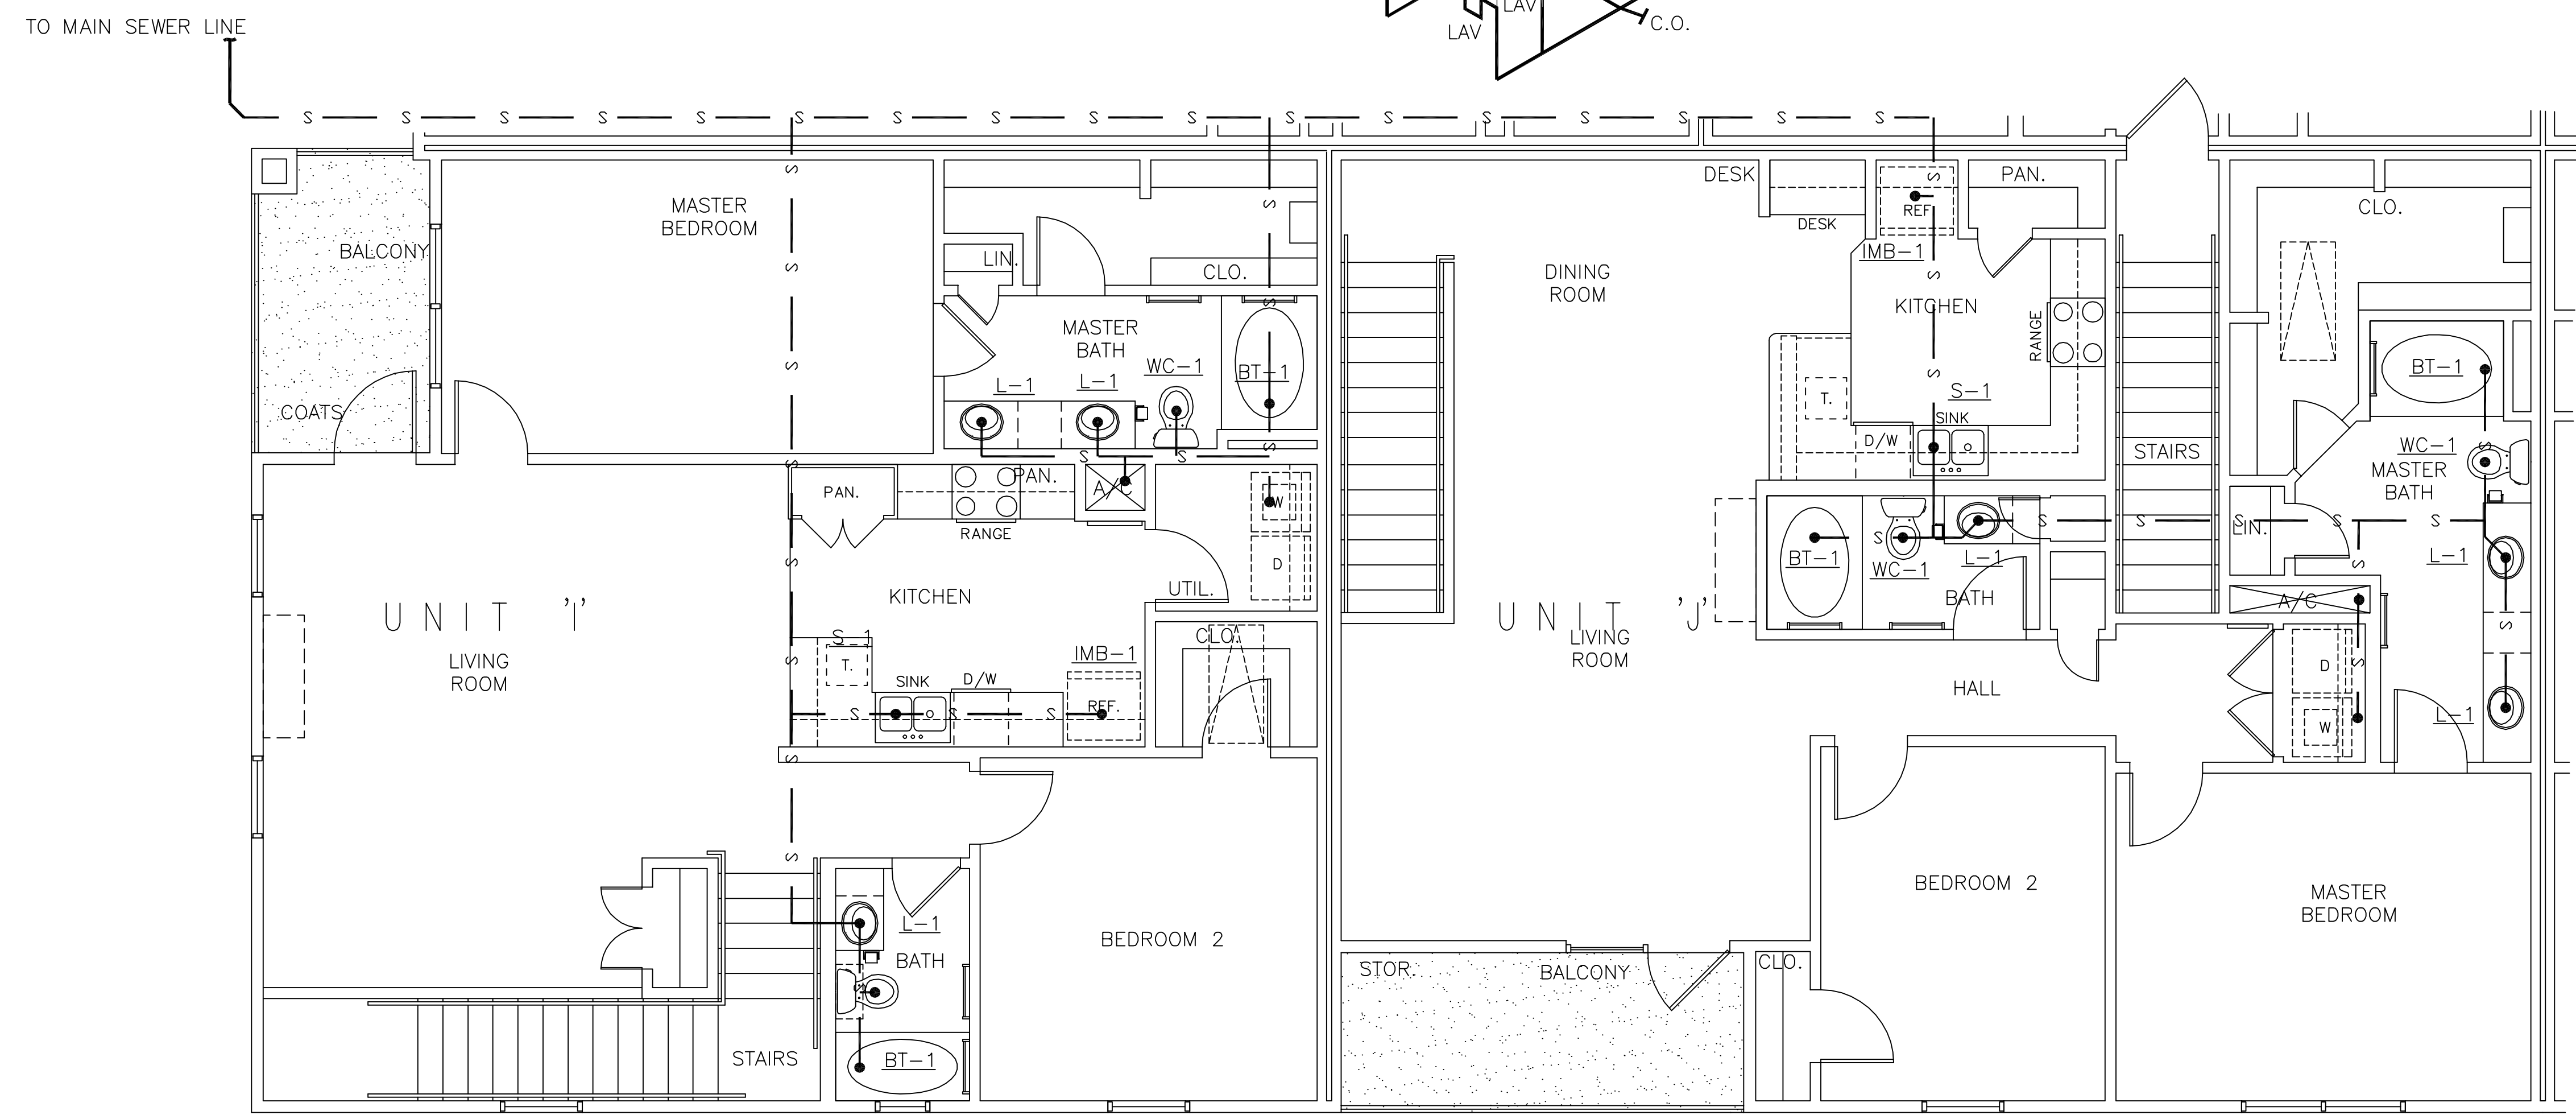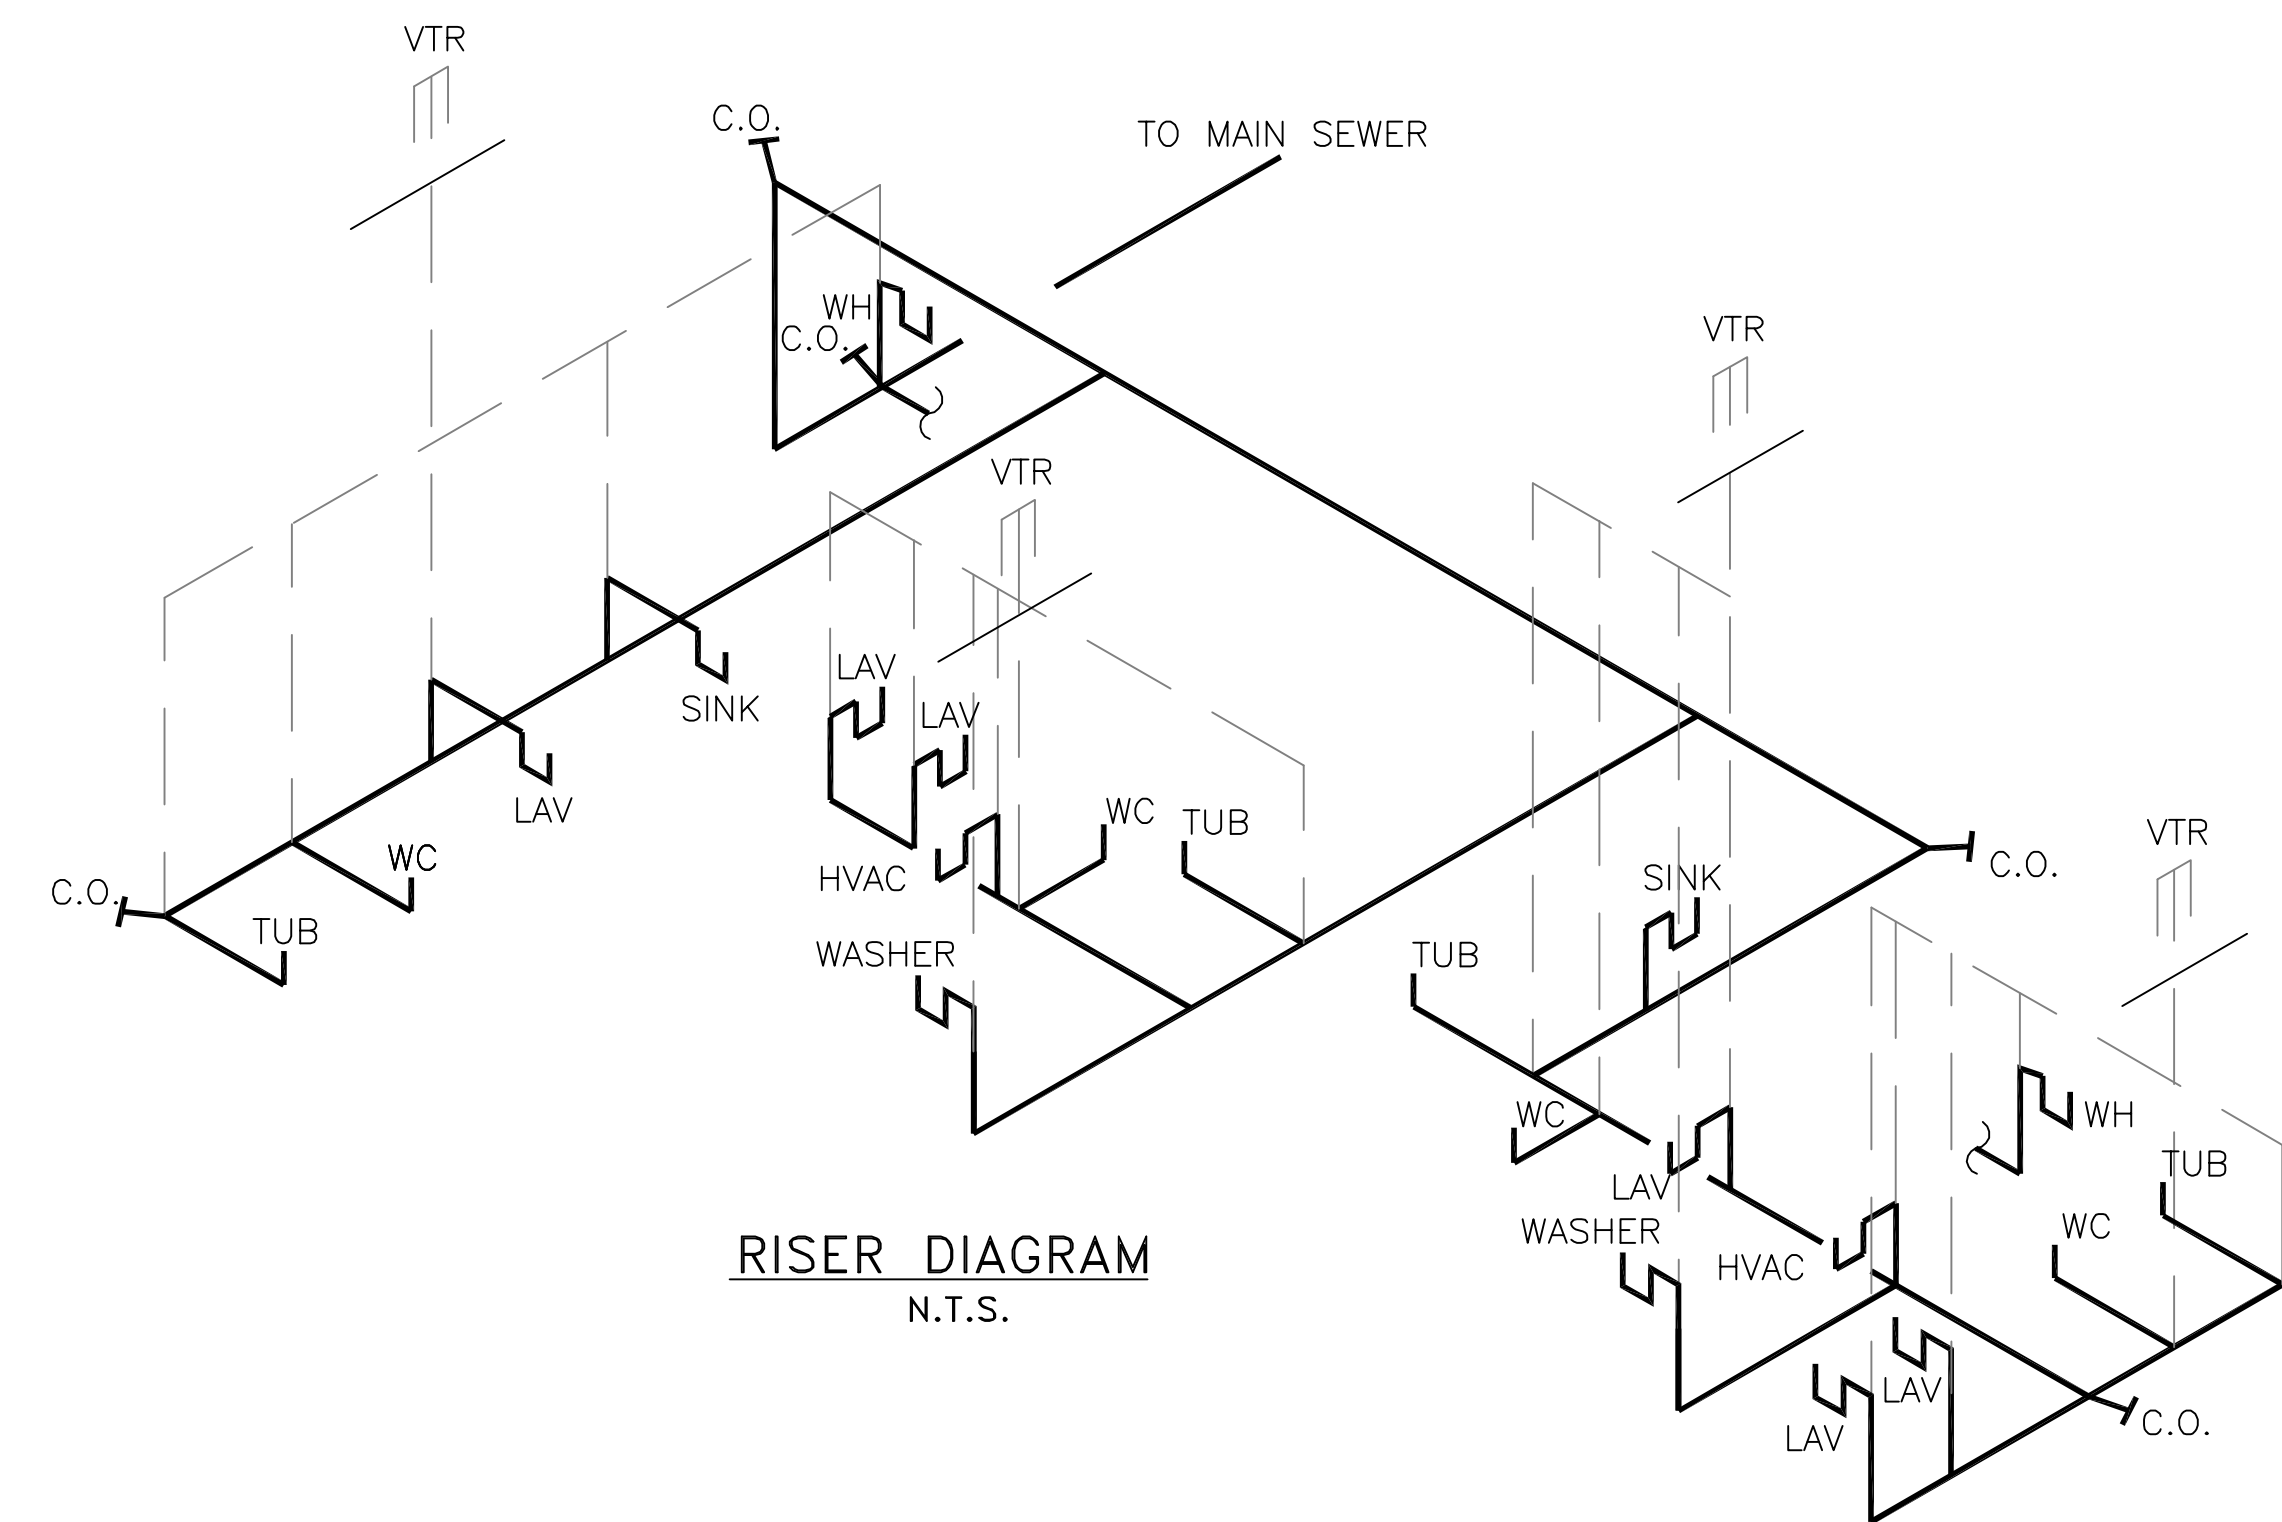


UNITS I & J PLUMBING PLAN
 SCALE: 1/4" = 1'-0"

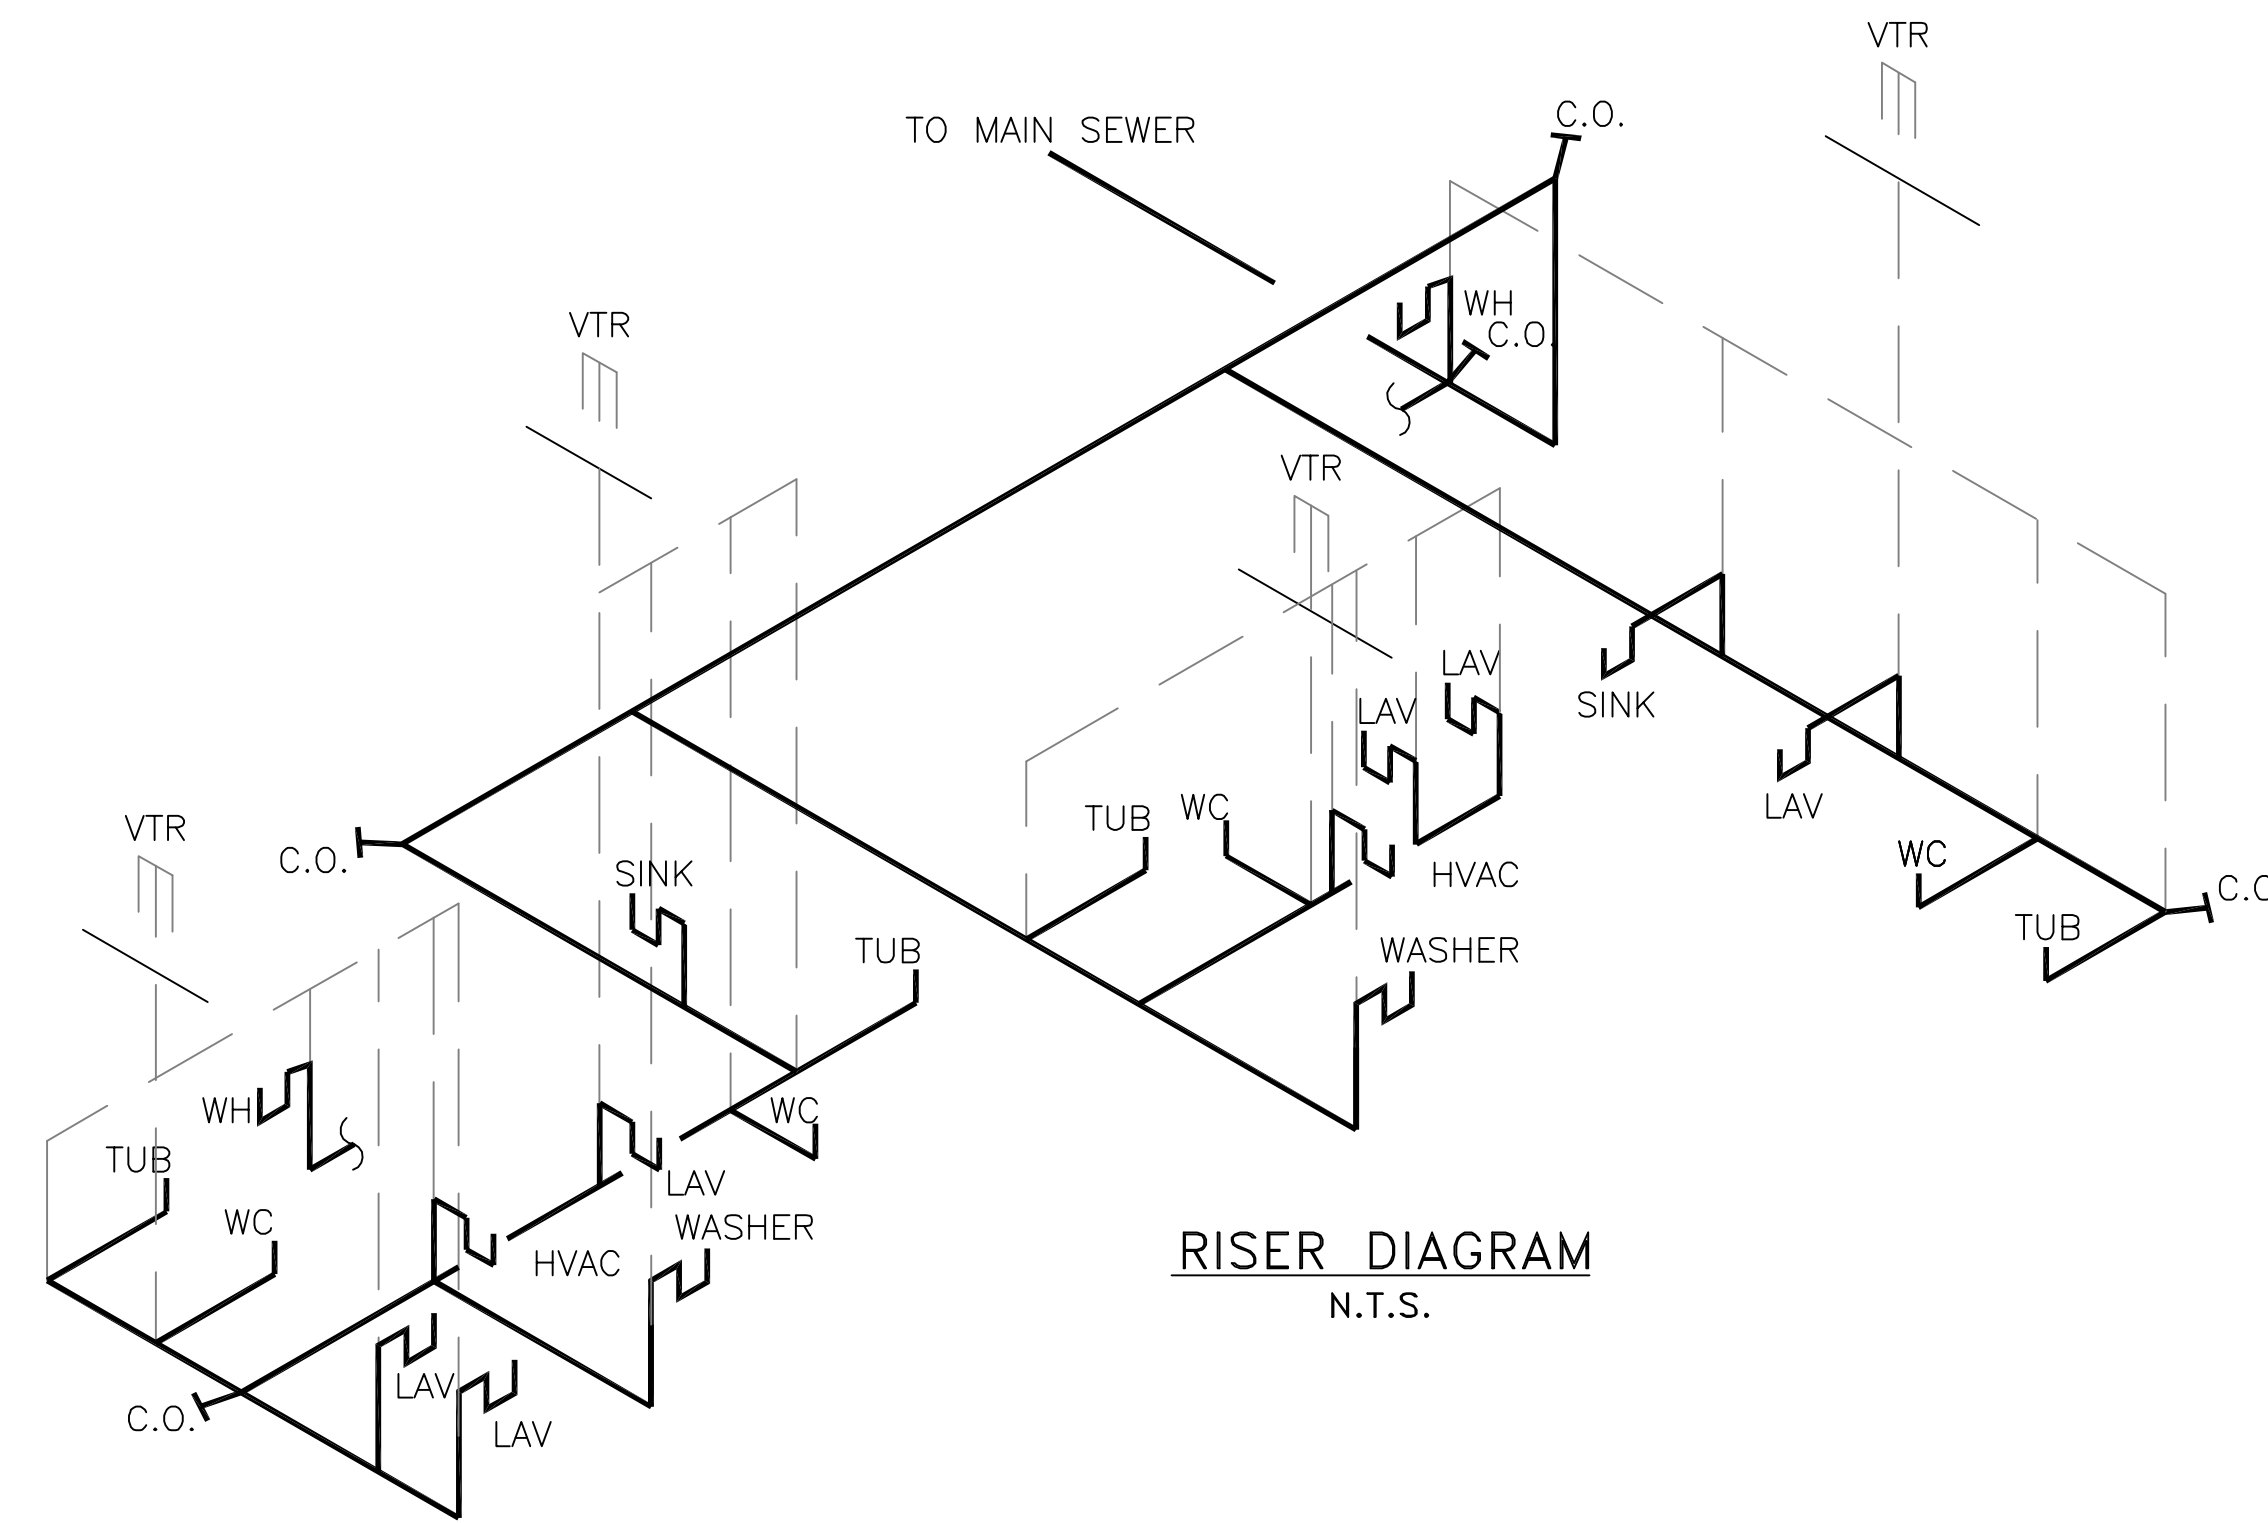

RISER DIAGRAM
N.T.S.

LEGEND
 — s — s — SANITARY SEWER
 - - - - - PLUMBING VENT

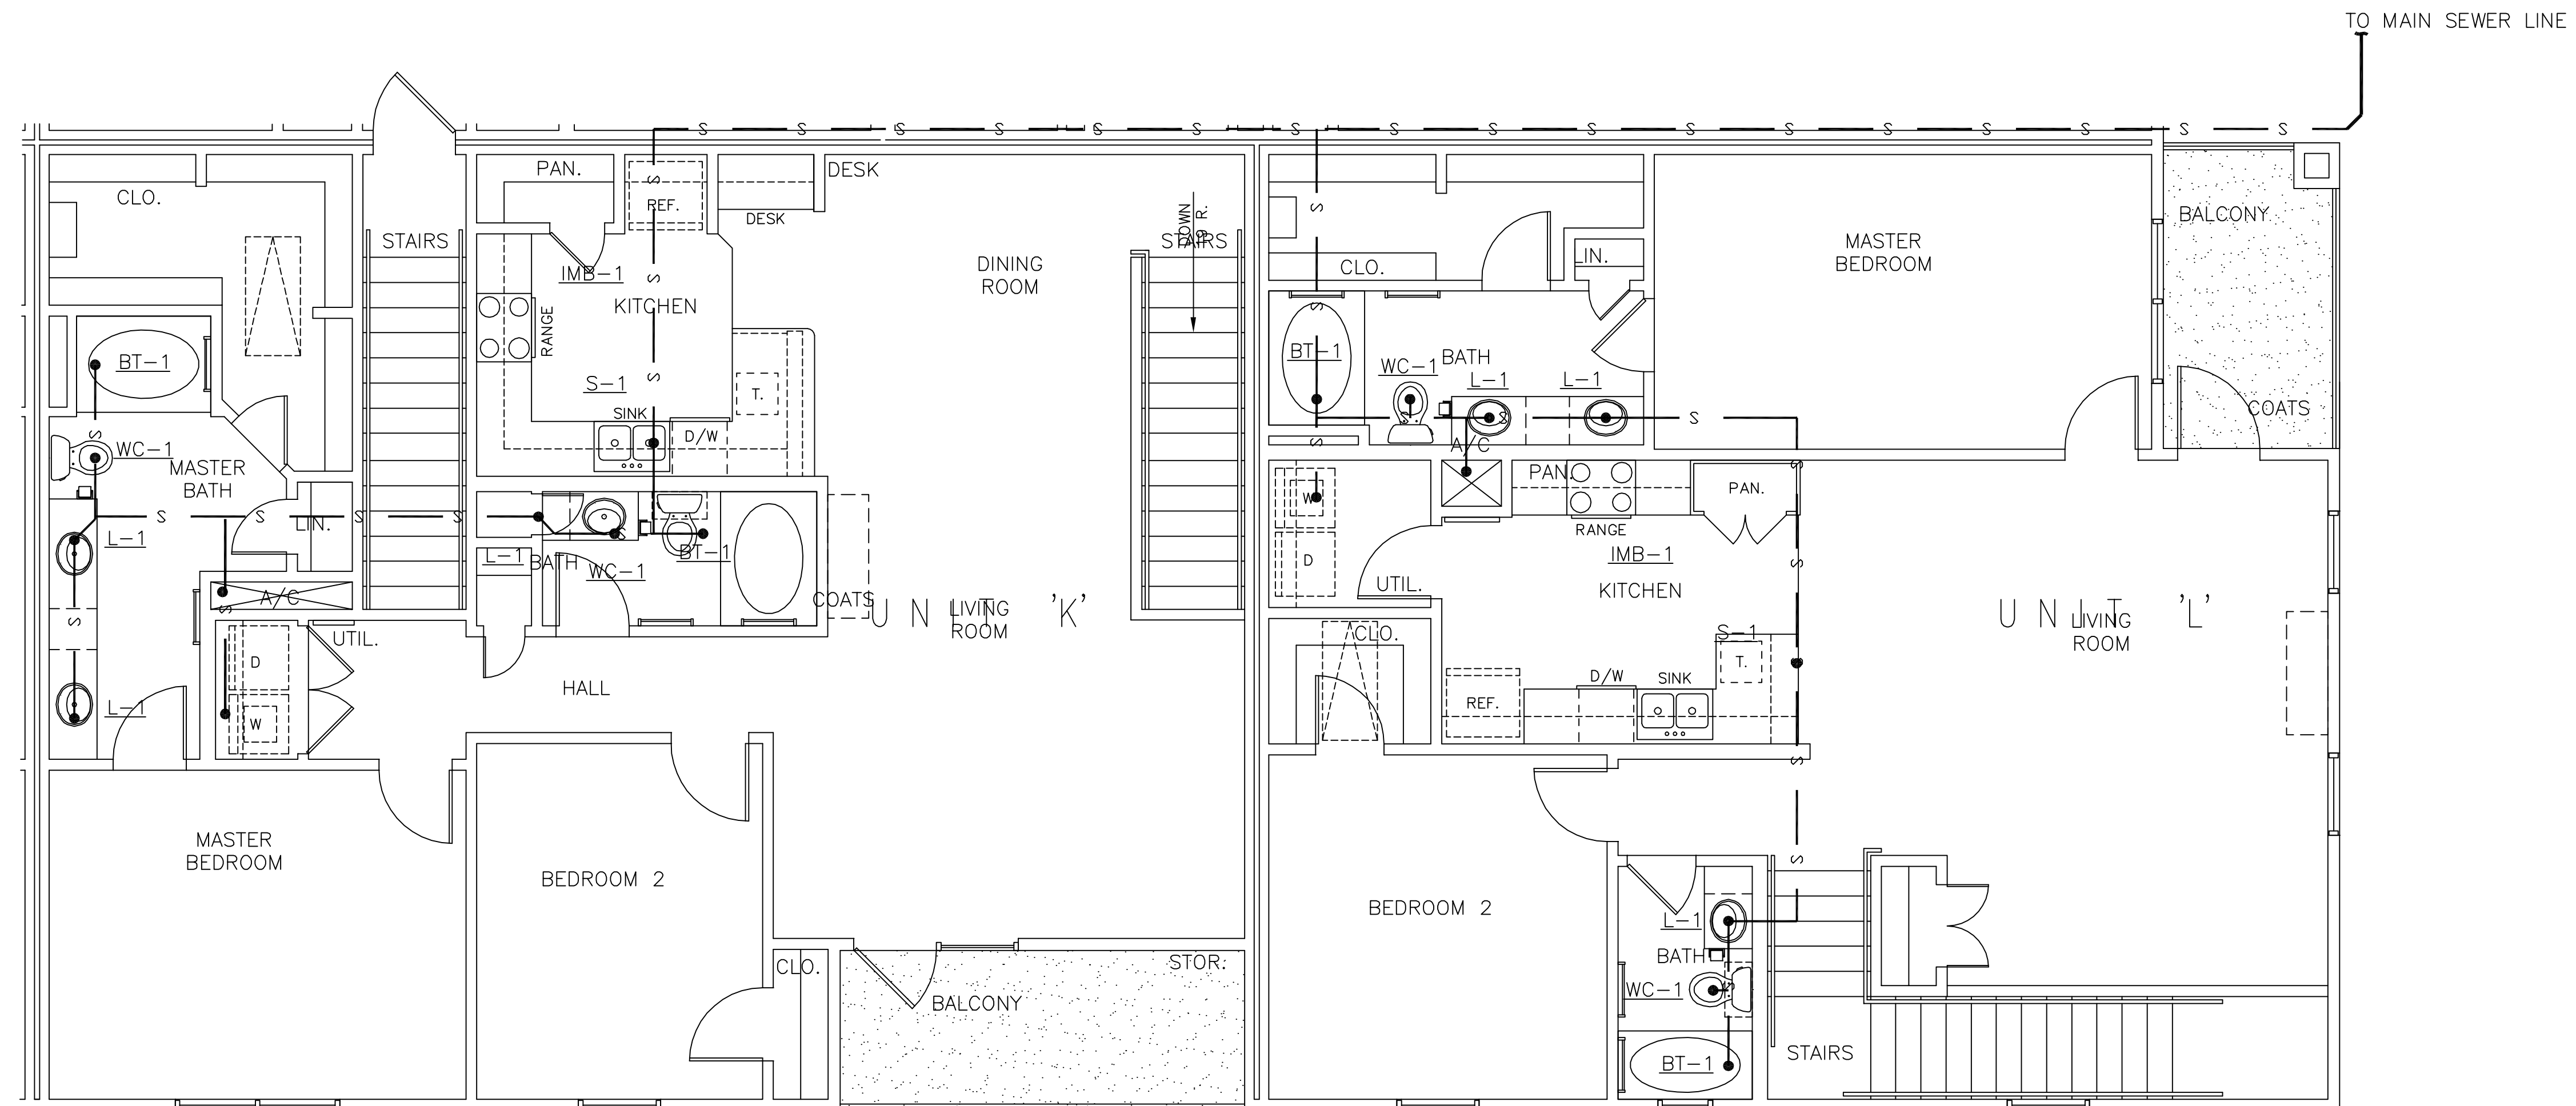

UNITS K & L PLUMBING PLAN
SCALE: 1/4" = 1'-0"

REVISED: 05/29/07ab

UNITS K & L PLUMBING PLAN
 REFLECTIONS OF ISLAND PARK
 APARTMENT COMMUNITY
 SHREVEPORT, LOUISIANA

REFLECTIONS OF ISLAND PARK
DAMMON ENGINEERING, INC.
 1095 FLORIDA AVENUE 985-649-5832 SLIDELL, LA. 70458
 DAMMONENGINEERING.COM

SCALE: AS NOTED

FILE:


JOB NO. 1817

DATE: 01-12-07

SHEET

P-7

OF

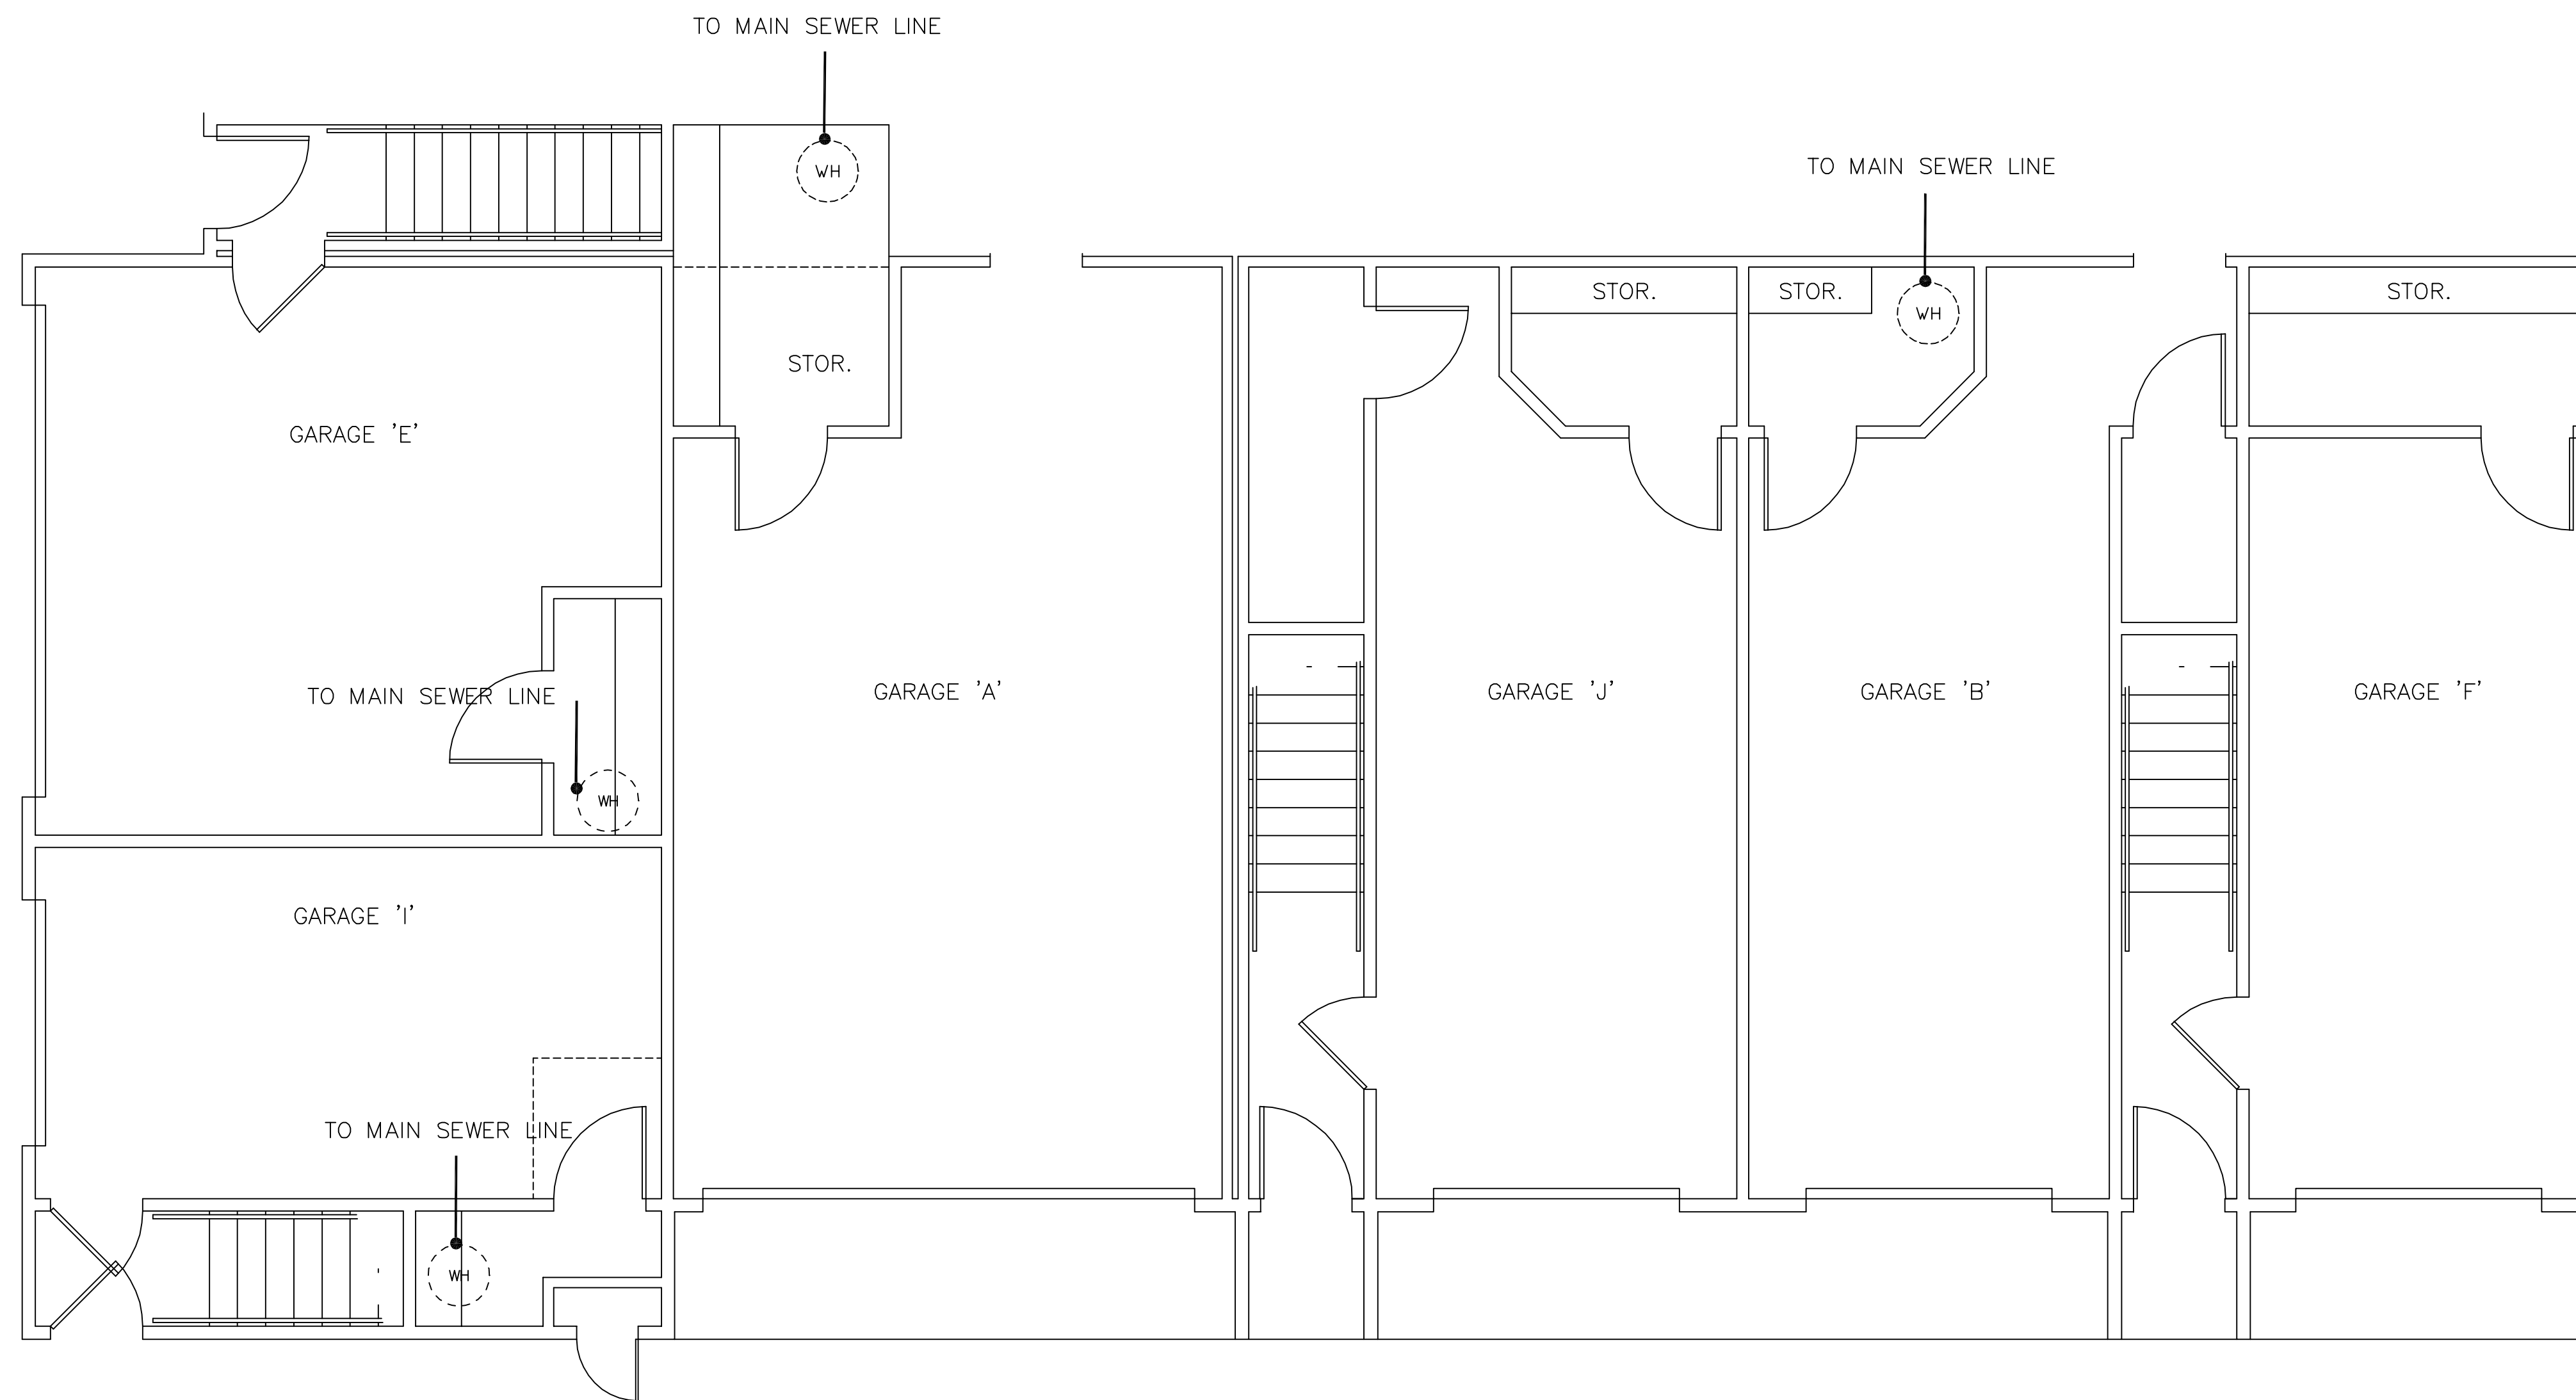

GARAGE PLUMBING PLAN
 SCALE: 1/4" = 1'-0"

GARAGE PLUMBING PLAN

ISLAND PARK
 APARTMENT COMMUNITY
 SHREVEPORT, LOUISIANA

ISLAND PARK APARTMENT COMMUNITY

DAMMON ENGINEERING, INC.
 1095 FLORIDA AVENUE 985-649-5832 SLIDELL, LA. 70458
 DAMMONENGINEERING.COM

SCALE: AS NOTED

FILE:


JOB NO. 1817

DATE: 01-12-07

SHEET

P - 08

OF

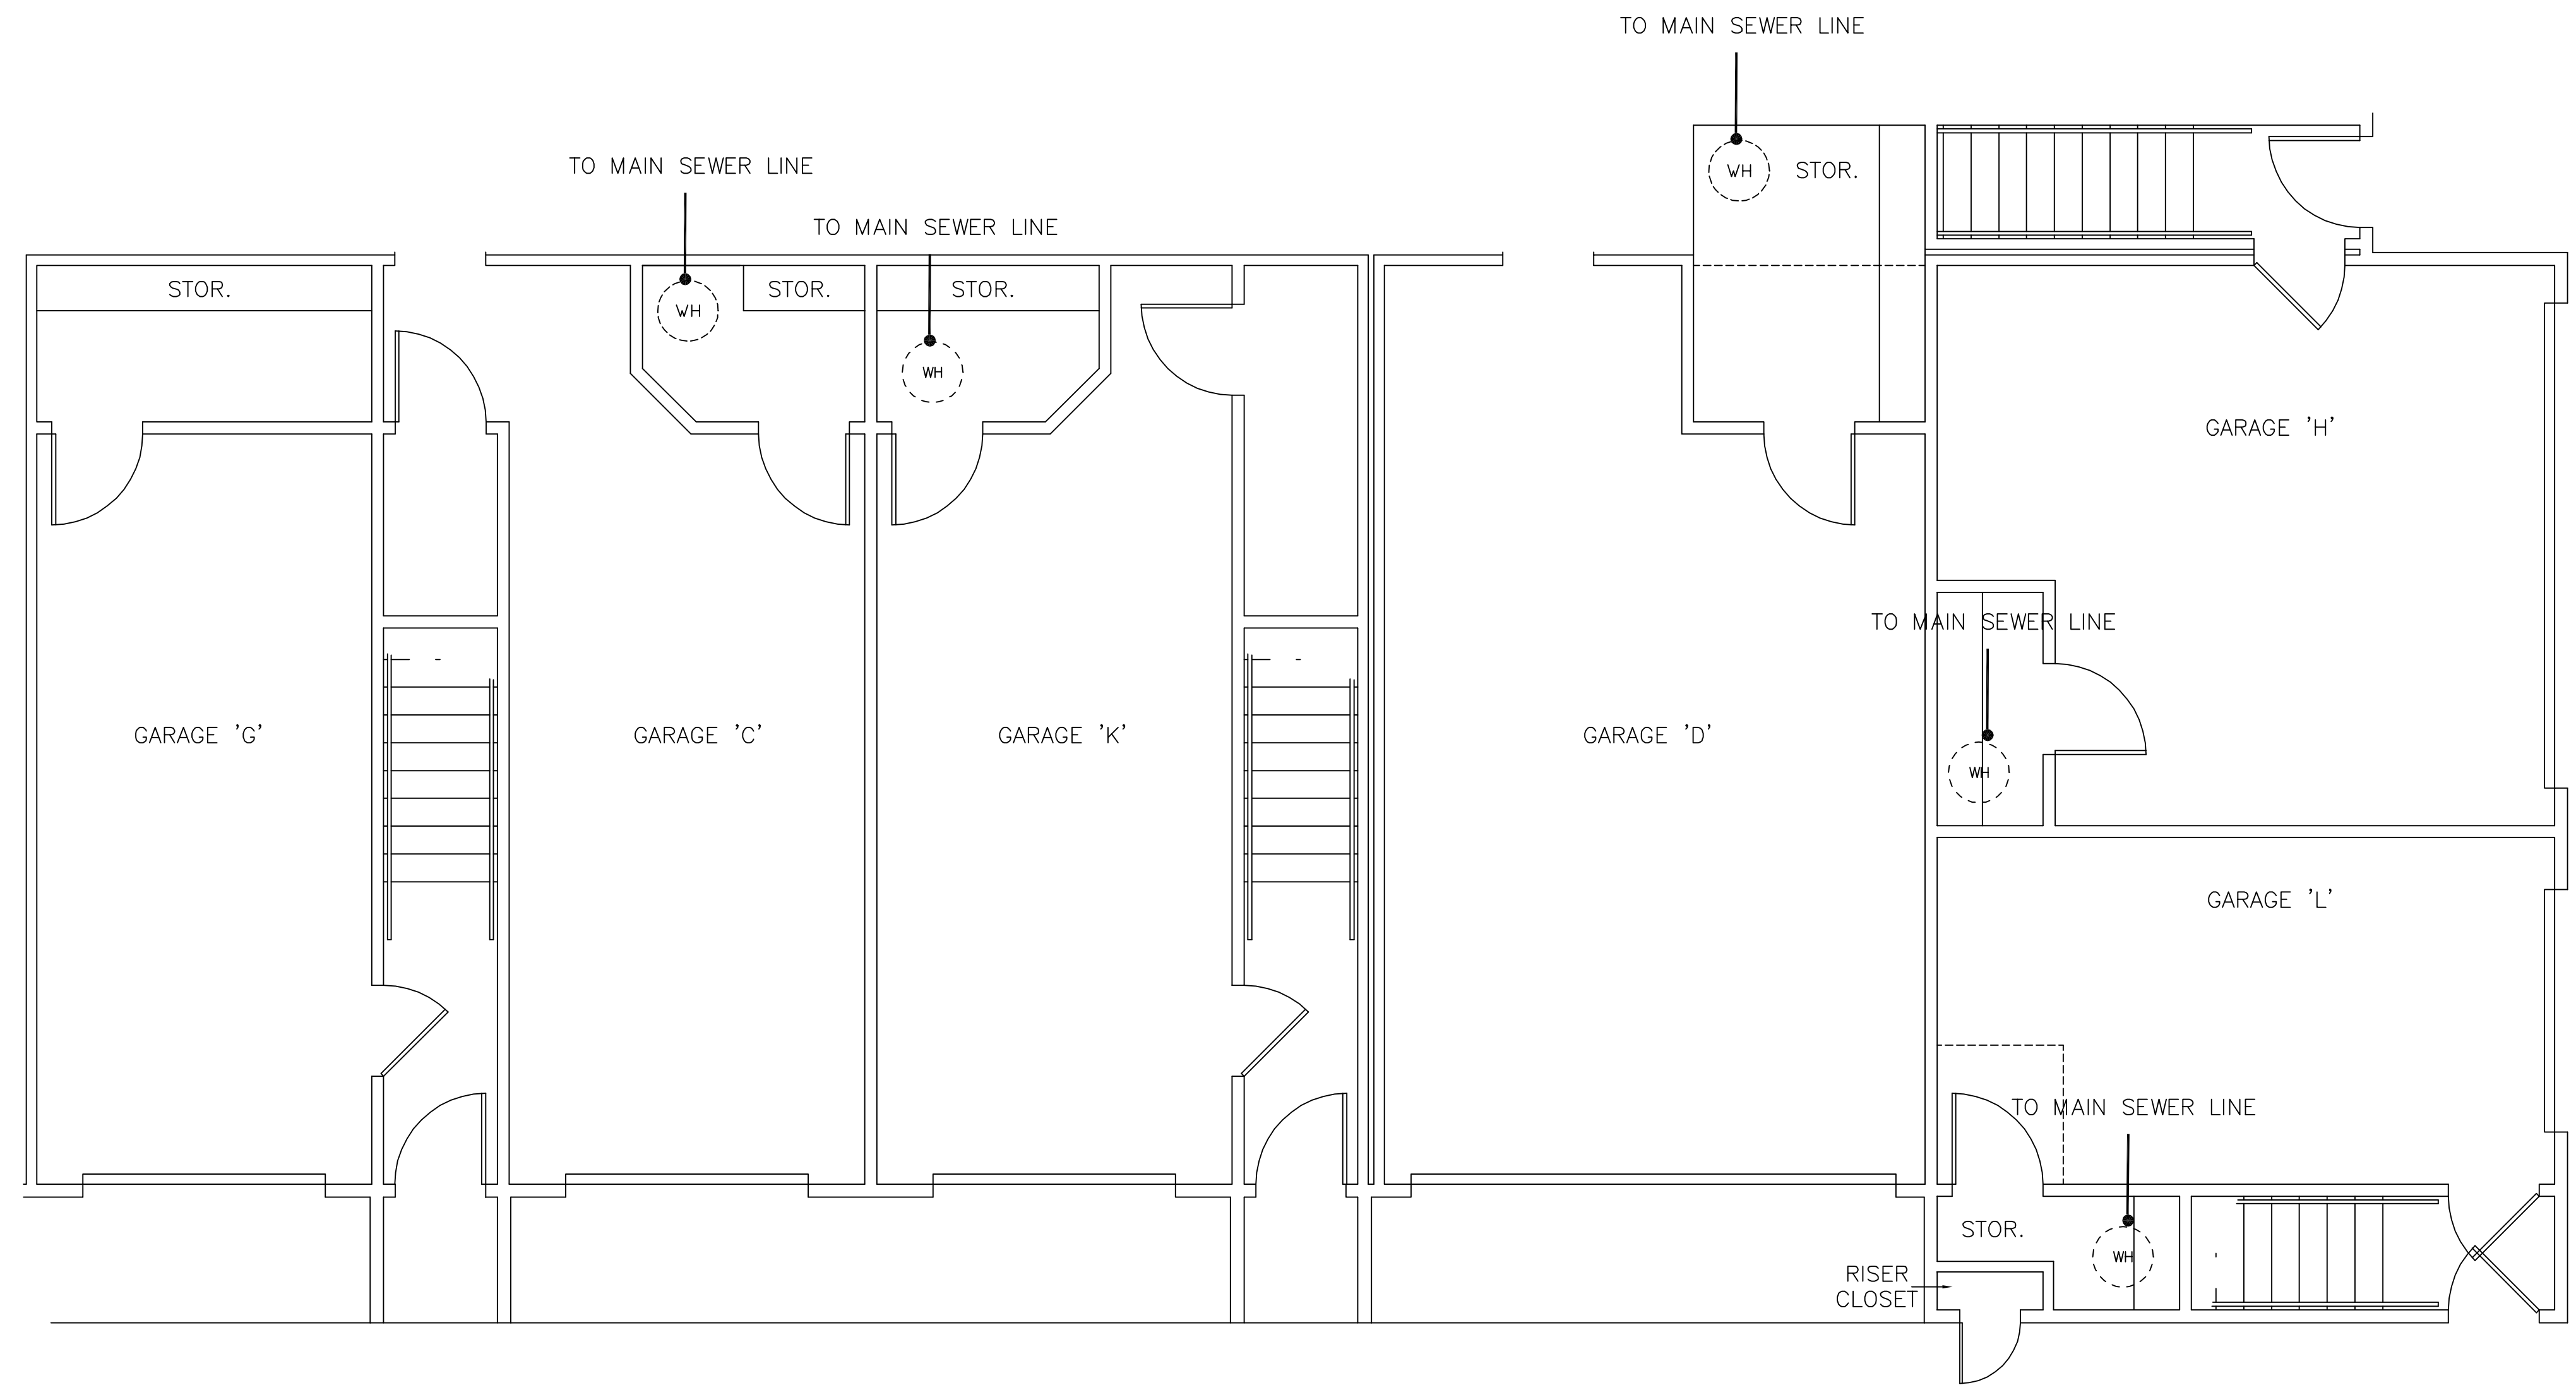

GARAGE PLUMBING PLAN
 SCALE: 1/4" = 1'-0"

GARAGE PLUMBING PLAN
 ISLAND PARK
 APARTMENT COMMUNITY
 SHREVEPORT, LOUISIANA

ISLAND PARK APARTMENT COMMUNITY
DAMMON ENGINEERING, INC.
 1095 FLORIDA AVENUE 985-649-5832 SLIDELL, LA. 70458
 DAMMONENGINEERING.COM

SCALE: AS NOTED
 FILE:
 JOB NO. 1817
 DATE: 01-12-07

SHEET
 P - 9
 OF