


UNIT 'C'

UNIT 'D'

UNITS C & D PLUMBING PLAN
SCALE: 1/4" = 1'-0"

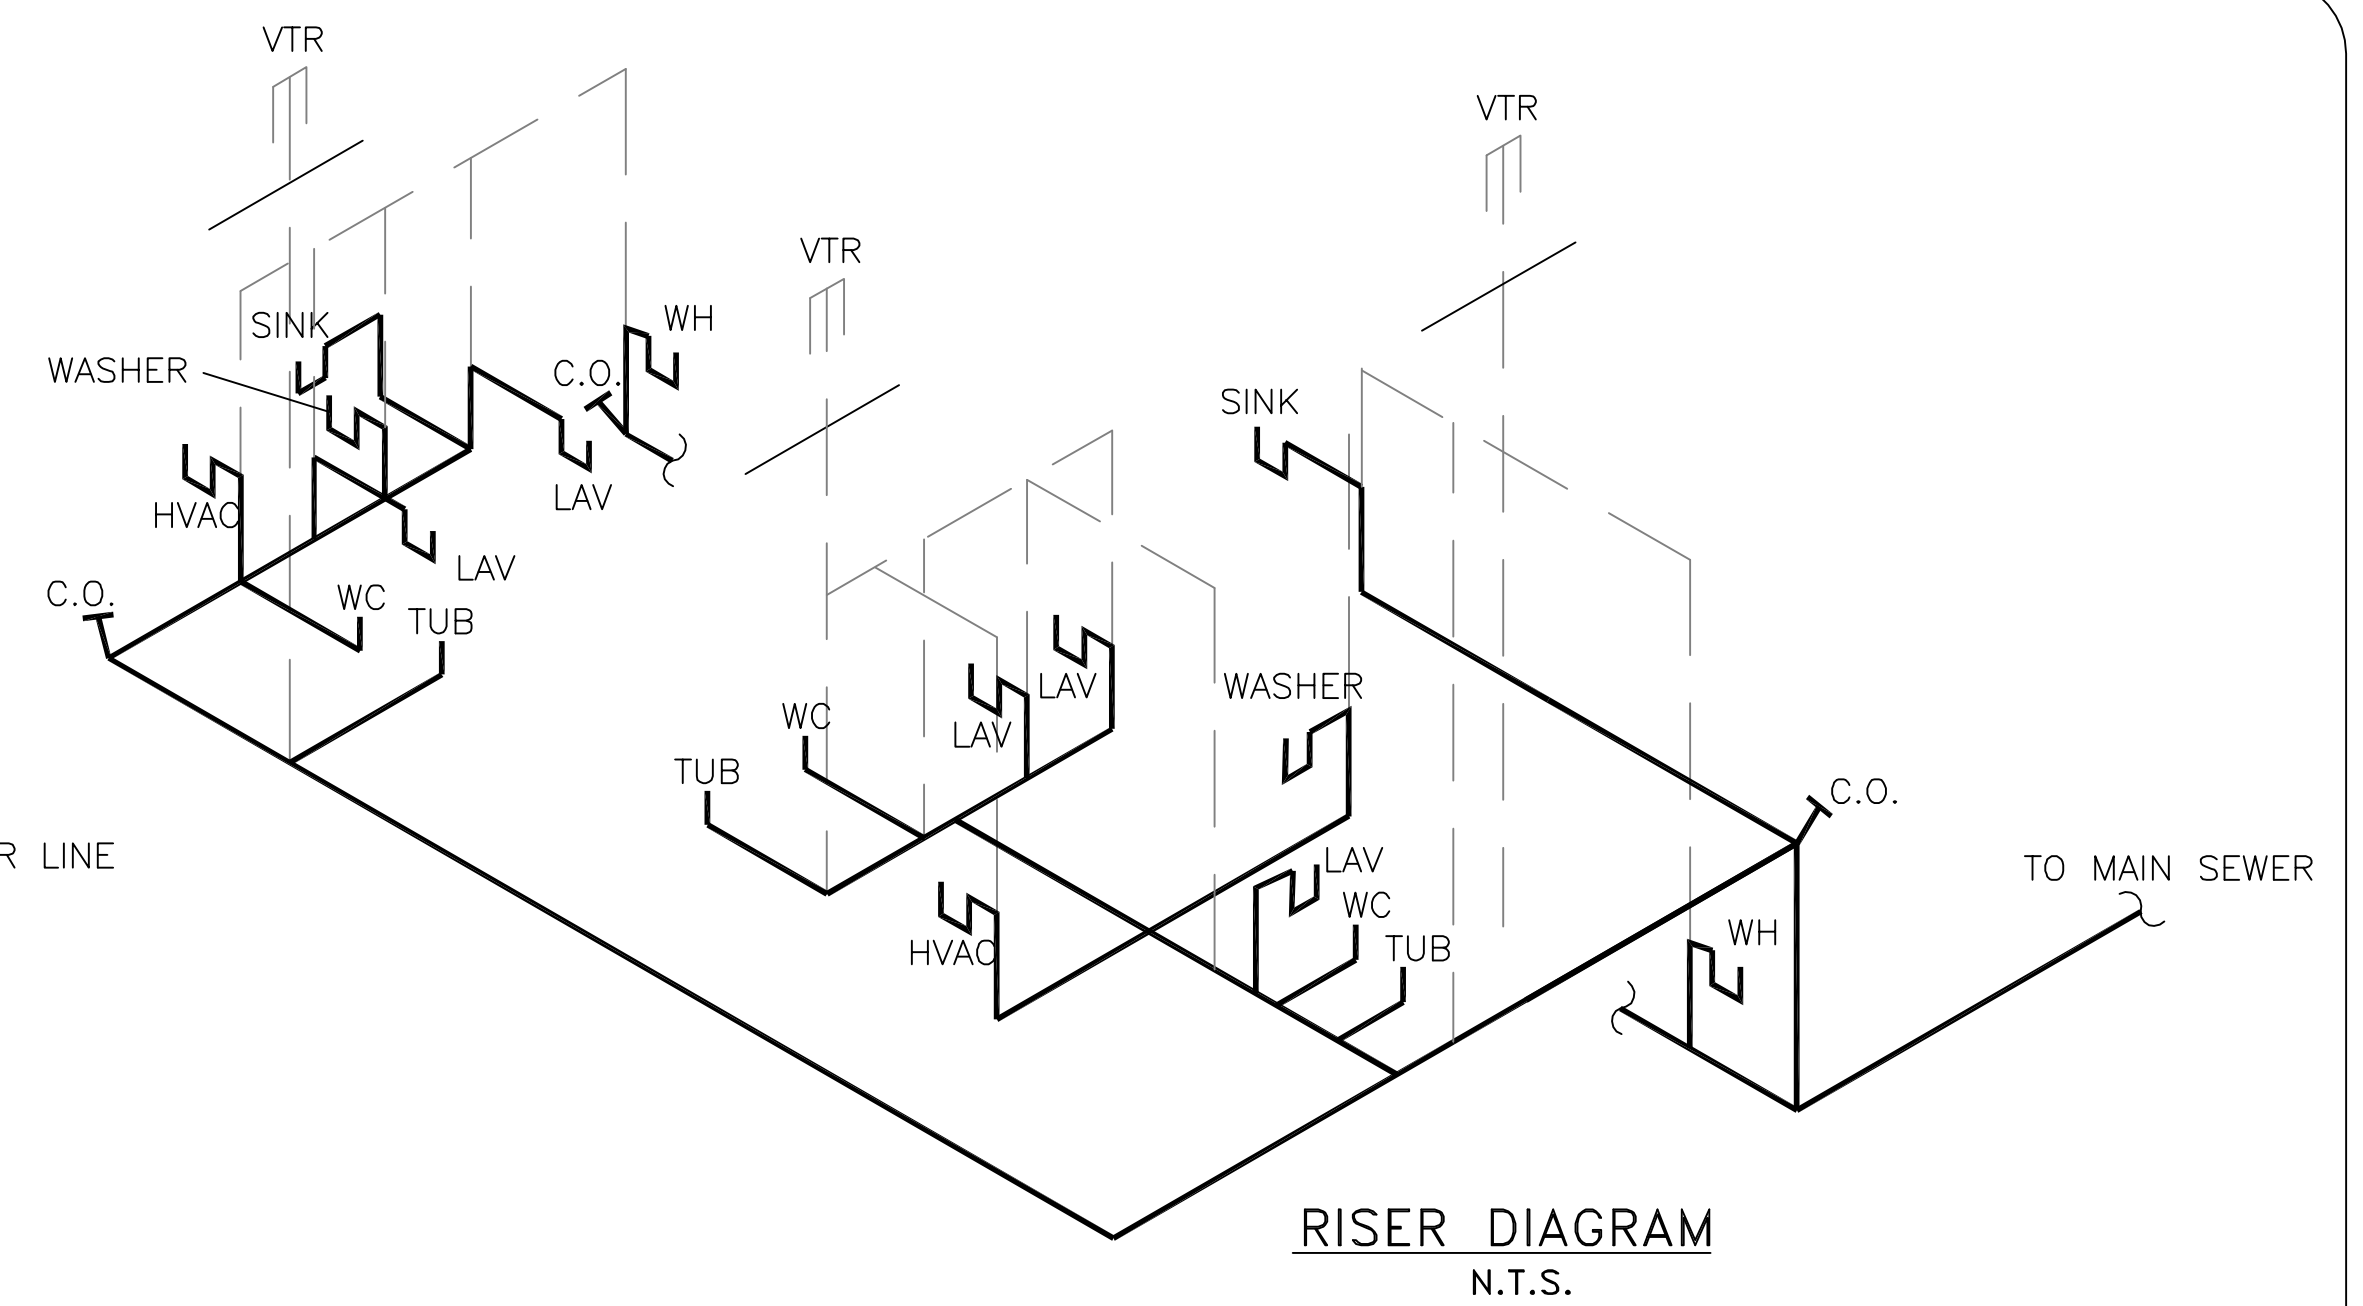

LEGEND
 — s — s — SANITARY SEWER
 - - - - - PLUMBING VENT

UNITS C & D PLUMBING PLAN
 REFLECTIONS OF ISLAND PARK
 APARTMENT COMMUNITY
 SHREVEPORT, LOUISIANA

REFLECTIONS OF ISLAND PARK
DAMMON ENGINEERING, INC.
 1095 FLORIDA AVENUE 985-649-5832 SLIDELL, LA. 70458
 DAMMONENGINEERING.COM

SCALE: AS NOTED

FILE:

JOB NO. 1817

DATE: 01-12-07

SHEET

P - 3

OF