


**RISER DIAGRAM**  
N.T.S.

**LEGEND**  
 — s — s — SANITARY SEWER  
 - - - - - PLUMBING VENT

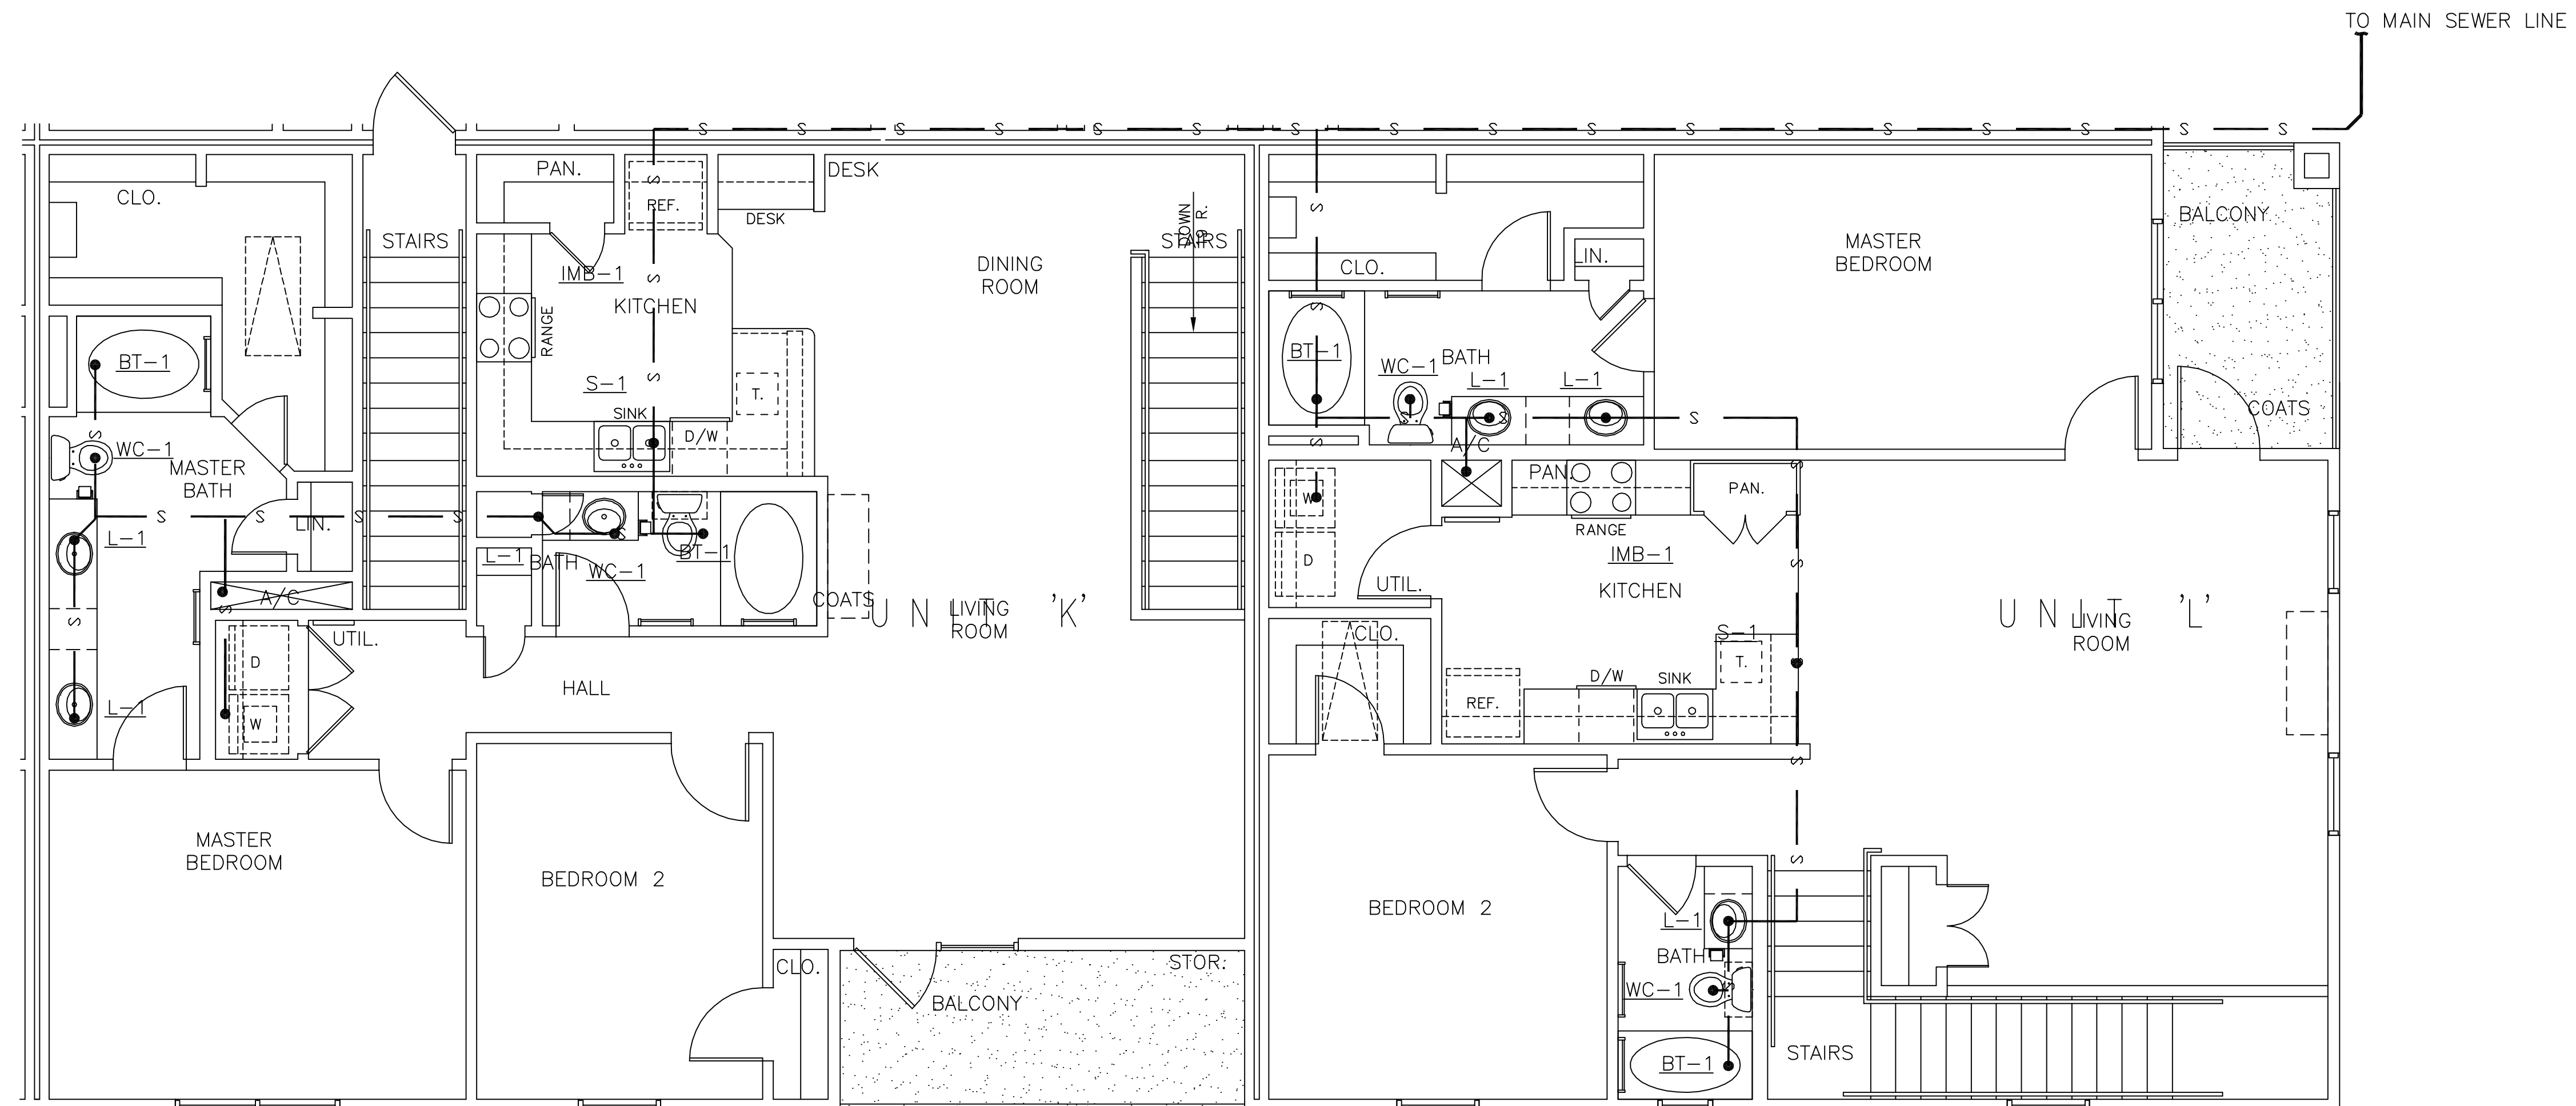

**UNITS K & L PLUMBING PLAN**  
SCALE: 1/4" = 1'-0"

REVISED: 05/29/07ab

UNITS K & L PLUMBING PLAN  
 REFLECTIONS OF ISLAND PARK  
 APARTMENT COMMUNITY  
 SHREVEPORT, LOUISIANA

REFLECTIONS OF ISLAND PARK  
**DAMMON ENGINEERING, INC.**  
 1095 FLORIDA AVENUE 985-649-5832 SLIDELL, LA. 70458  
 DAMMONENGINEERING.COM

SCALE: AS NOTED

FILE:

JOB NO. 1817

DATE: 01-12-07

SHEET

P-7

OF