

**DAMMON**  
ENGINEERING, INC.  
CHIEF ENGINEER  
EMMETT  
DAMMON, P.E.  
CHIEF ARCHITECT  
ROBERT  
WILTSE

1095 FLORIDA AVENUE  
SLIDELL, LA, 70458  
OFFICE: 985-649-5832  
FAX: 985-641-5950

WEBSITE:  
WWW.DAMMONENGINEERING.COM  
EMAIL:  
DAMMONEN@BELLSOUTH.NET

ARCHITECTURE  
ENGINEERING  
STUDIES  
PLANNING  
INVESTIGATION  
EXPERT WITNESS

EL-BETHEL  
PENTECOSTAL  
CHURCH

REV. EUGENE  
WELLINGTON  
ALLEN ROAD  
SLIDELL, LA

POWER  
PLAN

REV:

SCALE: AS NOTED


JOB#: 1819A

DATE: 11-19-08

SHEET 15

E-1

OF 20

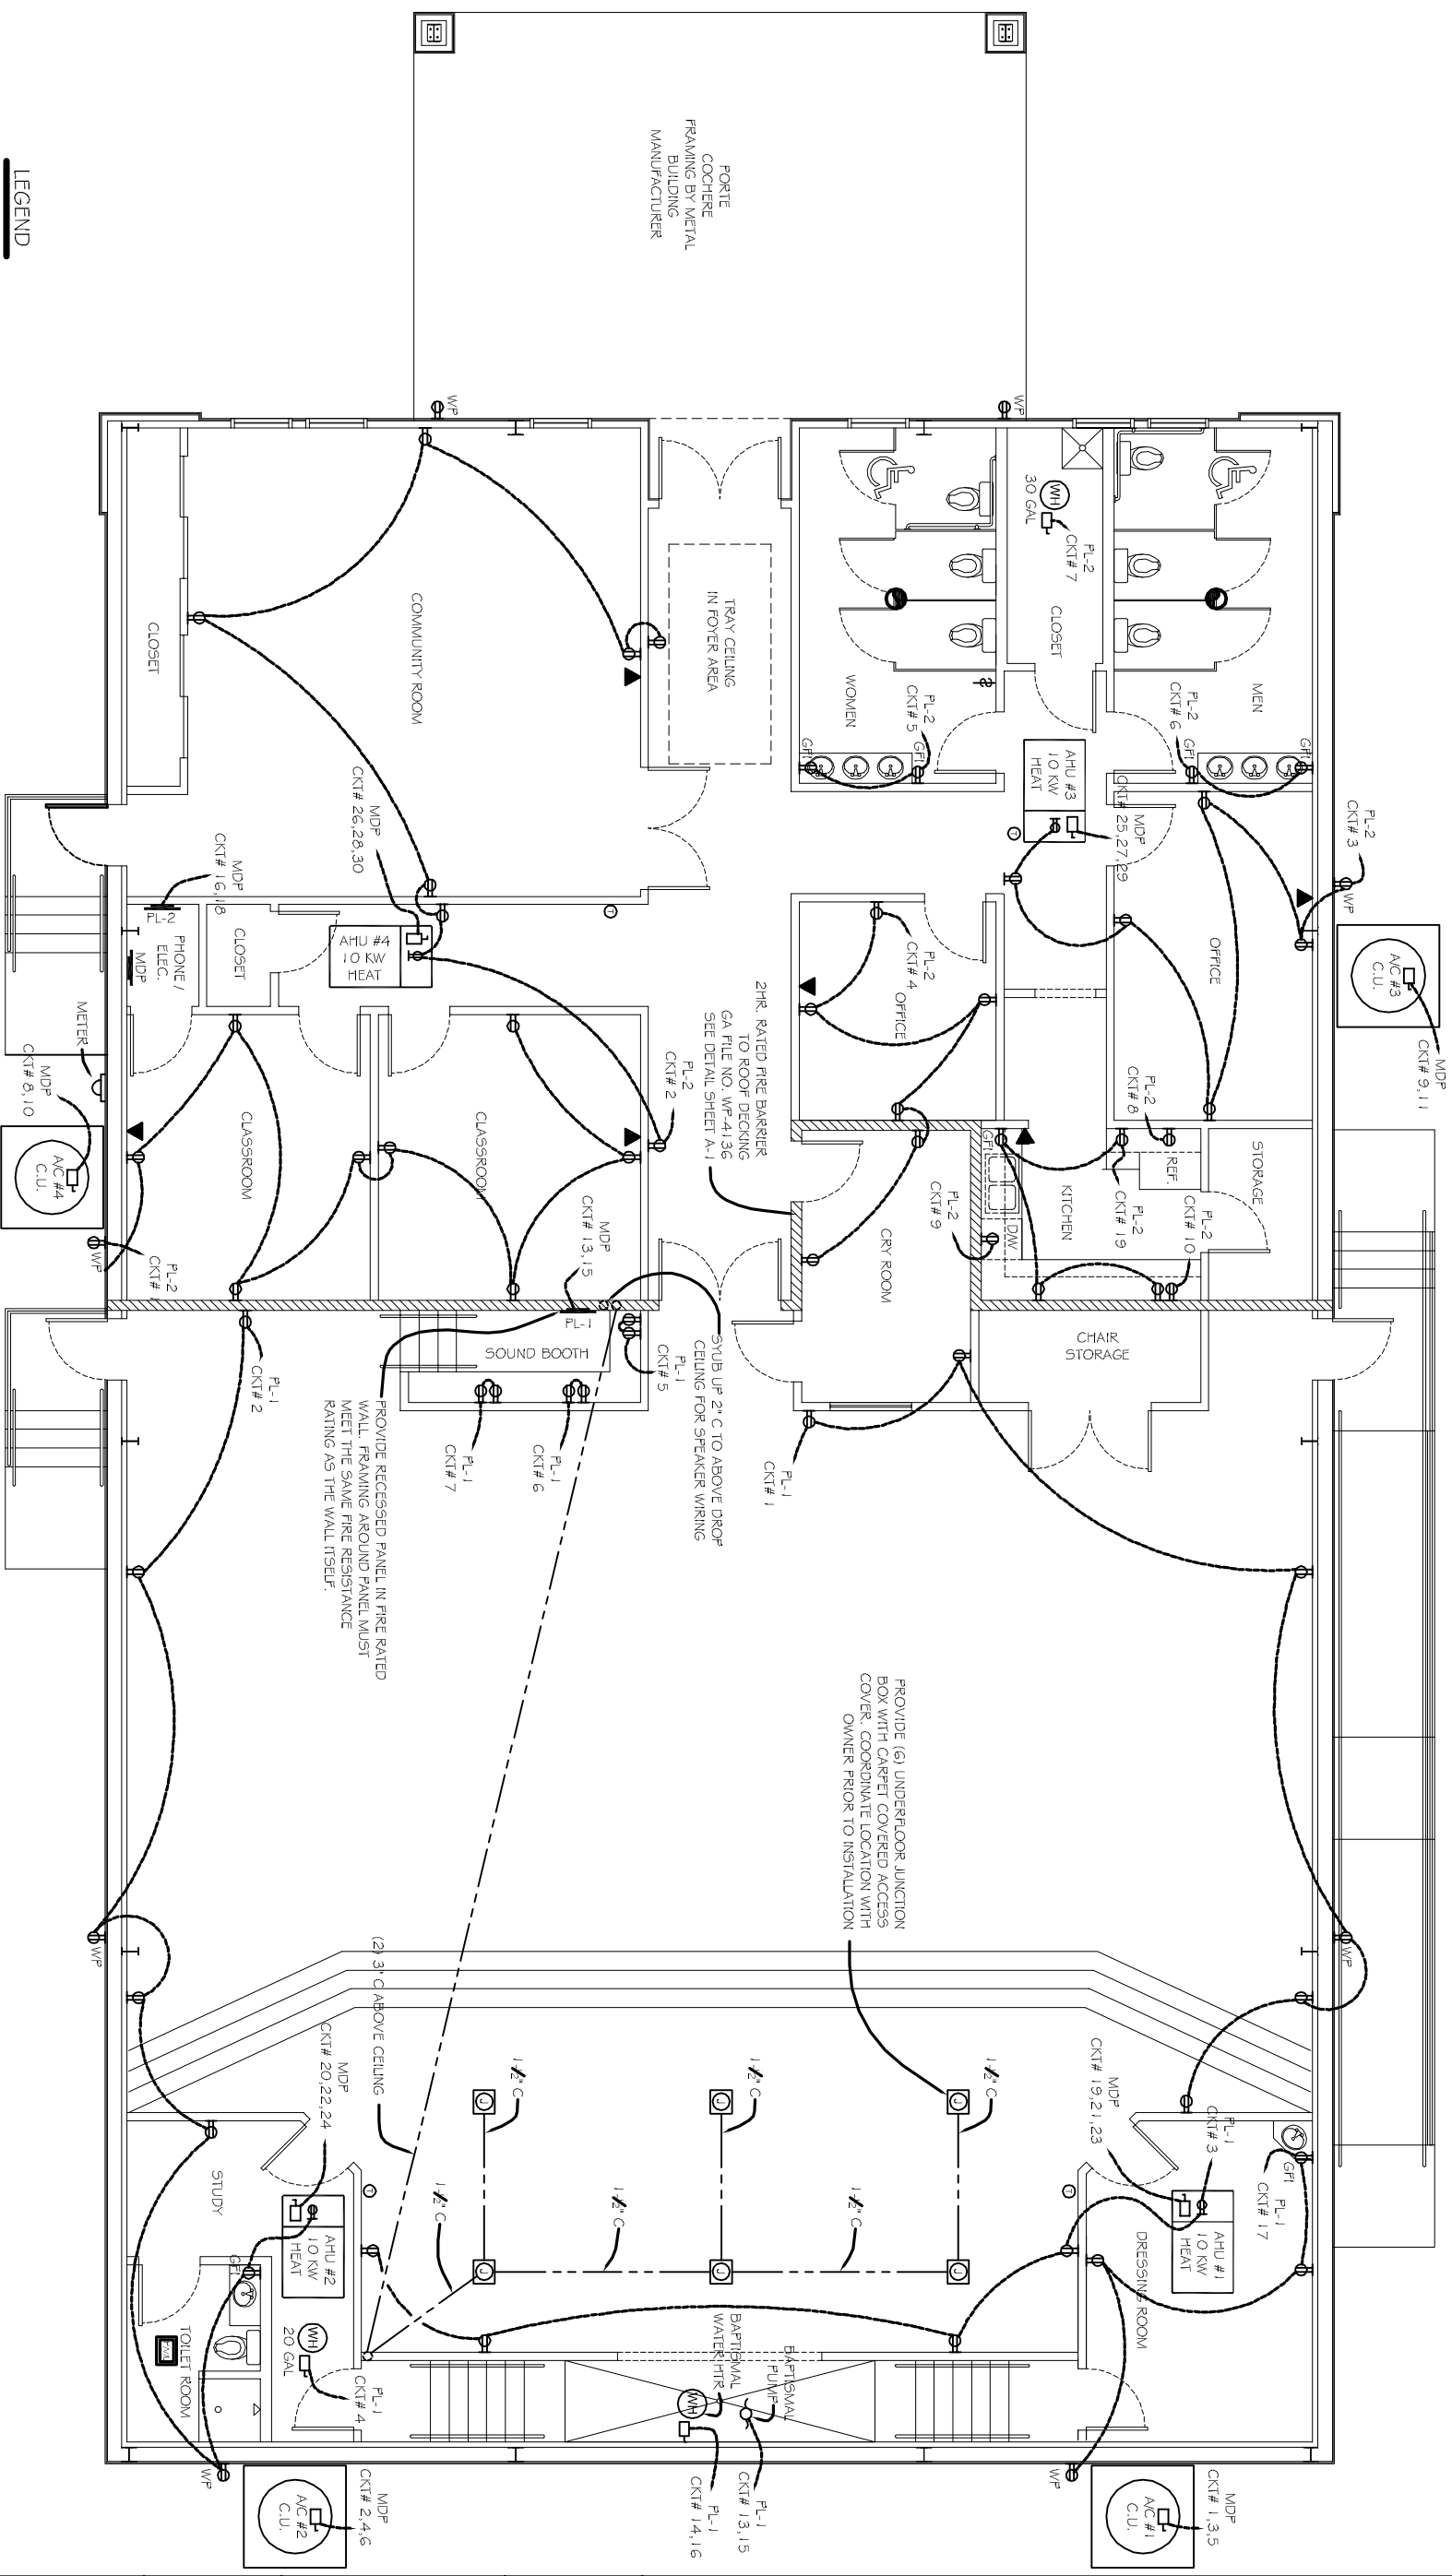

**POWER PLAN**  
SCALE: 1/4"=1'-0"

SEE SHEET E-3 FOR ELECTRICAL NOTES AND PANEL SCHEDULE.

- LEGEND**
- ⊕ - 120V, 20A DUPLEX RECEPTACLE
  - ⊕WP - 120V, 20A DUPLEX RECEPTACLE (WEATHER PROOF)
  - ⊖ - JUNCTION BOX
  - ⊖ - DISCONNECT
  - ⊖ - POWER PANEL
  - ⊖WP - WATER HEATER W/ DISCONNECT
  - ⊖ - SWITCH
  - ⊖ - PHONE / INTERNET / CABLE COORDINATE WITH OWNER

FORTE  
COCHERE  
FRAMING BY METAL  
BUILDING  
MANUFACTURER

2-HR. RATED FIRE BARRIER  
TO ROOF DECKING  
GA FILE NO. WF-4136  
SEE DETAIL SHEET A-1

PROVIDE RECESSED PANEL IN FIRE RATED  
WALL. FRAMING AROUND PANEL MUST  
MEET THE SAME FIRE RESISTANCE  
RATING AS THE WALL ITSELF.

PROVIDE (6) UNDERLOOR JUNCTION  
BOX WITH CARPET COVERED ACCESS  
COVER. COORDINATE LOCATION WITH  
OWNER PRIOR TO INSTALLATION