


1 POTABLE WATER PIPING PLAN
P2.1 SCALE: 1/4" = 1'-0"



2 SANITARY AND VENT PIPING PLAN
P2.1 SCALE: 1/4" = 1'-0"

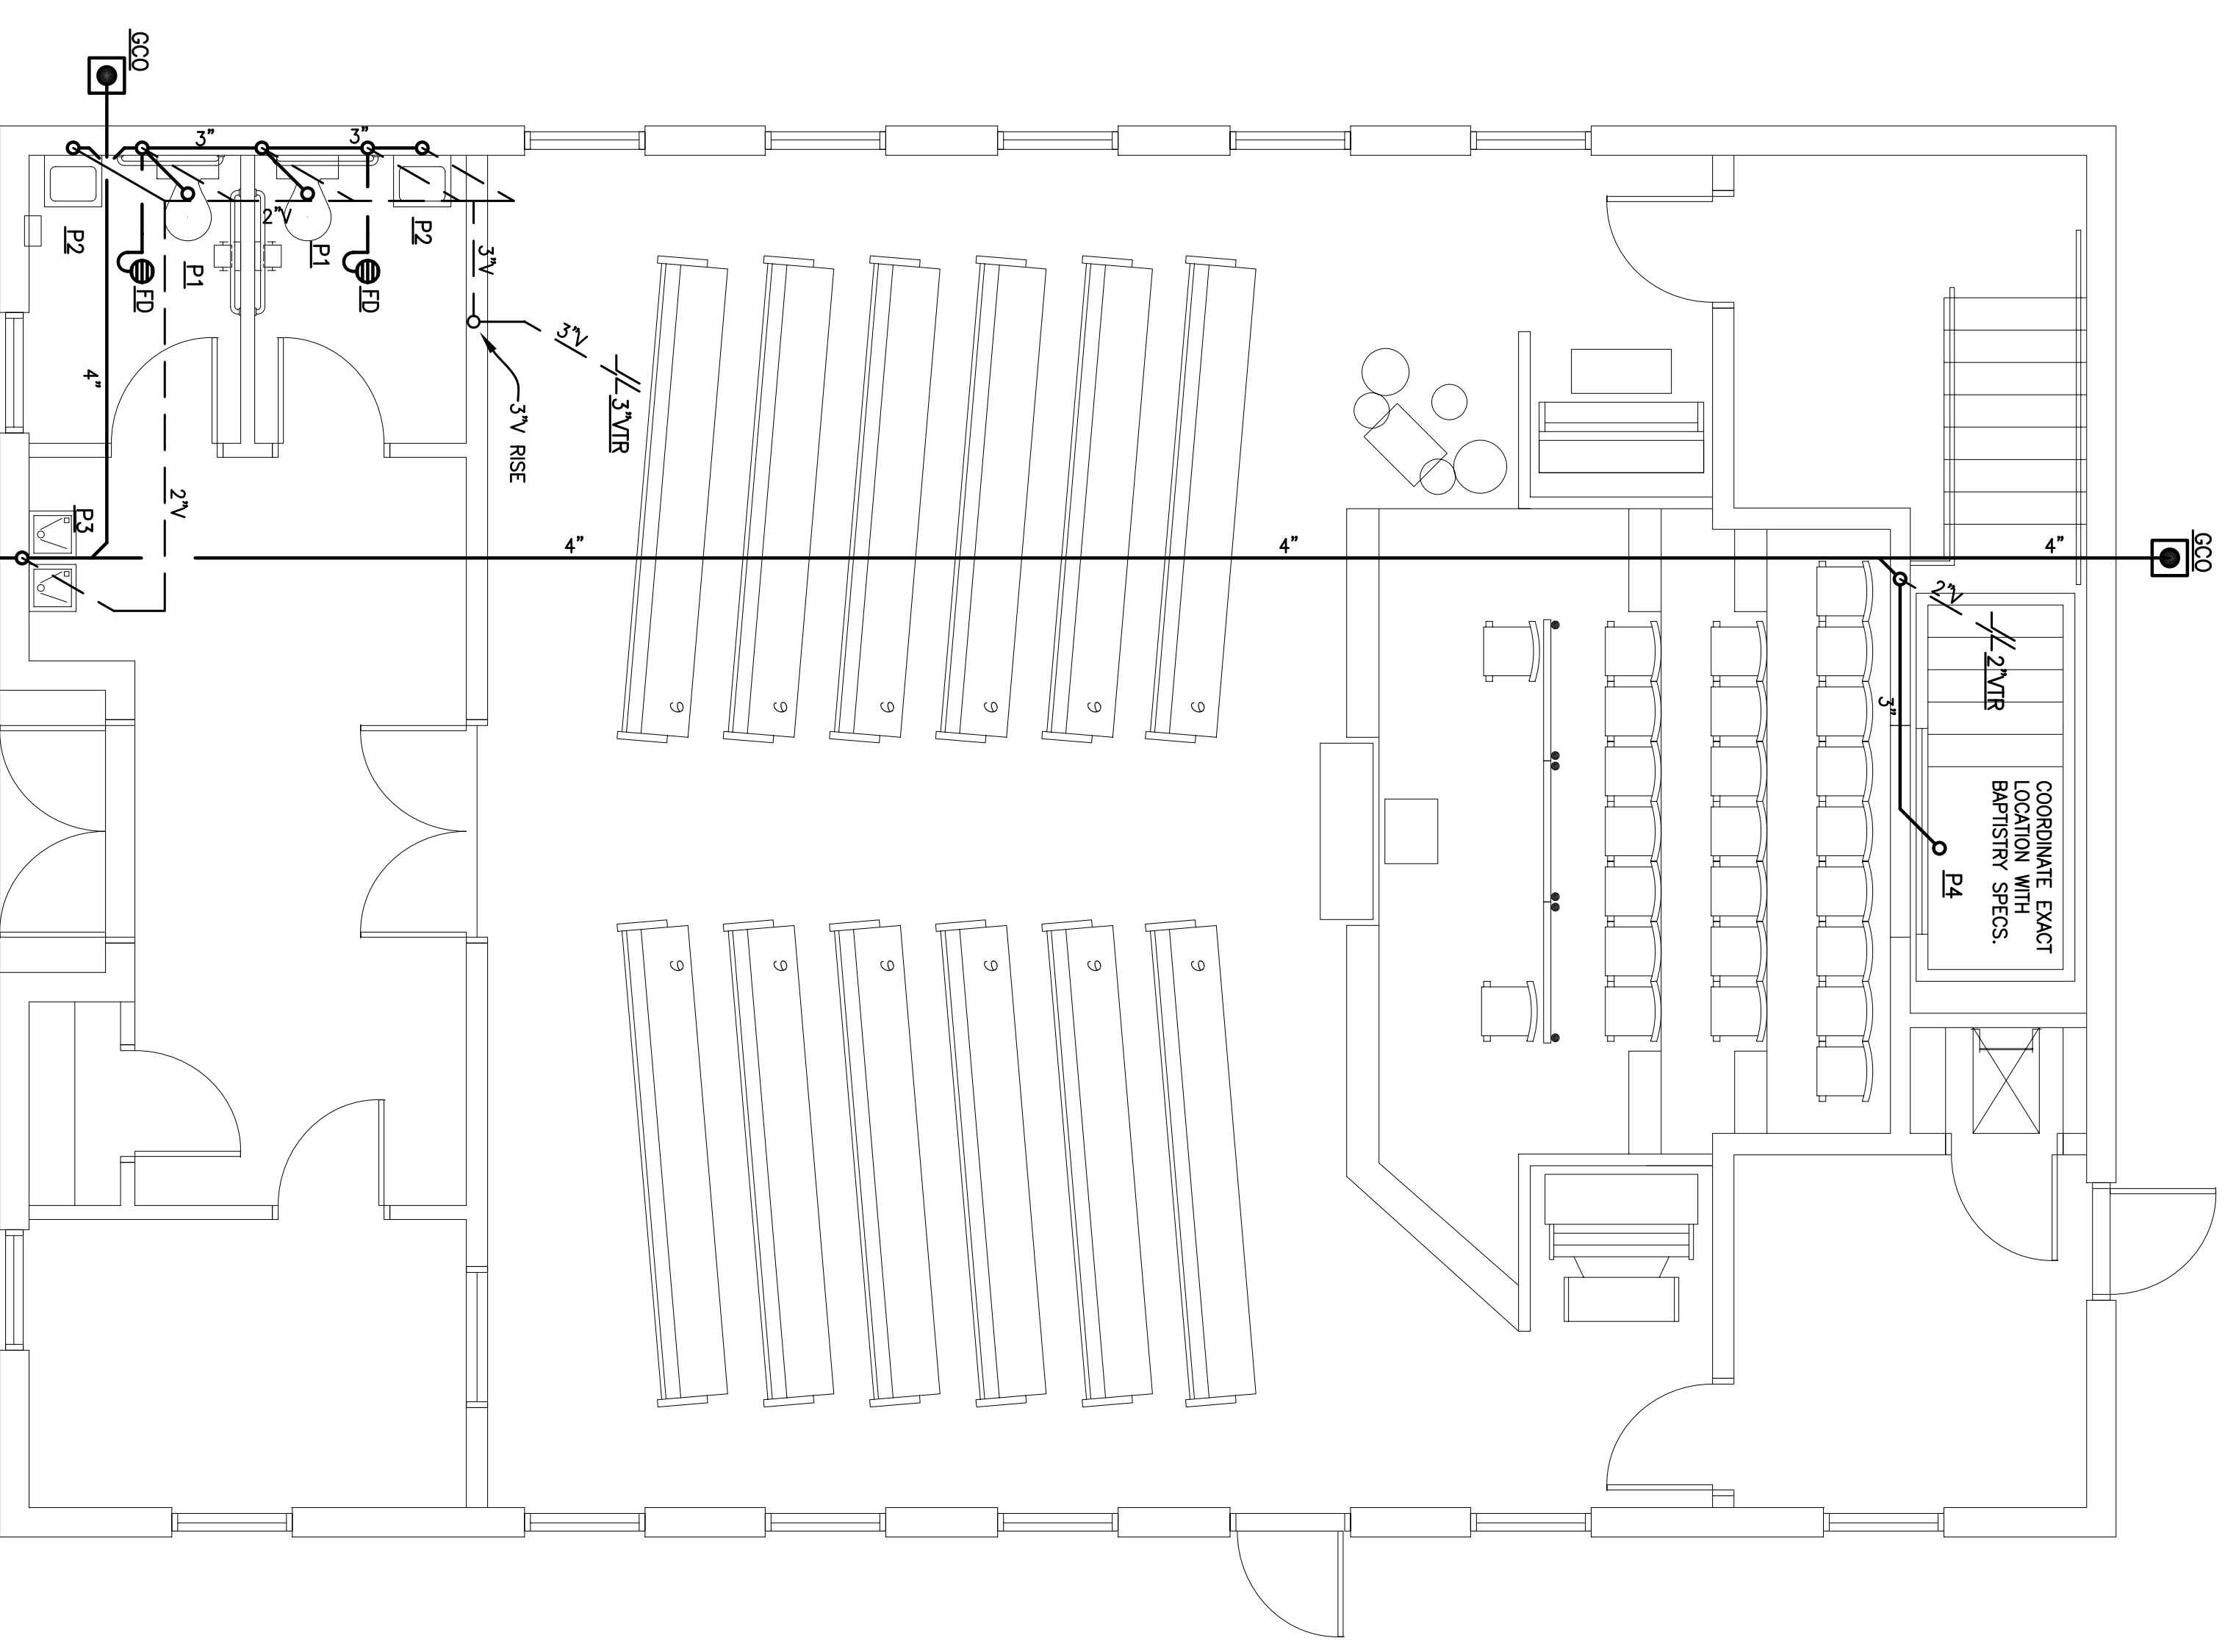

P2.1

PLUMBING PLAN

Date: 10-11-07
 Dwg. By: BAC
 Ck. By: TAV
 File No.: 7.183
 Sheet

Mk.	Date	Description

BEULAHLAND BAPTIST CHURCH
 2436 ST. MAURICE AVENUE
 NEW ORLEANS, LA

Church Interiors Inc.
The Nation's Leading Church Renovation Specialists.
 800 Eastchester Dr. - High Point, NC 27262
 (336) 889-0197 - FAX (336) 885-4949