


ELECTRICAL KEY PLAN


N.T.S.

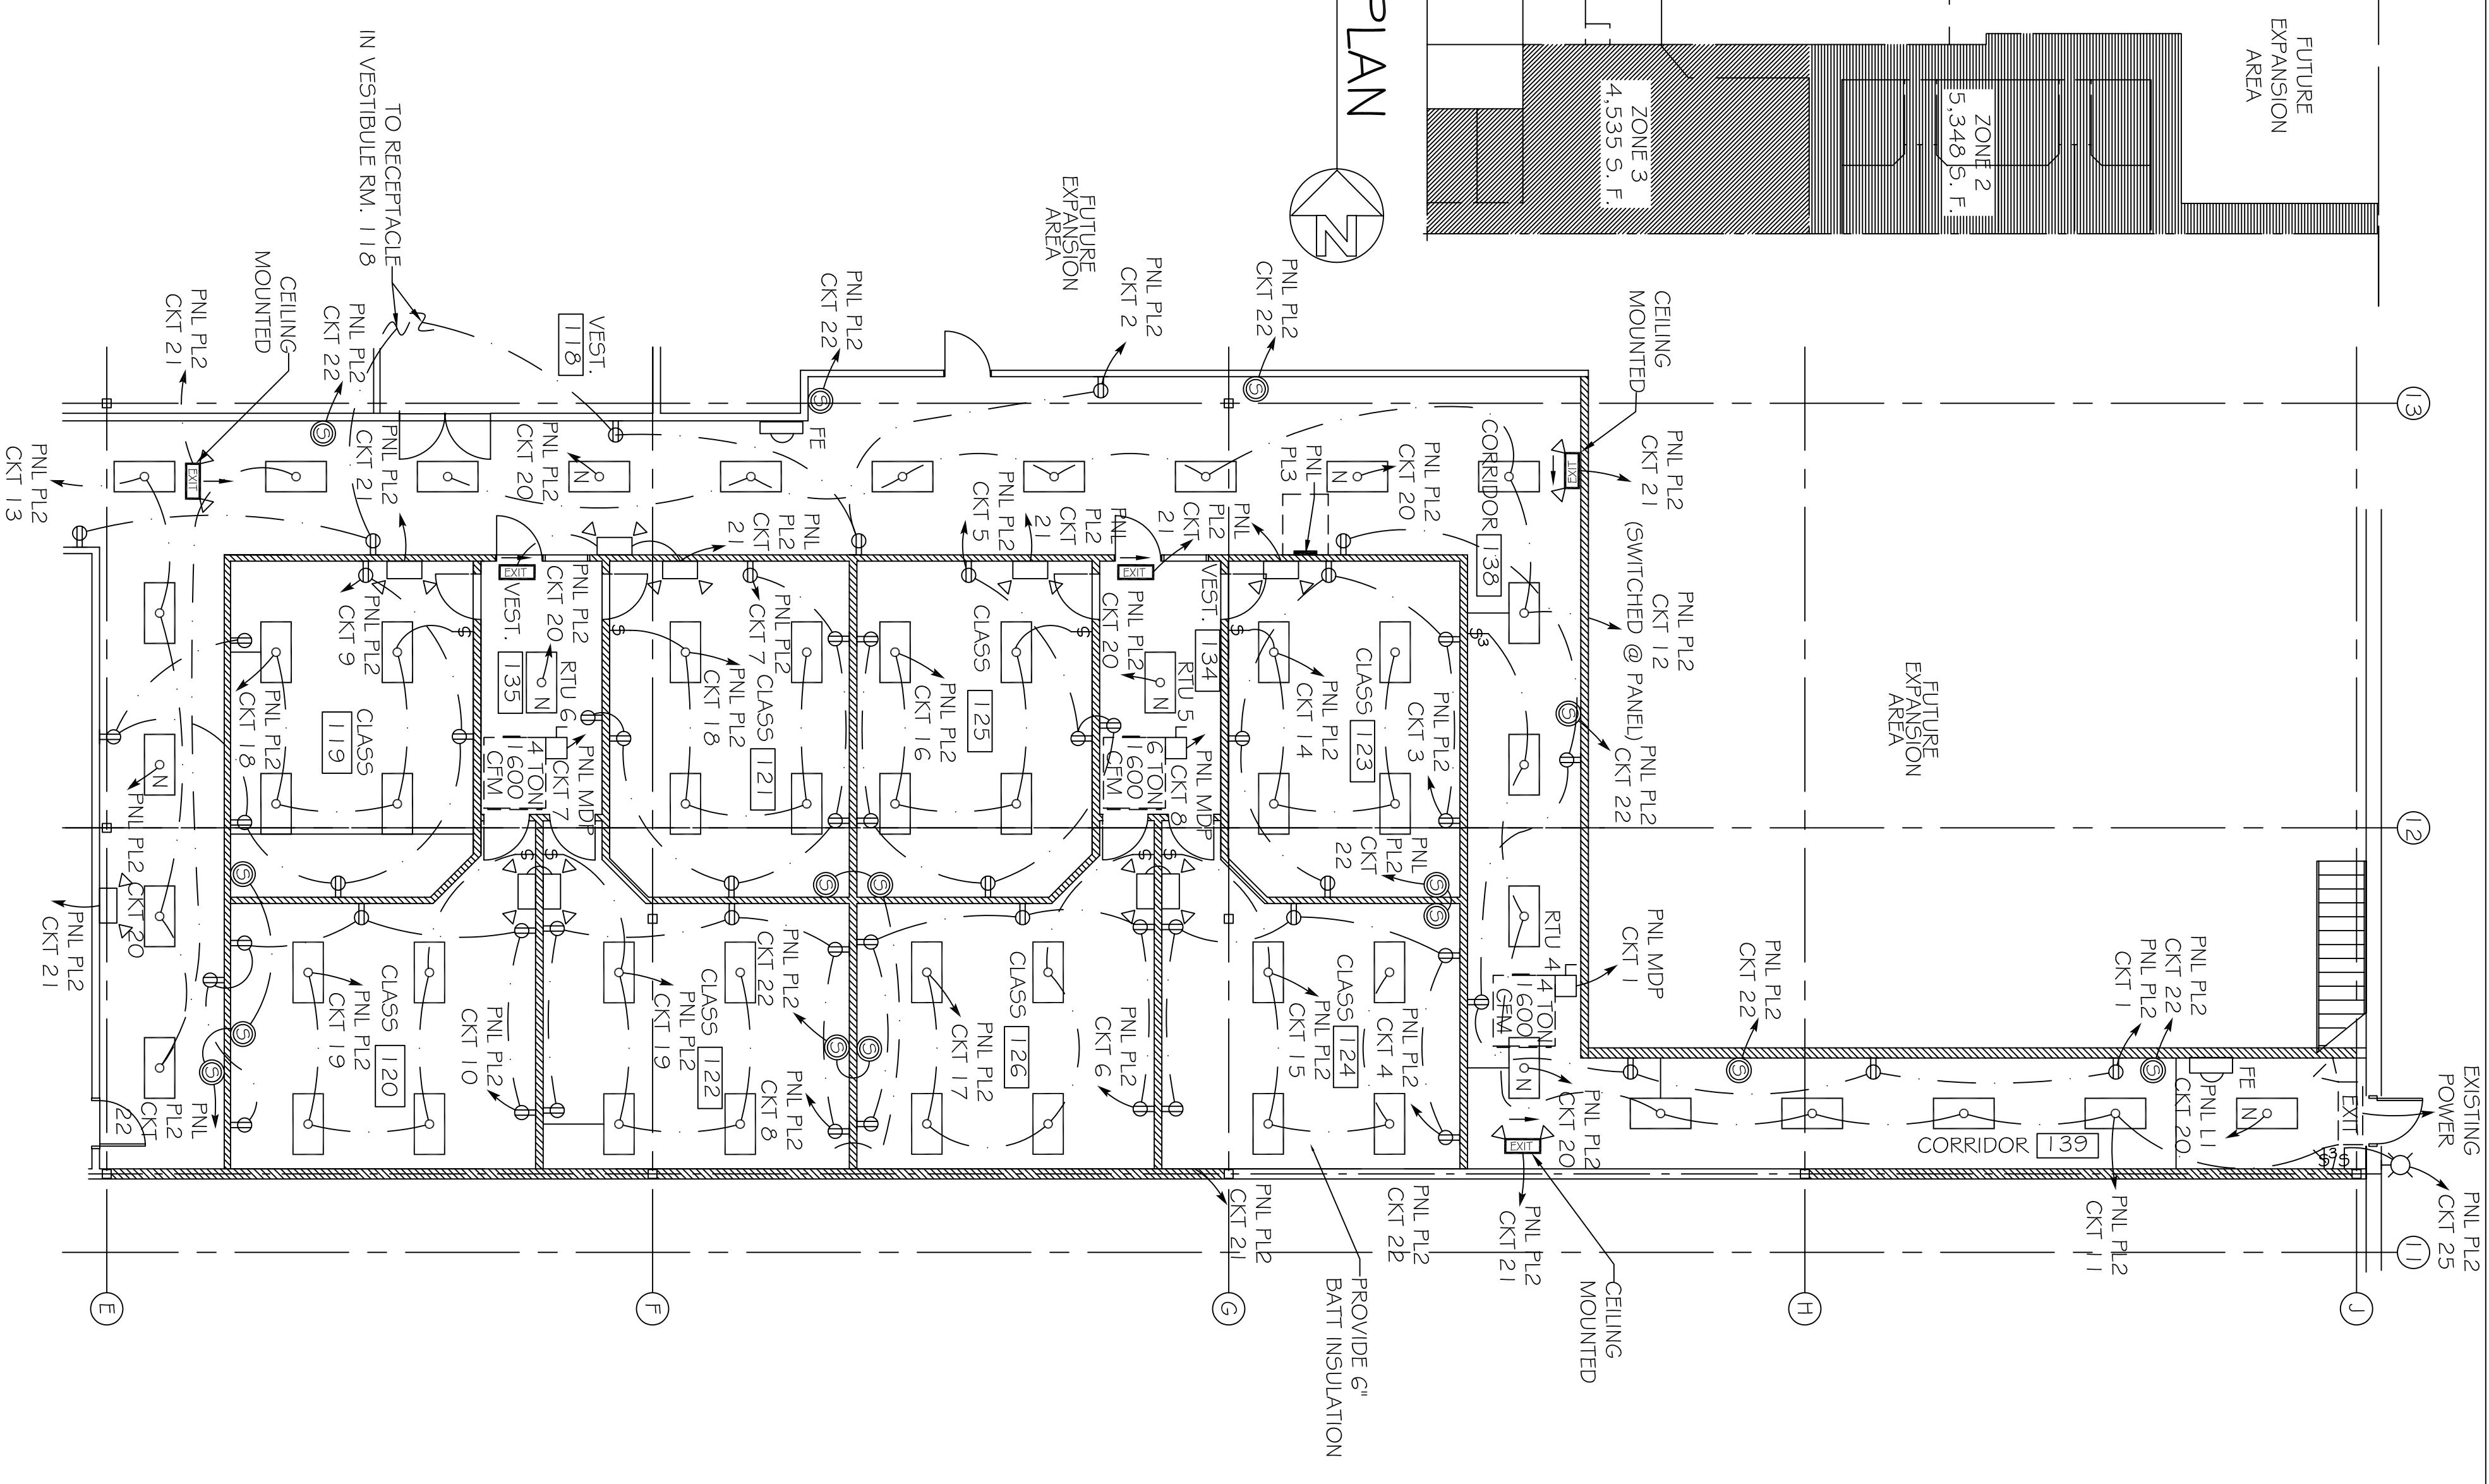

ZONE 2 POWER & LIGHTING PLAN

SCALE: 1/8"=1'-0"

NOTE:
ALL HVAC EQUIPMENT SHOWN IS NEW. EXISTING HVAC EQUIPMENT SHALL BE REMOVED PRIOR TO CONSTRUCTION, UNLESS OTHERWISE NOTED.

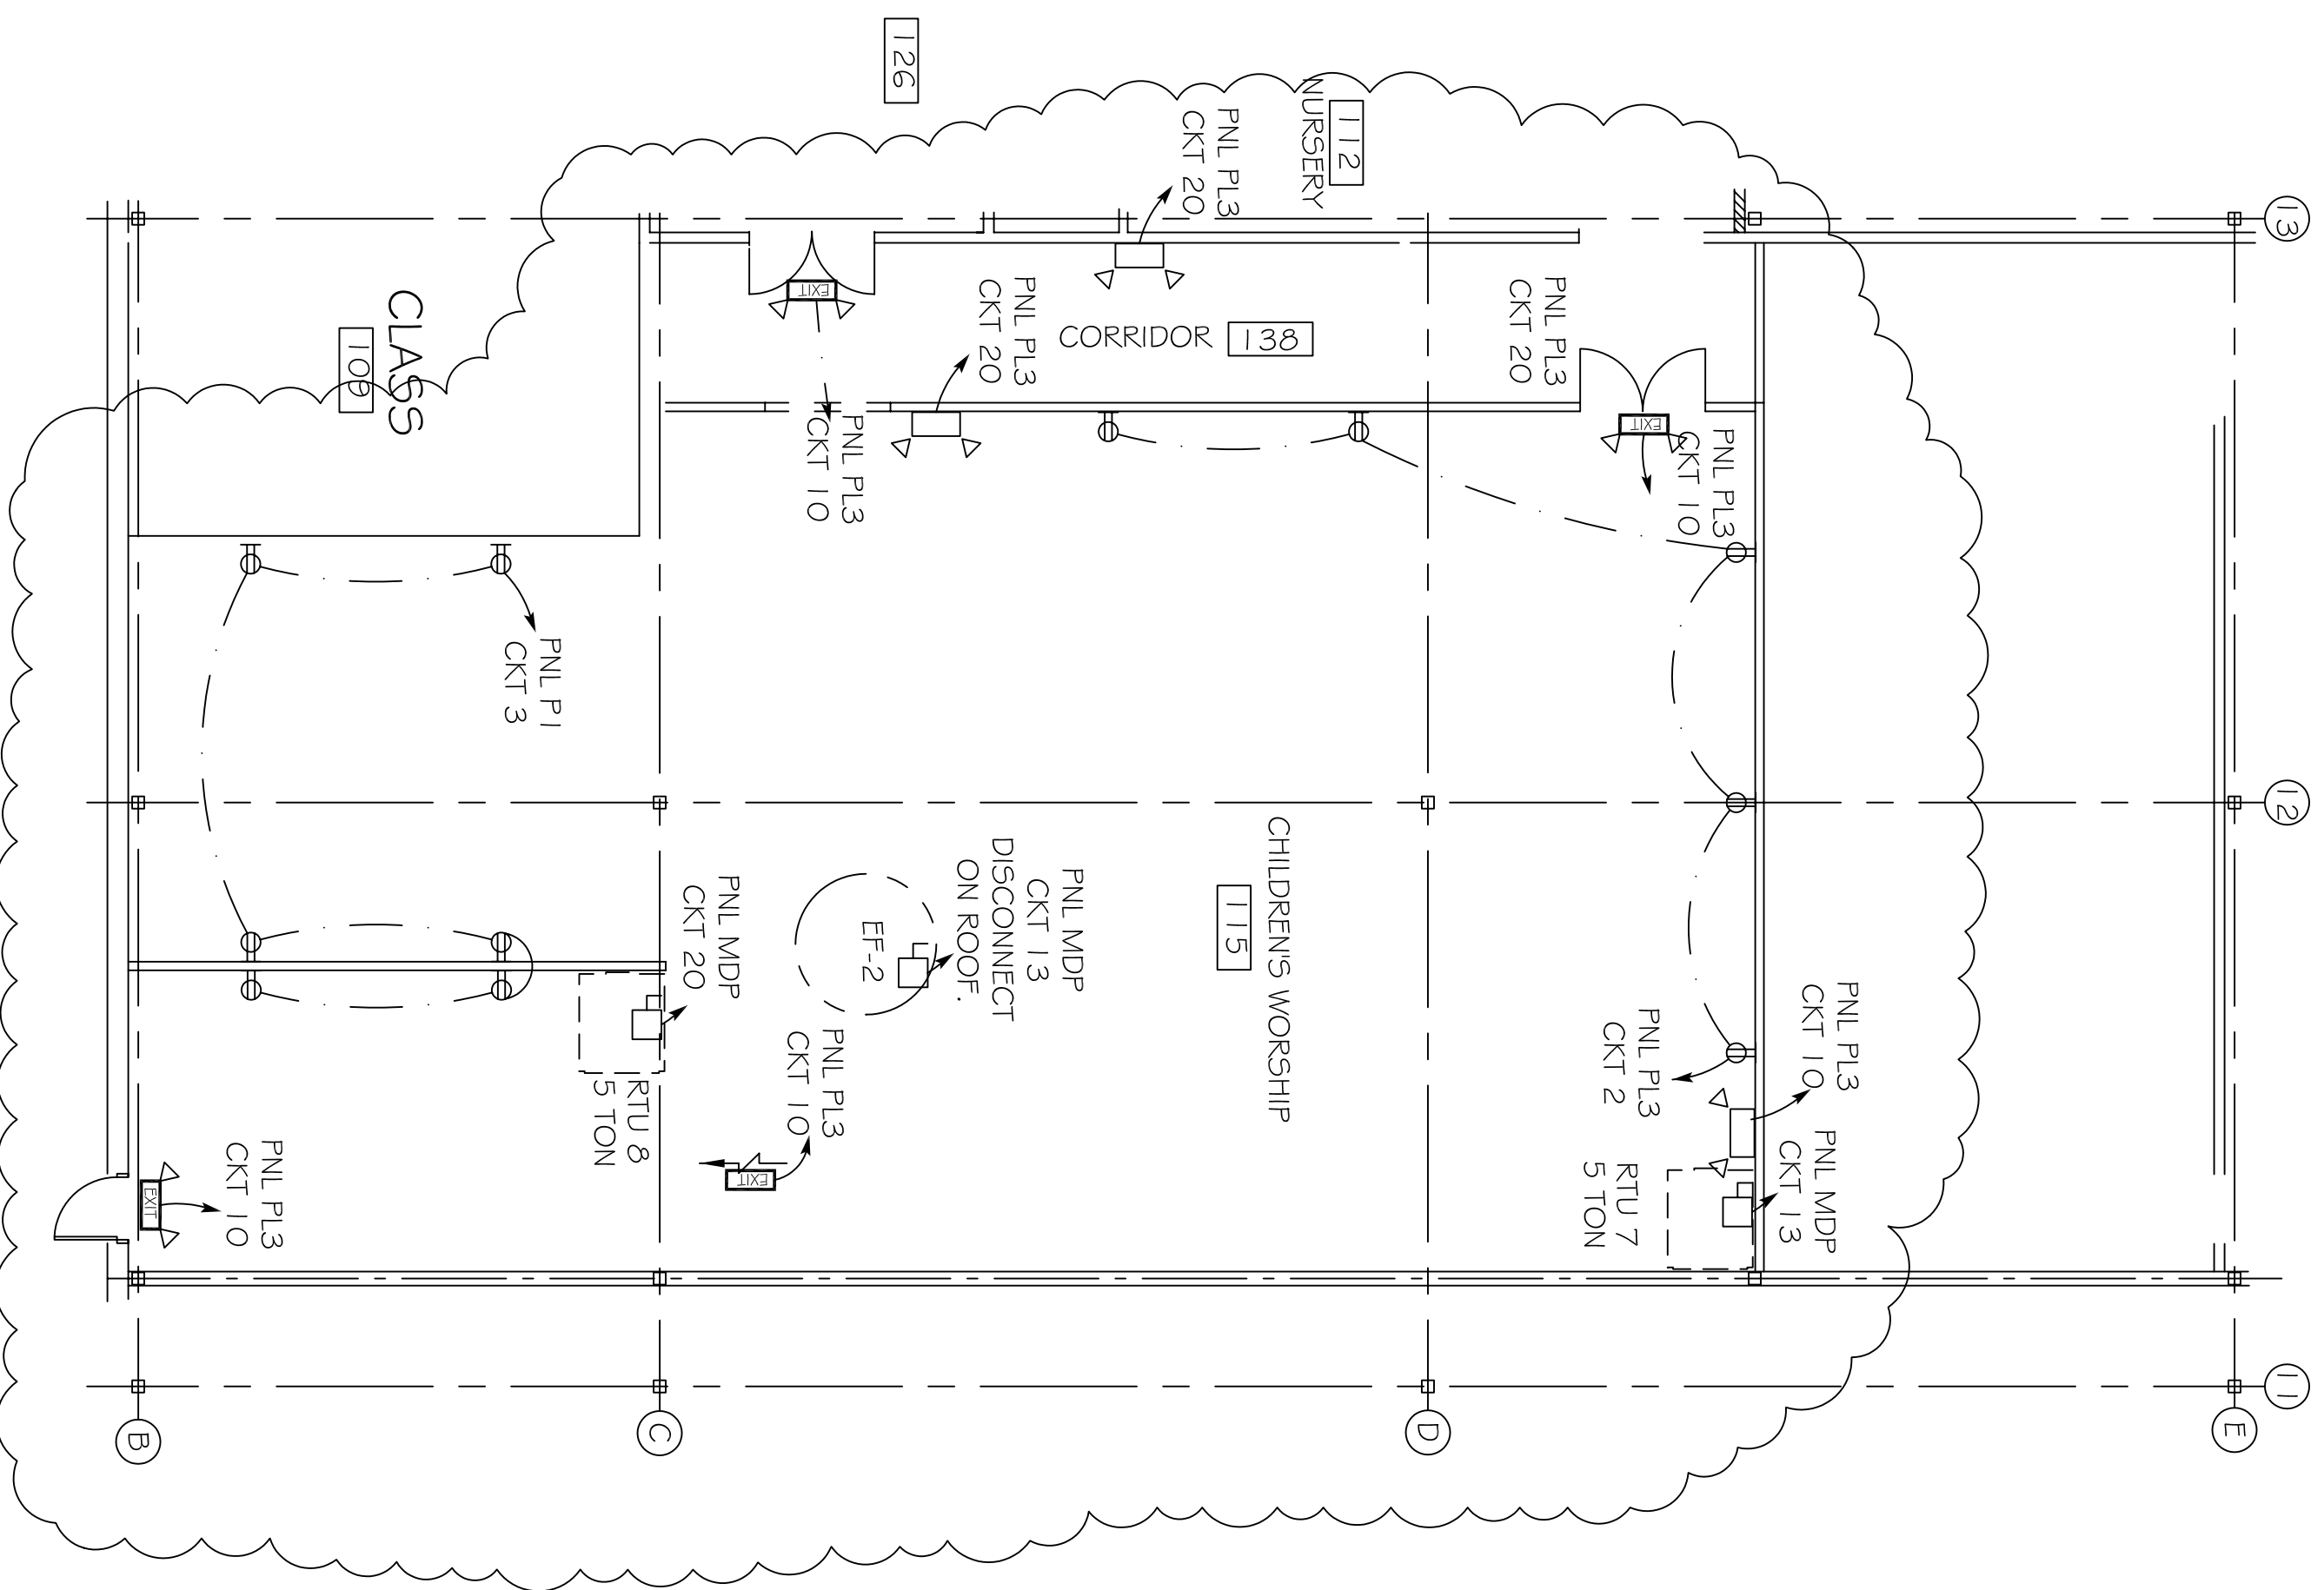


ZONE 3 POWER PLAN

SCALE: 1/8"=1'-0"

LEGEND

- ⌘ - EXISTING SWITCH
- ⌘ - EXISTING 3 WAY SWITCH
- ⌘ - EXISTING 2 X 4 FLUORESCENT FIXTURE
- ⌘ - EXISTING 2 X 4 FLUORESCENT FIXTURE
- ⌘ - EXISTING 2 X 4 FLUORESCENT FIXTURE
- ⌘ - EXISTING 2 X 4 FLUORESCENT FIXTURE
- ⌘ - EXISTING EXIT/ EMERGENCY LIGHT
- ⌘ - EXISTING HALIDE LIGHT
- ⌘ - EXISTING HPS FIXTURE
- ⌘ - EXISTING TELEPHONE/ DATA OUTLET
- ⌘ - EXISTING DUPLEX OUTLET
- ⌘ - EXISTING DUPLEX GFI OUTLET
- ⌘ - EXISTING DUPLEX WEATHERPROOF GFI OUTLET
- ⌘ - EXISTING QUAD OUTLET
- ⌘ - EXISTING 208V OUTLET
- ⌘ - EXISTING WEATHERPROOF 208V OUTLET
- ⌘ - EXISTING DISCONNECT
- ⌘ - EXISTING POWER, LIGHTING PANEL
- ⌘ - EXISTING POWER, LIGHTING PANEL
- ⌘ - SWITCH
- ⌘ - DIMMER SWITCH
- ⌘ - 3 WAY SWITCH
- ⌘ - 2 X 4 FLUORESCENT FIXTURE
- ⌘ - 2 X 4 FLUORESCENT FIXTURE (N INDICATES NIGHT LIGHT- ALWAYS ON)
- ⌘ - CEILING MOUNTED FIXTURE
- ⌘ - EXTERIOR WALL SCONCE FIXTURE w. 90 MIN. BACKUP
- ⌘ - EXIT/ EMERGENCY LIGHT w/ 90 MIN. BACKUP
- ⌘ - EMERGENCY LIGHT w/ 90 MIN. BACKUP
- ⌘ - CABLE TV OUTLET
- ⌘ - TELEPHONE OUTLET
- ⌘ - SMOKE DETECTOR
- ⌘ - VENT
- ⌘ - FIRE EXTINGUISHER AND CABINET- 10 LB. MULTI-USE

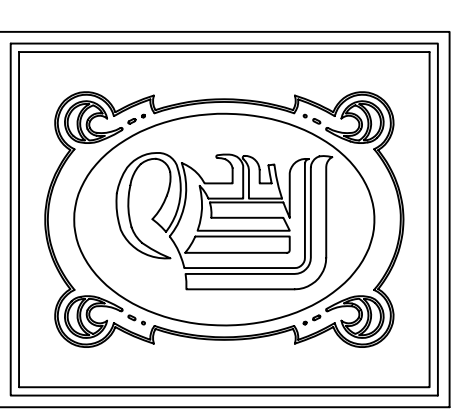

DAMMON ENGINEERING, INC.

CHIEF ENGINEER
EMMETT DAMMON, P.E.
CHIEF ARCHITECT
ROBERT WILTSE

1095 FLORIDA AVENUE
SLIDELL, LA, 70458
OFFICE: 985-649-5632
FAX: 985-641-5950

WWW.DAMMONENGINEERING.COM
EMAIL: DAMMONENG@Bellsouth.net

ARCHITECTURE
ENGINEERING
STUDIES
PLANNING
INVESTIGATION
EXPERT WITNESSES

NORTHSHORE CHURCH
KENSINGTON DR.
SLIDELL, LA

ZONES 2 & 3 POWER & LIGHTING PLAN

REV: #3 11-2-09

SCALE: AS NOTED

JOB#: 1988

DATE: 09-30-08

SHEET

E-5

OF