

DAMMON
ENGINEERING, INC.

CHIEF ENGINEER
EMMETT
DAMMON, P.E.

CHIEF ARCHITECT
ROBERT
WILTSE

554 OLD SPANISH TRAIL
SLIDELL, LA. 70458
OFFICE: 985-649-5832
FAX: 985-641-5950


WEBSITE:
WWW.DAMMONENGINEERING.COM

EMAIL:
DAMMONENG@BELLSOUTH.NET

ARCHITECTURE
ENGINEERING
STUDIES
PLANNING
INVESTIGATION
EXPERT WITNESS

BRIAN FONG, M.D. Inc.
MEDICAL OFFICE
2965 GAUSE BLVD.
SLIDELL, LA

LIGHTING
PLAN

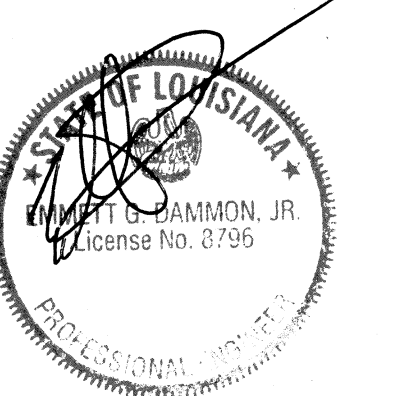

REV:

SCALE: AS NOTED


JOB#: 2132

DATE: 04-17-12

SHEET 9

E-2

OF 12

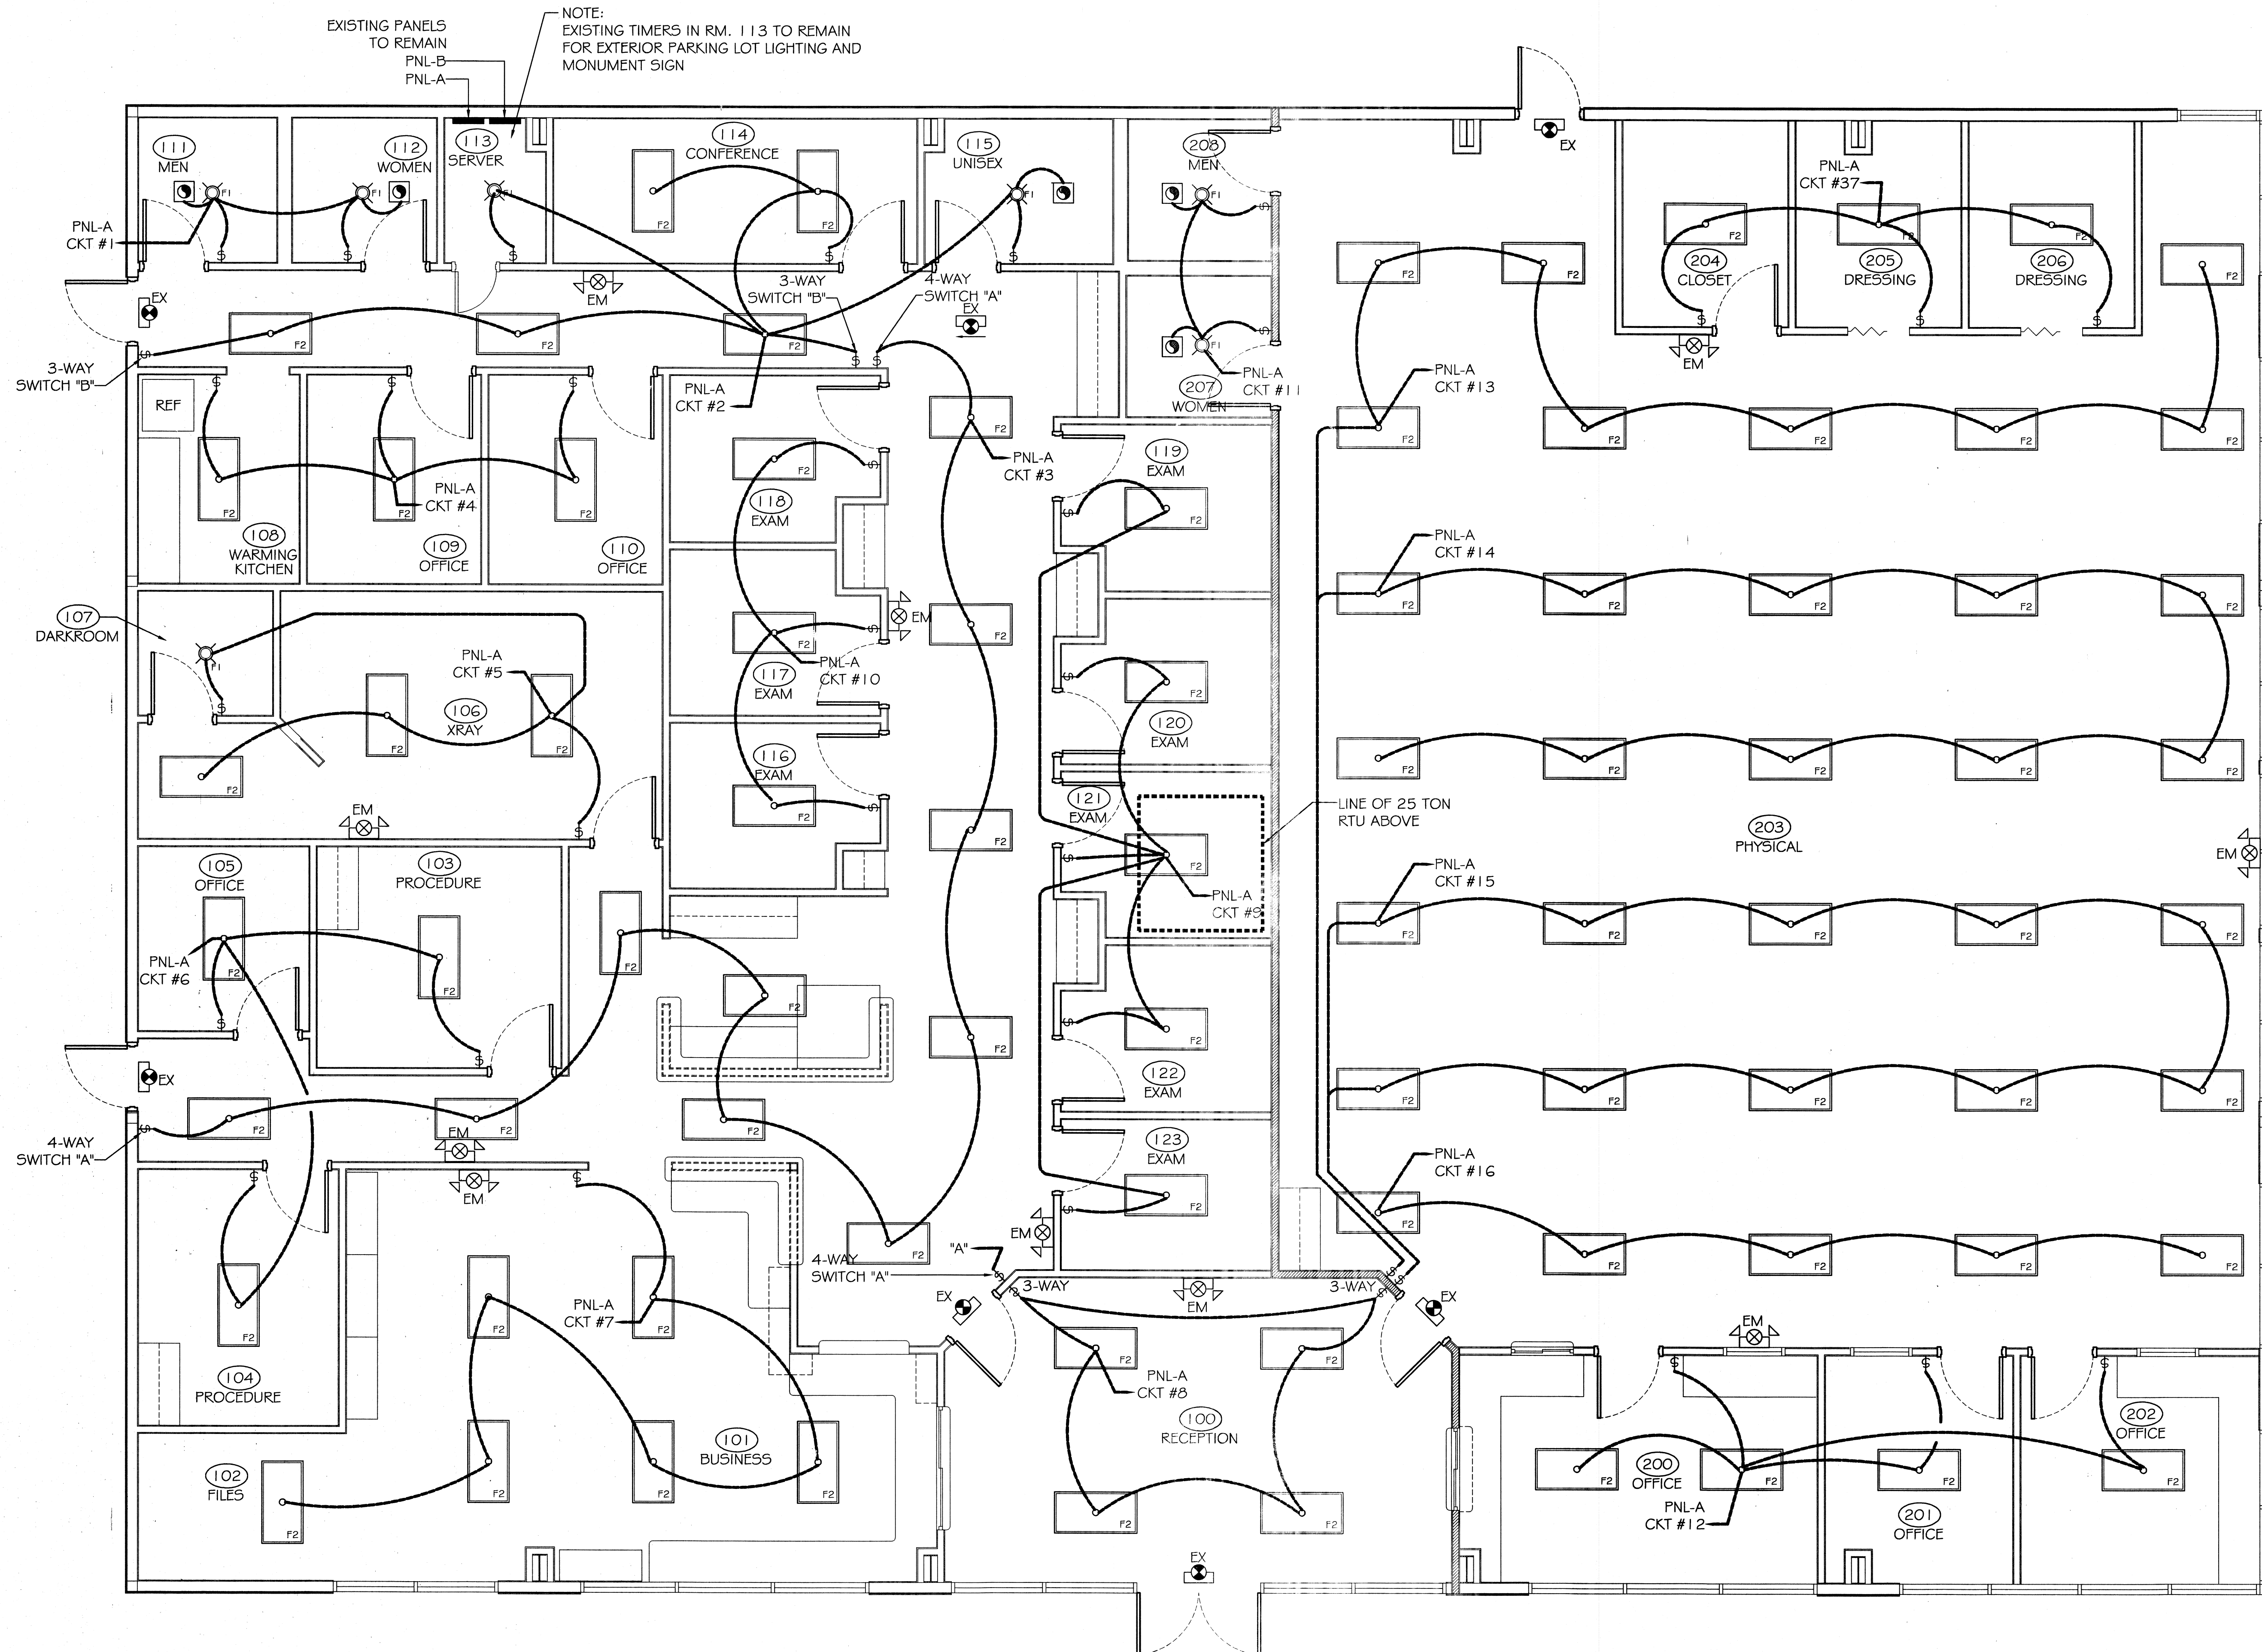

LIGHTING PLAN
SCALE: 1/4" = 1'-0"

NOTE:
SEE SHEET E-3 FOR LIGHTING FIXTURE SCHEDULE,
PANEL SCHEDULES, AND ELECTRICAL NOTES.