


**GENERAL NOTES**

1. AREAS WITHOUT CEILING PATTERN INDICATES AREAS EXPOSED TO EXISTING ROOF CONSTRUCTION. THESE AREAS TO RECEIVE BLACK PAINT TREATMENT.
2. SEE ELECTRICAL DRAWINGS FOR LIGHT FIXTURE SPECIFICATIONS FOR OPEN AREAS.
3. SEE ELECTRICAL DRAWINGS FOR SWITCHING AND CIRCUITRY.

**FIXTURE SCHEDULE**

- 2' x 2' FLUORESCENT
- 4' FLUORESCENT STRIP
- 100W LED PENDANT FIXTURE ON DIMMER
- 8" DIAM. RECESSED LED ON DIMMER
- CHANDELIER AS SELECTED BY OWNER
- EMERGENCY EXIT SIGN, DIRECTION OF SIGN
- EMERGENCY LIGHT
- EXHAUST FAN/LIGHT

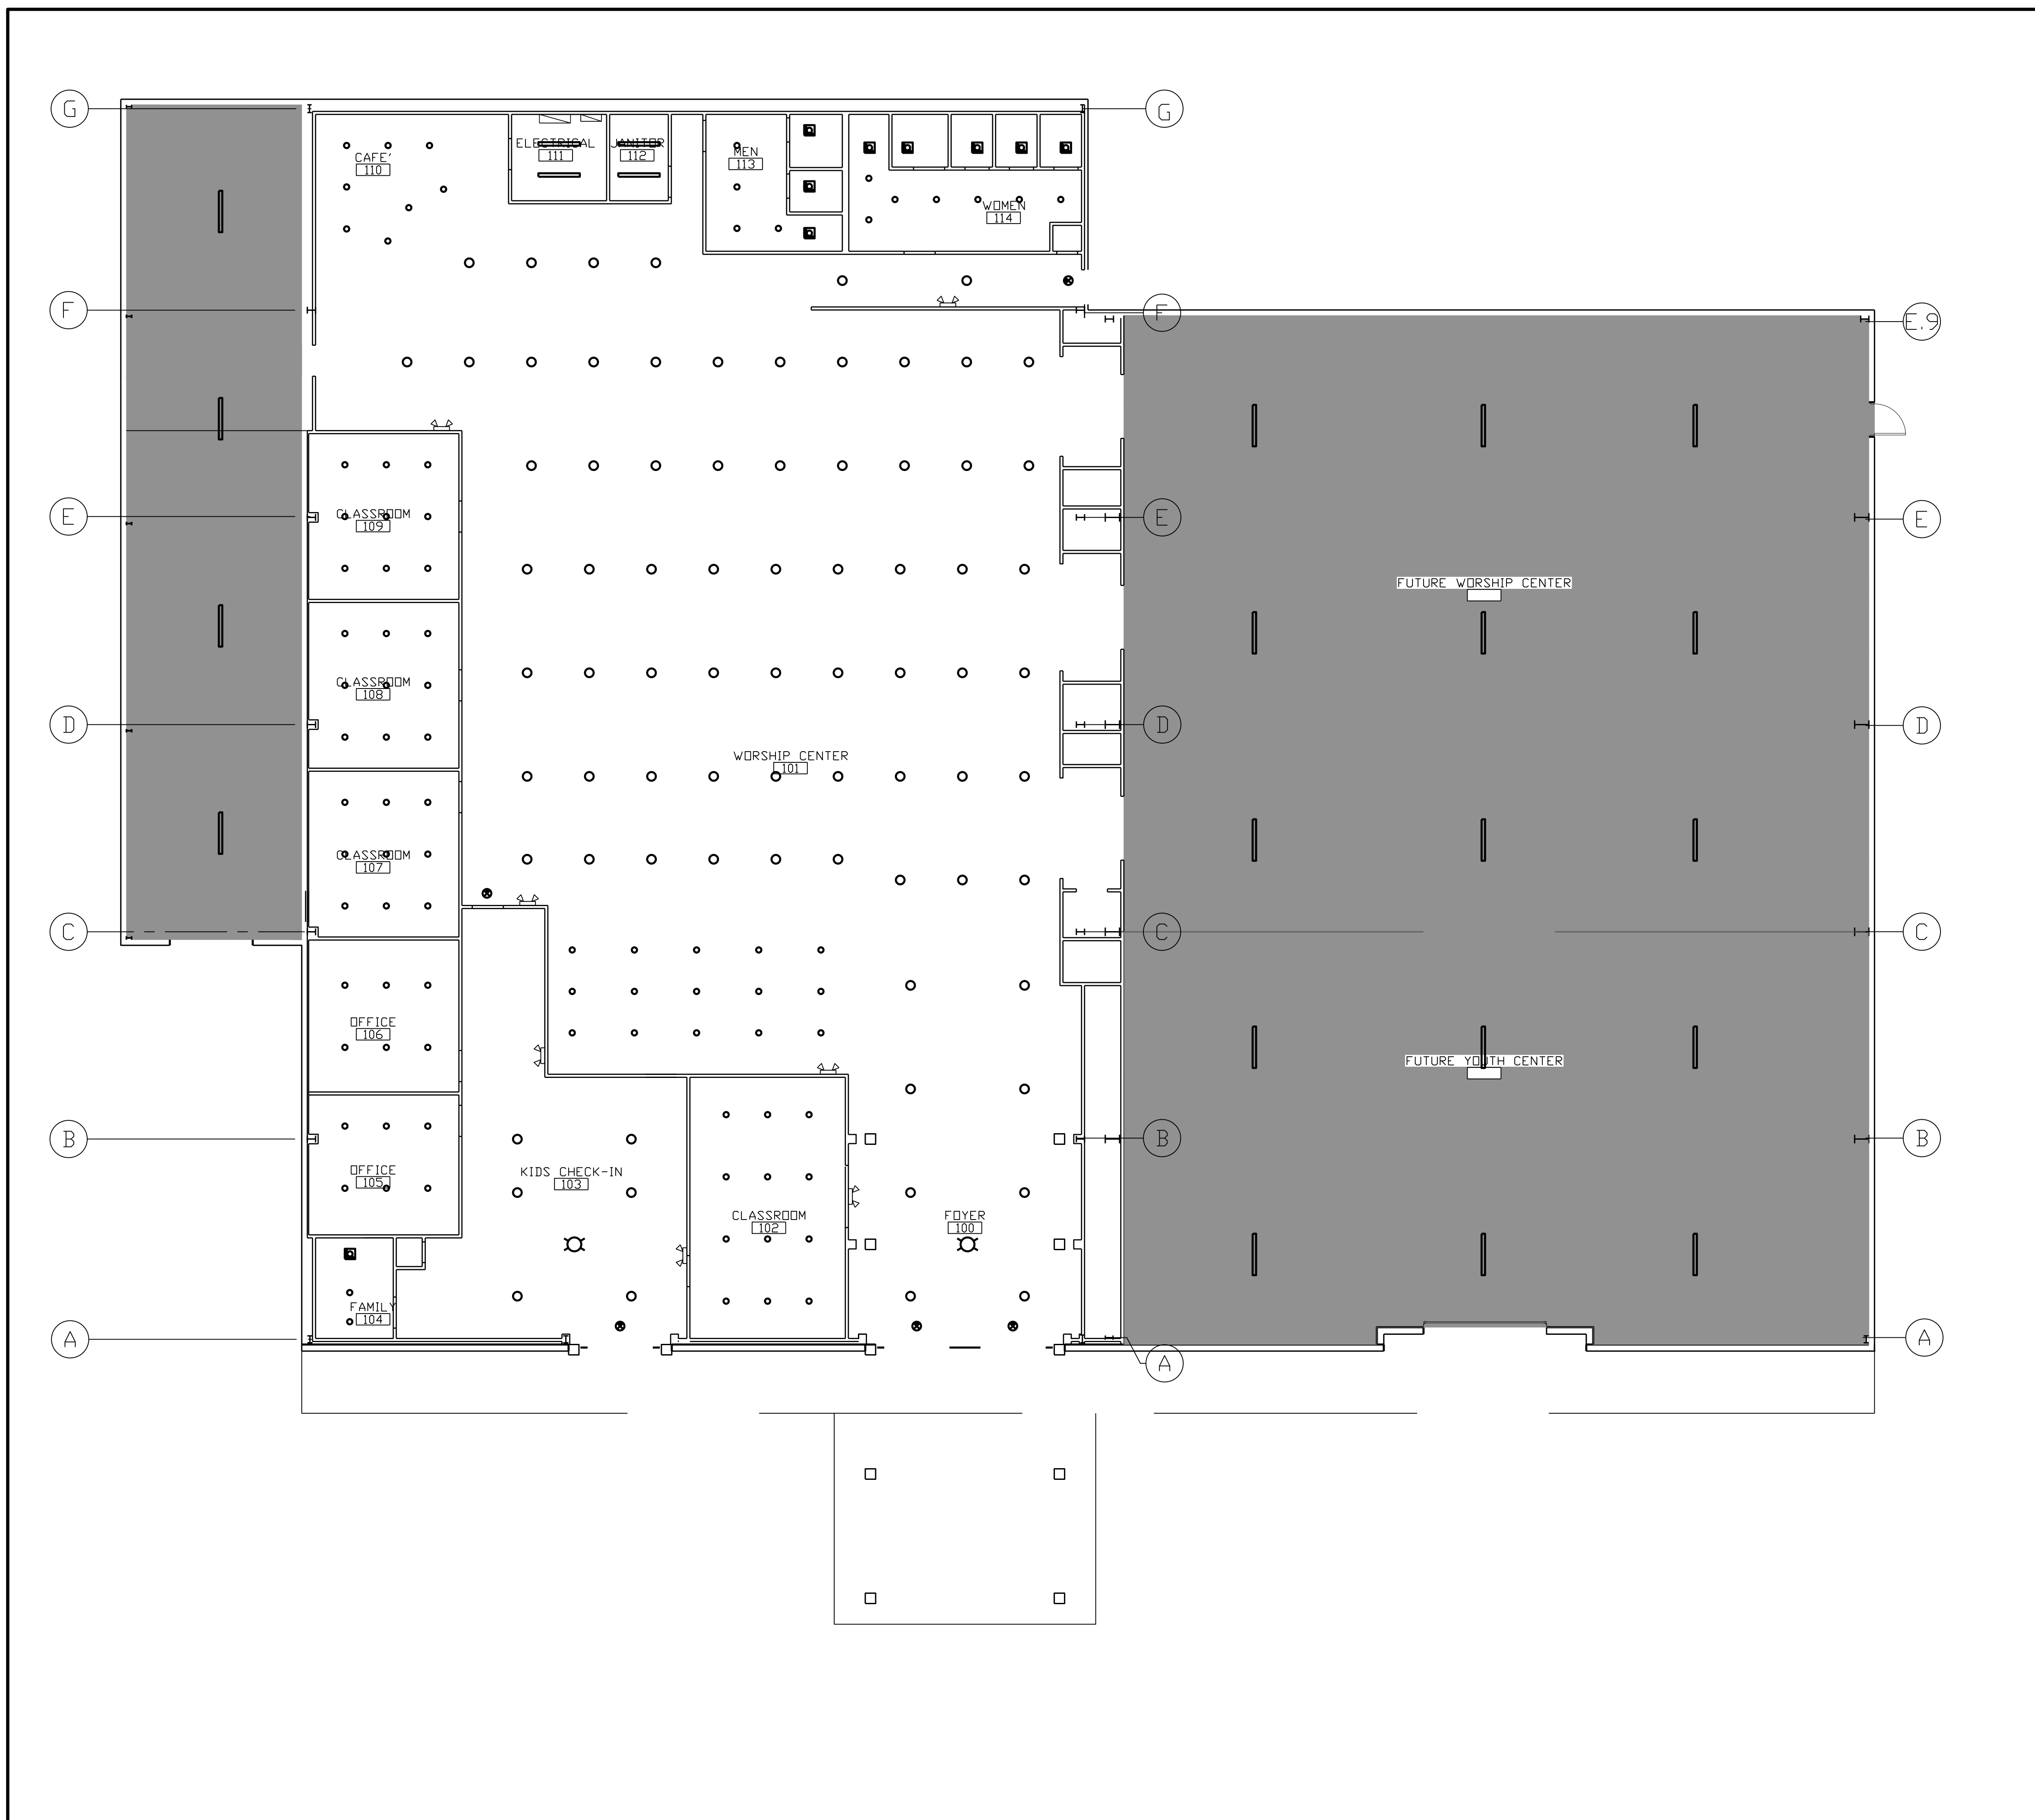

**NEW WORSHIP CENTER**  
**GRACE FELLOWSHIP CHURCH**  
 34492 WILLIS ALLEY  
 TOWN OF PEARL RIVER, LOUISIANA 70451

These drawings contain proprietary and confidential information that is the intellectual property of Kravet, LLC. Reproduction and use of these documents or the underlying design concepts contained therein without the prior and written permission of Kravet, LLC, is prohibited.

These drawings and specifications have been prepared under my close personal supervision and to the best of my knowledge they comply with all local and state requirements. I Will / Will Not be observing the work.

PROJECT NO. 16.0104.00	
DRAWN BY: RSK	
CHECKED BY:	
DATE	PHASE
15 April 16	Construction Documents

REFLECTED CEILING PLAN  
A9.00

504.220.4649