

GENERAL NOTES


- AREAS WITHOUT CEILING PATTERN INDICATES AREAS EXPOSED TO EXISTING ROOF CONSTRUCTION. THESE AREAS TO RECEIVE BLACK PAINT TREATMENT.
- SEE ELECTRICAL DRAWINGS FOR LIGHT FIXTURE SPECIFICATIONS FOR OPEN AREAS.
- SEE ELECTRICAL DRAWINGS FOR SWITCHING AND CIRCUITRY.

FIXTURE SCHEDULE

- 2' x 2' FLUORESCENT
- 4' FLUORESCENT STRIP
- 100W LED PENDANT FIXTURE ON DIMMER
- 8' DIAM. RECESSED LED ON DIMMER
- CHANDELIER AS SELECTED BY OWNER
- EMERGENCY EXIT SIGN, DIRECTION OF SIGN
- EMERGENCY LIGHT
- EXHAUST FAN/LIGHT

GENERAL NOTES

- WORK UNDER THESE DOCUMENTS IS LIMITED TO THE RENOVATION OF EXISTING BUILDING INTERIOR SPACES FOR A NEW ASSEMBLY OCCUPANCY AND THE INSTALLATION OF NEW STOREFRONT ENTRANCE SYSTEMS. ALL EXISTING STRUCTURAL SYSTEMS AND BUILDING CLADDING ARE NOT PART OF THE WORK AND ANY MODIFICATIONS TO THIS EXISTING CONSTRUCTION SHALL BE PER THE RECOMMENDATIONS OF THE ORIGINATING MANUFACTURER. ALL MODIFICATIONS TO THE EXISTING STRUCTURAL CONCRETE SLAB SHALL BE PER THE REVIEW OF A LICENSED STRUCTURAL ENGINEER.
- CONTRACTOR SHALL VERIFY THE EXISTENCE AND LOCATION OF ALL SITE UTILITIES AND PROVIDE NEW UTILITIES AS REQUIRED PER THESE DOCUMENTS.
- CONTRACTOR TO PROVIDE SITE AND BUILDING DRAINAGE SYSTEMS PER MUNICIPAL REQUIREMENTS.
- CONTRACTOR TO PROVIDE A FULLY COMPLIANT FIRE PROTECTION SYSTEM PER NFPA 13 AND FIRE ALARM SYSTEM PER NFPA 70 AND 72 AND SMOKE DETECTION SYSTEM IN UNOCCUPIED SPACES. SIGNED AND SEALED DRAWINGS AND SPECIFICATIONS SHALL BE PROVIDED TO THE AUTHORITIES HAVING JURISDICTION FOR APPROVAL.
- ALL INTERIOR PLAN DIMENSIONS ARE TO THE FACE OF STUD, U.N.O.
- ALL DIMENSIONS ARE SUBJECT TO FIELD VERIFICATION OF EXISTING CONDITIONS.
- FIRE EXTINGUISHERS: FEC-A EQUIVALENT TO JL INDUSTRIES COSMIC SE (UL 3A-40BC) ON WALL BRACKET; FEC-B EQUIVALENT TO JL INDUSTRIES COSMIC SE (UL 3A-40BC) INSTALLED IN JL INDUSTRIES AMBASSADOR CABINET #8117-w-10-WHITE.

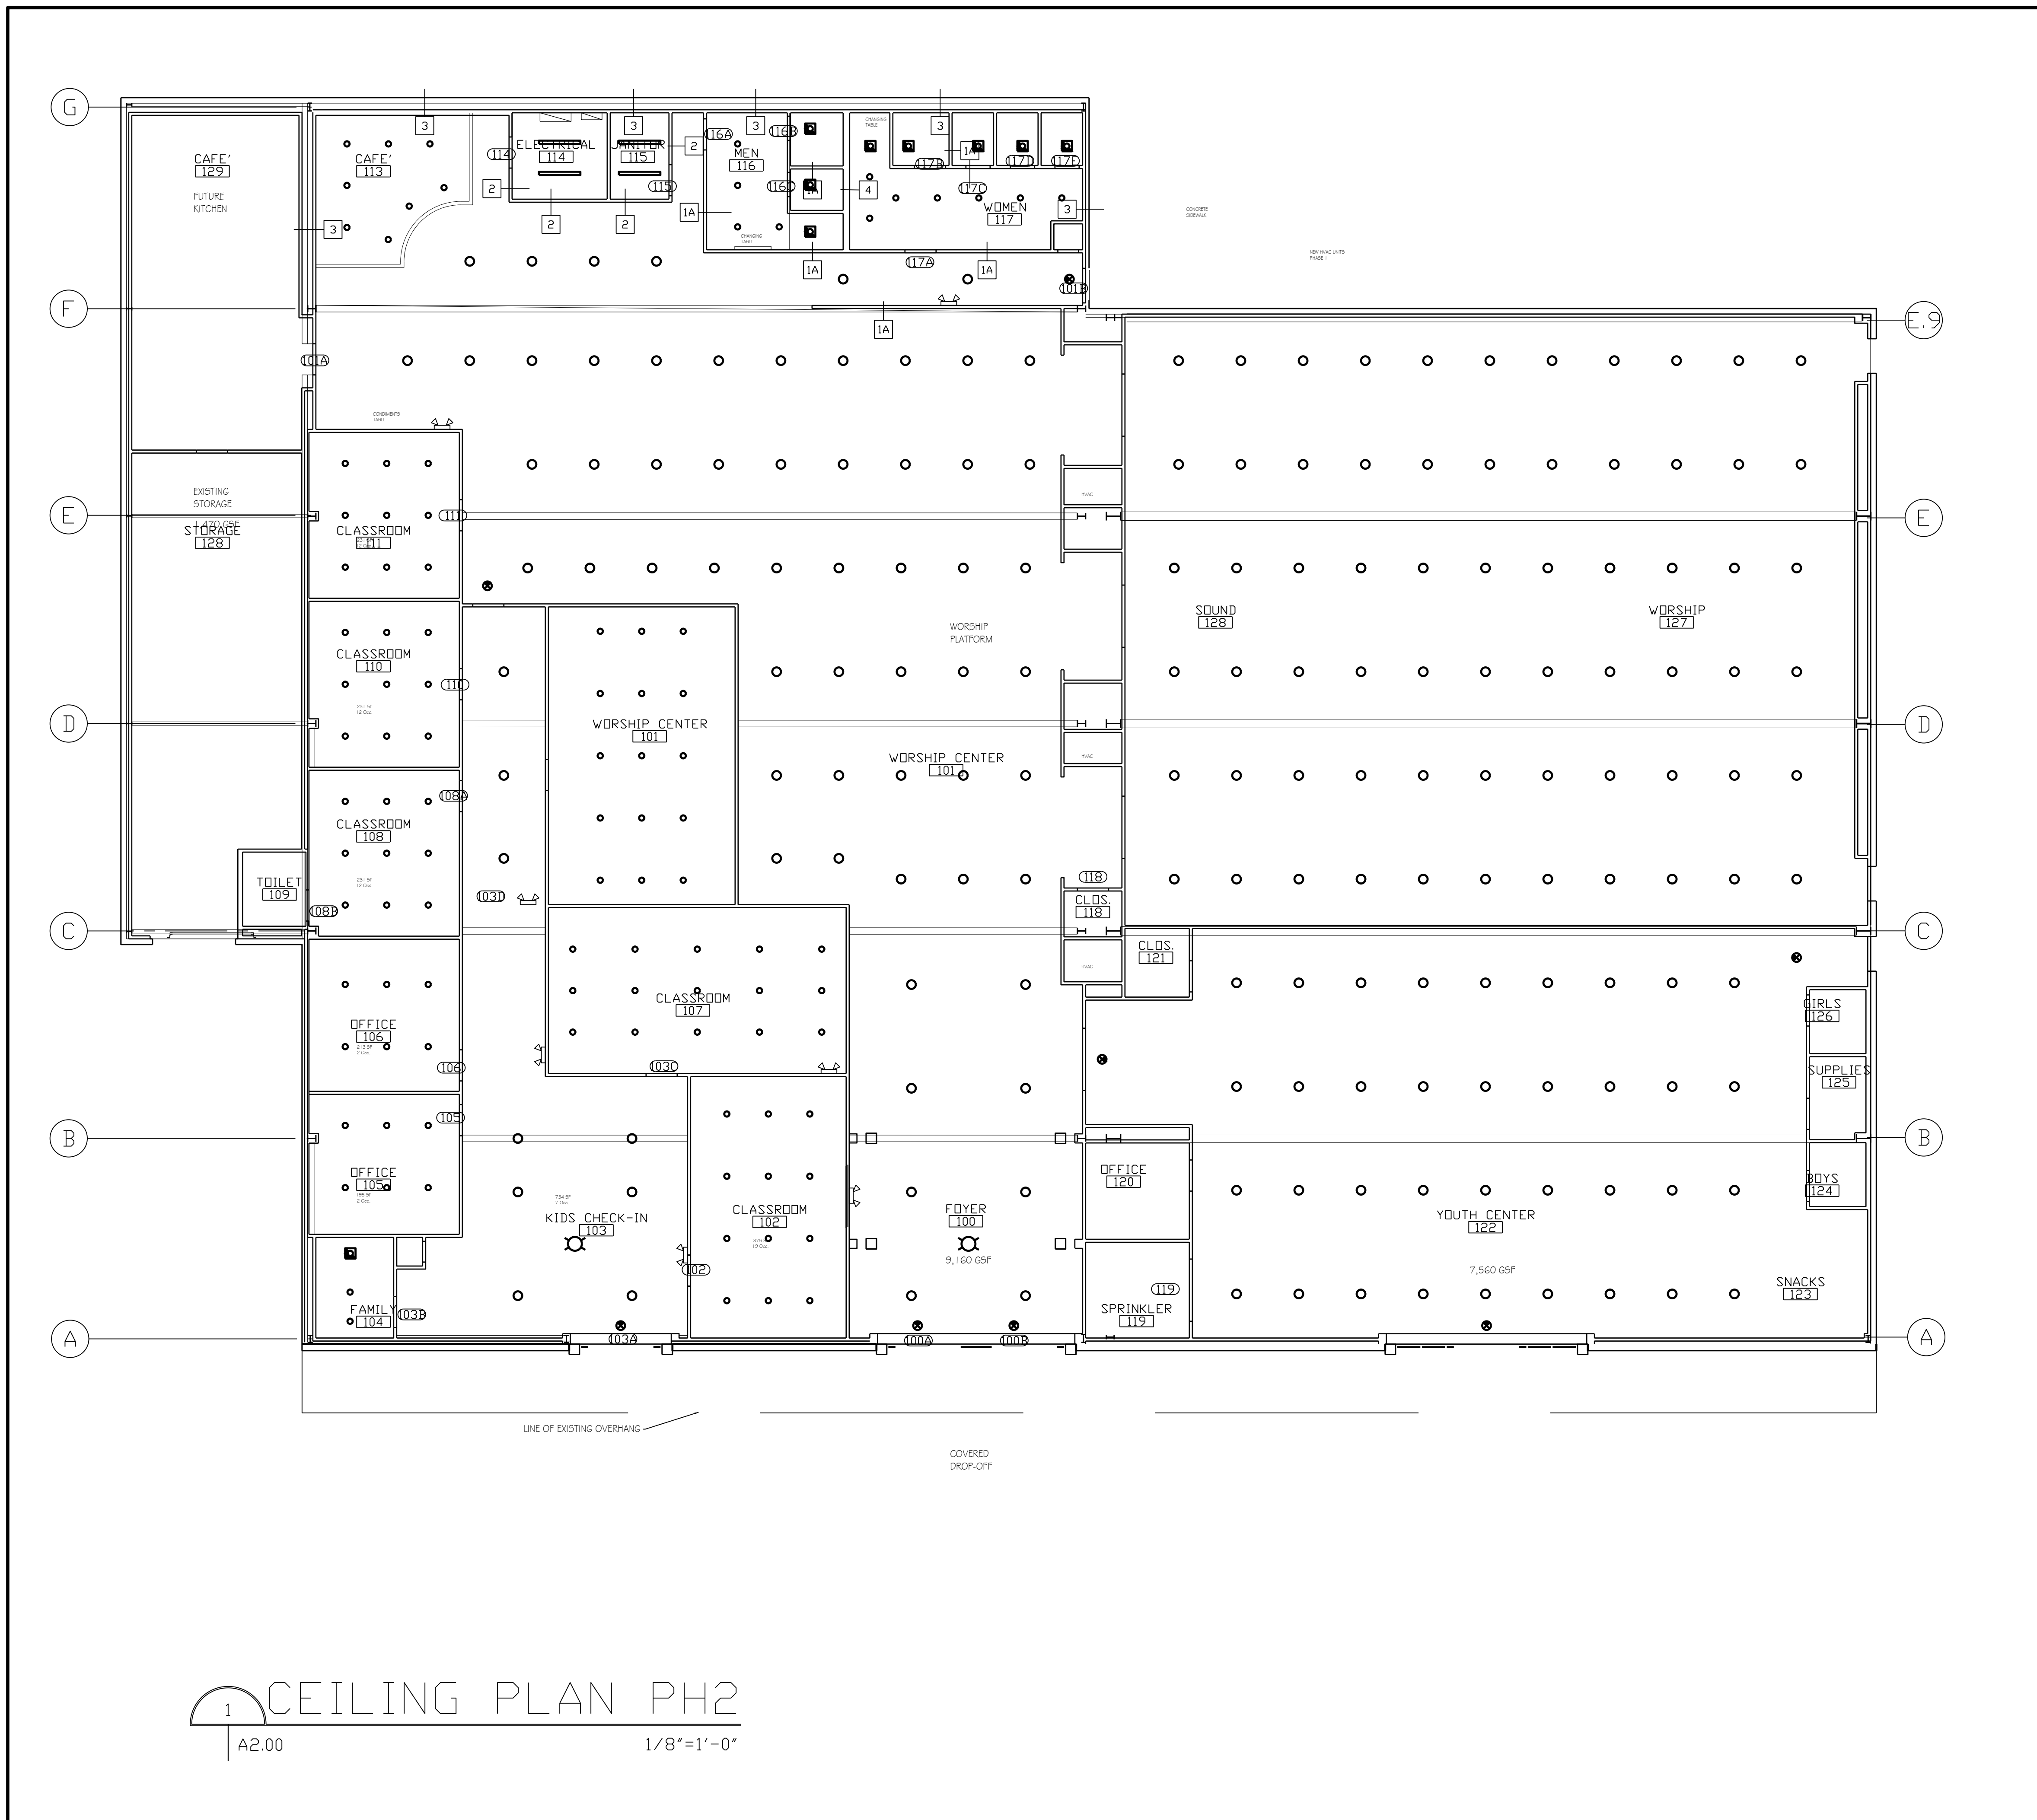

1 CEILING PLAN PH2
A2.00 1/8"=1'-0"

KRAVET



Richard S. Kravet, AIA, NCARB
www.kravetarchitects.com

504.220.4649

**NEW WORSHIP CENTER
GRACE FELLOWSHIP CHURCH**

34492 WILLIS ALLEY
TOWN OF PEARL RIVER, LOUISIANA 70451

These drawings contain proprietary and confidential information that is the intellectual property of Kravet, LLC. Reproduction and use of these documents or the underlying design concepts contained therein without the prior and written permission of Kravet, LLC is prohibited.

These drawings and specifications have been prepared under my close personal supervision and to the best of my knowledge they comply with all local and state requirements. I Will / Will Not be observing the work.

PROJECT NO. 16.0104.00	
DRAWN BY: RSK	
CHECKED BY:	
DATE	PHASE
15 April 16	Construction Documents

REFLECTED CEILING PLAN

A9.01