



fauntleroy latham
weldon barré
architects

a professional corporation in
continuous practice since 1981

architecture
planning
interiors
sustainable design
consulting


229 ST. JOHN LANE
COVINGTON, LA 70433
985-893-4100



A NEW CHURCH BUILDING
FOR:

REDEEMER
LUTHERAN


22531 Hwy 1088
Mandeville, LA 70471

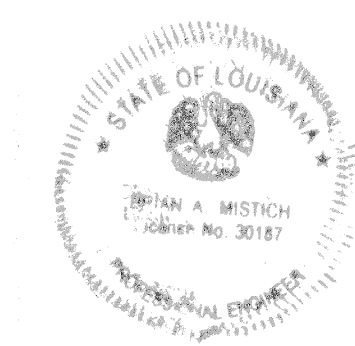

THESE DRAWINGS ARE THE SOLE PROPERTY OF FAUNTLEROY LATHAM
WELDON BARRÉ ARCHITECTS, APC, AND ARE ISSUED AS INSTRUMENTS
OF SERVICE. THESE DRAWINGS SHALL NOT BE COPIED, REPRODUCED
OR USED IN ANY MANNER WITHOUT WRITTEN CONSENT OF
FAUNTLEROY LATHAM WELDON BARRÉ ARCHITECTS, APC.

Issue	Date	Remark


LIGHTING PLAN - MECHANICAL MEZZANINE

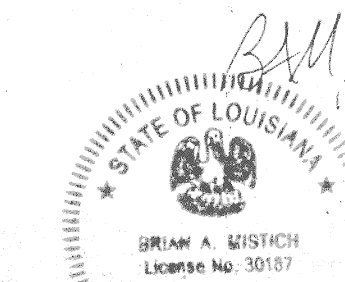

DAMMON ENGINEERING, INC.
554 Old Spanish Trail
Slidell, LA 70458
985-649-5832

Job No.	214011.01	Sheet No.	E2.3
Drawn by			
Checked by			
Date	11.6.2014		

COPYRIGHT 2014, FAUNTLEROY LATHAM WELDON BARRÉ ARCHITECTS, APC

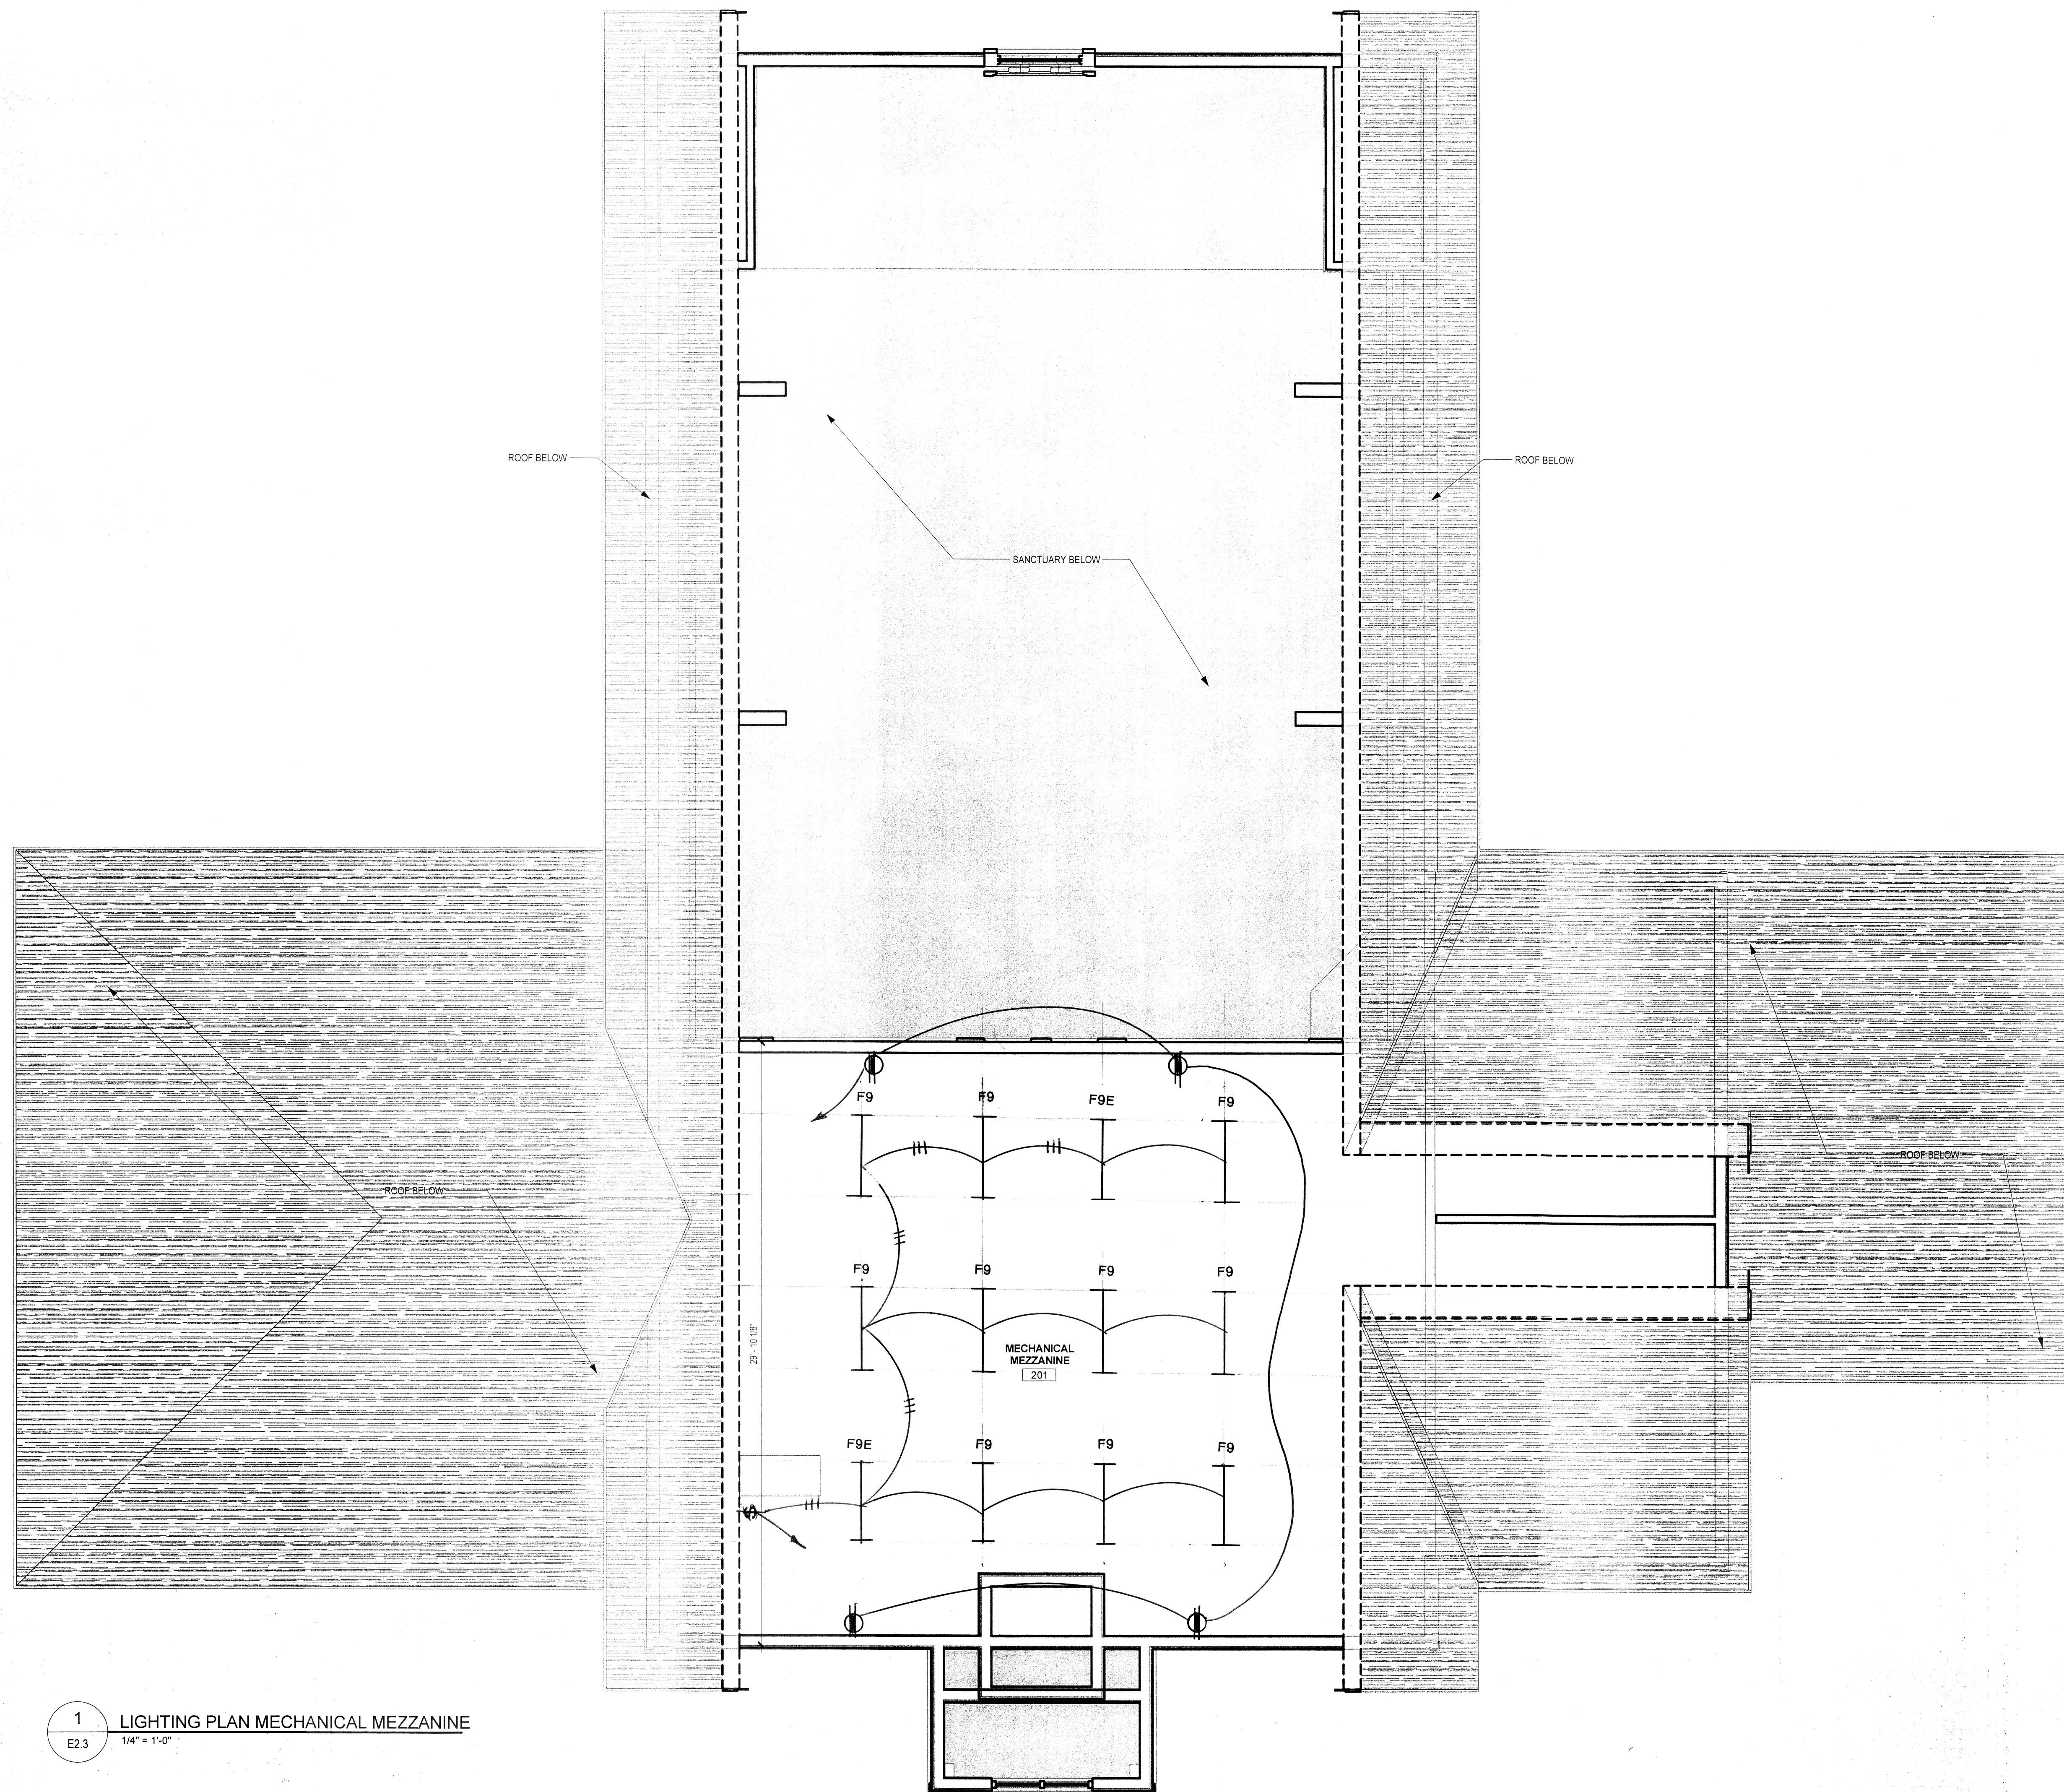

1 LIGHTING PLAN MECHANICAL MEZZANINE
E2.3 1/4" = 1'-0"