


REFLECTED CEILING PLAN - ATRIUM
 SCALE: 1/8" = 1'-0"

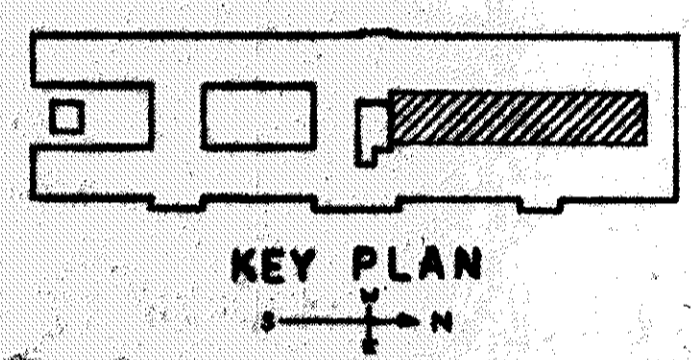


THESE PLANS WERE PREPARED BY ME OR UNDER MY CLOSE PERSONAL SUPERVISION AND TO THE BEST OF MY KNOWLEDGE AND BELIEF THEY COMPLY WITH ALL STATE AND FEDERAL REQUIREMENTS.
 I AM A LICENSED PROFESSIONAL ARCHITECT.
 J. M. HUDDLESTON
 REGISTERED ARCHITECT

ATRIUM CLUSTER LIGHT FIXTURE SCHEDULE


CLUSTER NUMBER	LETTER	FIXTURE DESCRIPTION	WATTS	CHORD LENGTH
A	A	P 94004	100	10'6"
	B	P 4406	180	9'4"
	C	P 4402-29	100	8'8"
	D	PRES. 94008	100	11'6"
	E	P 4356	100	8'4"
B	F	P 4402-29	100	6'8"
	G	PRES. 94014	100	8'8"
	H	PRES. 546-C	150	6'2"
	J	PRES. 94003	100	7'2"
	K	P 4402-29	100	8'8"
C	L	P 4401-29	60	11'9"
	M	PRES. 4356	100	9'2"
	N	PRES. 94431	150	11'8"
	P	P 4401-29	60	8'0"
	Q	PRES. 94431	100	10'6"
D	R	PRES. 94008	100	13'8"
	S	PRES. 94018	100	8'10"
	T	P 4402-29	100	11'0"
	U	PRES. 94003	100	10'6"
	V	PRES. 94005	100	8'6"
E	W	PRES. 546-C	150	6'0"
	X	PRES. 94014	100	11'0"
	Y	P 4402-29	100	7'8"
	Z	PRES. 94013	100	10'0"
	AA	PRES. 94431	150	7'0"
BB	PRES. 546-C	150	10'0"	
CC	PRES. 94010	100	12'0"	
DD	P 4402-29	100	9'2"	

NOTES: "PRES." = PRESCOLITE
 "P" = PROGRESS
 CHORD LENGTHS ARE FROM THE CEILING SURFACE TO THE TOPS OF FIXTURES.

CLUSTER "A"

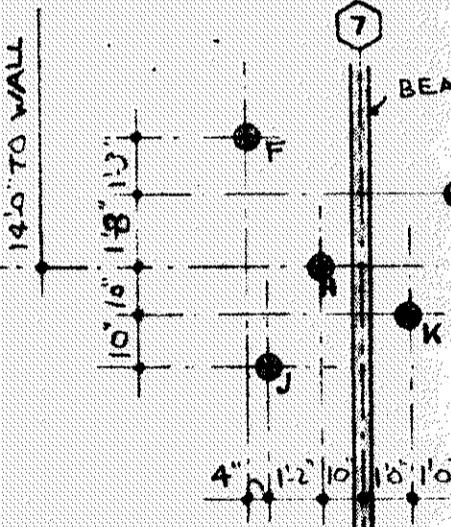


CLUSTER "B"

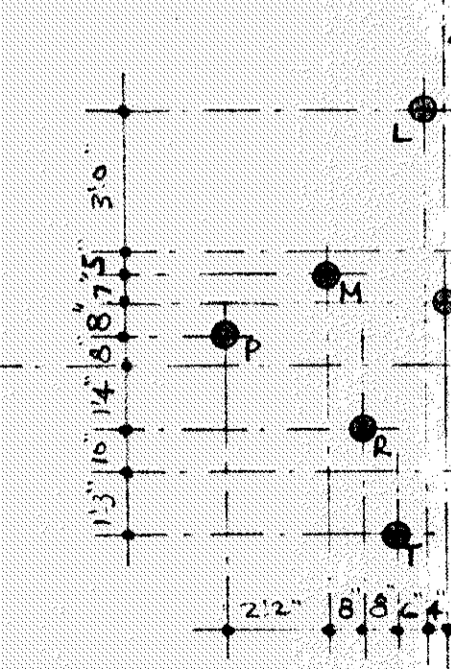



CLUSTER "C"




CLUSTER "D"

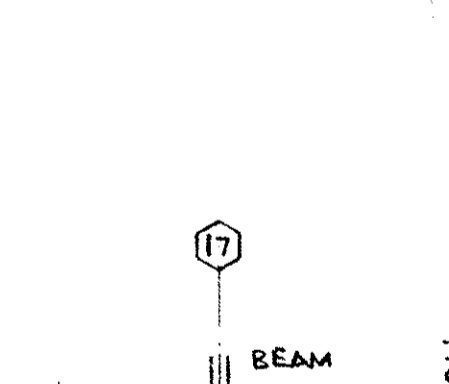

CLUSTER "E"

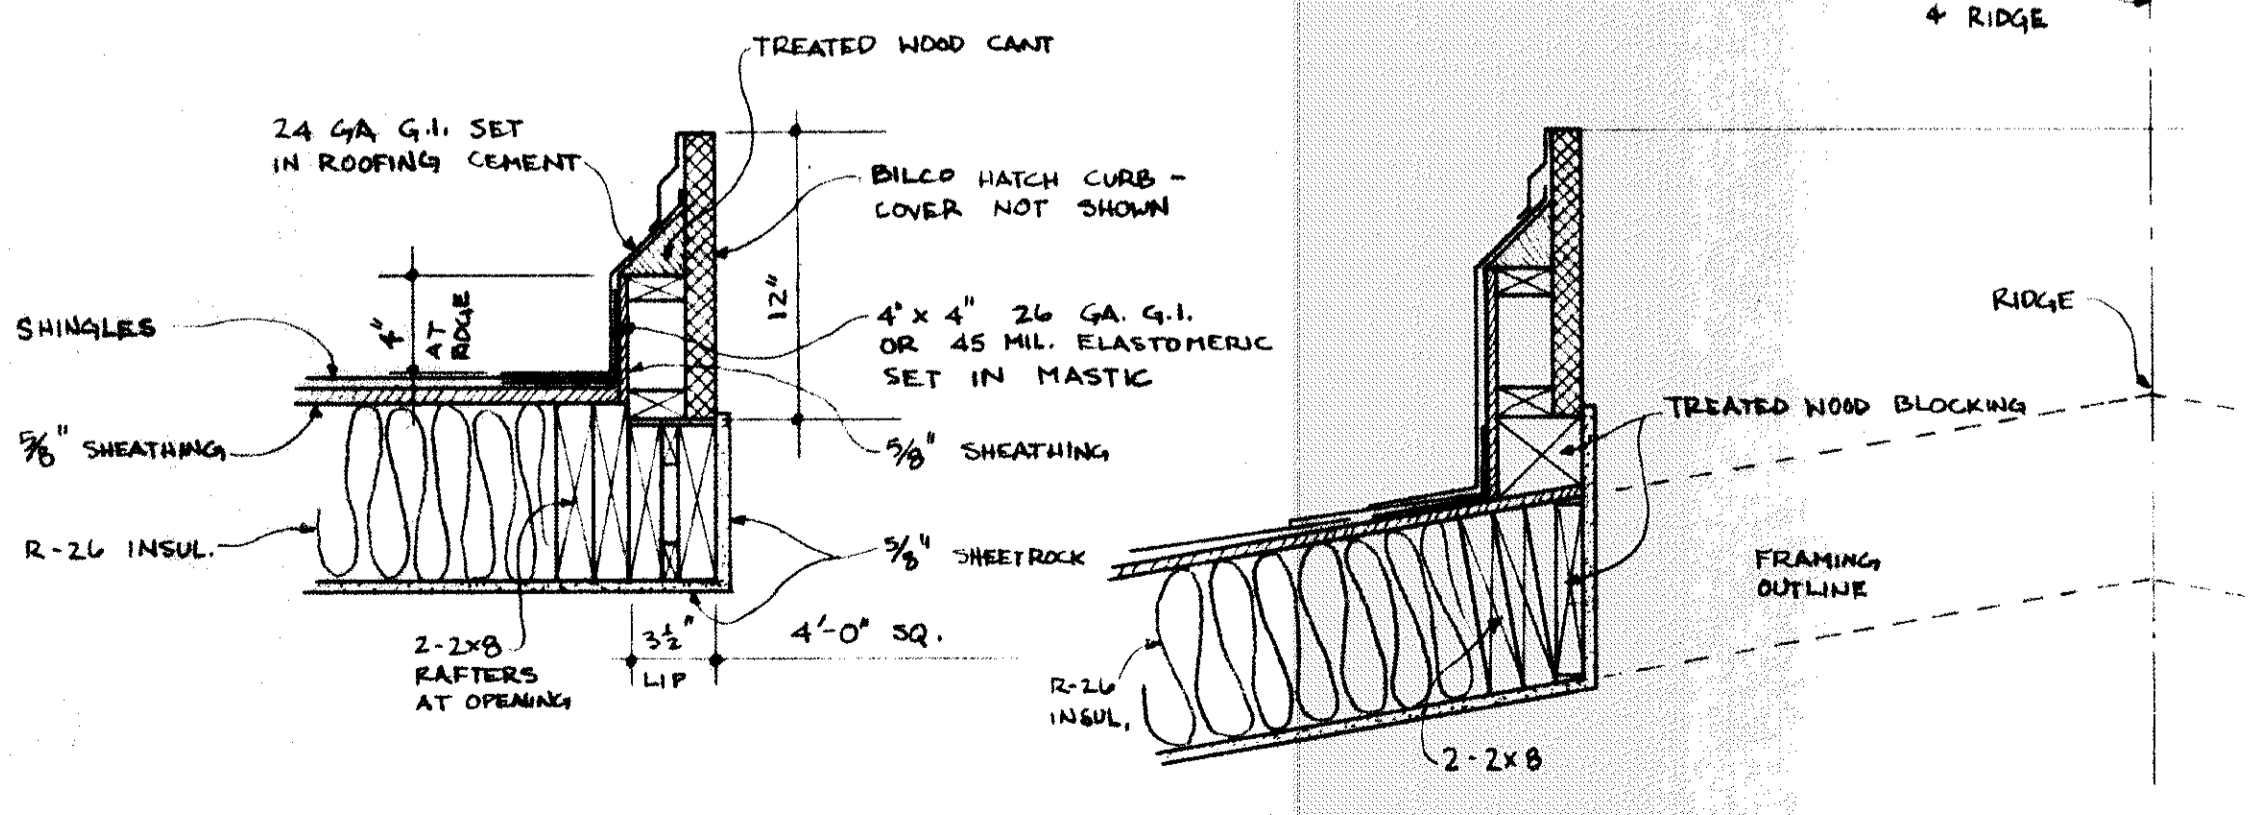 

BILCO ROOF HATCH DETAILS
 SCALE: 1 1/2" = 1'-0"

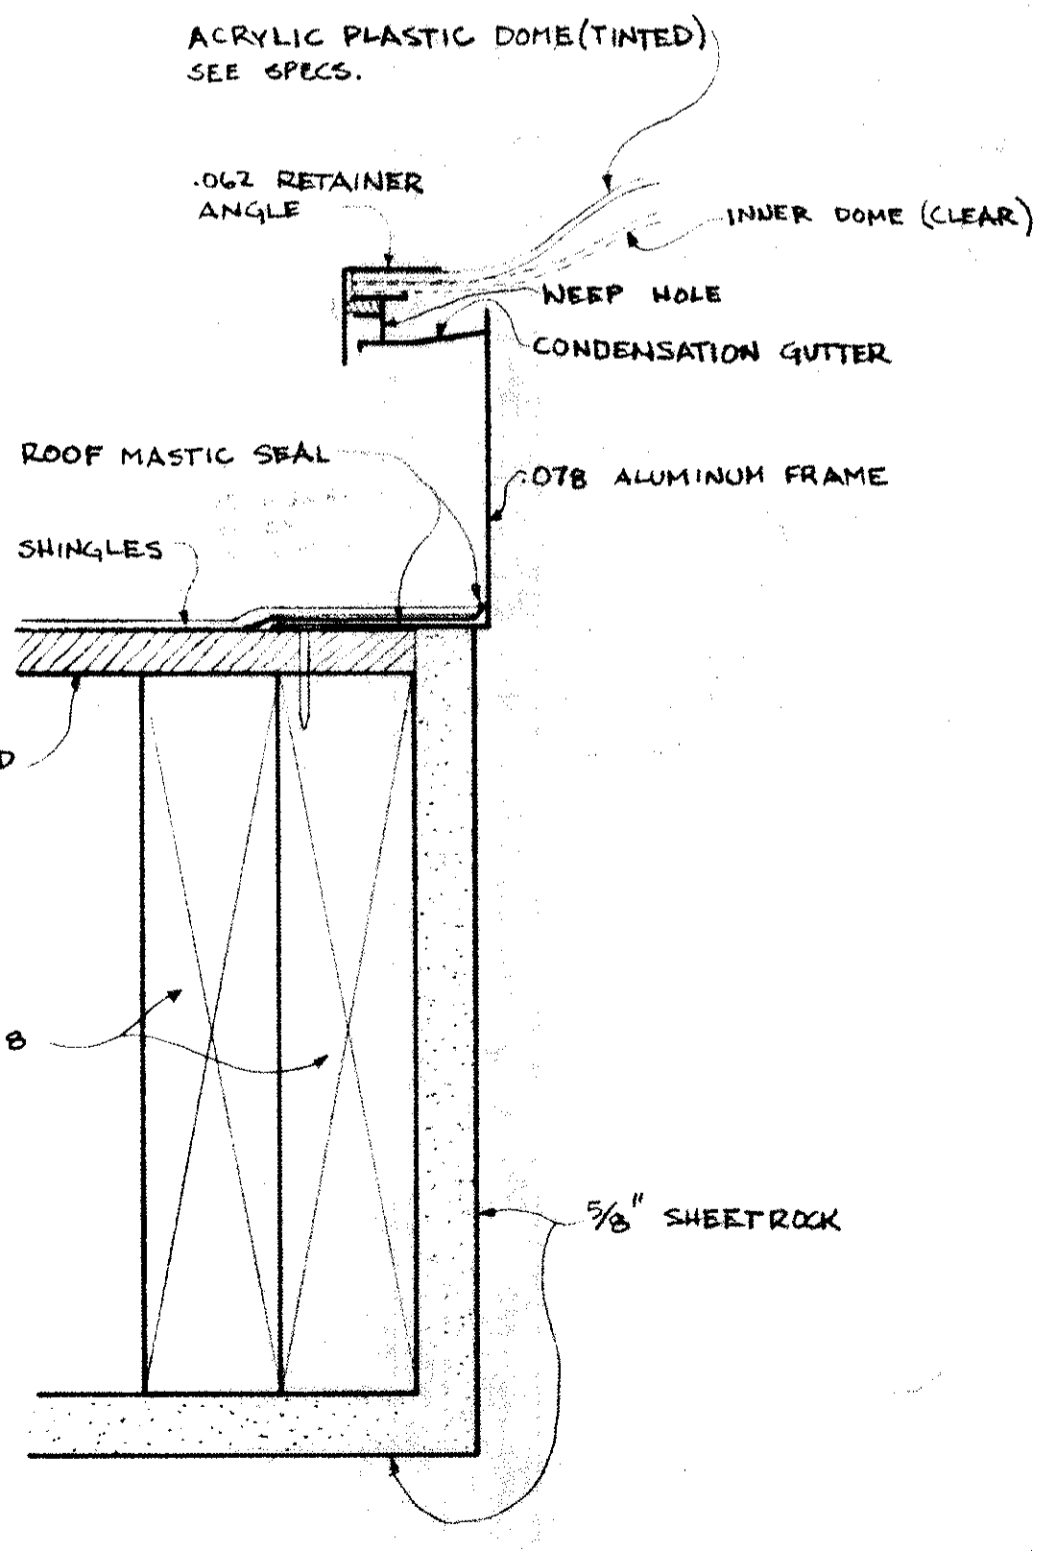

SKYLIGHT DETAIL
 HALF SCALE