 


PROJECT NAME: \_\_\_\_\_ FIXTURE TYPE: \_\_\_\_\_

**HADCO PROFILER PASS AREA-LYTE SPECIFICATION SHEET**




model PA3S


**SPECIFICATIONS**

The Hadco Profiler Pass Area-Lyte luminaire is a straight arm architectural area fixture. Designed for performance, it is ideal for use in parking lots, drive-thru lanes, and other areas where high visibility and uniform lighting is required. Combined with the Profiler Pass Area-Lyte and Profiler Flood-Lyte, the low profile aesthetic design meets the requirements of your discriminating customers.

**LIGHT FIXTURE**  
N.T.S.

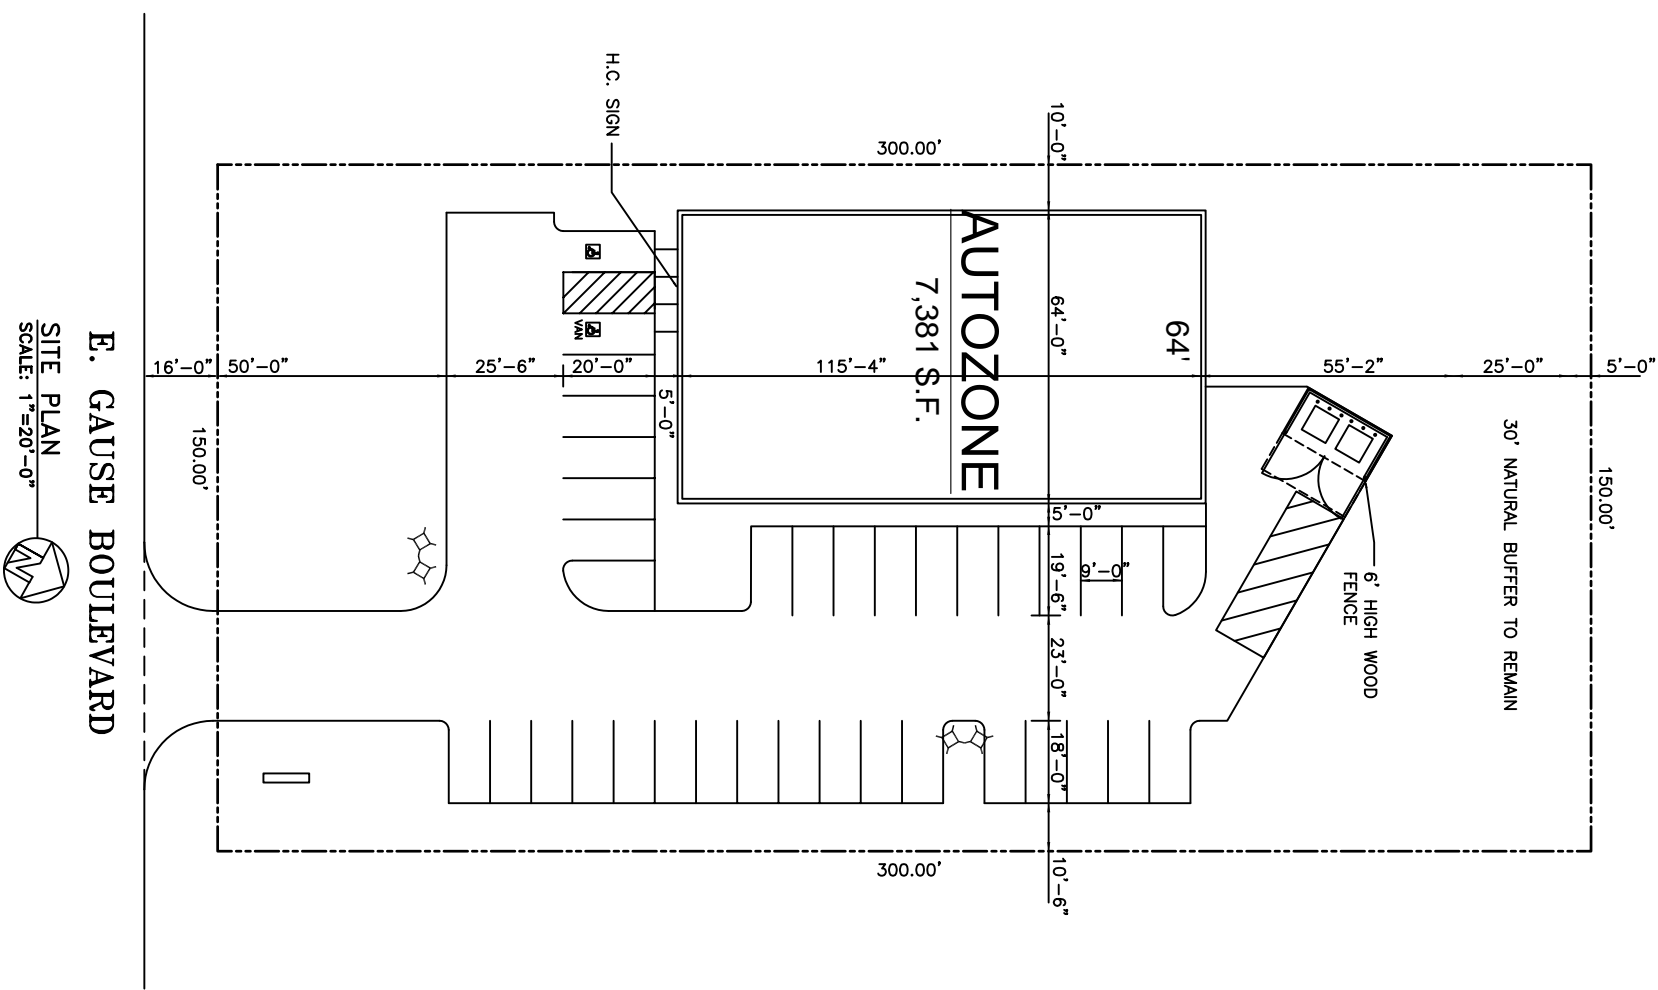

**E. GAUSE BOULEVARD**  
SITE PLAN  
SCALE: 1"=20'-0"

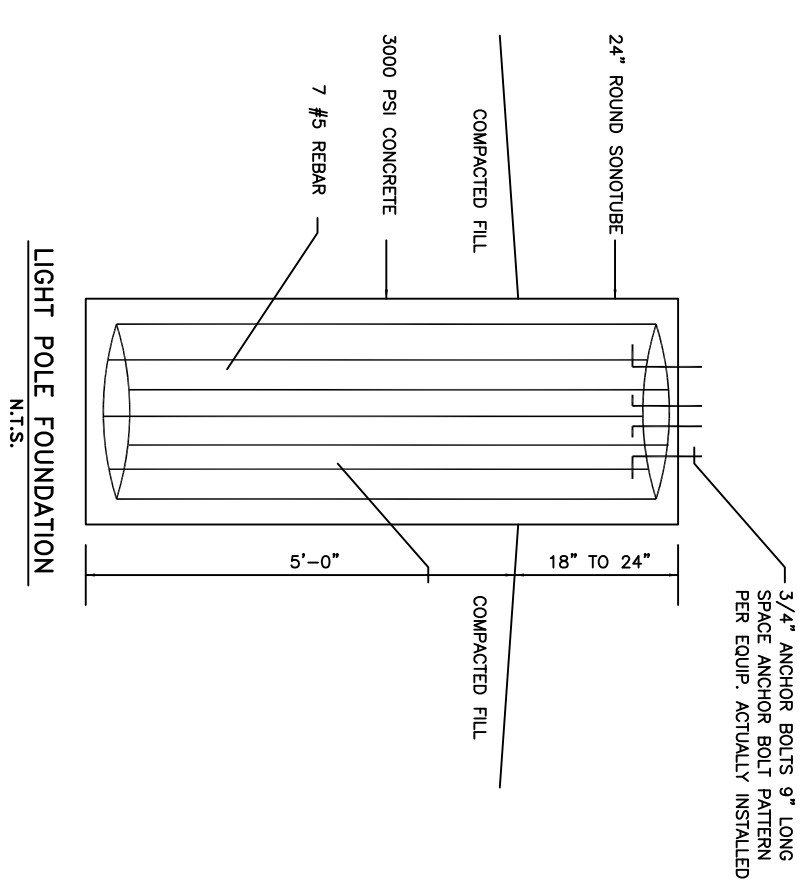

**LEGEND**  
- DOUBLE LUMINAIRE

NOTE: EXTERIOR LIGHTING SHALL BE SHADED OR INWARDLY DIRECTED IN SUCH A MANNER SO THAT NO DIRECT LIGHTING OR GLARE IS CAST BEYOND THE PROPERTY LINE. THE INTENSITY OF SUCH LIGHTING SHALL NOT EXCEED ONE FOOT CANDLE AS MEASURED AT THE ABUTTING PROPERTY LINE.