



**DAMMON**  
ENGINEERING, INC.  
EMMETT  
DAMMON

ARCHITECT  
ROBERT  
WILTSE

1095 FLORIDA AVENUE  
SLIDELL, LA, 70458  
985-649-5832

WEBSITE:  
WWW.DAMMONENGINEERING.COM  
EMAIL:  
DAMMONENG@BELLSOUTH.NET

ARCHITECTURE  
ENGINEERING  
STUDIES  
PLANNING  
INVESTIGATION  
EXPERT WITNESS

NEW OFFICE  
BUILDING

K. B. KAUFMANN  
TERRACE AVENUE  
SLIDELL, LA

PLUMBING  
PLAN

REV:

SCALE: AS NOTED

JOB#: 1871


DATE: 10-31-07

SHEET

P-1

NOTES:  
1. INSULATE PIPING FOR HANDCAP FIXTURE.  
2. PROVIDE CHAIR CARRIER FOR WALL HUNG FIXTURE.  
3. H.C. - HANDCAP FIXTURE  
4. INSTALL CONTINUOUS DRIP VALVE ON ALL FLOOR DRAINS.

PLUMBING FIXTURE SCHEDULE				
MARK	DESCRIPTION	TYPE	ROUGH-IN SIZES	NOTES
WC	H.C. WATER CLOSET	VALVE	4" 4" 4" 4"	3
LAV	H.C. LAVATORY	WALL HUNG	2" 1/2" 1/2" 1/2"	1, 2, 3
F.D.	FLOOR DRAIN	-	2" 2" 2" 2"	4
HS	HAND SINK	-	2" 2" 1/2" 1/2"	-
WH	WATER HEATER DRAIN	-	2" 2" 2" 2"	-

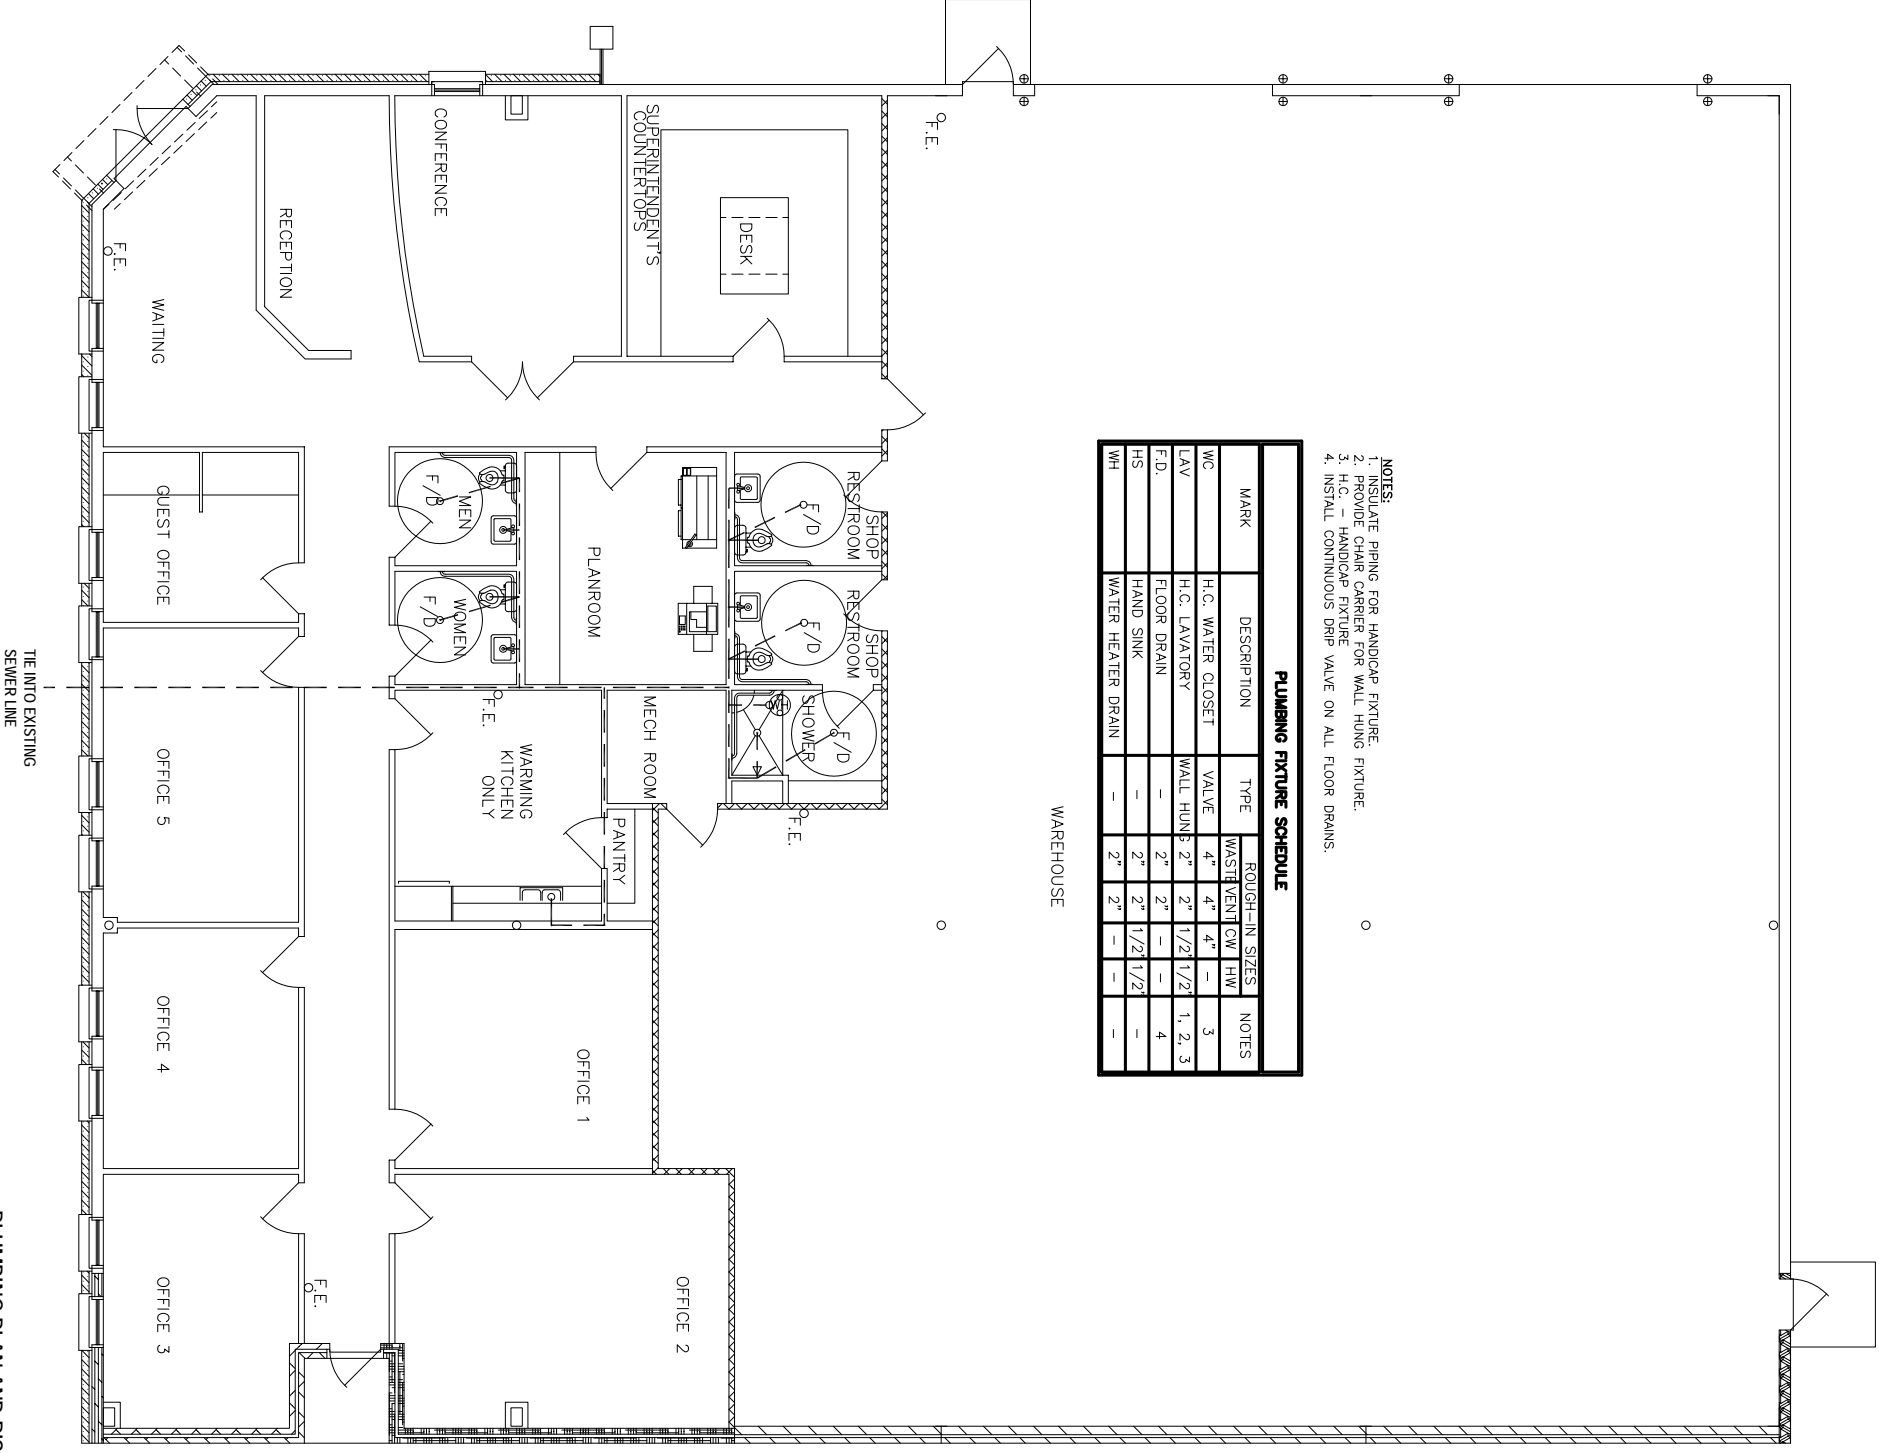

PLUMBING PLAN AND RISER  
SCALE: 3/16" = 1'-0"

