

Engberg Anderson Design Partnership, Inc.  
MILWAUKEE • MADISON

### AMERICAN DENTAL PARTNERS- METAIRIE


2400 VETERANS BOULEVARD SUITE 210  
KENNER, LOUISIANA

**Owner**  
American Dental Partners, Inc.  
3000 W. Esplanade Ave. Suite 200  
Metairie, LA 70002

**Project No** 071750

**Issued For:**

No.	Description	Date
01	ISSUED FOR BID	10-17-07

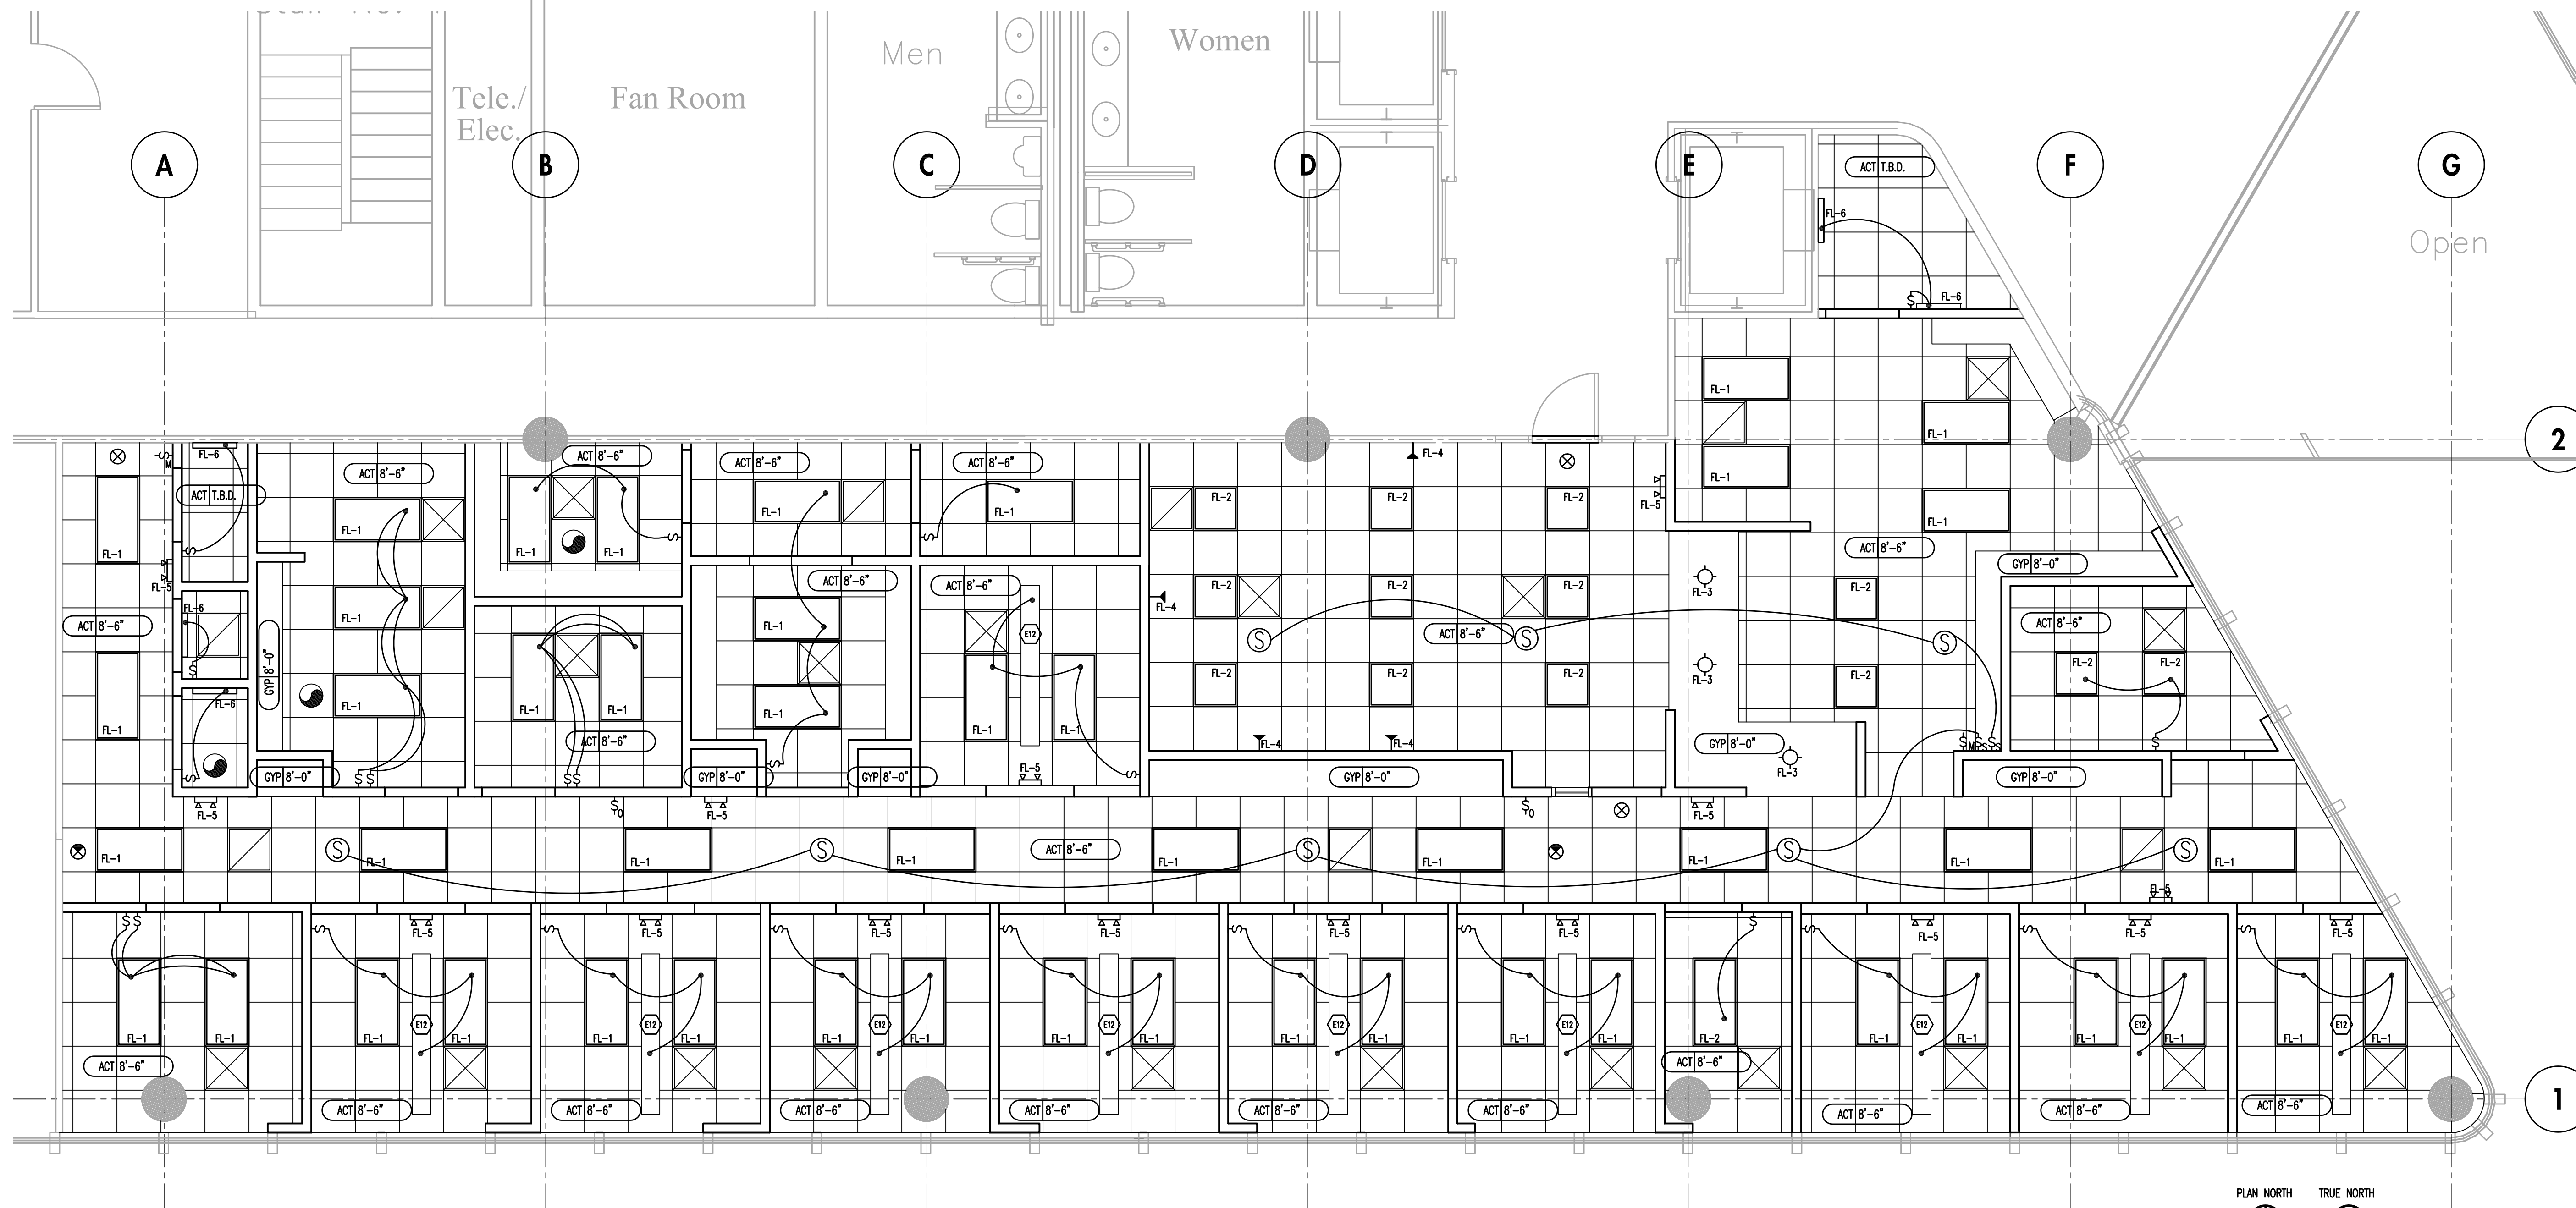

1 Reflected Ceiling Plan  
SCALE: 1/4"=1'-0"

### MECHANICAL NOTES

- 1 - MECHANICAL WORK TO BE DESIGN BUILD

### GENERAL NOTES

- PROVIDE SOFT SWITCH 128 LIGHTING CONTROL SYSTEM. CHECK PLAN FOR CONTROL STATION LOCATIONS.
- ALL LIGHTING TO RUN THROUGH LIGHTING CONTROL PANEL. NOTE: COORDINATE DIMMING BALLASTS WITH CONTROL SYSTEM. ADJUST FIXTURE SPECIFICATIONS AS REQUIRED FOR PROPER INTERGRATION WITH LIGHTING CONTROL.
- ALL UNDER COUNTER LIGHTING TO BE CONTROLLED BY ROOM LIGHT SWITCH UNLESS NOTED OTHERWISE.
- SPRINKLER CONTRACTOR, LIGHTING CONTRACTOR, HVAC CONTRACTOR & CEILING CONTRACTOR TO COORDINATE DRAWINGS. LIGHTING DRAWINGS TO TAKE PRECEDENT OVER OTHER TRADES.
- PROVIDE CIRCUIT(S) IN LIGHTING CONTROL PANEL FOR EXTERIOR BUILDING SIGNAGE.


### KEY

\*\*\*DO NOT SUBSTITUTE FIXTURES\*\*\*

- FL-1 [Symbol] - RECESSED 2x4: LITHONIA 2PM3N-G-A-3-32-18-LD-GE8-120-LST  
NOTE: VERIFY DUAL SWITCHING LOCATIONS ON PLANS
- FL-2 [Symbol] - RECESSED 2x2: LITHONIA 2PM3N-G-A-3-17-9-LD-GE8-120  
NOTE: VERIFY DUAL SWITCHING LOCATIONS ON PLANS
- FL-3 [Symbol] - RECESSED CAN: PORTFOLIO C6042-10-8001-LI
- FL-4 [Symbol] - ART LIGHT: TECH LIGHTING, JOSHUA, 700-JOS-CP-C
- FL-5 [Symbol] - EMERGENCY LIGHT: LITHONIA ELM2-SD
- FL-6 [Symbol] - INDUSTRIAL FLUORESCENT: LITHONIA WC-2-17-MVOLT-GE810S
- FL-7 [Symbol] - UNDER CABINET: LITHONIA UC-21-0P-120 (SEE MILLWORK ELEVATIONS FOR LOCATIONS)
- FL-8 [Symbol] - EXIT SIGN: SURE-LITES ES-7-FACE-70-WH-R/RM-DIRECTION-C

### KEY

- [Symbol] - SWITCH
- [Symbol] - THREWAY SWITCH
- [Symbol] - LIGHTING CONTROL SYSTEM MASTER SWITCH
- [Symbol] - LIGHTING CONTROL SYSTEM OVERRIDE SWITCH
- [Symbol] - SOUND CONTROL
- [Symbol] - CEILING MOUNTED SPEAKER

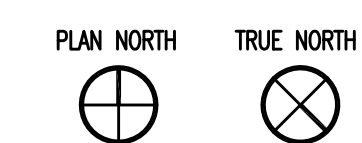

### Reflected Ceiling Plan

# A2.4