

**DAMMON ENGINEERING, INC.**

CHIEF ENGINEER  
EMMETT  
DAMMON, P.E.

CHIEF ARCHITECT  
ROBERT  
WILTSE

1095 FLORIDA AVENUE  
SLIDELL, LA. 70458  
OFFICE: 985-649-5832  
FAX: 985-641-5950

WEBSITE:  
WWW.DAMMONENGINEERING.COM

EMAIL:  
DAMMONENG@BELLSOUTH.NET

ARCHITECTURE  
ENGINEERING  
STUDIES  
PLANNING  
INVESTIGATION  
EXPERT WITNESS

GREEN-STATEFARM  
RETAIL COMPLEX  
383 GAUSE  
BLVD., WEST  
SLIDELL, LA

**REFLECTED  
CEILING PLAN**

REV:

SCALE: AS NOTED


JOB#: 2057

DATE: 04-29-10

SHEET 12

**A-5**

OF 19

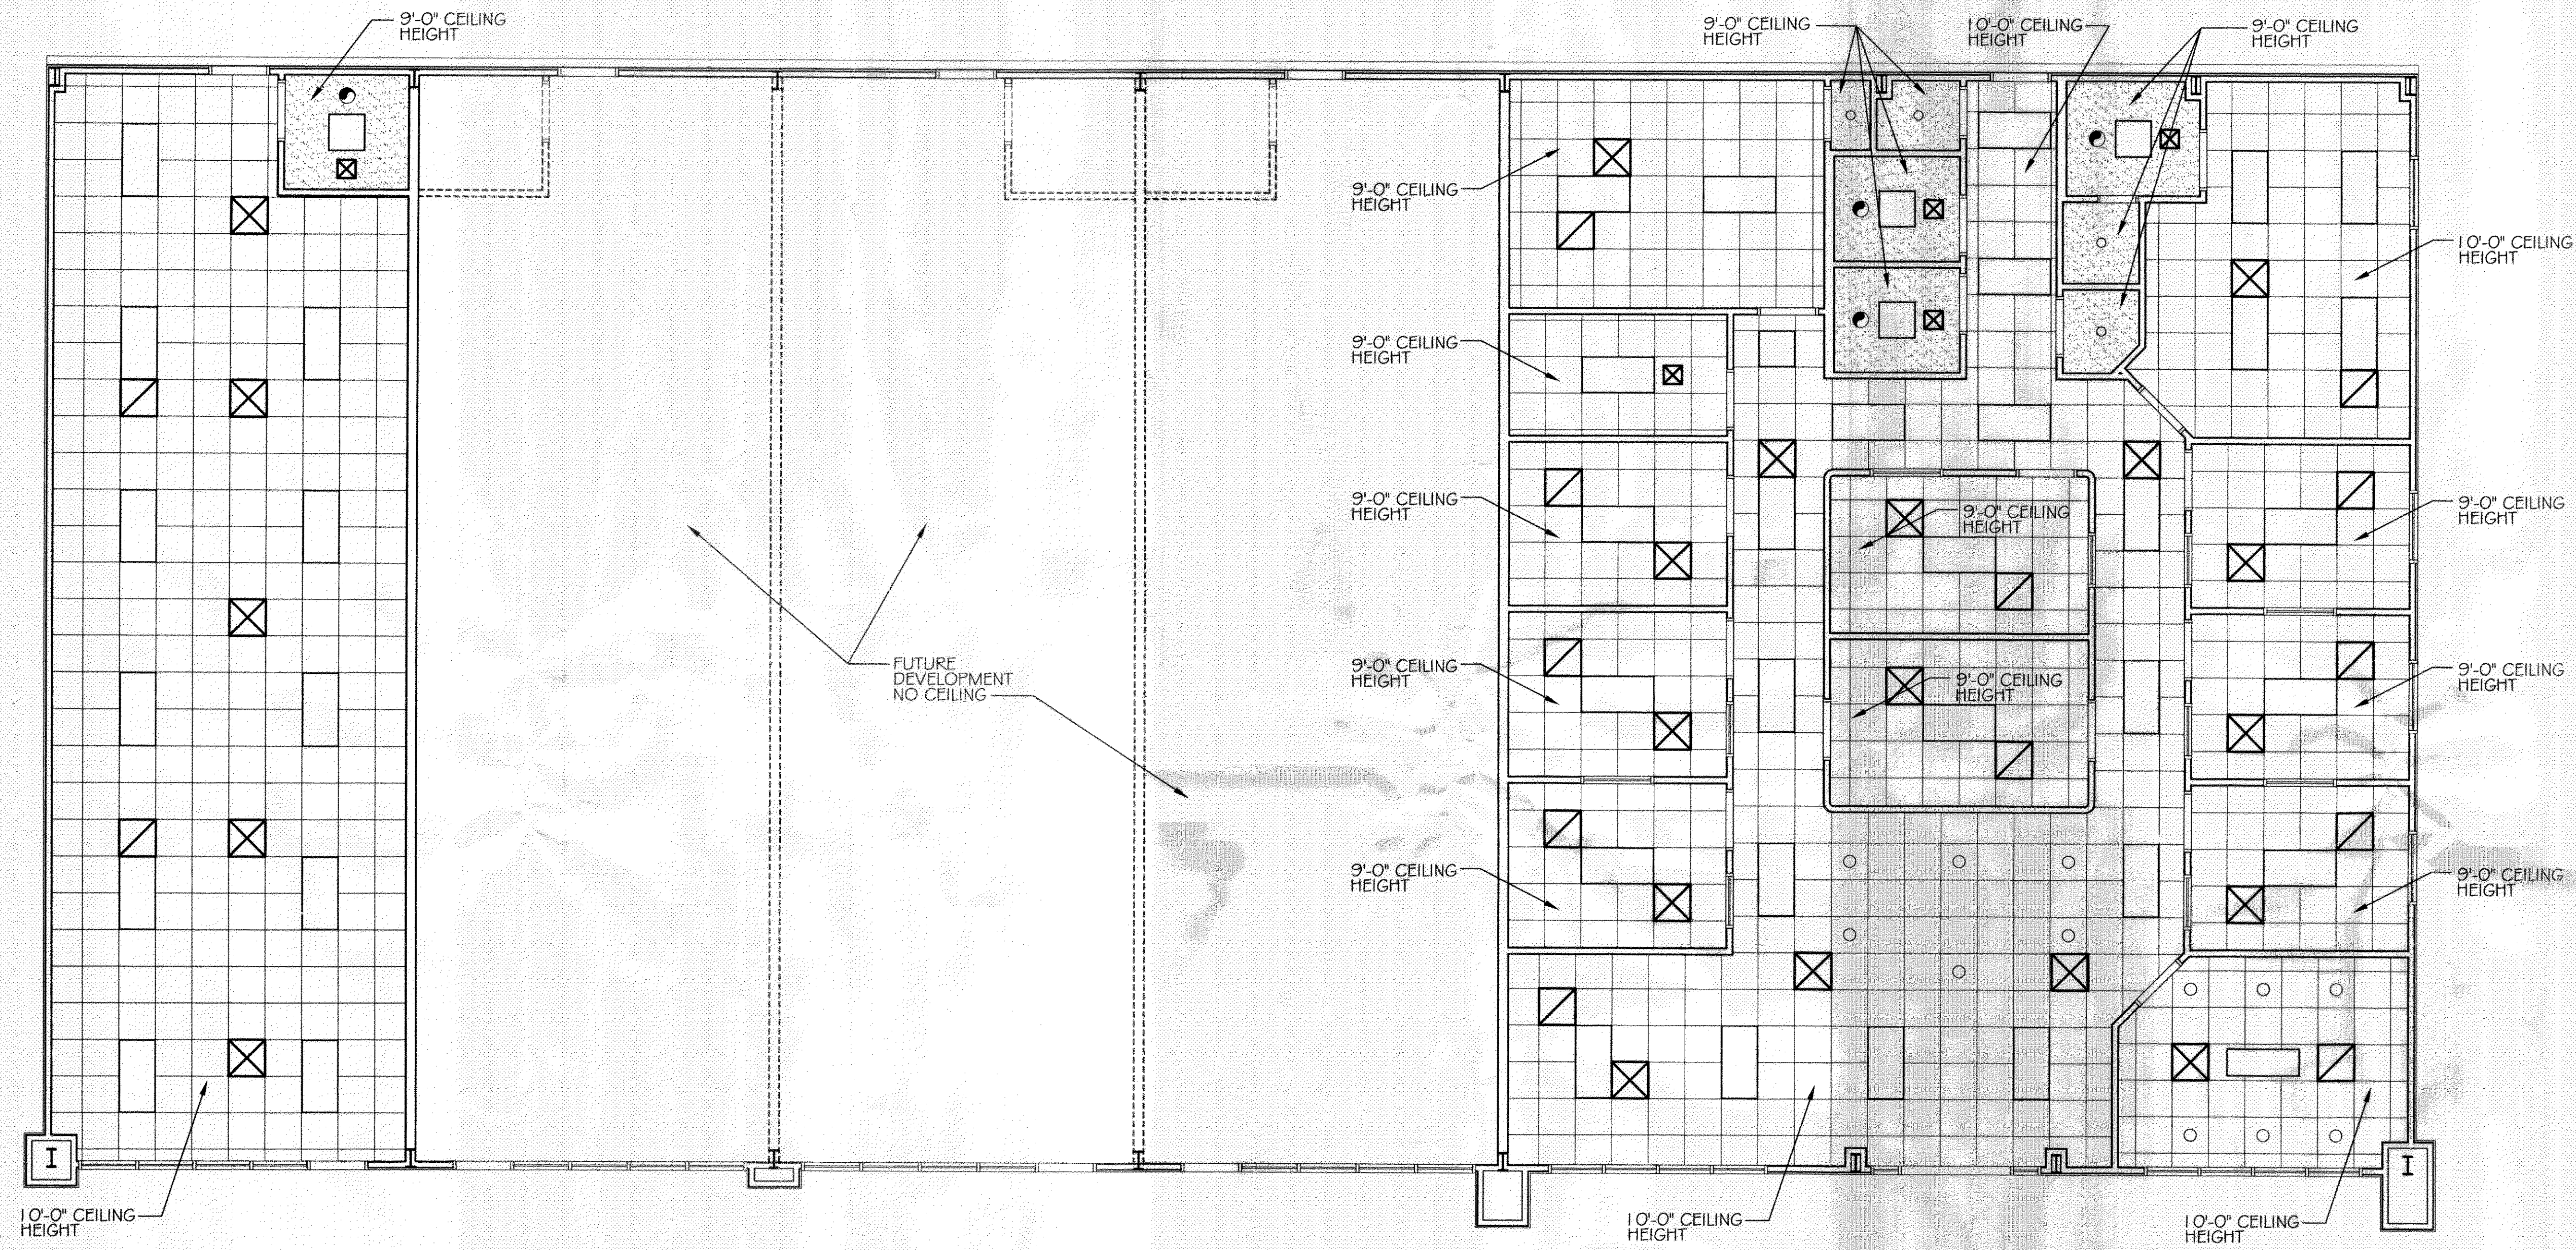

**REFLECTED CEILING PLAN**  
SCALE: 3/16"=1'

**LEGEND**

- A.C.T. CEILING GRID (2x2')
- GYPSUM BOARD CEILING
- SUPPLY AIR
- RETURN AIR
- 2x4' FLUORESCENT LIGHT
- 2x2' FLUORESCENT LIGHT
- 18"x4' FLUORESCENT CONFERENCE ROOM LIGHT
- EXHAUST FAN
- CAN LIGHT
- STANDARD BULB FIXTURE

380899  
REVIEWED FOR  
STATE FIRE MARSHAL  
AS PER REVIEW LETTER  
BY: JAMES W. WHITE, ARCHITECT, CBO