

**DAMMON  
ENGINEERING, INC.**

CHIEF ENGINEER  
EMMETT  
DAMMON, P.E.

CHIEF ARCHITECT  
ROBERT  
WILTSE

1095 FLORIDA AVENUE  
SLIDELL, LA. 70458  
OFFICE: 985-649-5832  
FAX: 985-641-5950

WEBSITE:  
WWW.DAMMONENGINEERING.COM

EMAIL:  
DAMMONENG@BELLSOUTH.NET

ARCHITECTURE

ENGINEERING

STUDIES

PLANNING

INVESTIGATION

EXPERT WITNESS

GREEN-STATEFARM  
RETAIL COMPLEX  
381-391 GAUSE  
BLVD., WEST  
SLIDELL, LA

**REFLECTED  
CEILING PLAN**

REV:

SCALE: AS NOTED


JOB#: 2057

DATE: 06-23-10

SHEET 12

**A-5**

OF 19

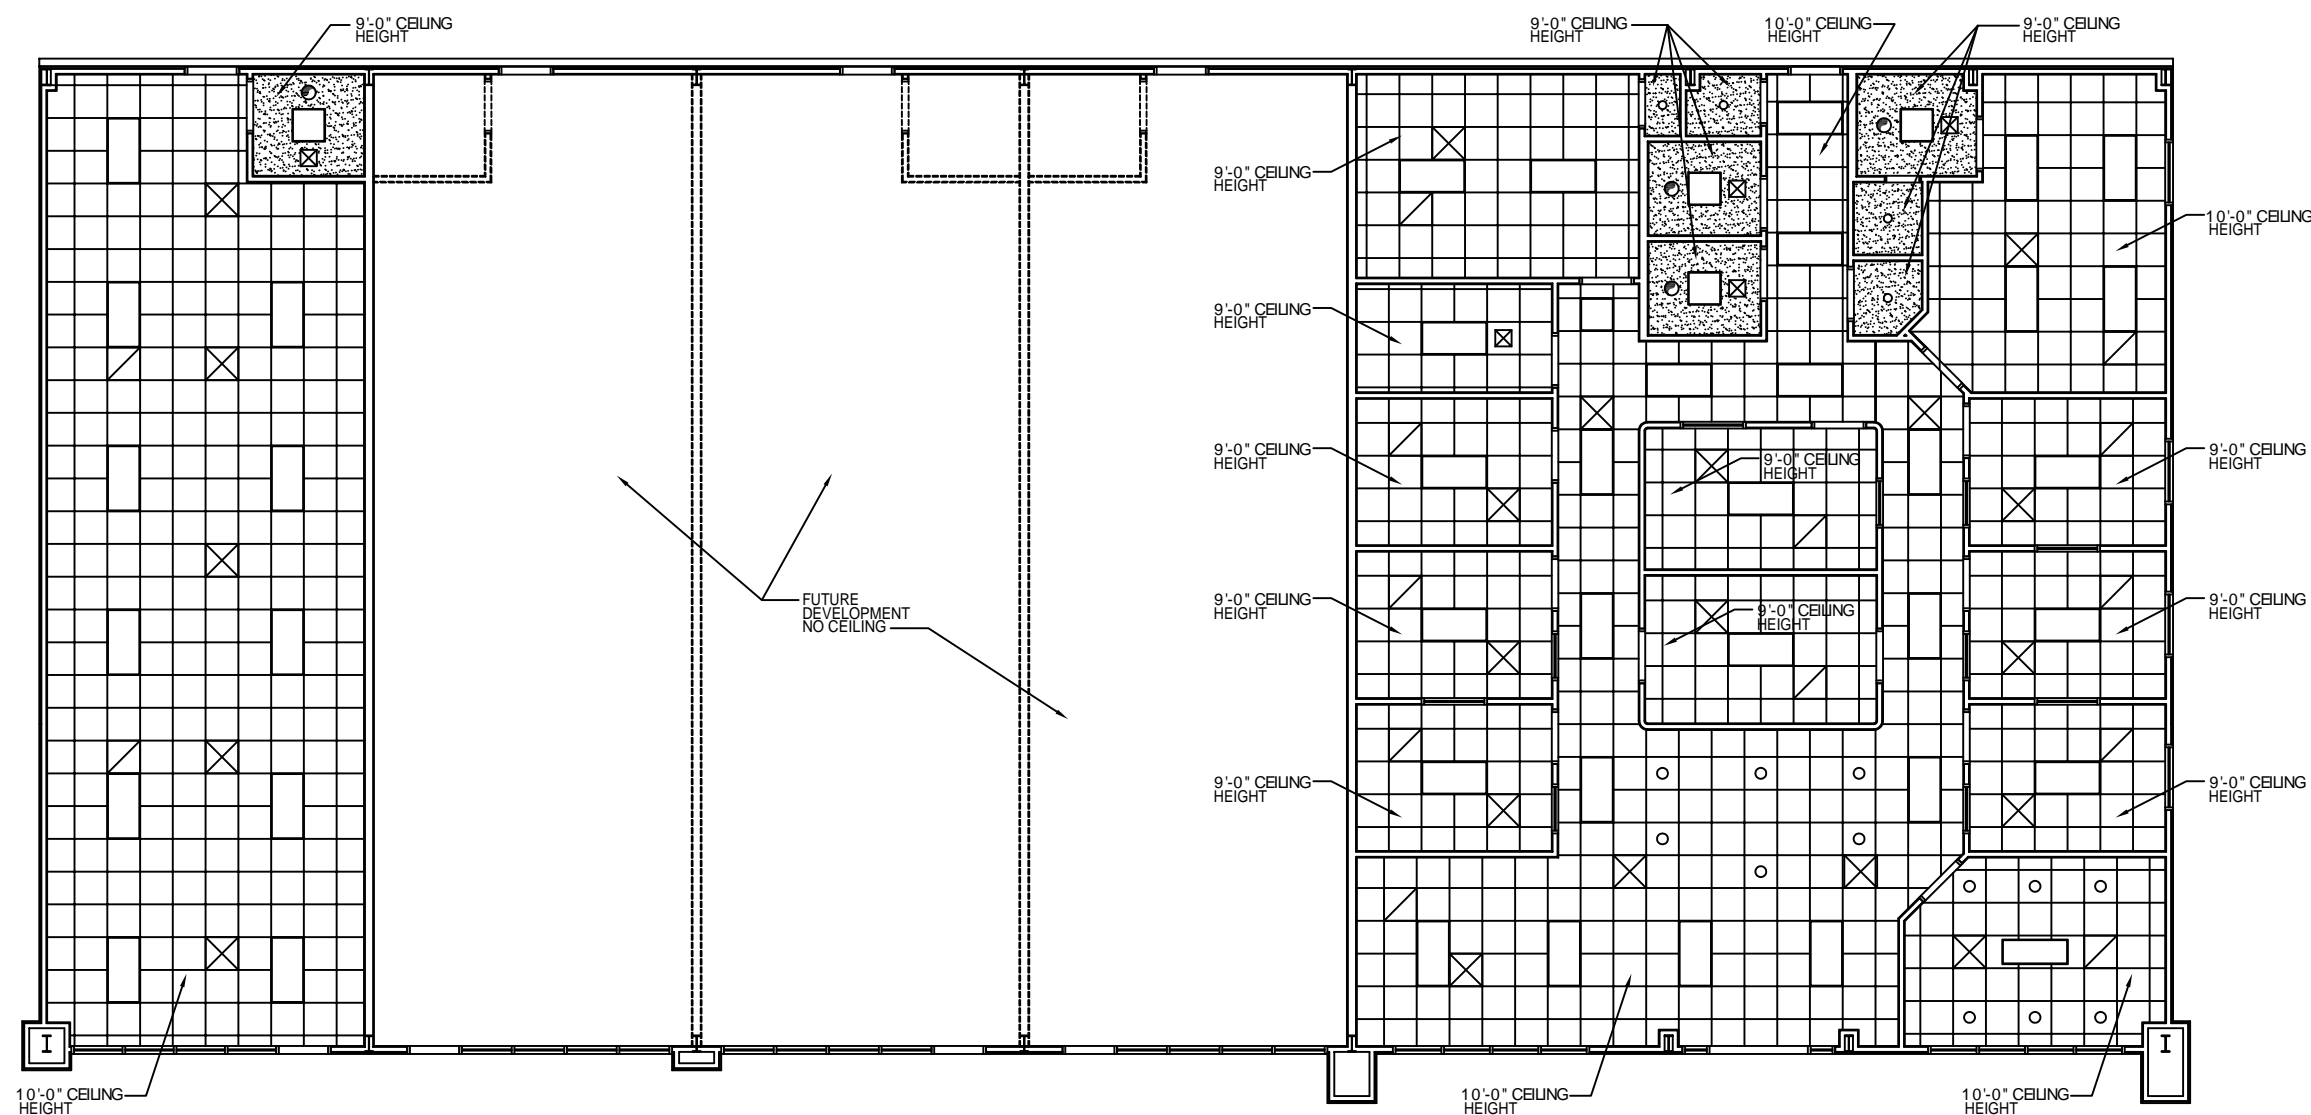

**REFLECTED CEILING PLAN**  
SCALE: 3/16"=1'

**LEGEND**

- A.C.T. CEILING GRID (2'x2')
- GYPSUM BOARD CEILING
- SUPPLY AIR
- RETURN AIR
- 2'x4' FLUORESCENT LIGHT
- 2'x2' FLUORESCENT LIGHT
- 18 1/4' FLUORESCENT CONFERENCE ROOM LIGHT
- EXHAUST FAN
- CAN LIGHT
- STANDARD BULB FIXTURE