

DAMMON
ENGINEERING, INC.

CHIEF ENGINEER
EMMETT
DAMMON, P.E.

CHIEF ARCHITECT
ROBERT
MILTSE

1095 FLORIDA AVENUE
SUDDLE, LA. 70456
OFFICE: 985-649-5932
FAX: 985-641-15950

WEBSITE:
WWW.DAMMONENGINEERING.COM

EMAIL:
DAMMONENR@BLSOUTH.NET

ARCHITECTURE
ENGINEERING
STUDIES
PLANNING
INVESTIGATION
EXPERT WITNESS

NEW
LIVING
FACILITY

STARCO WEST
1705 VIOLA ST
MANDEVILLE, LA

SITE
PLAN

REV:

SCALE: AS NOTED


JOB#: 2081

DATE: 11-4-10

SHEET 3

C-2

OF 17

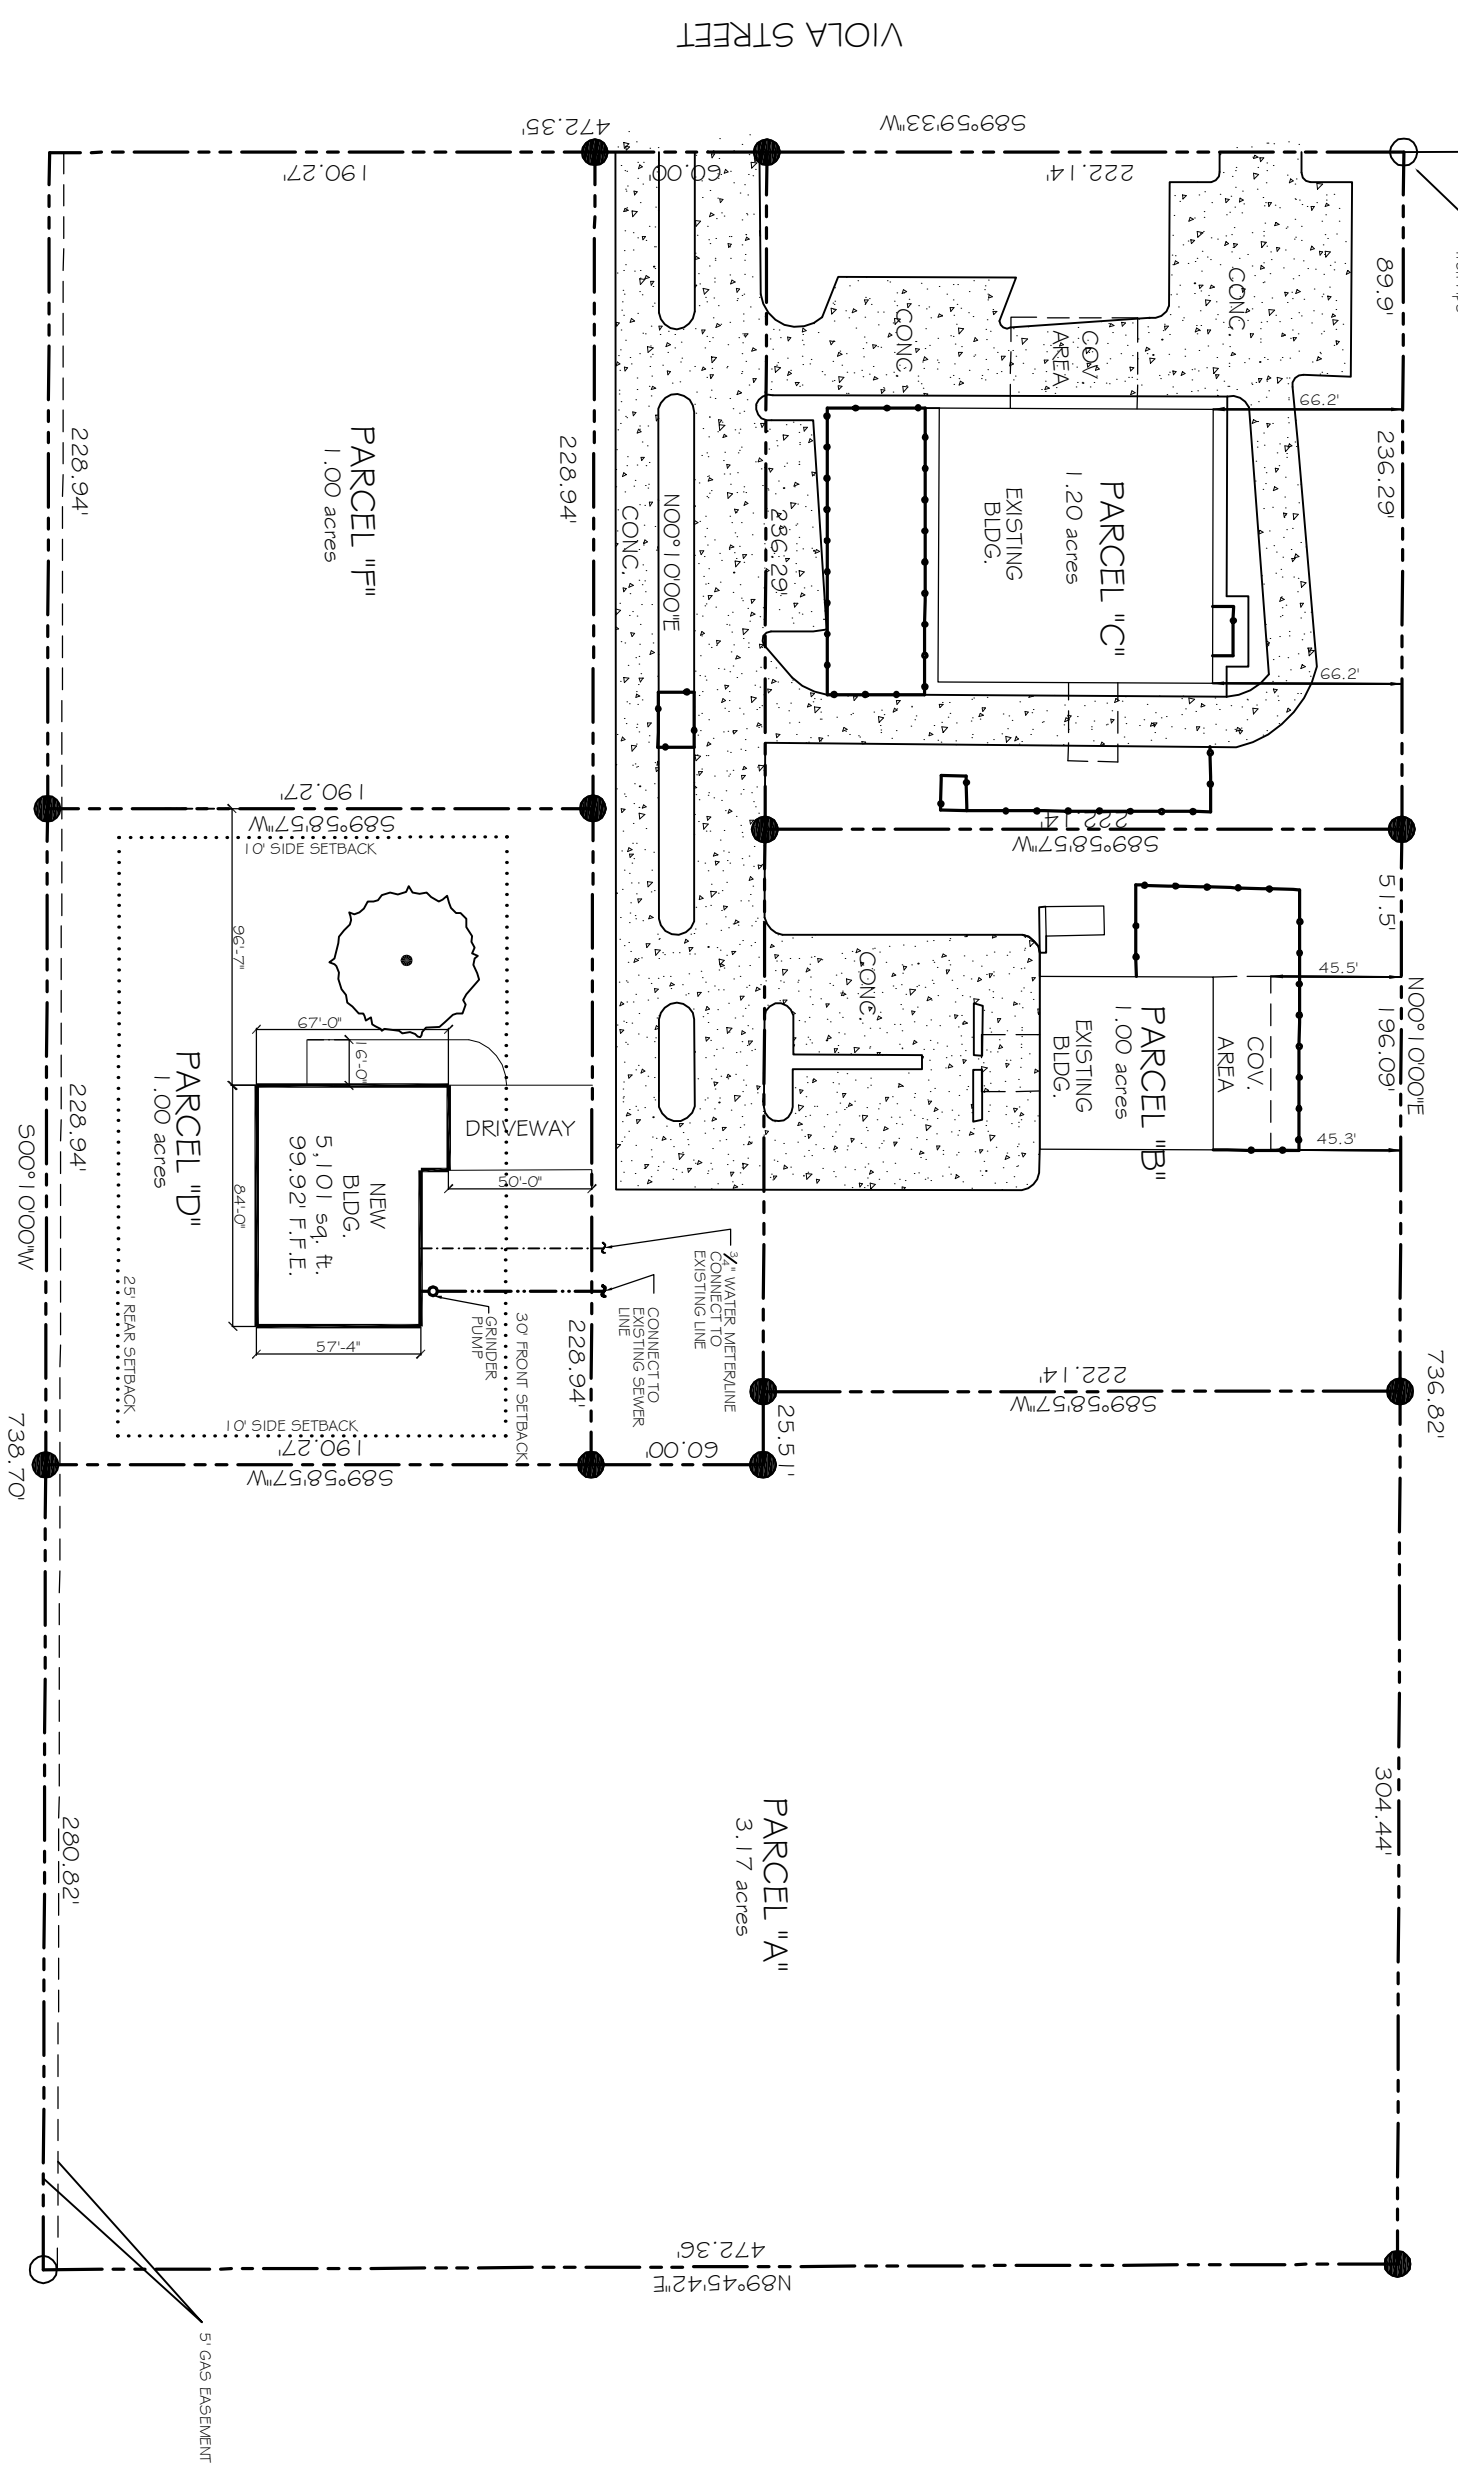

SITE PLAN
SCALE: 1"=30'-0"



- LEGEND**
- PROPERTY LINE
 - SETBACK
 - NEW BUILDING OUTLINE
 - 5' GAS EASEMENT
 - SEWER LINE
 - WATER LINE

This document was created with Win2PDF available at <http://www.win2pdf.com>.
The unregistered version of Win2PDF is for evaluation or non-commercial use only.
This page will not be added after purchasing Win2PDF.