




CONDENSING UNIT MOUNTING DETAIL  
N.T.S.

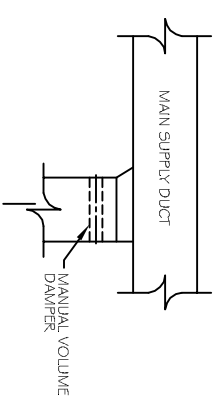


SUPPLY DUCT TAKE-OFF DETAIL  
N.T.S.

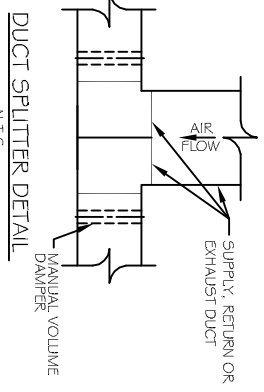


DUCT SPLITTER DETAIL  
N.T.S.

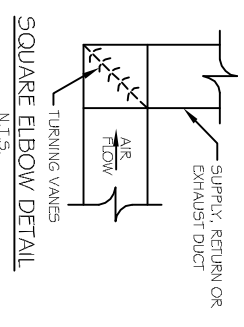

SQUARE ELBOW DETAIL  
N.T.S.

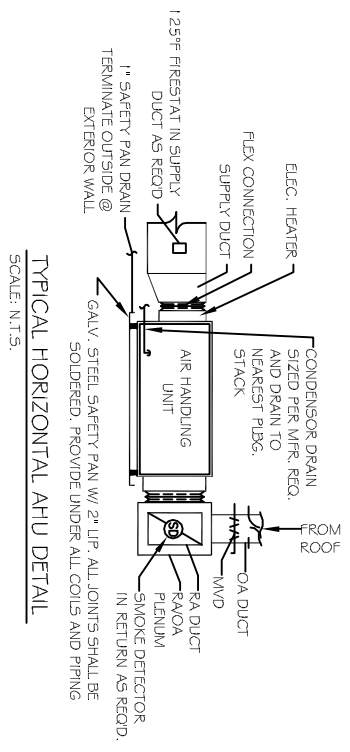

TYPICAL HORIZONTAL AHU DETAIL  
SCALE: N.T.S.

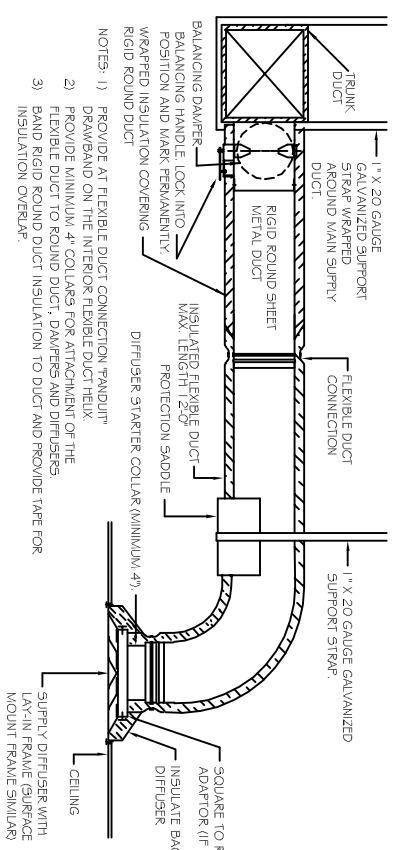

DIFFUSER CONNECTION DETAIL-FLEX DUCT  
N.T.S.

- HVAC NOTES**
1. CONDENSED WATER TO BE U... 1.8\"/>


**AC UNIT SCHEDULE**

NO.	TOTAL BTU	CFM	O.A.	HEAT ELEC.	VOLTAGE	WCH	EXT BRKR	COMMENTS
1	50,000	2,000	210	15 KW	208V, 3Ø	-	FULL	

**EXHAUST FAN SCHEDULE**

FAN No.	CFM	VOLTAGE	T-°C	W/AFR.
274	100	120	VENT/DIRT	

- LEGEND**
- 24x24 CEILING DIFFUSER
  - 12x12 DIFFUSERS IN TIGHT ROOMS
  - VENT / DIRT COMBINATION
  - THERMOSTAT
  - AC UNIT

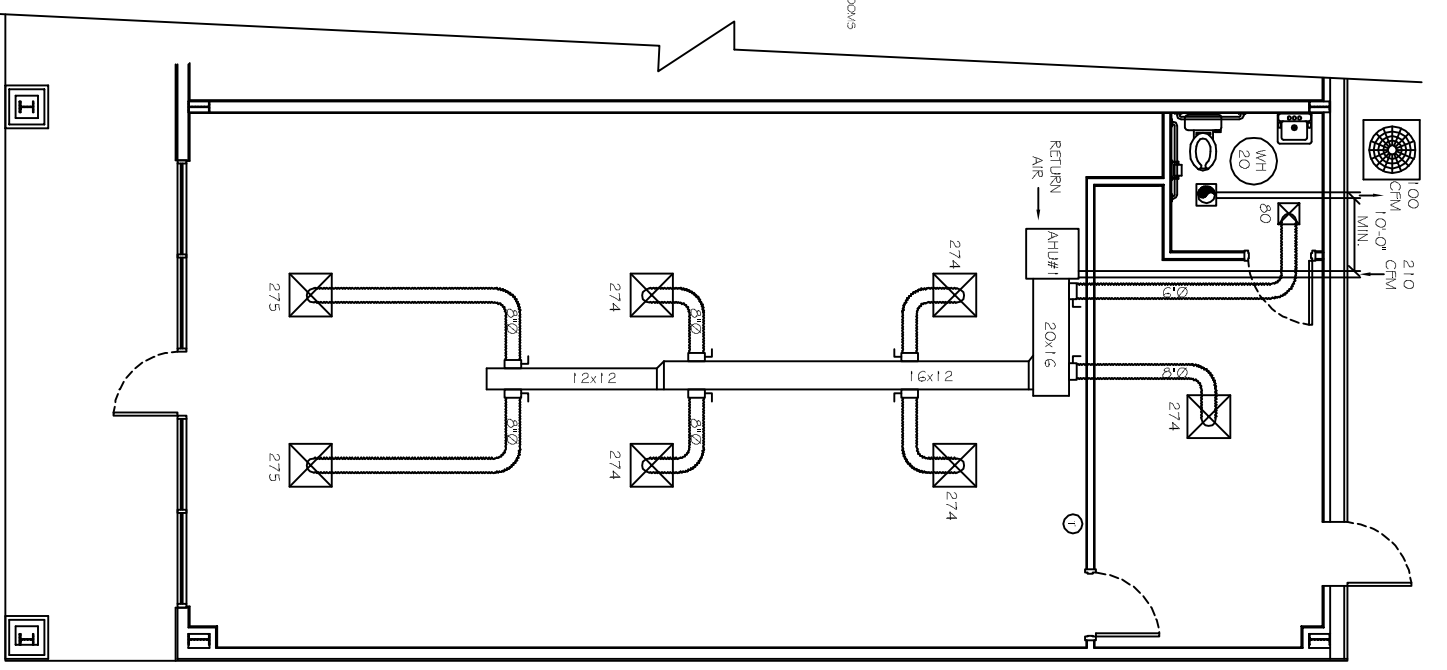

MECHANICAL PLAN  
SCALE: 1/4\"/>

<p><b>M-1</b></p> <p>SHEET No: 3 OF 4</p>	<p>MECHANICAL PLAN</p>	<p>REVISIONS</p> <table border="1"> <thead> <tr> <th>#</th> <th>DESCRIPTION</th> <th>DATE</th> </tr> </thead> <tbody> <tr> <td> </td> <td> </td> <td> </td> </tr> </tbody> </table>	#	DESCRIPTION	DATE				<p><b>DUDLEY SMITH PRINTING</b> TYLER SQUARE SUITE #1 58465 TYLER STREET SUDELL, LA</p>	<p>JOB No: 2152    DATE: 10-03-12</p> <p>DRAWN BY: BSN    CHECKED BY: BSN</p>	<p><b>DAMMON ENGINEERING, INC.</b> Architects &amp; Engineers</p> <p>CHIEF ENGINEER: ENMETT DAMMON, P.E. CHIEF ARCHITECT: ROBERT WILTSE 554 OLD SPANISH TRAIL SUDELL, LA 70450</p> <p>dammoneng@bellsouth.net PHONE: 905-649-5832 FAX: 905-641-5950</p>
		#	DESCRIPTION	DATE							