
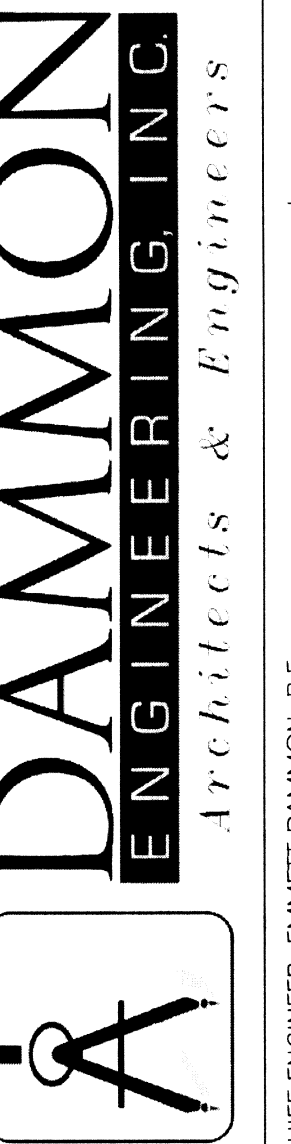
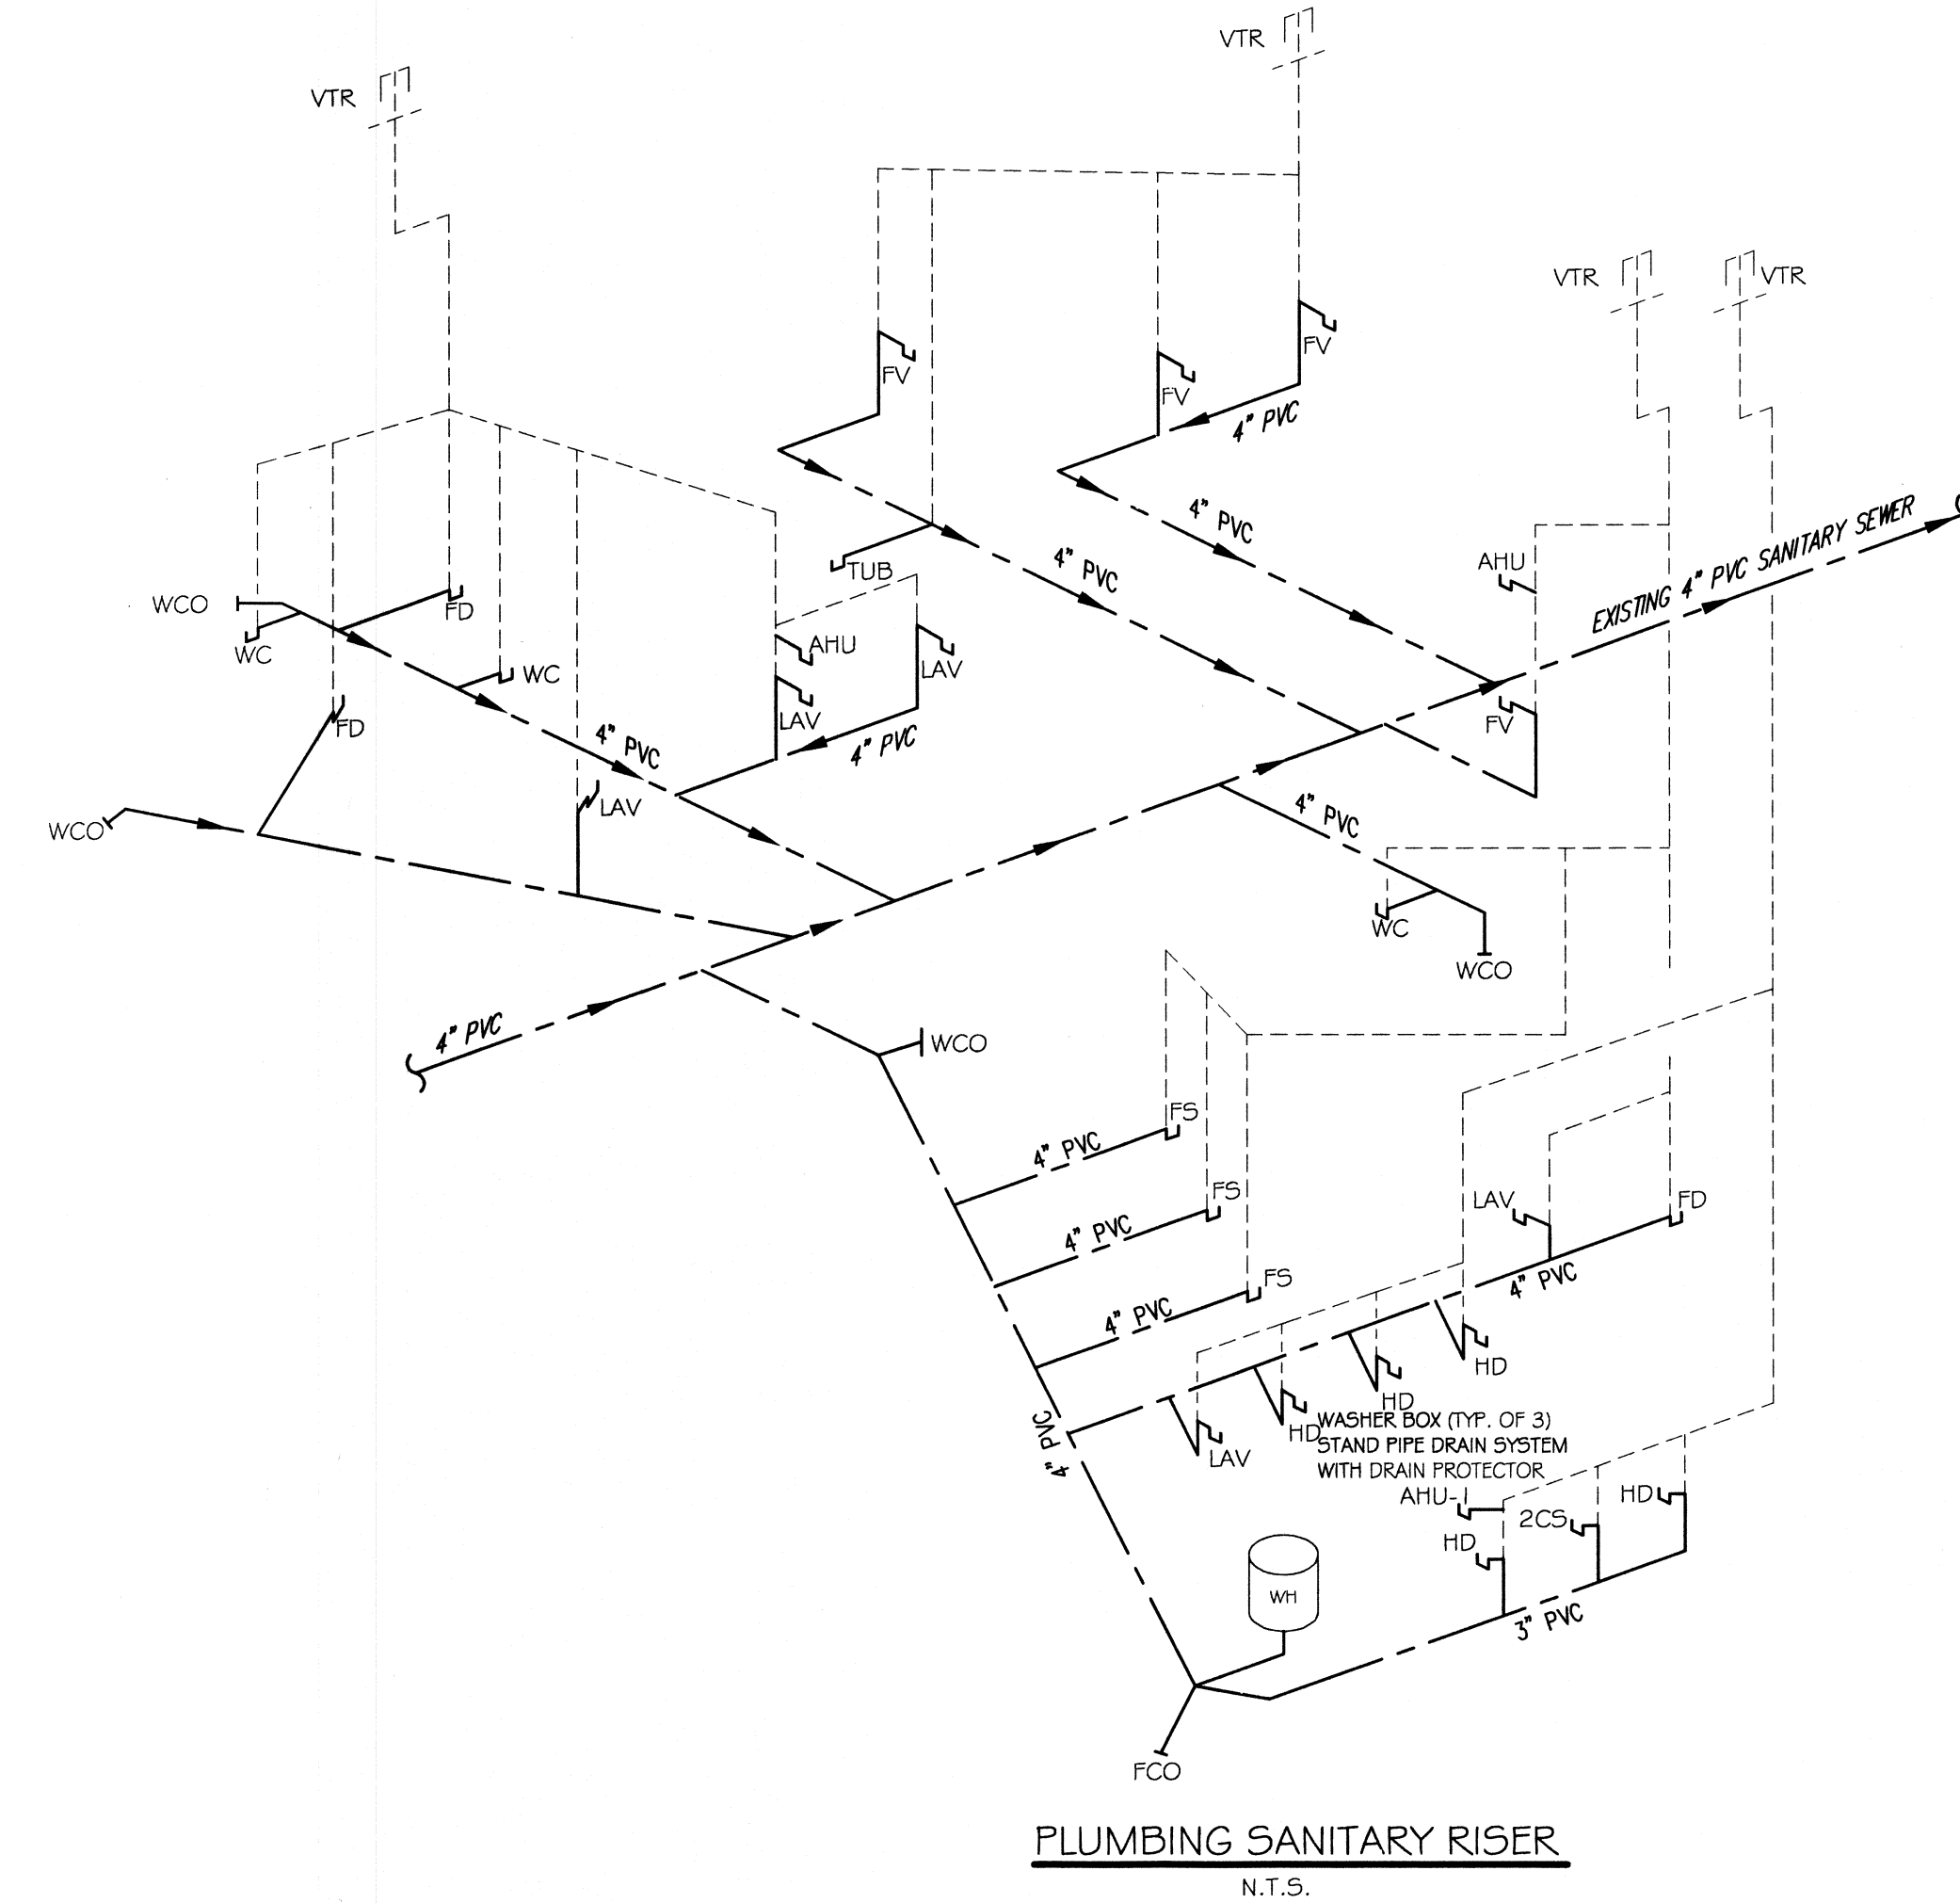


PLUMBING FIXTURE SCHEDULE

FIXTURE	
"WC"	WATER CLOSET
"LAV"	LAVATORY
"FV"	FACIAL VANITY
"TUB"	VINTAGE TUB
"EFS"	ECHO FOOT SPA
"2CS"	TWO COMP SINK
"US"	UTILITY SINK
"WH"	WATER HEATER
"FD"	FLOOR DRAIN
"HD"	HUB DRAIN
"FS"	FLOOR SINK

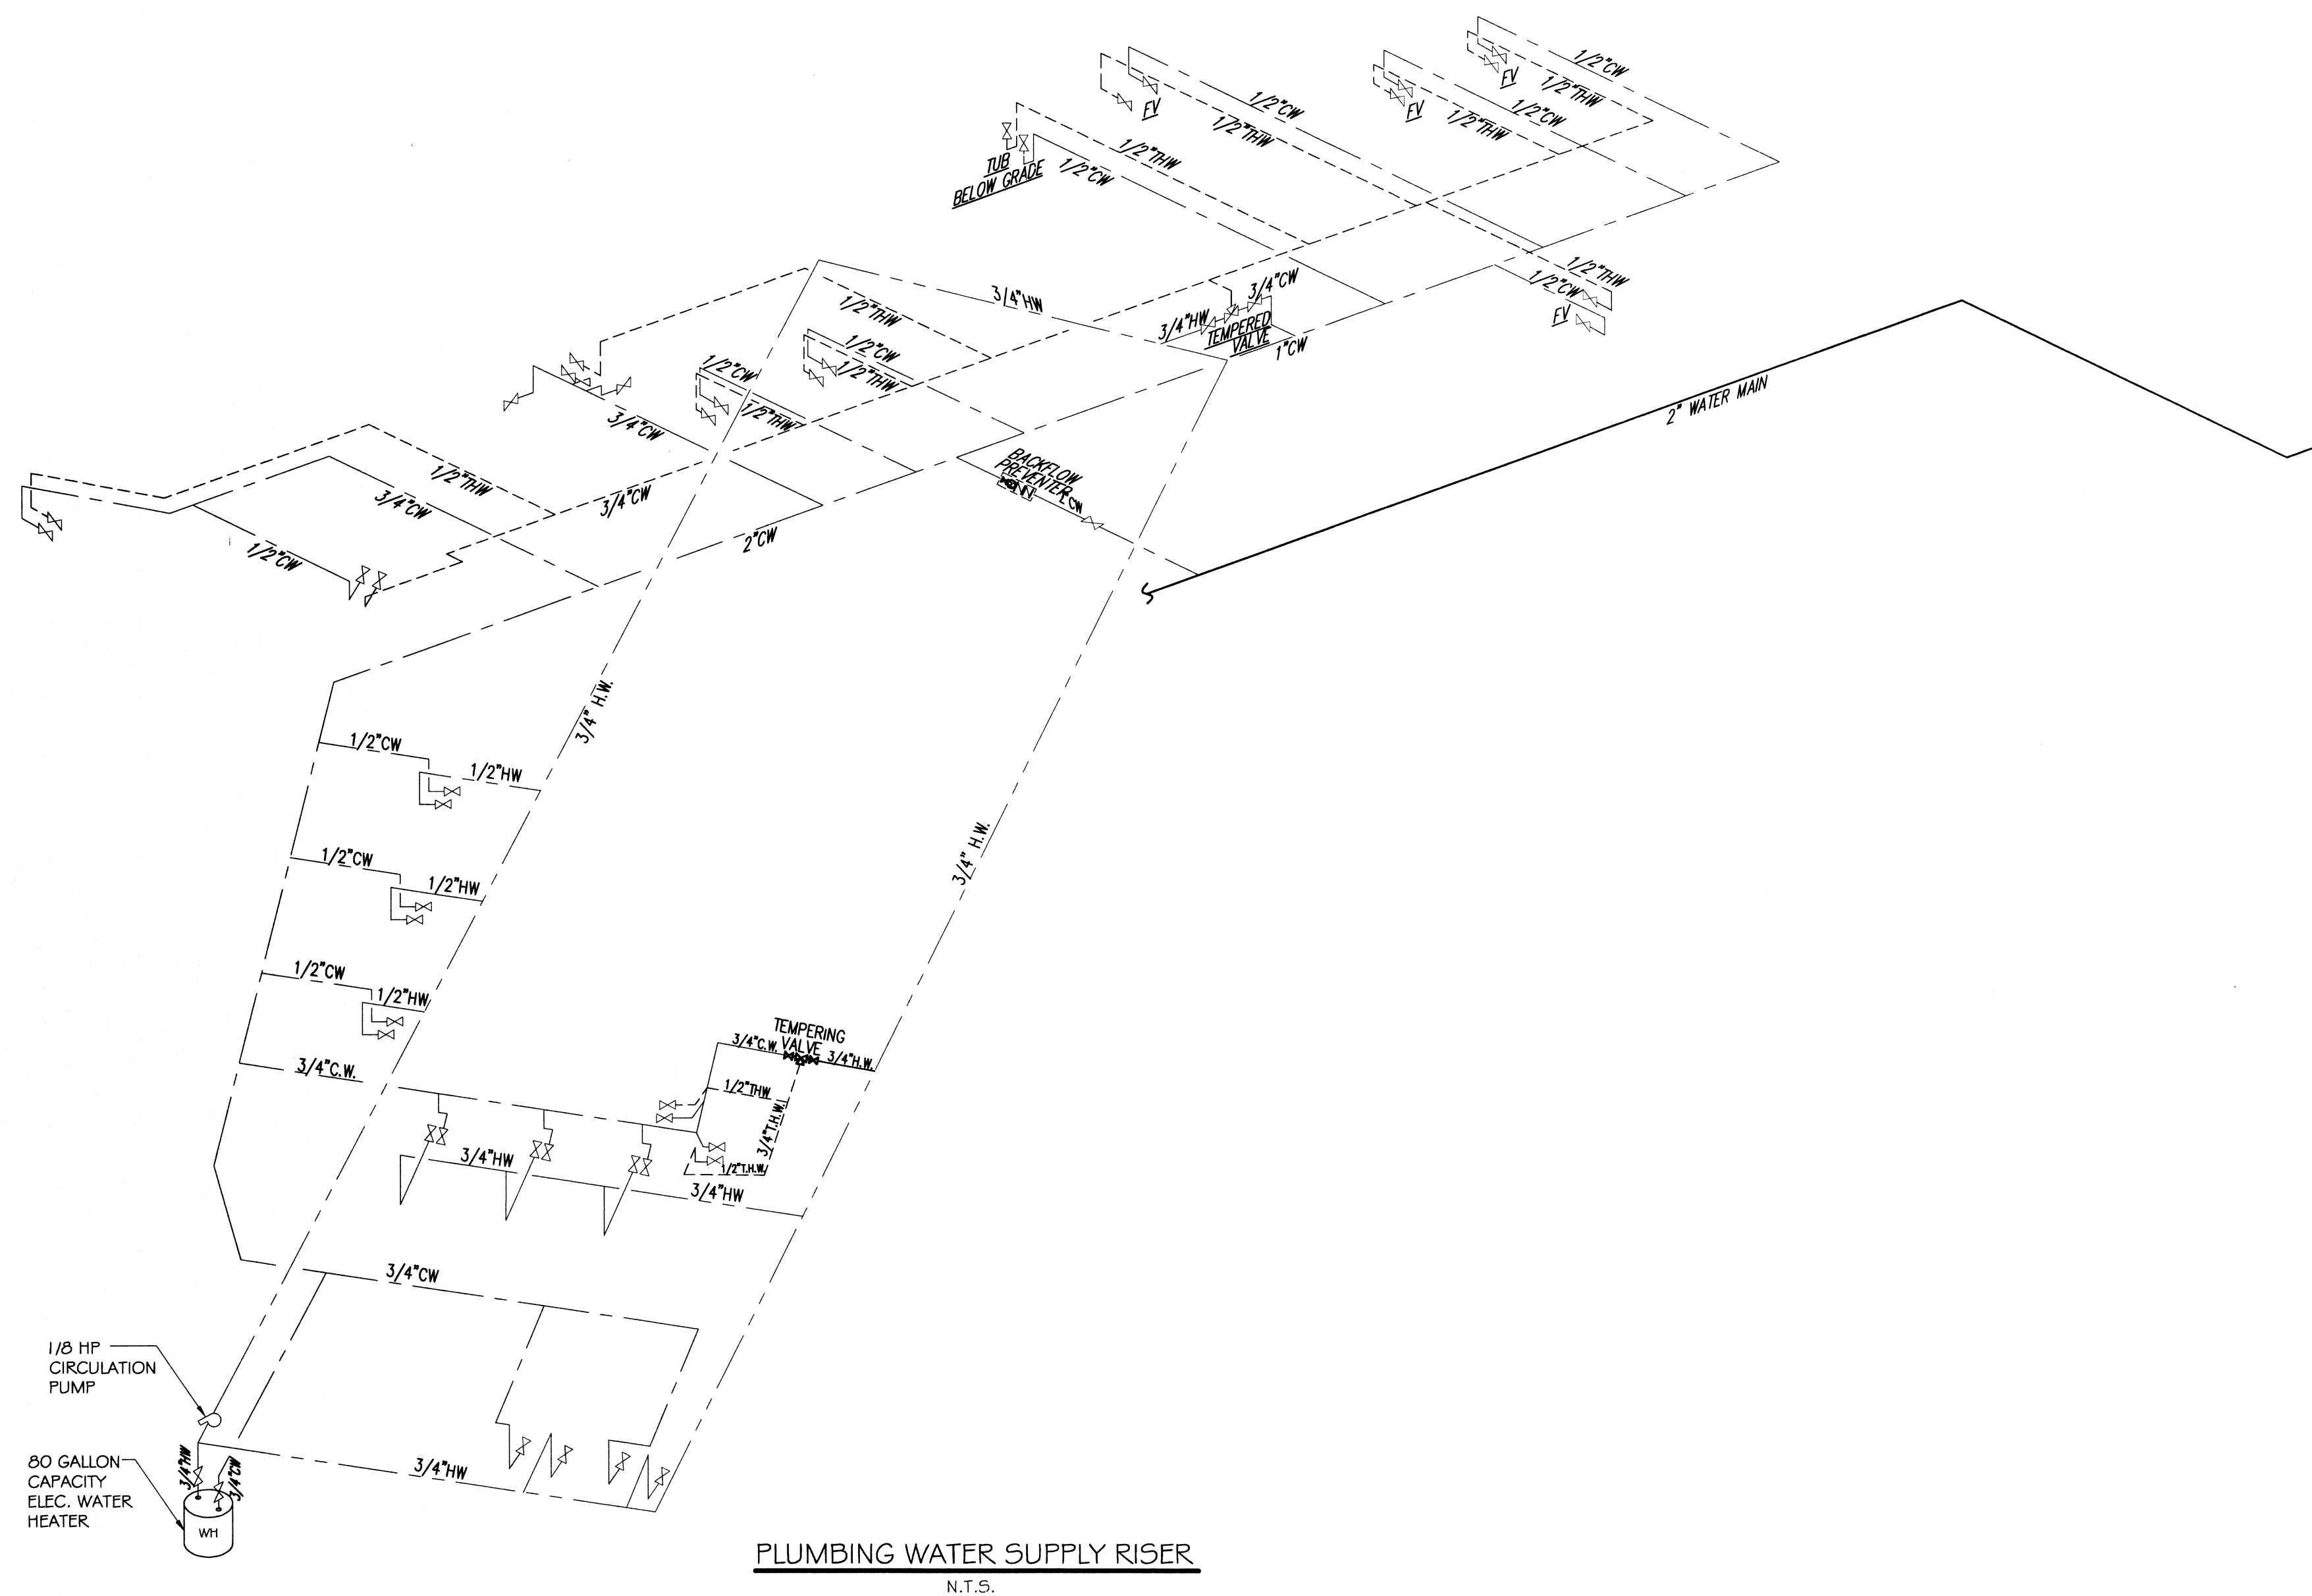

dammonengr.com
dammoneng@bellsouth.net
PHONE: 985-649-5832
FAX: 985-641-5950

CHIEF ENGINEER: EMMETT DAMMON, P.E.

CHIEF ARCHITECT: KEVIN KINCHEN

554 OLD SPANISH TRAIL

SLUDELL, LA 70458

WOODHOUSE SPA
THE HIGH GROVES APARTMENTS
BATON ROUGE, LA

JOB No: 2163 DATE: 2/4/2013

DRAWN BY: JCT CHECKED BY: KJK

#	DESCRIPTION	DATE
1	REVISION #1	5/23/2013
2	REVISION #2	7-22-13



PLUMBING RISER DIAGRAMS

SHEET No: 15 of 15

P-4

THIS PLAN IS DRAWN DIAGRAMMATICALLY
FIELD VERIFY PRIOR TO CONSTRUCTION