
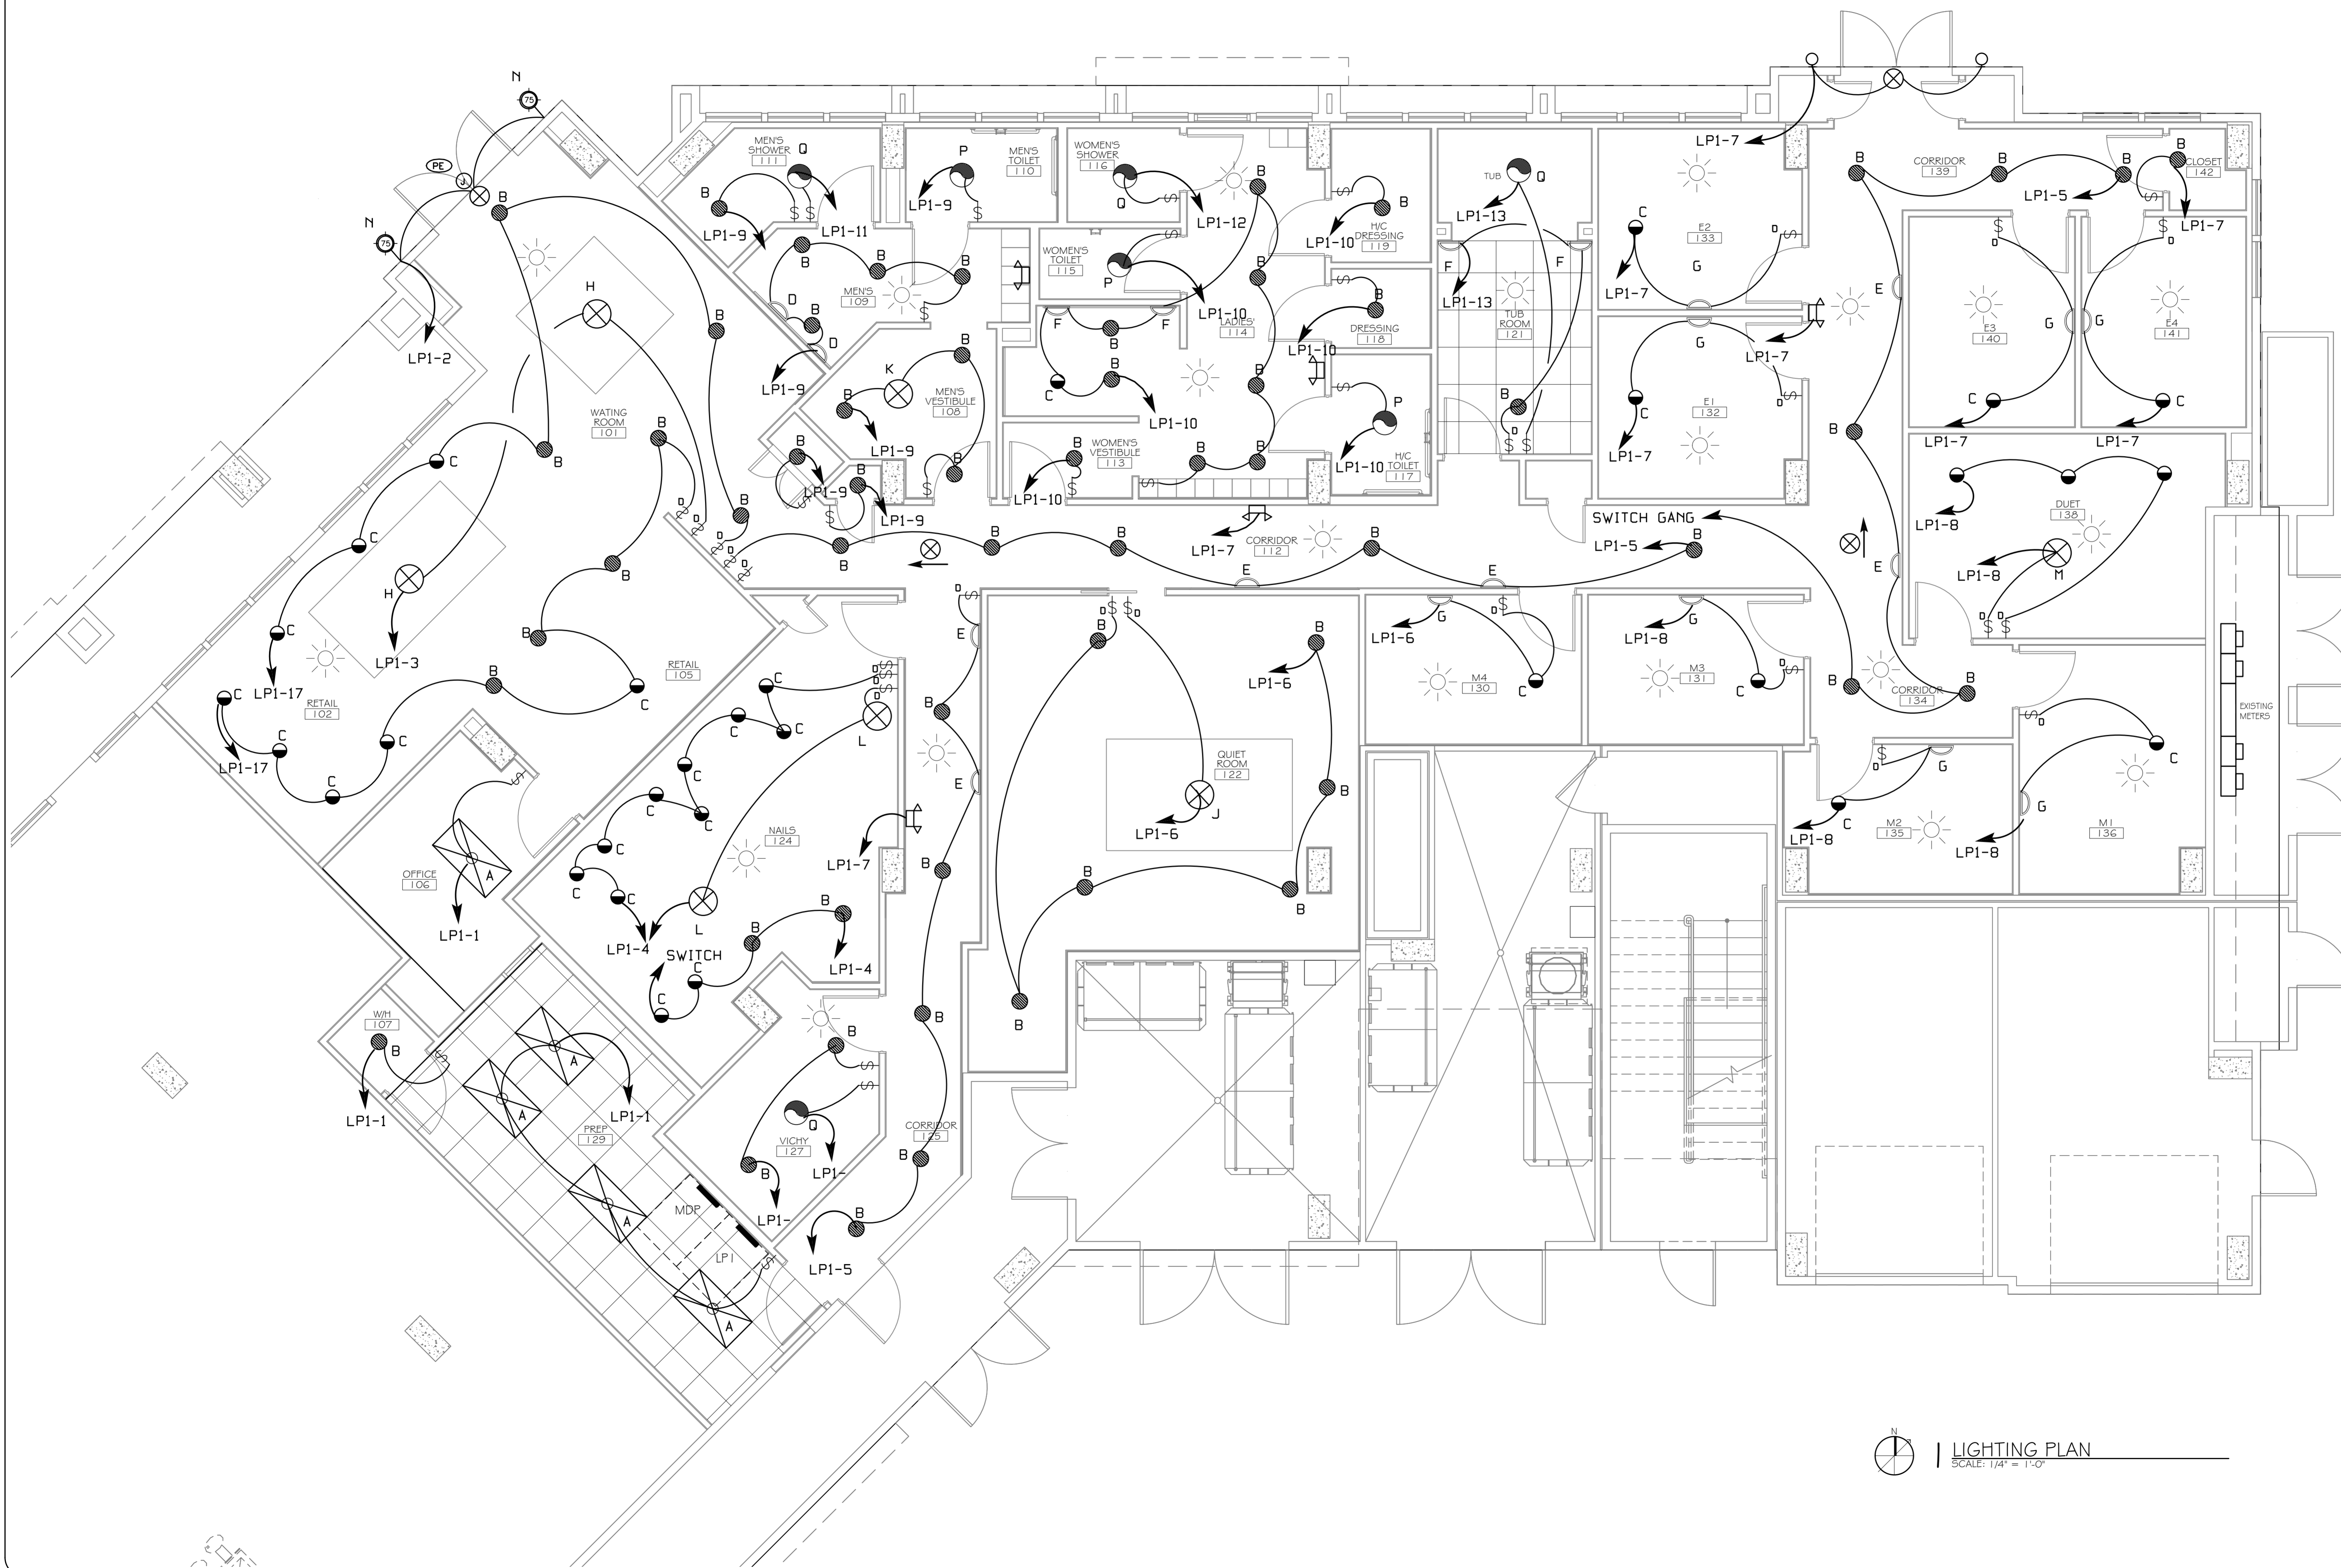


NOTE: ALL LIGHT FIXTURES AND LUMINAIRES ARE TO BE DIMMABLE AND CONNECTED TO A SLIDING DIMMER PACK, EXCEPT: OFFICE, MECHANICAL RM AND CLOSETS.

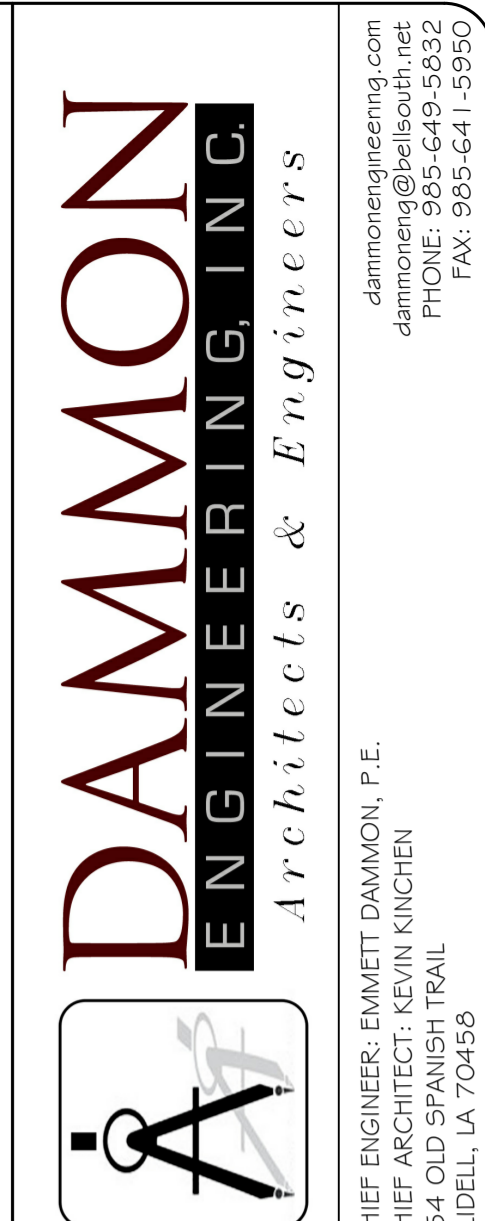


**LIGHTING PLAN**  
 SCALE: 1/4" = 1'-0"


**DAMMON**  
 ENGINEERING, INC.  
 Architects & Engineers

dammonengineering.com  
 dammoneng@bellsouth.net  
 PHONE: 985-649-5932  
 554 OLD SPANISH TRAIL  
 SUITE 100  
 SUDELL, LA 70455  
 FAX: 985-641-5950

CHIEF ENGINEER: DAMON DANON, P.E.  
 CHIEF ARCHITECT: KEVIN KIRCHEN  
 PROJECT ARCHITECT: SPANISH TRAIL

**WOODHOUSE SPA**  
 THE HIGH GROVES APARTMENTS  
 BATON ROUGE, LA

JOB No: 2163    DATE: 5/14/2013  
 DRAWN BY: KJK    CHECKED BY: KJK

#	DESCRIPTION	DATE

**LIGHTING PLAN**  
 SHEET No: 10 OF 15  
**E-2**