


LEGEND

- RECESSED CAN LIGHT
- DIRECTIONAL RECESSED CAN LIGHT
- ⊗ PENDANT LIGHT
- ⊕ CHANDELIER
- FANLIGHT
- ⊗ EXIT LIGHT

24"x24" SUSPENDED ACOUSTICAL TILE CEILING

5/8" GYPSUM BOARD CEILING

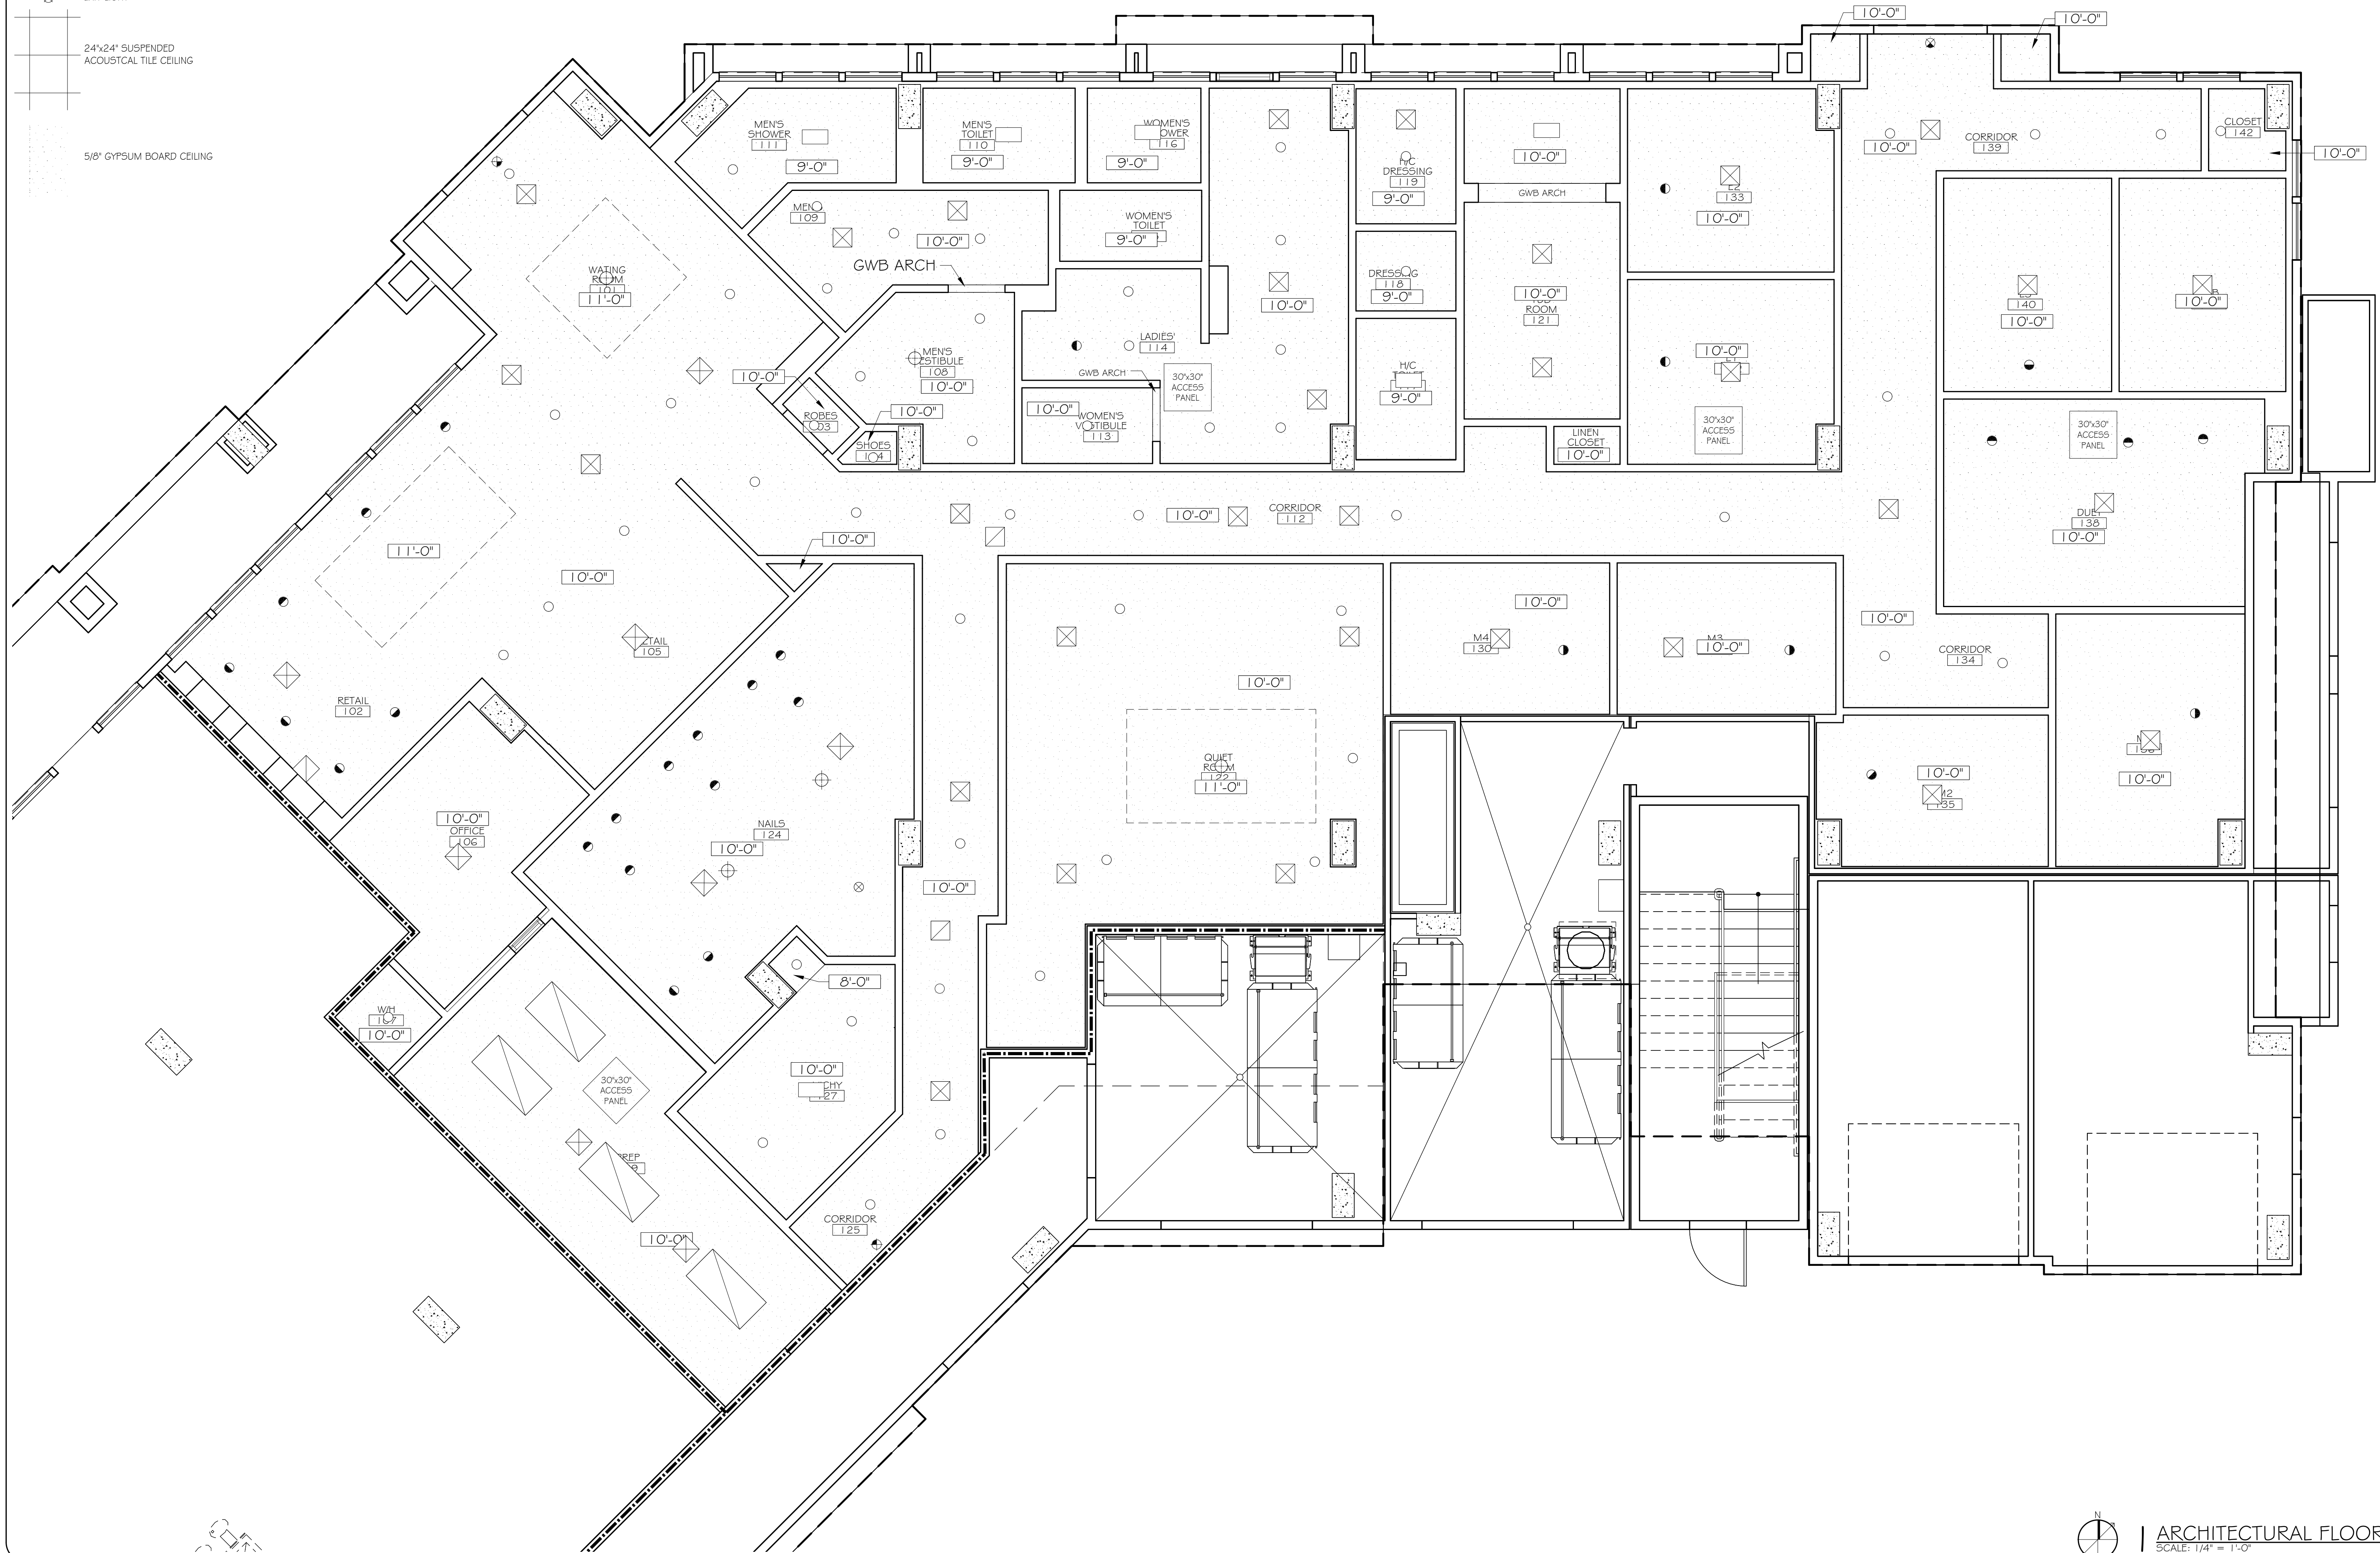

#	DESCRIPTION	DATE

JOB No: 2163 DATE: 2/4/2013
DRAWN BY: KJK CHECKED BY: KJK

REFLECTED CEILING PLAN

SHEET No: 4 OF 15

A-2

The floor, structure and production, including but not limited to, the property of Dammon Engineering, Inc. shall remain the property of Dammon Engineering, Inc. and shall not be used, copied, reproduced, or otherwise disseminated without the prior written consent of Dammon Engineering, Inc. All rights reserved.