


POWER PLAN LEGEND	
SYM.	DESCRIPTION
⊕	STANDARD 120V DUPLEX RECEPTACLE; NEMA 5-2 OR 18" H (UNLESS OTHERWISE NOTED)

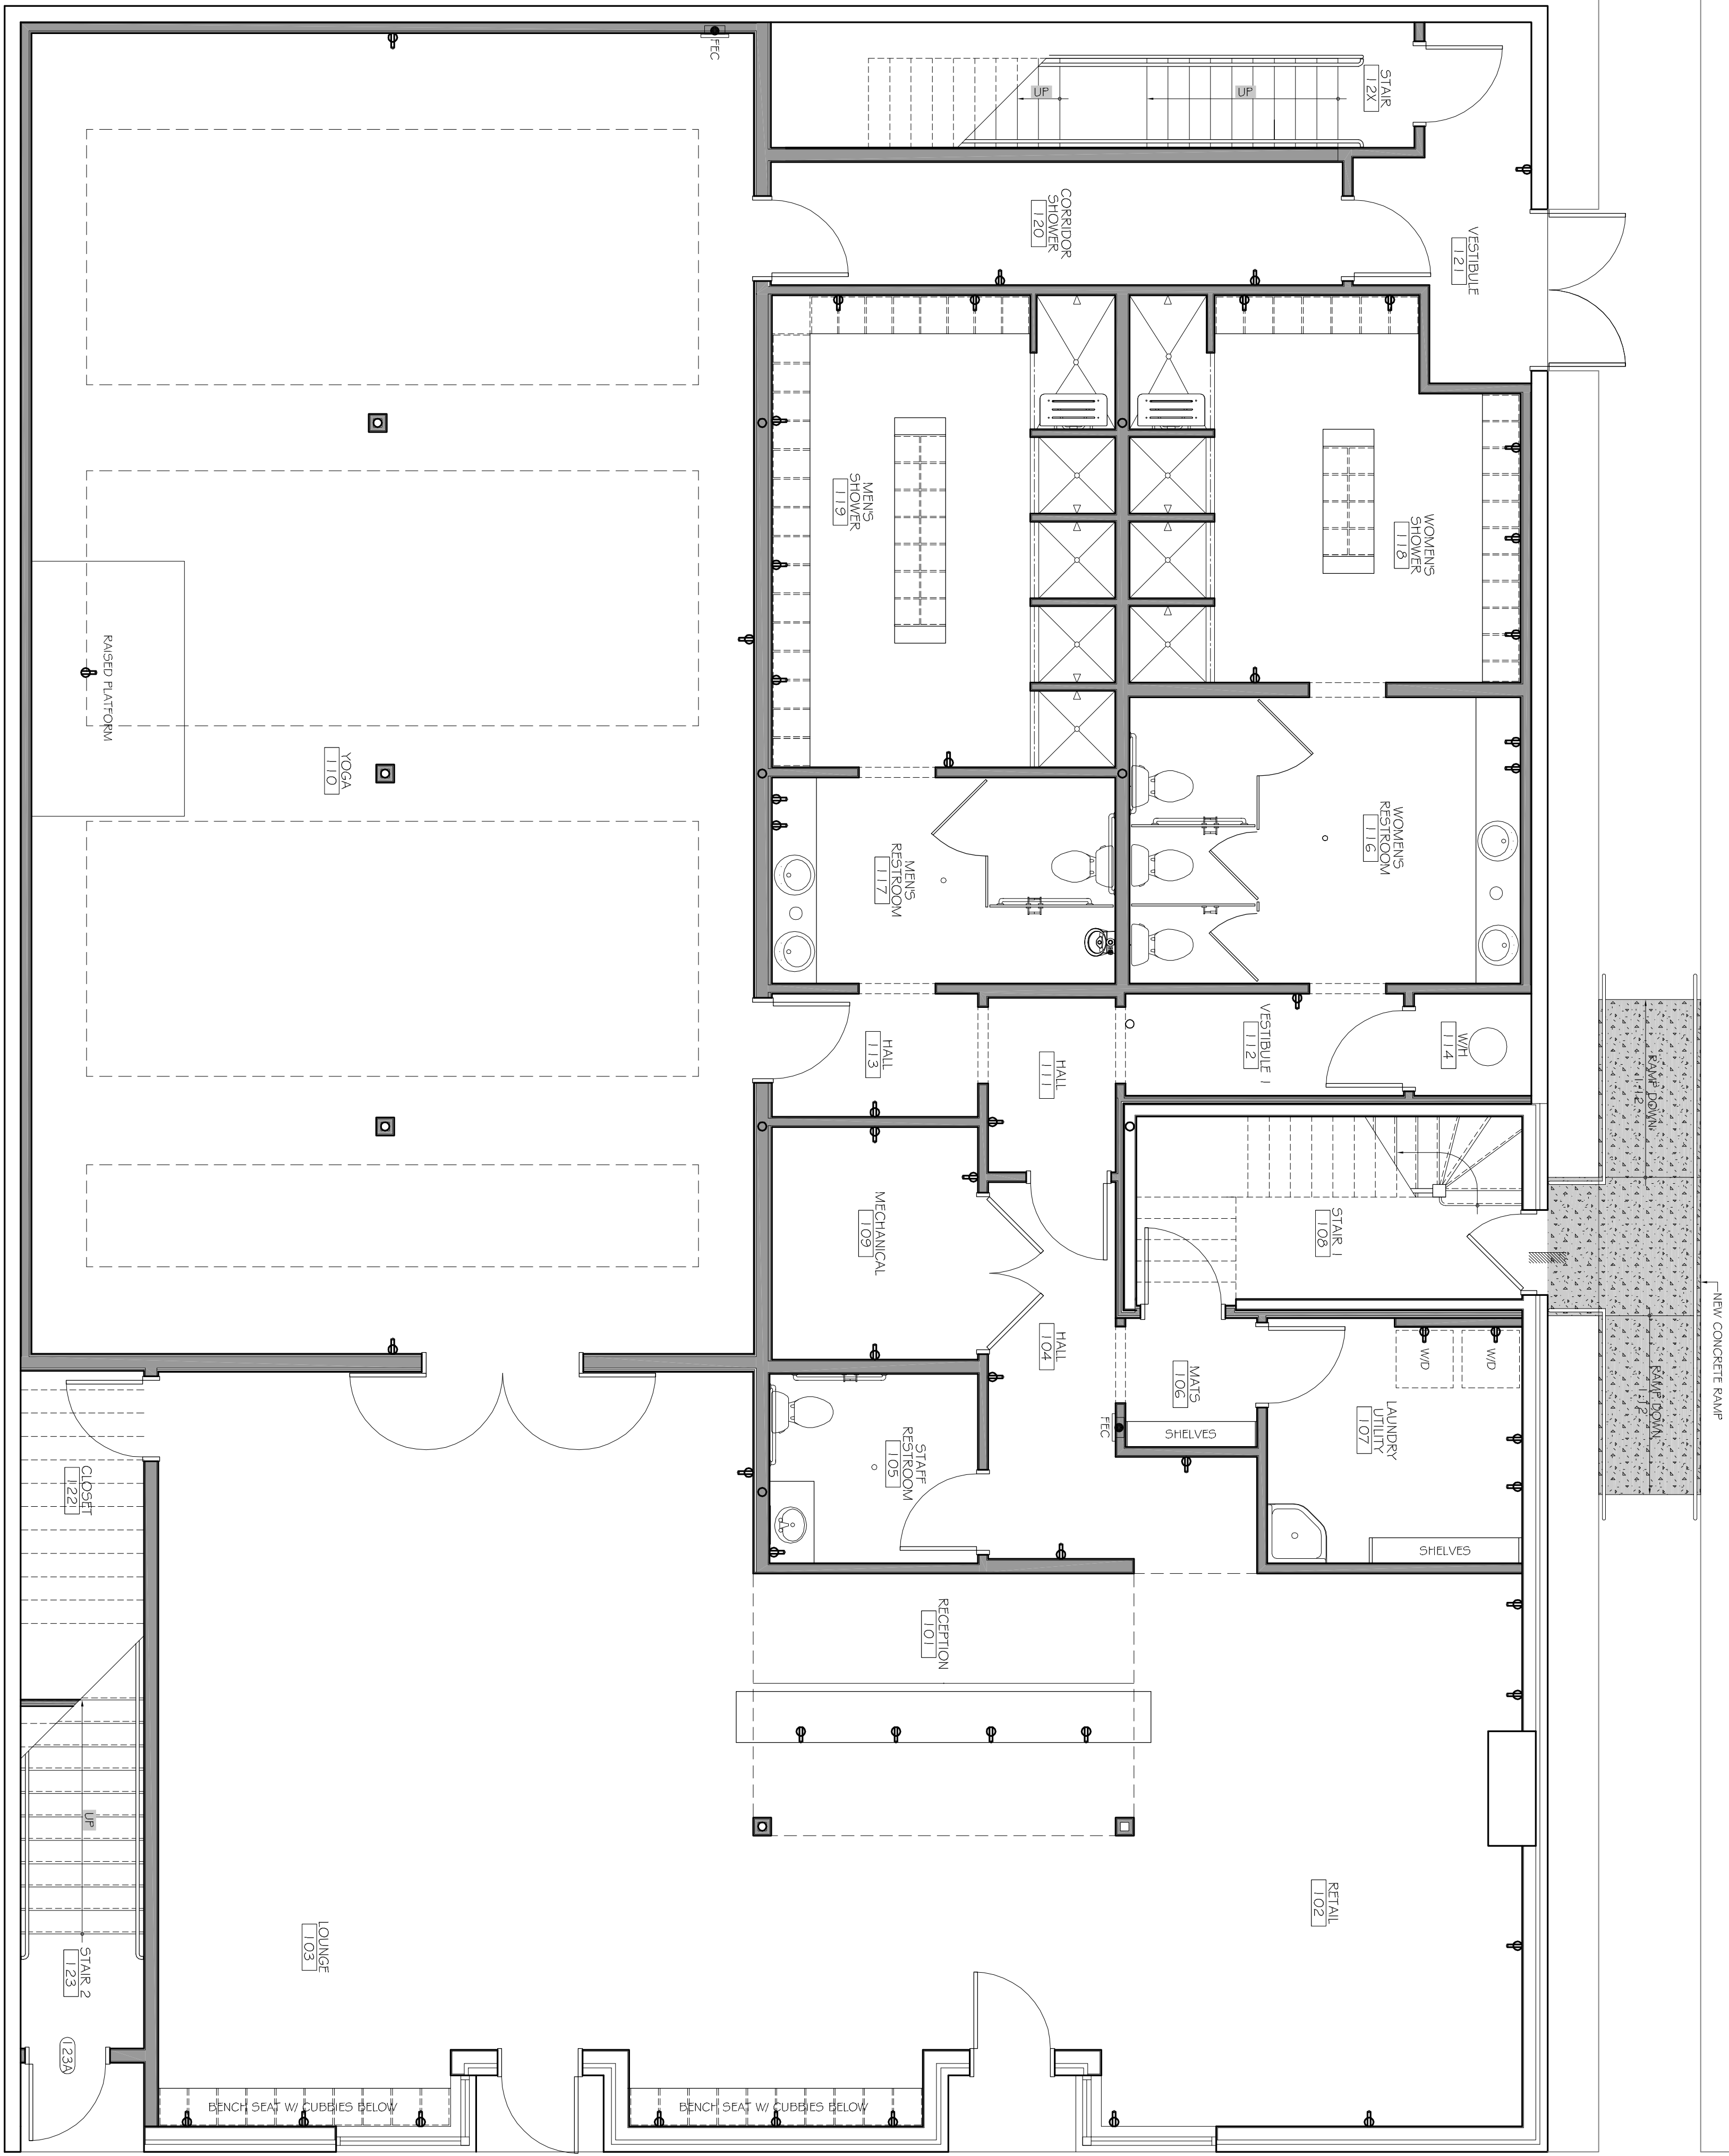

CAMERON STREET

OAK STREET

1 | ELECTRICAL PLAN
SCALE: 1/4" = 1'-0"

REVISIONS		
#	DESCRIPTION	DATE

BIKRAM YOGA STUDIO
8338 OAK STREET
NEW ORLEANS, LA 70118

JOB No: 2175 DATE: 5-6-2013
DRAWN BY: JCT CHECKED BY: KJK

The above drawings and specifications, design and arrangements represented thereby are and shall remain the property of Dammon Engineering, and no part thereof shall be copied, abstracted or taken, or used in connection with any work or project other than the specific project for which the fee has been prepared and delivered without written consent of Dammon Engineering. Visual contact with these drawings or specifications shall constitute constructive acceptance of these restrictions.



DAMMON
ENGINEERING, INC.
Architects & Engineers

CHIEF ENGINEER: EMMETT DAMMON, P.E.
CHIEF ARCHITECT: KEVIN KINCHEN, NCARB
554 OLD SPANISH TRAIL
SLIDELL, LA 70456

dammonengineering.com
dammoneng@bellsouth.net
PHONE: 985-649-5832
FAX: 985-641-5950

SHEET No: 00 of 00

FIRST FLOOR PLAN

E1