


LUMINAIRE SCHEDULE						
Symbol	Label	Qty	Catalog Number	Description	Lamp	Watts
	A	1	Z 1 54T5HO	Z STRIP FOR (1) 54W T5HO LAMP	ONE 54-WATT T5 LINEAR FLUORESCENT HO, HORIZONTAL POS.	56.6
○	B	41	LCP with Acculamp	6" LED RECESSED DOWNLIGHT, 1500 LUMENS 0.65 SPACING 3500K CCT	Acculamp	18.8
□	C	3	2GT8 3 32 A1 2 1/3 ADDE	GT8 GENERAL PURPOSE T8 TROFFER 2X4' 3 LP T8 #A1 2 LENS 1/3 ELEC	THREE 32-WATT T8 LINEAR FLUORESCENT.	88
○	D	23	LF6N 2/2GDT MVOLT FGLD2 PF	6" LENSED DOWNLIGHT WITH DROP PRISMATIC PLASTIC LENS, PLASTIC FLANGE.	TWO 26-WATT DOUBLE TWIN TUBE COMPACT FLUORESCENT, HORIZONTAL POSITION.	62
	E	52	Z 2 54T5HO ASR	Z STRIP FOR (2) 54W T5HO LAMPS, ASYMMETRIC WHITE REFLECTOR	TWO 54-WATT T5 LINEAR FLUORESCENT HO, HORIZONTAL POS.	120.6
	F	40	Ecosense Linear INT	4' LED Undercabinet strip	LED	7.1
△	G	24	Con-Tech	Track Head	50 watt MR-16	50
	H	4	LITHONIA LIGHTING	4' WALL MOUNTED	32 WATT FLOURESCENT	32
⊙	J	8		EXIT LIGHTS WITH 90 MIN BACK-UP		100
✂	K	3	PROVIDED BY OWNER	FAN PROV. BY OWNER		100
⊗	L	2	PROVIDED BY OWNER	PENDANT LIGHT		20
⏏	M	11		EMERGENCY EXIT LIGHT WITH 90 MIN BACK-UP		100
⊗	N	2	BEGA-US NO. 2893P	EXTERIOR LIGHT		32

LIGHTING PLAN
SCALE: 1/4" = 1'-0"

- A. YOGA STUDIO; 400 AMP 3Ø METER W/400 AMP BREAKER AS MEANS OF DISCONNECT.
- B. RESIDENCE; 200 AMP 1Ø METER W/200 AMP BREAKER AS MEANS OF DISCONNECT.
- C. HOUSE METER; 200 AMP 1Ø METER W/200 AMP BREAKER AS MEANS OF DISCONNECT.
- D. NEMA 3R WIREWAY

ONE LINE DIAGRAM

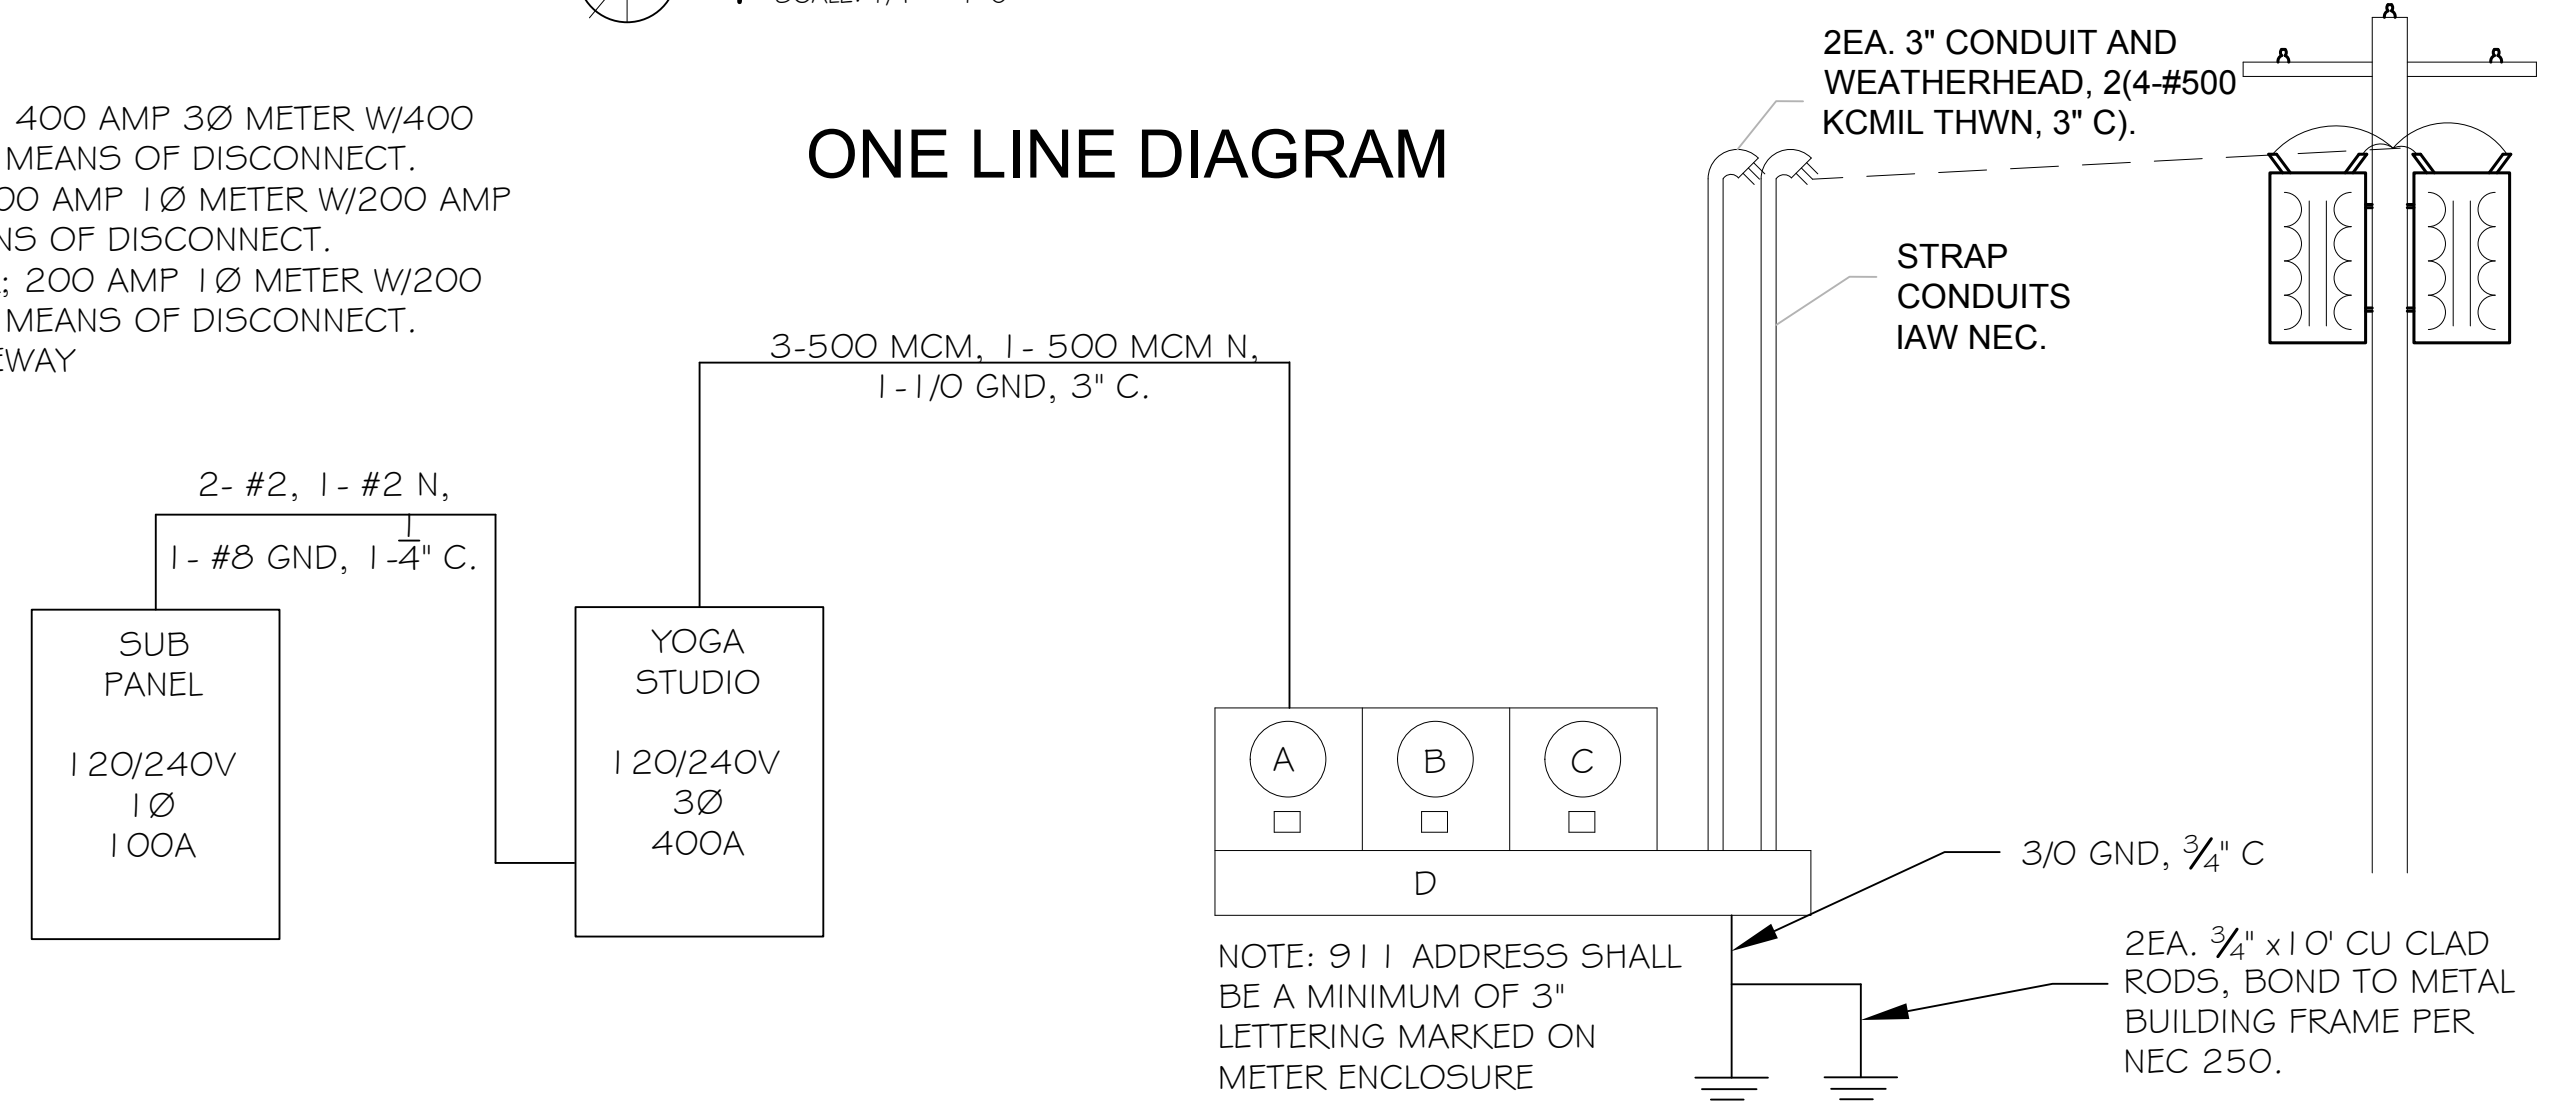

#	DESCRIPTION	DATE

LIGHTING PLAN