



**TUNNEL WALL EQUIPMENT ROOM**  
 1-SEE LEGEND SHEET  
 2-CONNECTIONS SHOWN IN THE ELEVATION VIEW ARE SCHEMATIC ONLY. REFER TO PLAN VIEWS FOR PLACEMENT.

**DRY WALL EQUIPMENT ROOM**

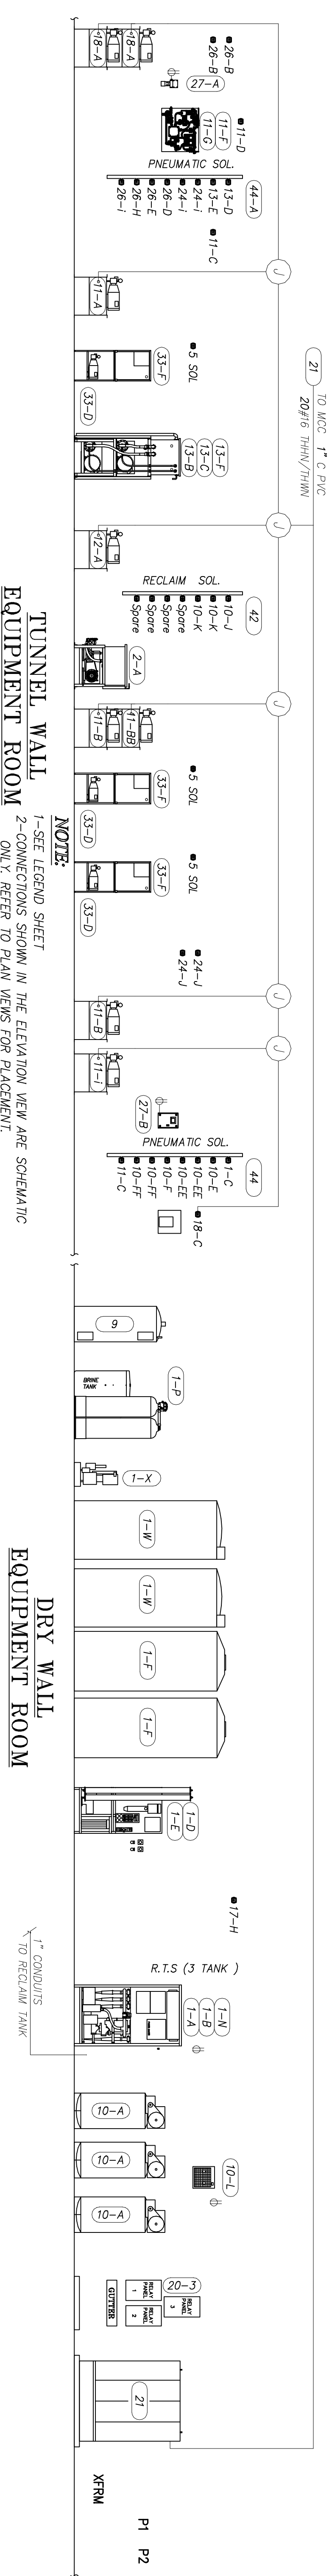

**TUNNEL WALL EQUIPMENT ROOM**  
 1-SEE LEGEND SHEET  
 2-CONNECTIONS SHOWN IN THE ELEVATION VIEW ARE SCHEMATIC ONLY. REFER TO PLAN VIEWS FOR PLACEMENT.

**DRY WALL EQUIPMENT ROOM**

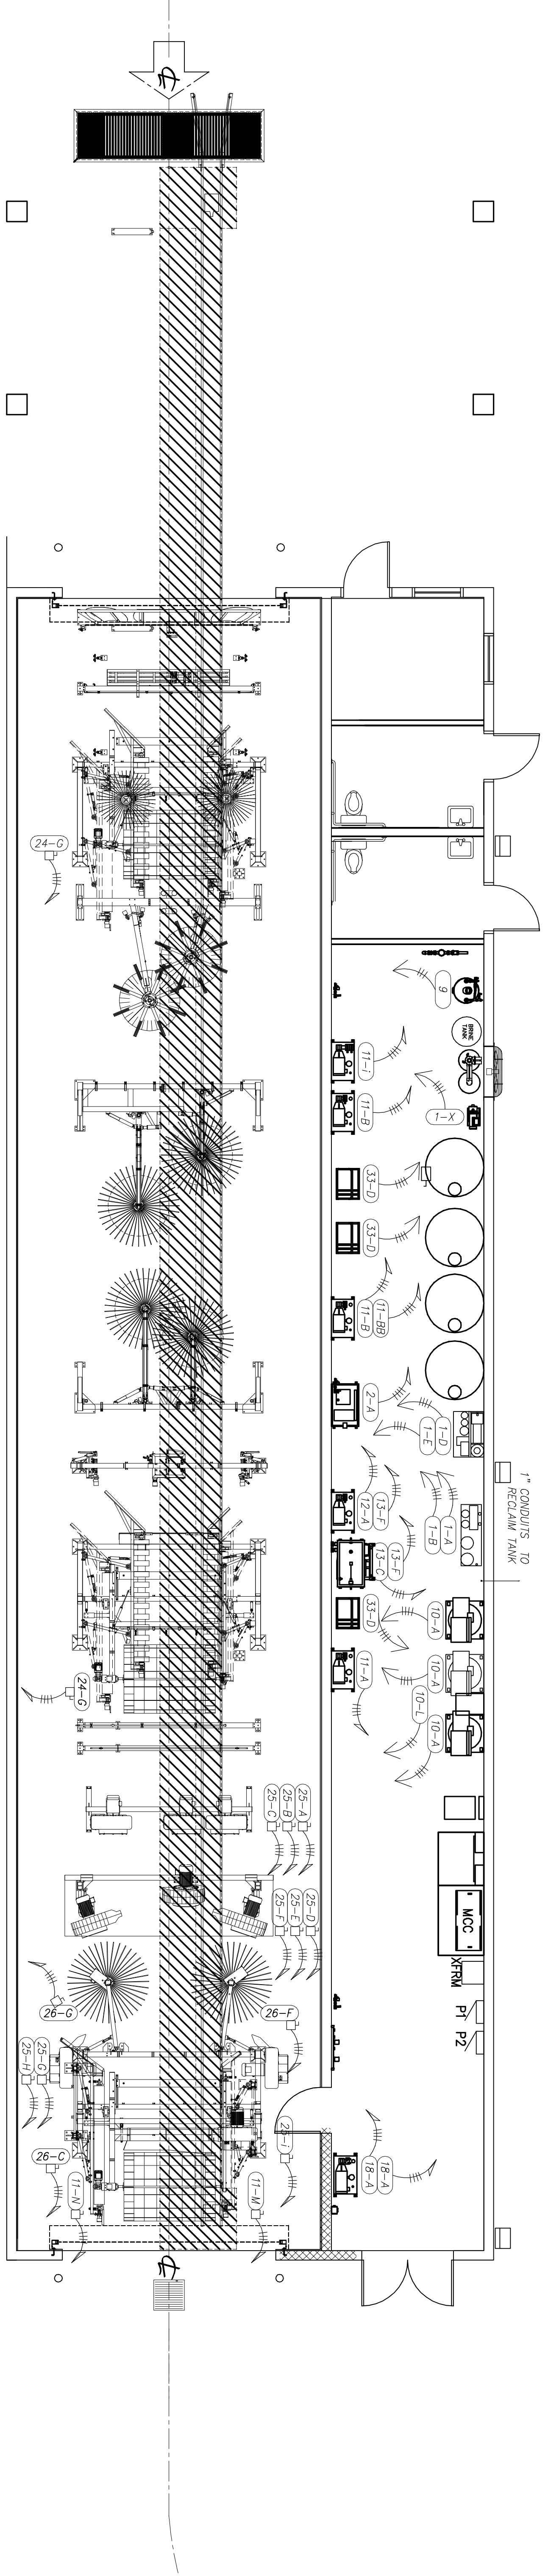

CARWASH ELECTRICAL PLAN  
 SCALE: 3/16"=1'-0"

REVISIONS		DATE
#	DESCRIPTION	DATE
A	ADDED RESTROOMS	07-19-13

**RAINFOREST CARWASH**  
 5026 HARDY ST.  
 HATTIESBURG, MISSISSIPPI

JOB No: 2176      DATE: 06-28-2013  
 DRAWN BY: JCT      CHECKED BY: CD

The above drawings and specifications, design and arrangements represented hereby are and shall remain the property of Dammon Engineering, and no part thereof shall be copied, reproduced or otherwise used in connection with any work or project other than the specific project for which they have been prepared and approved without written consent of Dammon Engineering. Visual contact with these drawings or specifications shall constitute conclusive evidence of acceptance of these restrictions.

**DAMMON ENGINEERING, INC.**

CHIEF ENGINEER, EMMETT DAMMON, P.E.  
 554 OLD SPANISH TRAIL  
 SLIDELL, LA 70458

dammonengneering.com  
 dammoneng@bellsouth.net  
 PHONE: 985-649-5832  
 FAX: 985-641-5950

CARWASH ELECTRICAL PLAN

SHEET No: 12 OF 22

**E-1**