



TUNNEL WALL EQUIPMENT ROOM
 1-SEE LEGEND SHEET
 2-CONNECTIONS SHOWN IN THE ELEVATION VIEW ARE SCHEMATIC ONLY. REFER TO PLAN VIEWS FOR PLACEMENT.

DRY WALL EQUIPMENT ROOM
 1-SEE LEGEND SHEET
 2-CONNECTIONS SHOWN IN THE ELEVATION VIEW ARE SCHEMATIC ONLY. REFER TO PLAN VIEWS FOR PLACEMENT.

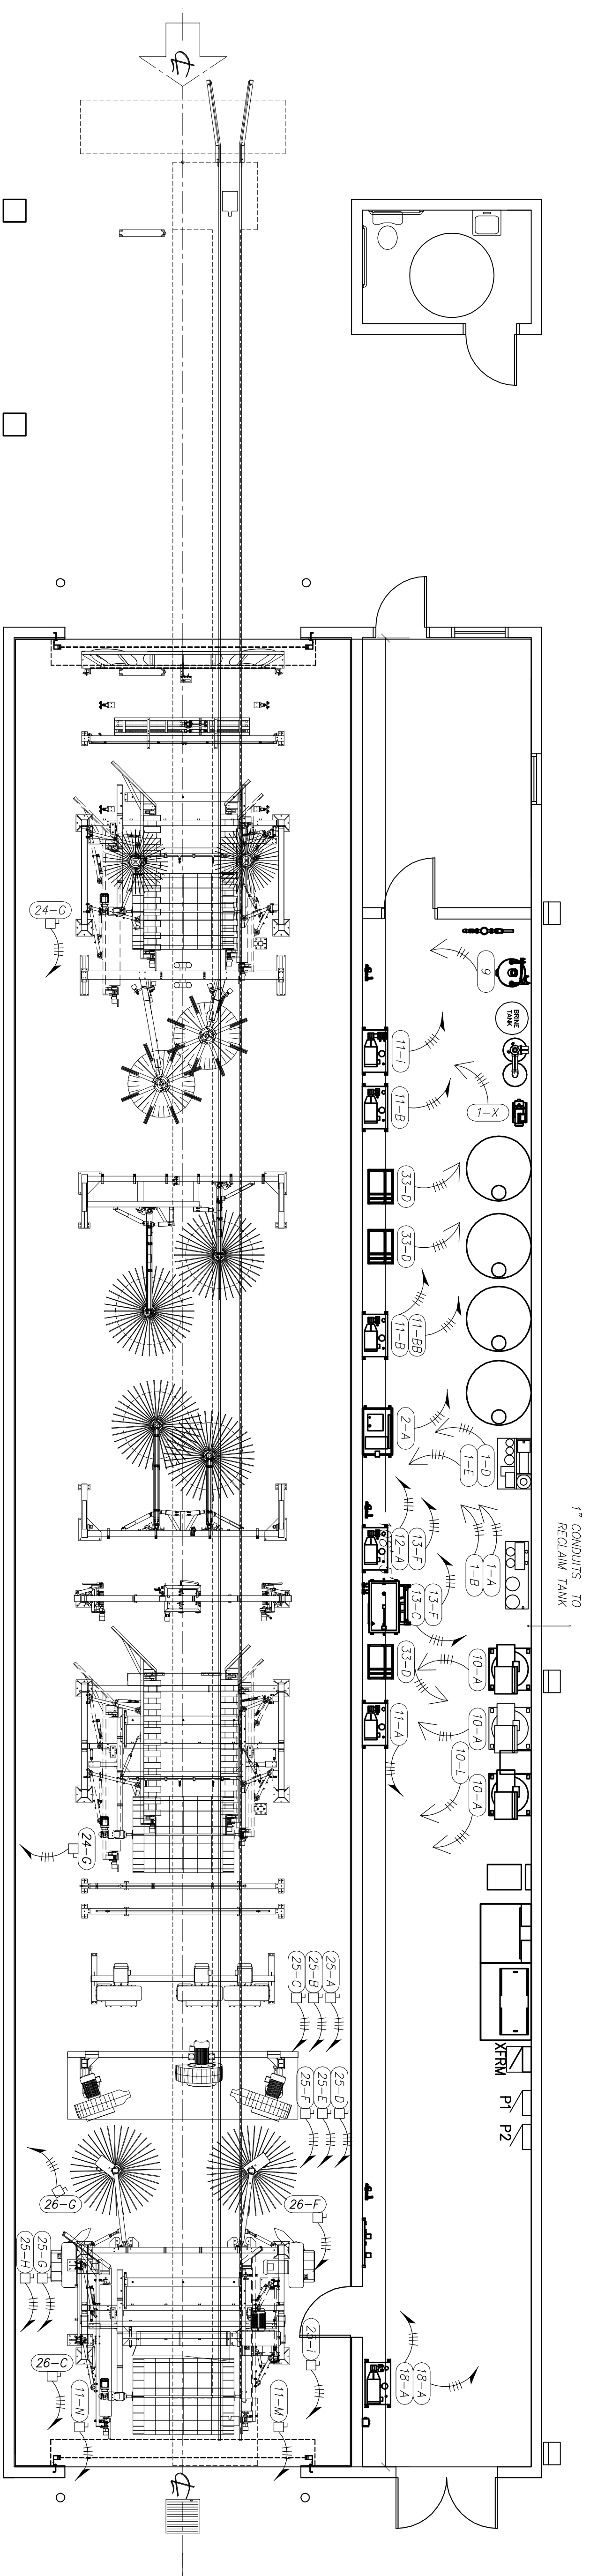

CARWASH ELECTRICAL POWER PLAN
 SCALE: 3/16" = 1'-0"

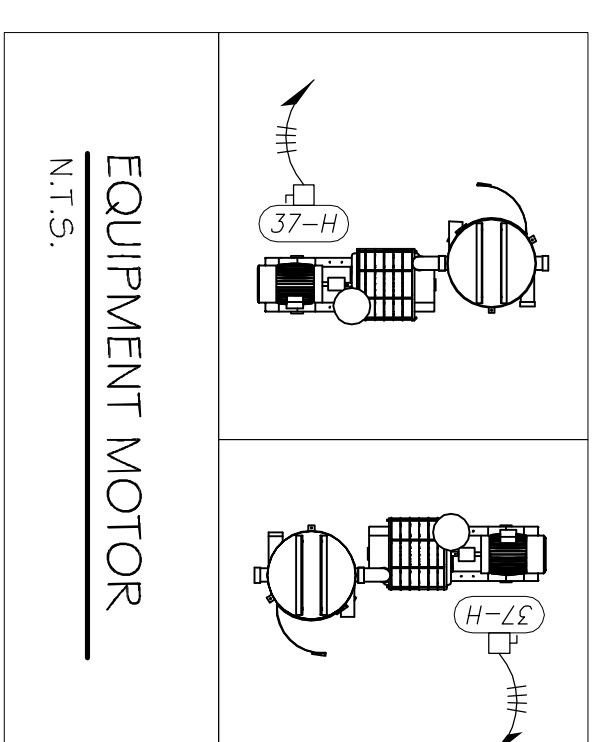

#	DESCRIPTION	REVISIONS	DATE

RAINFOREST CARWASH
 5026 HARDY ST.
 HATTIESBURG, MISSISSIPPI

JOB No: 2176 DATE: 06-28-2013
 DRAWN BY: JCT CHECKED BY: CD

DAMMON ENGINEERING, INC.
 CHIEF ENGINEER, EMMETT DAMMON, P.E.
 554 OLD SPANISH TRAIL
 SLIDELL, LA 70458

dammoneengineering.com
 dammoneng@bellsouth.net
 PHONE: 985-649-5832
 FAX: 985-641-5950