


FILE NAME: J:\Projects\10th Floor\10th Floor.dwg DATE: 07-15-21

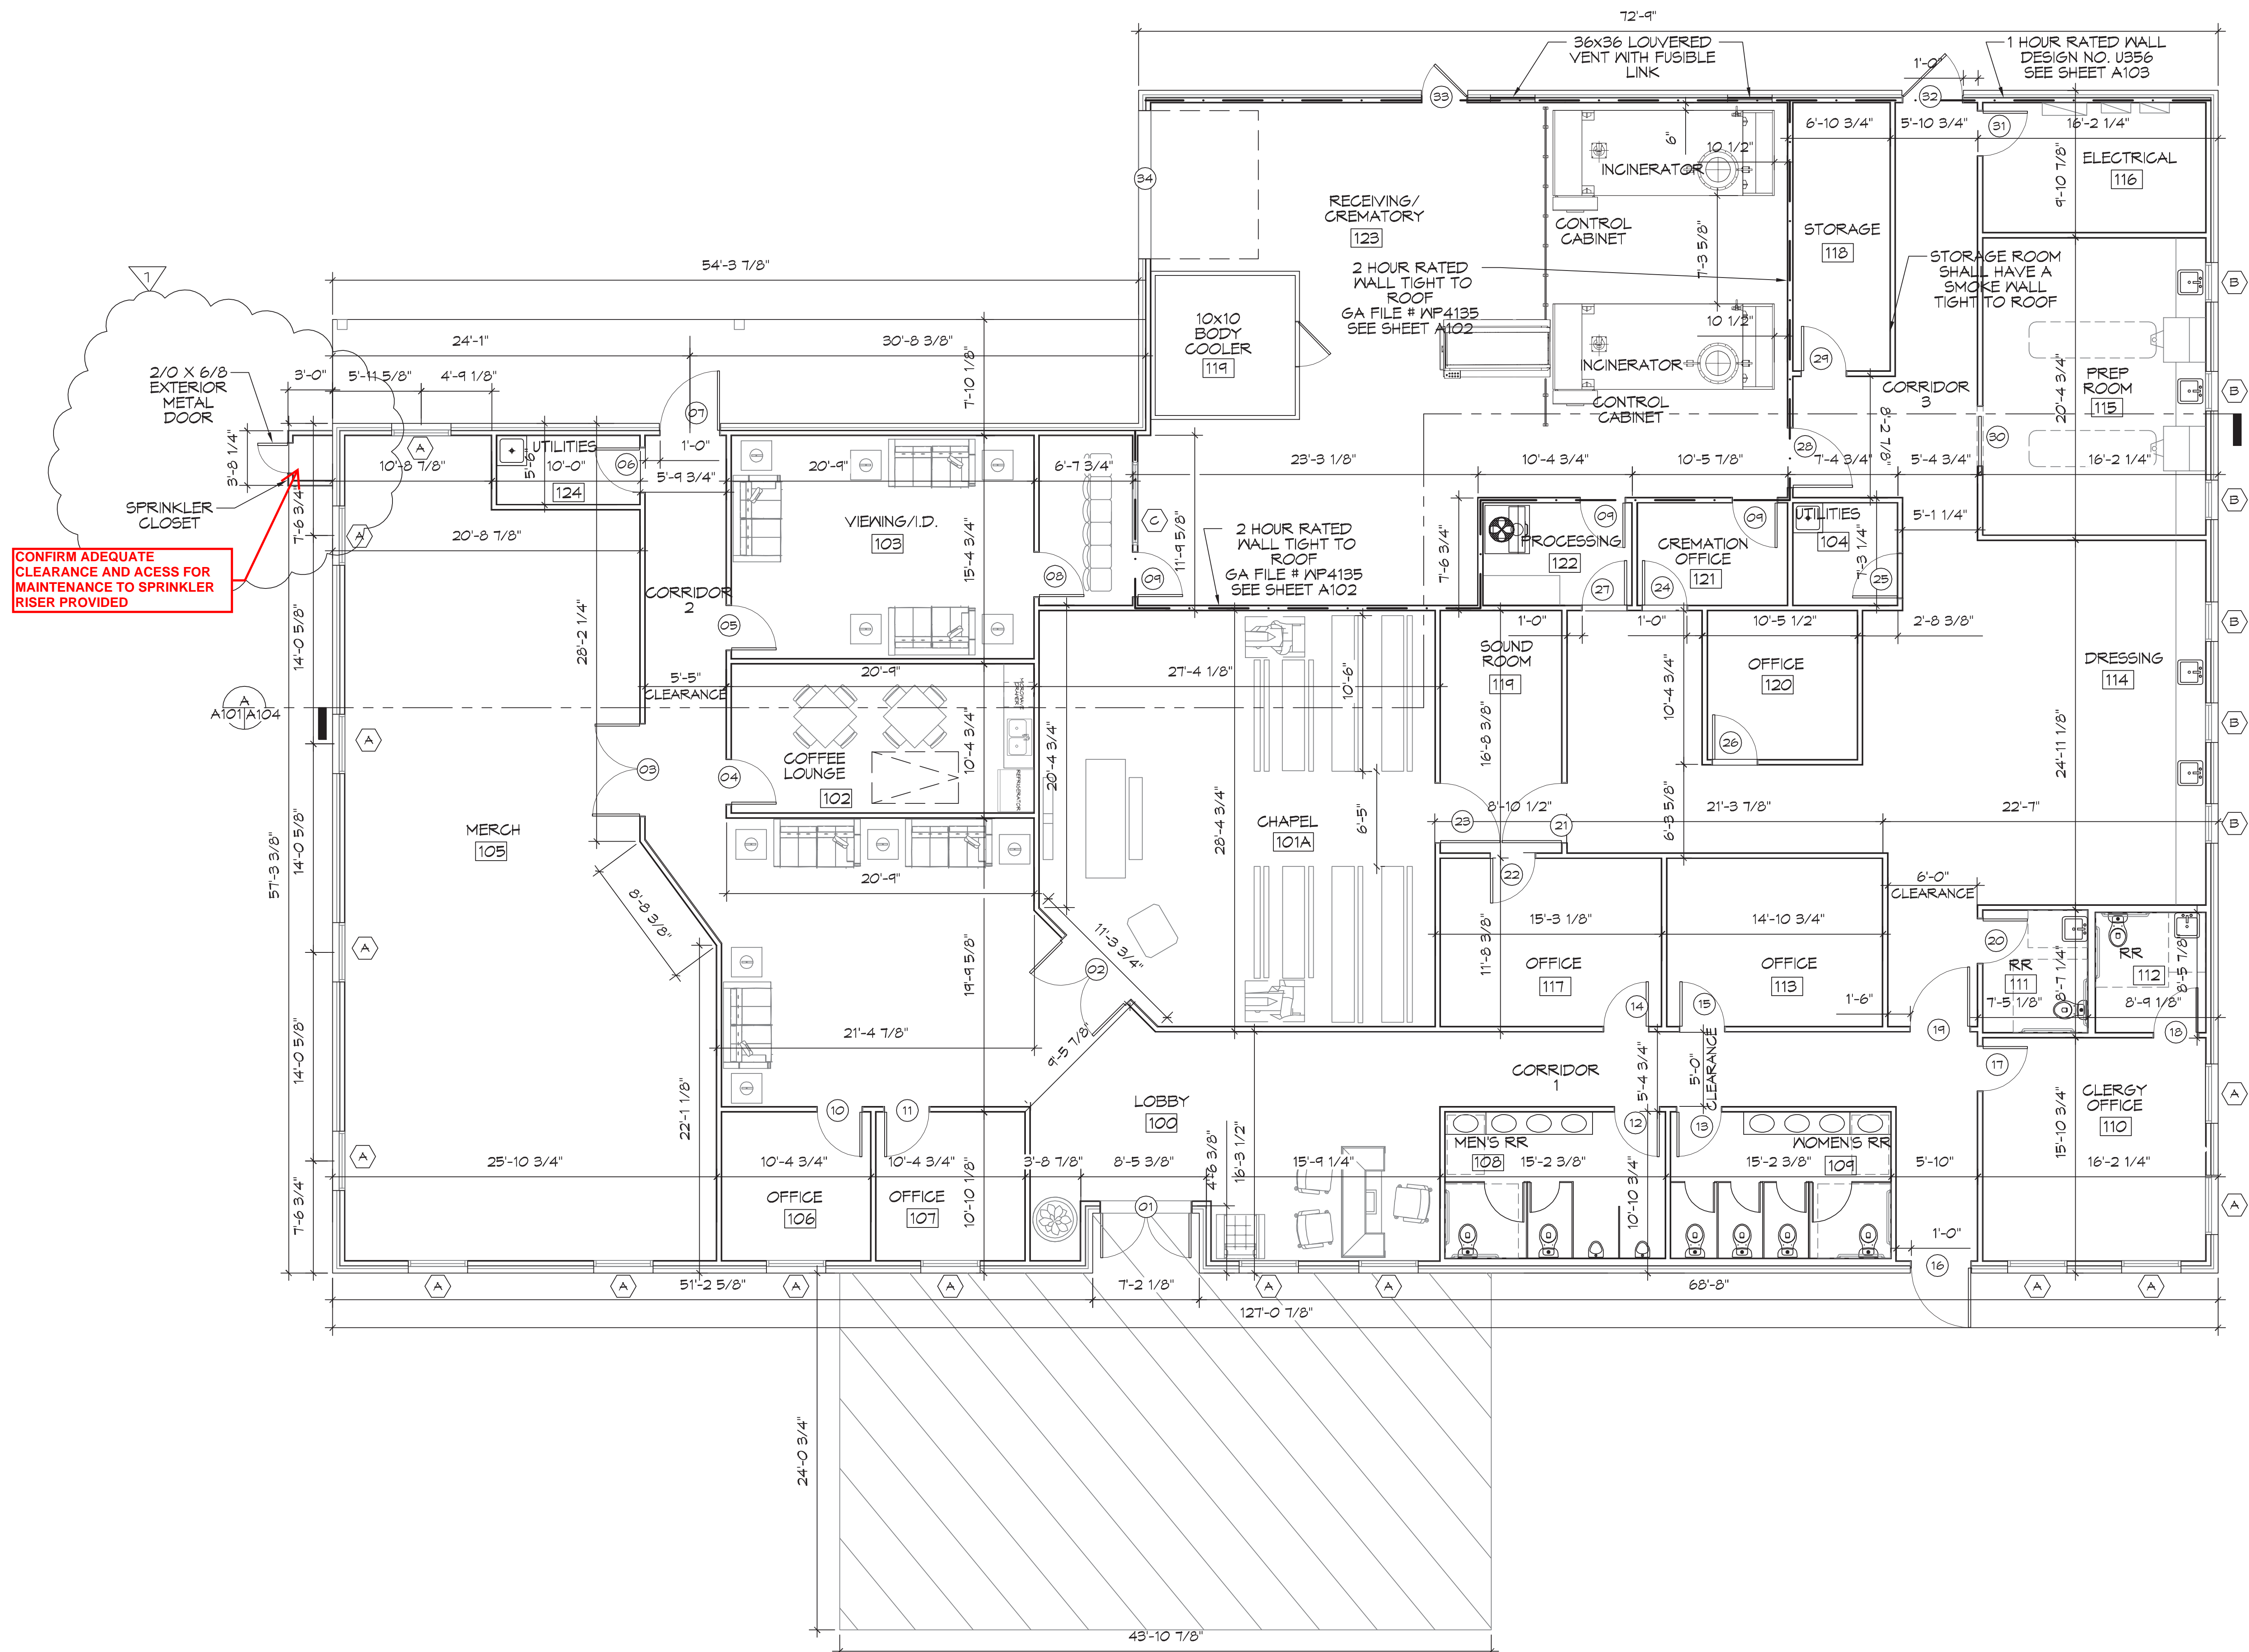


CONFIRM ADEQUATE CLEARANCE AND ACCESS FOR MAINTENANCE TO SPRINKLER RISER PROVIDED

10 FLOOR PLAN
SCALE: 3/16"=1'-0"

DAMMON ENGINEERING, INC.
LOUISIANA & MISSISSIPPI
Chief Engineer: Brian Abtch, PE
554 Old Spanish Trail
Slidell, LA 70488
www.dammonengineering.com
info@dammonengineering.com
PH: 985.649.8932

REVISIONS	DATE
# DESCRIPTION	07-15-21
1 ADDED SPRINKLER CLOSET	

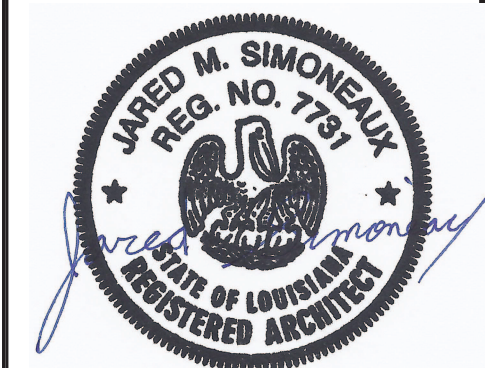

NEW FUNERAL HOME
BOYER FALHOME
4800 DOWNMAN ROAD
NEW ORLEANS, LA
JOB No: 2546 DATE: 05-05-2021
DRAWN BY: CSD CHECKED BY: CSD

SHEET TITLE:
FLOOR PLAN

REVIEWED FOR STATE FIRE MARSHAL AS PER REVIEW LETTER BY: ERIC M. RILEY, ARCHITECT
A101