

SITE PLAN
SCALE: 1/4" = 1'-0"

54'-3 3/4"

27'-7"

POOL SPECIFICATIONS:

DEPTH - 3' - 5'
GALLONS APPROXIMATELY ???
SUCTION AND RETURN PIPING = 2" PVC

POOL EQUIPMENT:

- 3/4" TRAFFICER PUMP
- 24" SAND FILTER
- 2" TANTAR 2" SKIMMERS
- 500 LITR A/GP APPROVED M.D. COVERS
- 3" FOOT LADDER
- 3" READ LADDER
- HANDRAIL ON STEPS
- POOL ROPE WITH FLOATS
- SHEPARD'S HOOK
- 30" RING BOX
- POOL RULE SIGN


POOL TURNOVER:

SCALE TO 50 GPM
APPROXIMATELY EVERY ?? HOURS
OR 4 TIMES IN 24 HOURS

NOTES:

1. DECKING SHALL BE INSTALLED IN ACCORDANCE WITH TEXAS STATE SANITARY CODE
2. PRESSURE OR VACUUM GAUGE SHALL BE INSTALLED IN ACCORDANCE WITH TEXAS STATE SANITARY CODE.
3. ALL DRAIN INLETS SHALL DISCHARGE 10" TO 15" BELOW THE SURFACE OF THE WATER IN ACCORDANCE WITH TEXAS STATE SANITARY CODE.
4. DEPTH MARKERS SHALL BE PLACED IN ACCORDANCE WITH TEXAS STATE SANITARY CODE. ?? IN ADDITION TO THE MARKINGS SHOWN, ADDITIONAL MARKERS SHALL BE LEGIBLE FROM INSIDE THE POOL.
5. THERE WILL BE NO PHYSICAL CONNECTION BETWEEN THE POOL OR POOL PIPING AND THE POTABLE WATER SYSTEM IN ACCORDANCE WITH TEXAS STATE SANITARY CODE.
6. THERE WILL BE NO PHYSICAL CONNECTION BETWEEN THE POOL DRAINAGE SYSTEM AND BACKWASH FILTER SYSTEM WITH THE LOCAL SEWER AND DRAINAGE SYSTEMS IN ACCORDANCE WITH TEXAS STATE SANITARY CODE.
7. THE DISINFECTANT FACILITY SHALL BE INSTALLED IN ACCORDANCE WITH THE TEXAS STATE SANITARY CODE.
8. POOL FILLING SHALL BE ACCOMPLISHED MANUALLY WITH A GARDEN HOSE. DURING FILLING OPERATIONS, THE HOSE SHALL NOT BE SUBMERGED TO PREVENT CROSS CONNECTIONS IN ACCORDANCE WITH TEXAS STATE SANITARY CODE.
9. POOL PLASTER SHALL BE WHITE IN COLOR.
10. GROUNDING SHALL BE INSTALLED IN A LOOP AROUND POOL AND SPA CONNECTING TO HANDRAILS AND LADDERS PER NATIONAL ELECTRICAL CODE.
11. TOTAL DYNAMIC HEAD FOR POOL ??
12. POOL AND SPA SANITATION IS INLINE TABLET FEEDER. PH SHALL BE MURATIC ACID.


POOL PROFILE

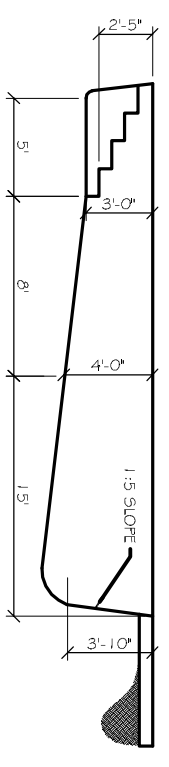

POOL PROFILE
N.T.S.



SKIMMER
N.T.S.

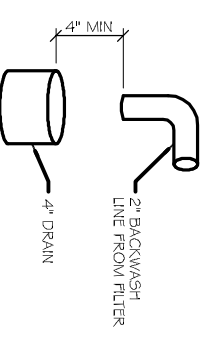

BACKWASH AIR GAP
N.T.S.

REVISIONS	
#	DESCRIPTION

INDEPENDENT HOTEL
309 EAST INTERSTATE HWY 20
MIDLAND, TEXAS 79701

JOB No: 2214 DATE: 07-16-2014

DRAWN BY: CKD CHECKED BY: DPD

DAMMON ENGINEERING, INC.
Architects & Engineers

CHIEF ENGINEER: BRIAN METTICH, P.E.
CHIEF ARCHITECT: KEVIN KINCHEN
554 OLD SPANISH TRAIL
SUDDLE, LA 70458

dammoneengineering.com
dammoneng@earthlink.net
PHONE: 985-649-5832
FAX: 985-641-5950

POOL SITE PLAN

SHEET No: 01 OF 01

C1