



NEW WET WELL
TOP VIEW

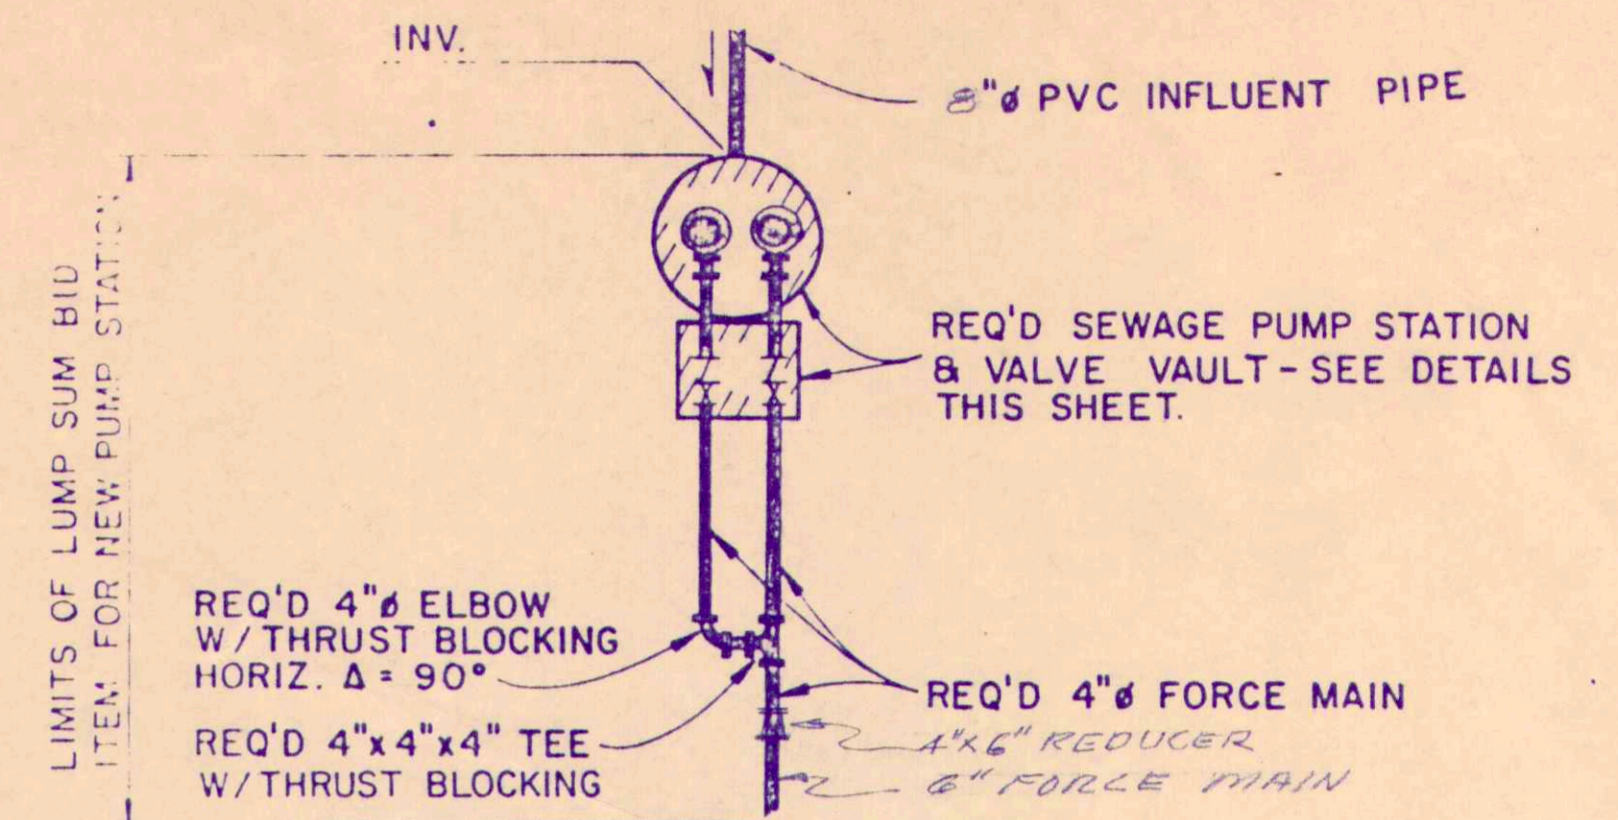


SITE PLAN OF PUMP STATION
SCALE: 1" = 5'

NEW PUMP STATION
PLAN VIEW UNDER TOP SLAB

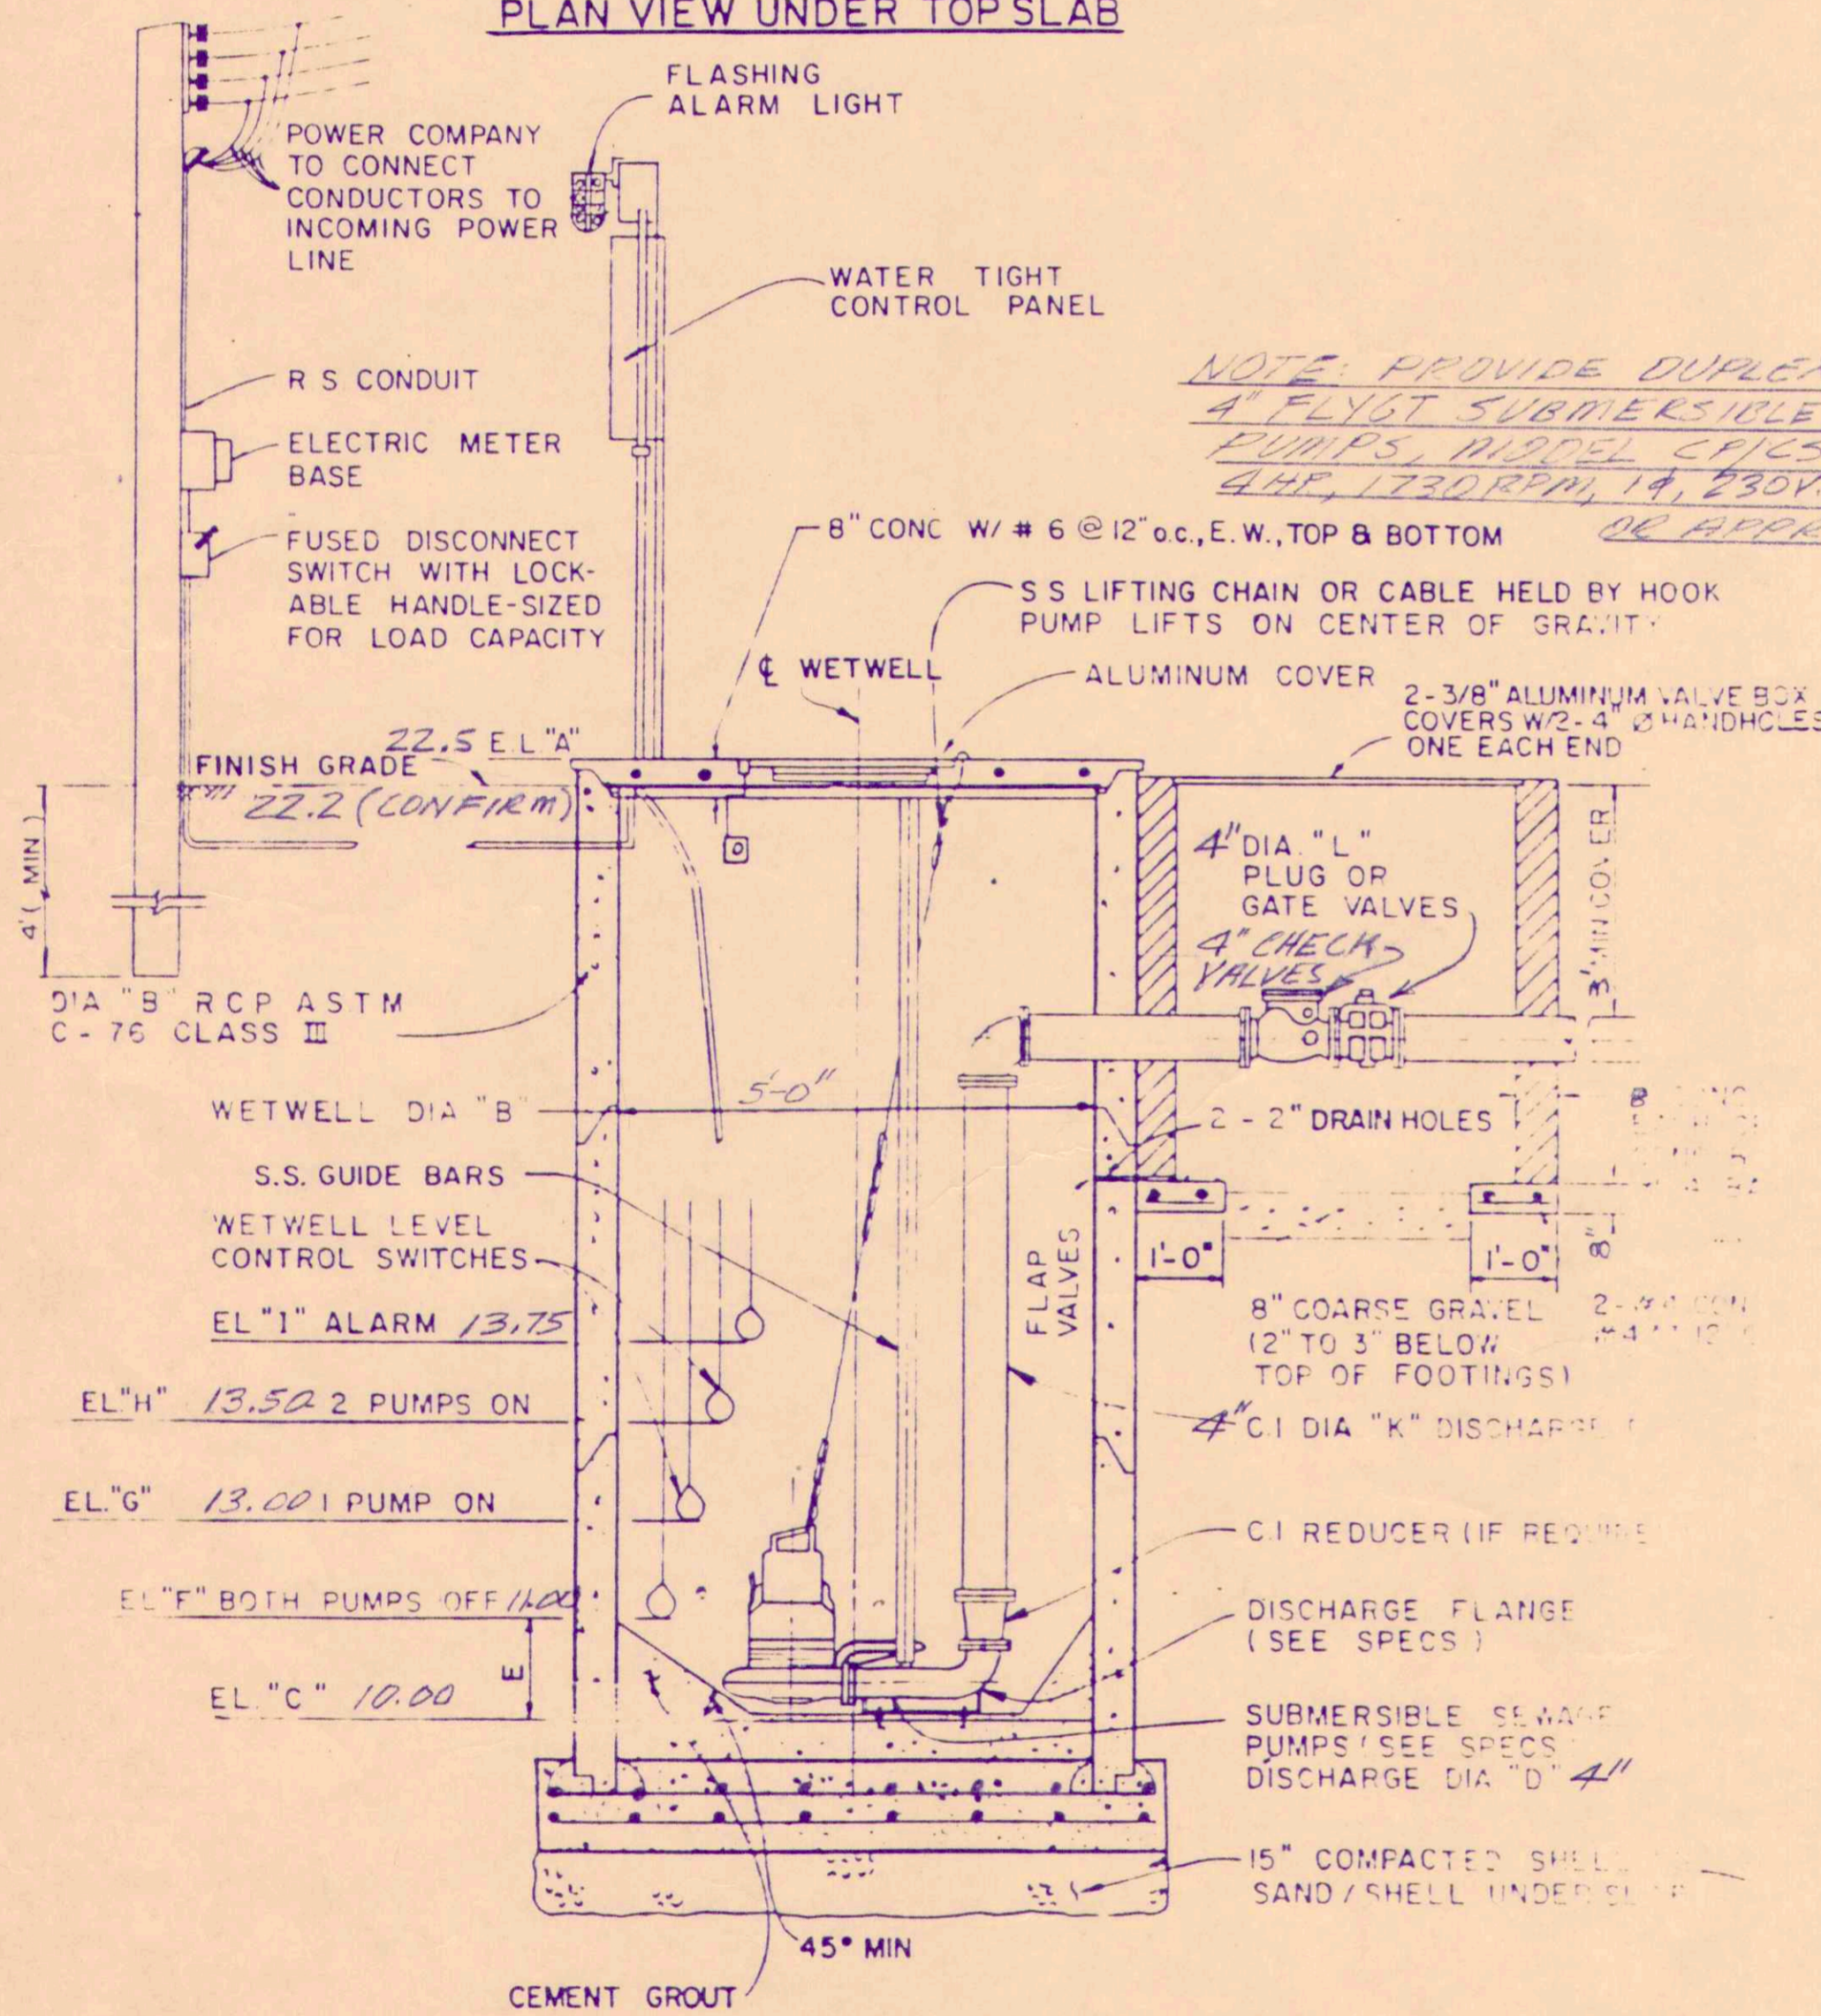

SECTION A-A
NO SCALE

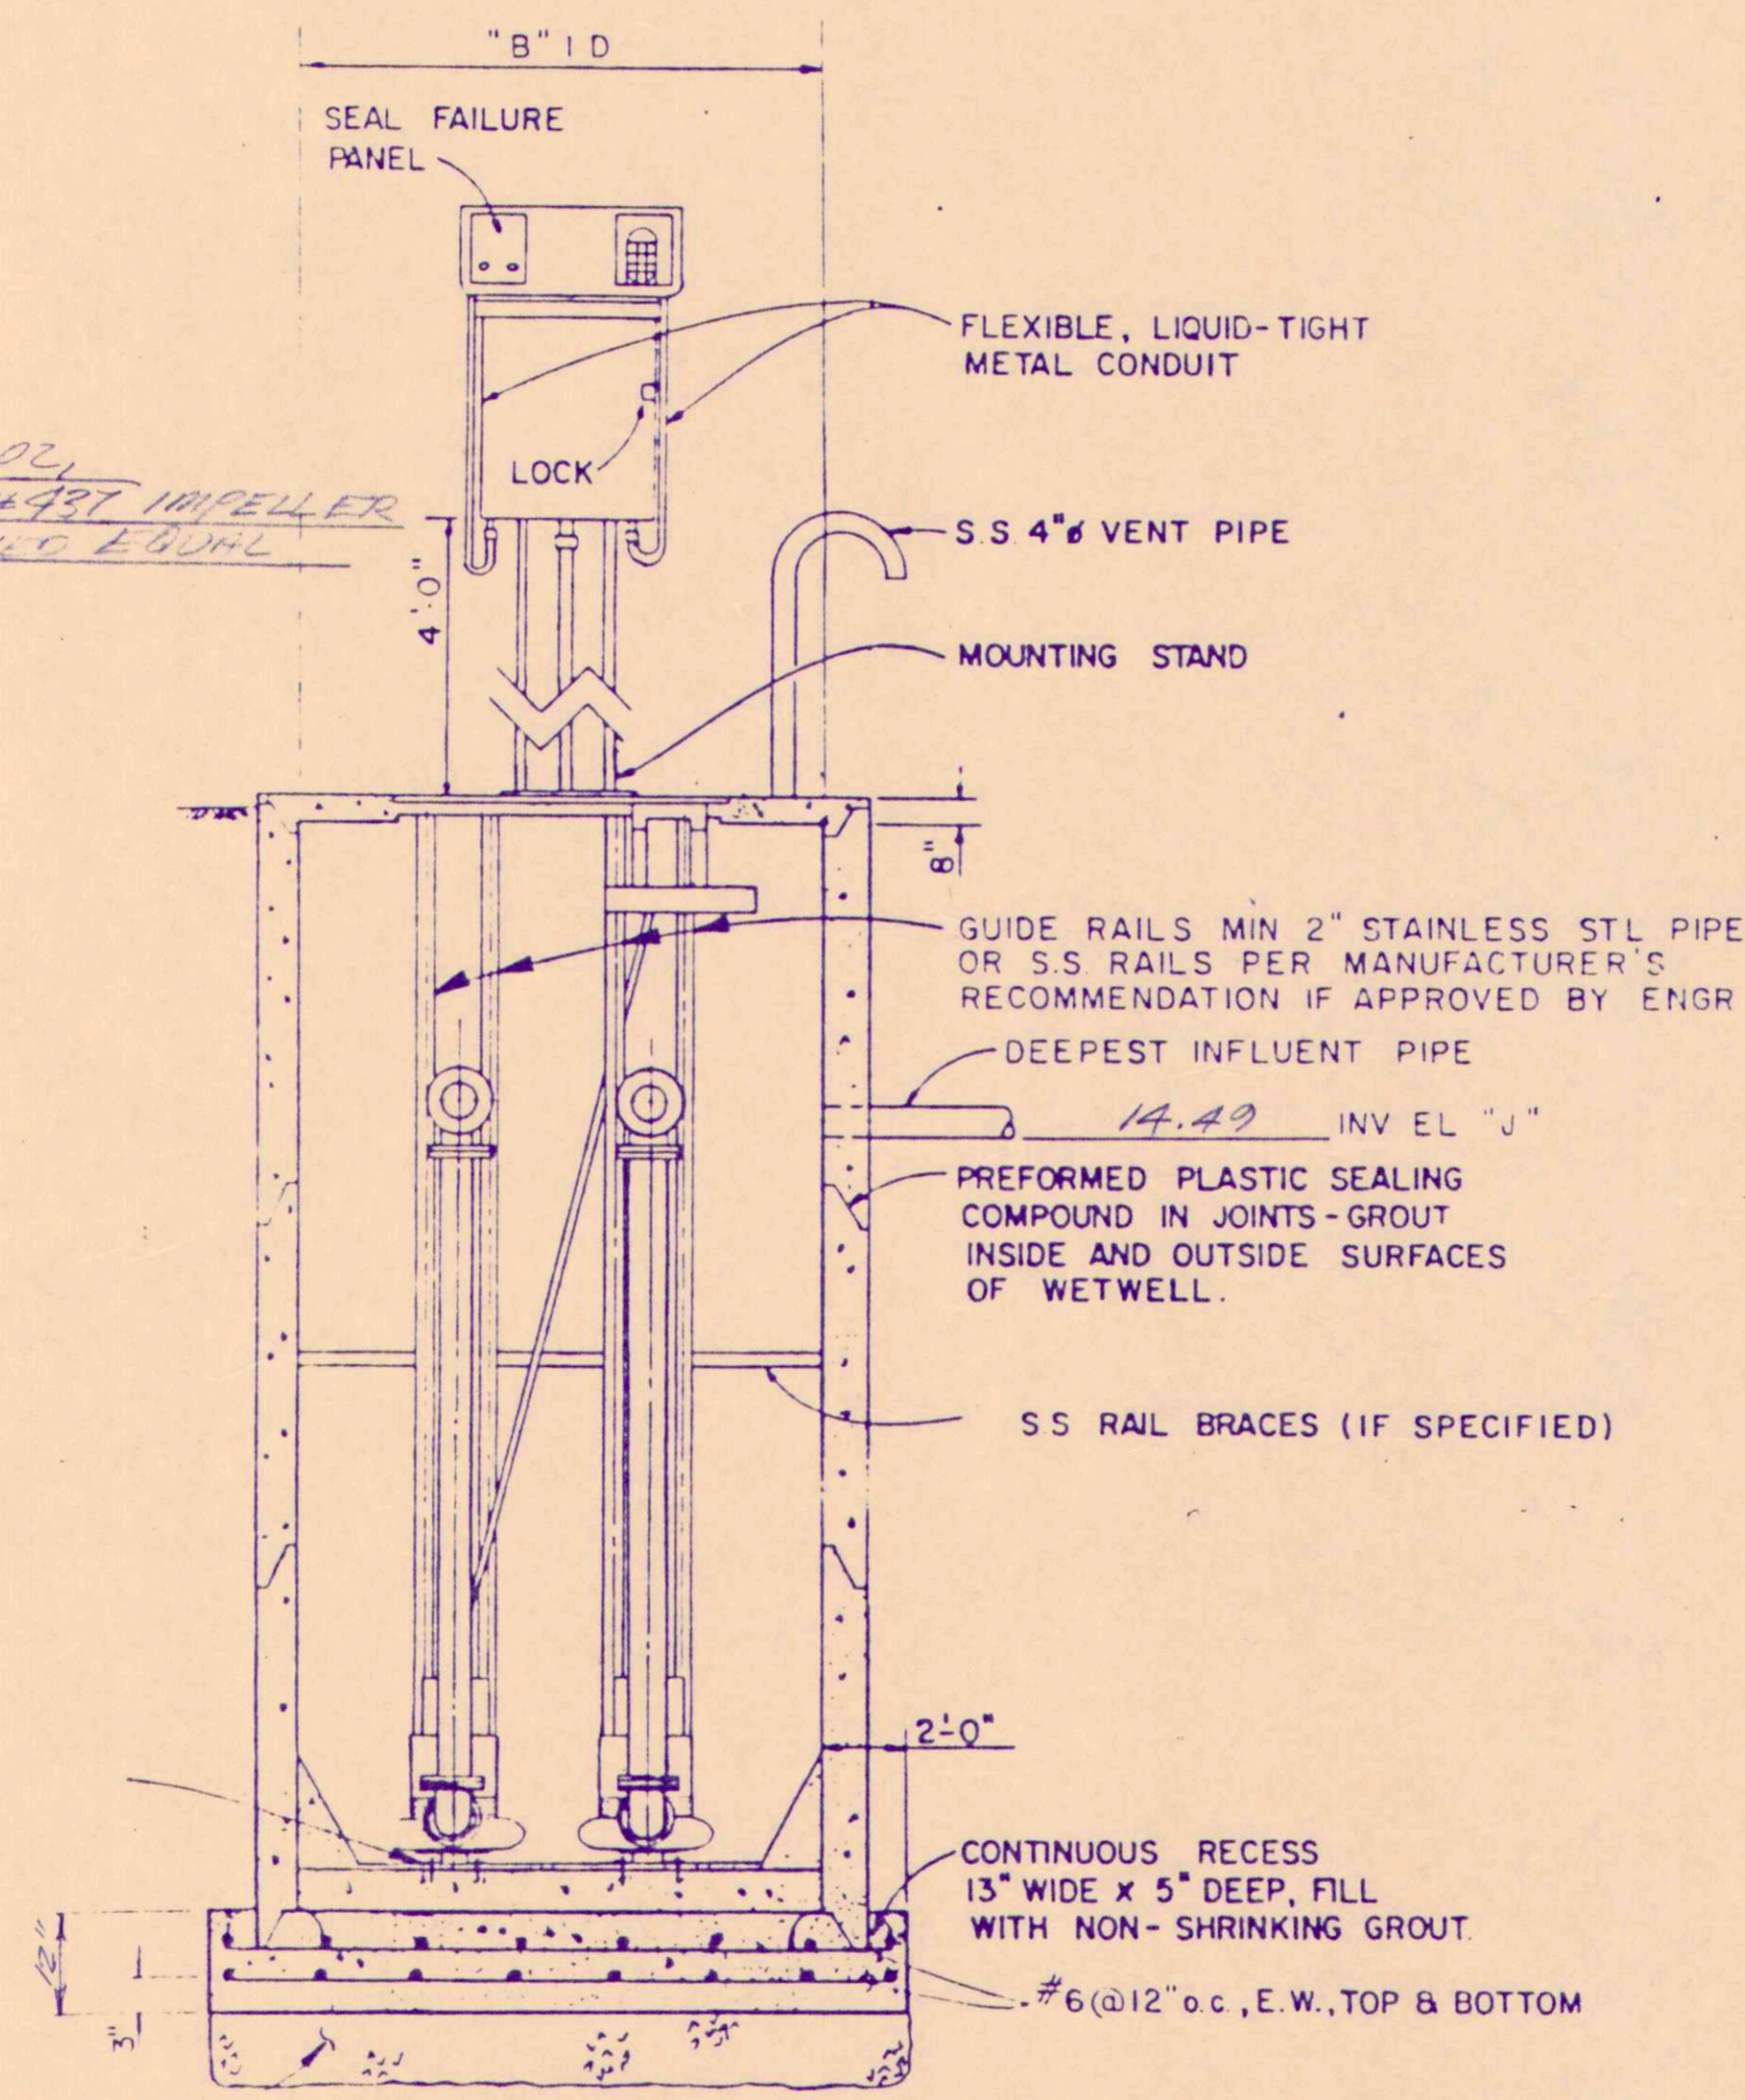


SECTION B-B
NO SCALE

* TIME DELAY 2nd PUMP ON

DATE	BY	DESCRIPTION OF REVISION	DATE	BY	DESCRIPTION OF REVISION

DATE: 2/28/85
DRAWN BY: R.S.
SCALE: Hor. 1" = 10'
Vert. 1" = 10'
JOB NO: 85-6

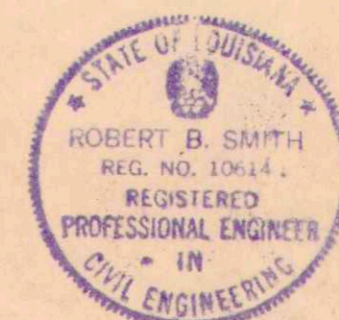

SMITH & ASSOCIATES
Consulting Engineers & Planners
122 Chamale Drive
Slidell, La 70460 681-5432

country club
mobile home park
st tammany parish louisiana

SHEET NO.
5

lift station