


SYMBOL KEY:

	2X4 ACOUSTIC CLG. TILE
	SUPPLY AIR DIFFUSER
	RETURN AIR DIFFUSER
	4" FIBERGLASS BLANKET ABOVE FINISH CEILING
	FIRE SPRINKLER
	FLUSH MOUNTED SPEAKER

GENERAL NOTES FOR REFLECTED CEILING PLAN DRAWINGS


1. IN ALL BACK OF HOUSE SPACES A.C.T. IS TO BE MOUNTED 9'-0" ABOVE FINISH FLOOR UNLESS OTHERWISE INDICATED
2. SEE AUDIO DRAWINGS FOR AUDIO EQUIPMENT INFORMATION AND LOCATIONS
3. SH INDICATES PREFERRED ARCHITECTURAL LOCATION FOR SPRINKLER HEADS IN HISTORIC SPACES. SPRINKLER SUB-CONTRACTOR TO CONFIRM ADEQUACY OF LAYOUT TO MEET REQUIRED CODES AND BUILDING STANDARDS. IF ADDITIONAL HEAD LOCATIONS ARE REQUIRED, LAYOUT OF SAID HEADS TO BE APPROVED BY ARCHITECT ON SHOP DRAWINGS AND IN THE FIELD.
4. FOR DUCT DETAILS SEE MECHANICAL DWGS (TYP.)
5. COORDINATE ALL LIGHTING FIXTURES AND LAYOUT WITH ELECTRICAL DRAWINGS (TYP.)
6. ALL CEILING NOT NOTED AS EXIST. ARE NEW
7. ALL DIMENSIONS SHOWN FOR REPAIR ARE APPROXIMATE, GC TO FIELD VERIFY EXTENT, TYP.
8. REFER TO HP-0.00 FOR HP NOTES AND AD-0.00 FOR AD NOTES.

-01 / A-1.28

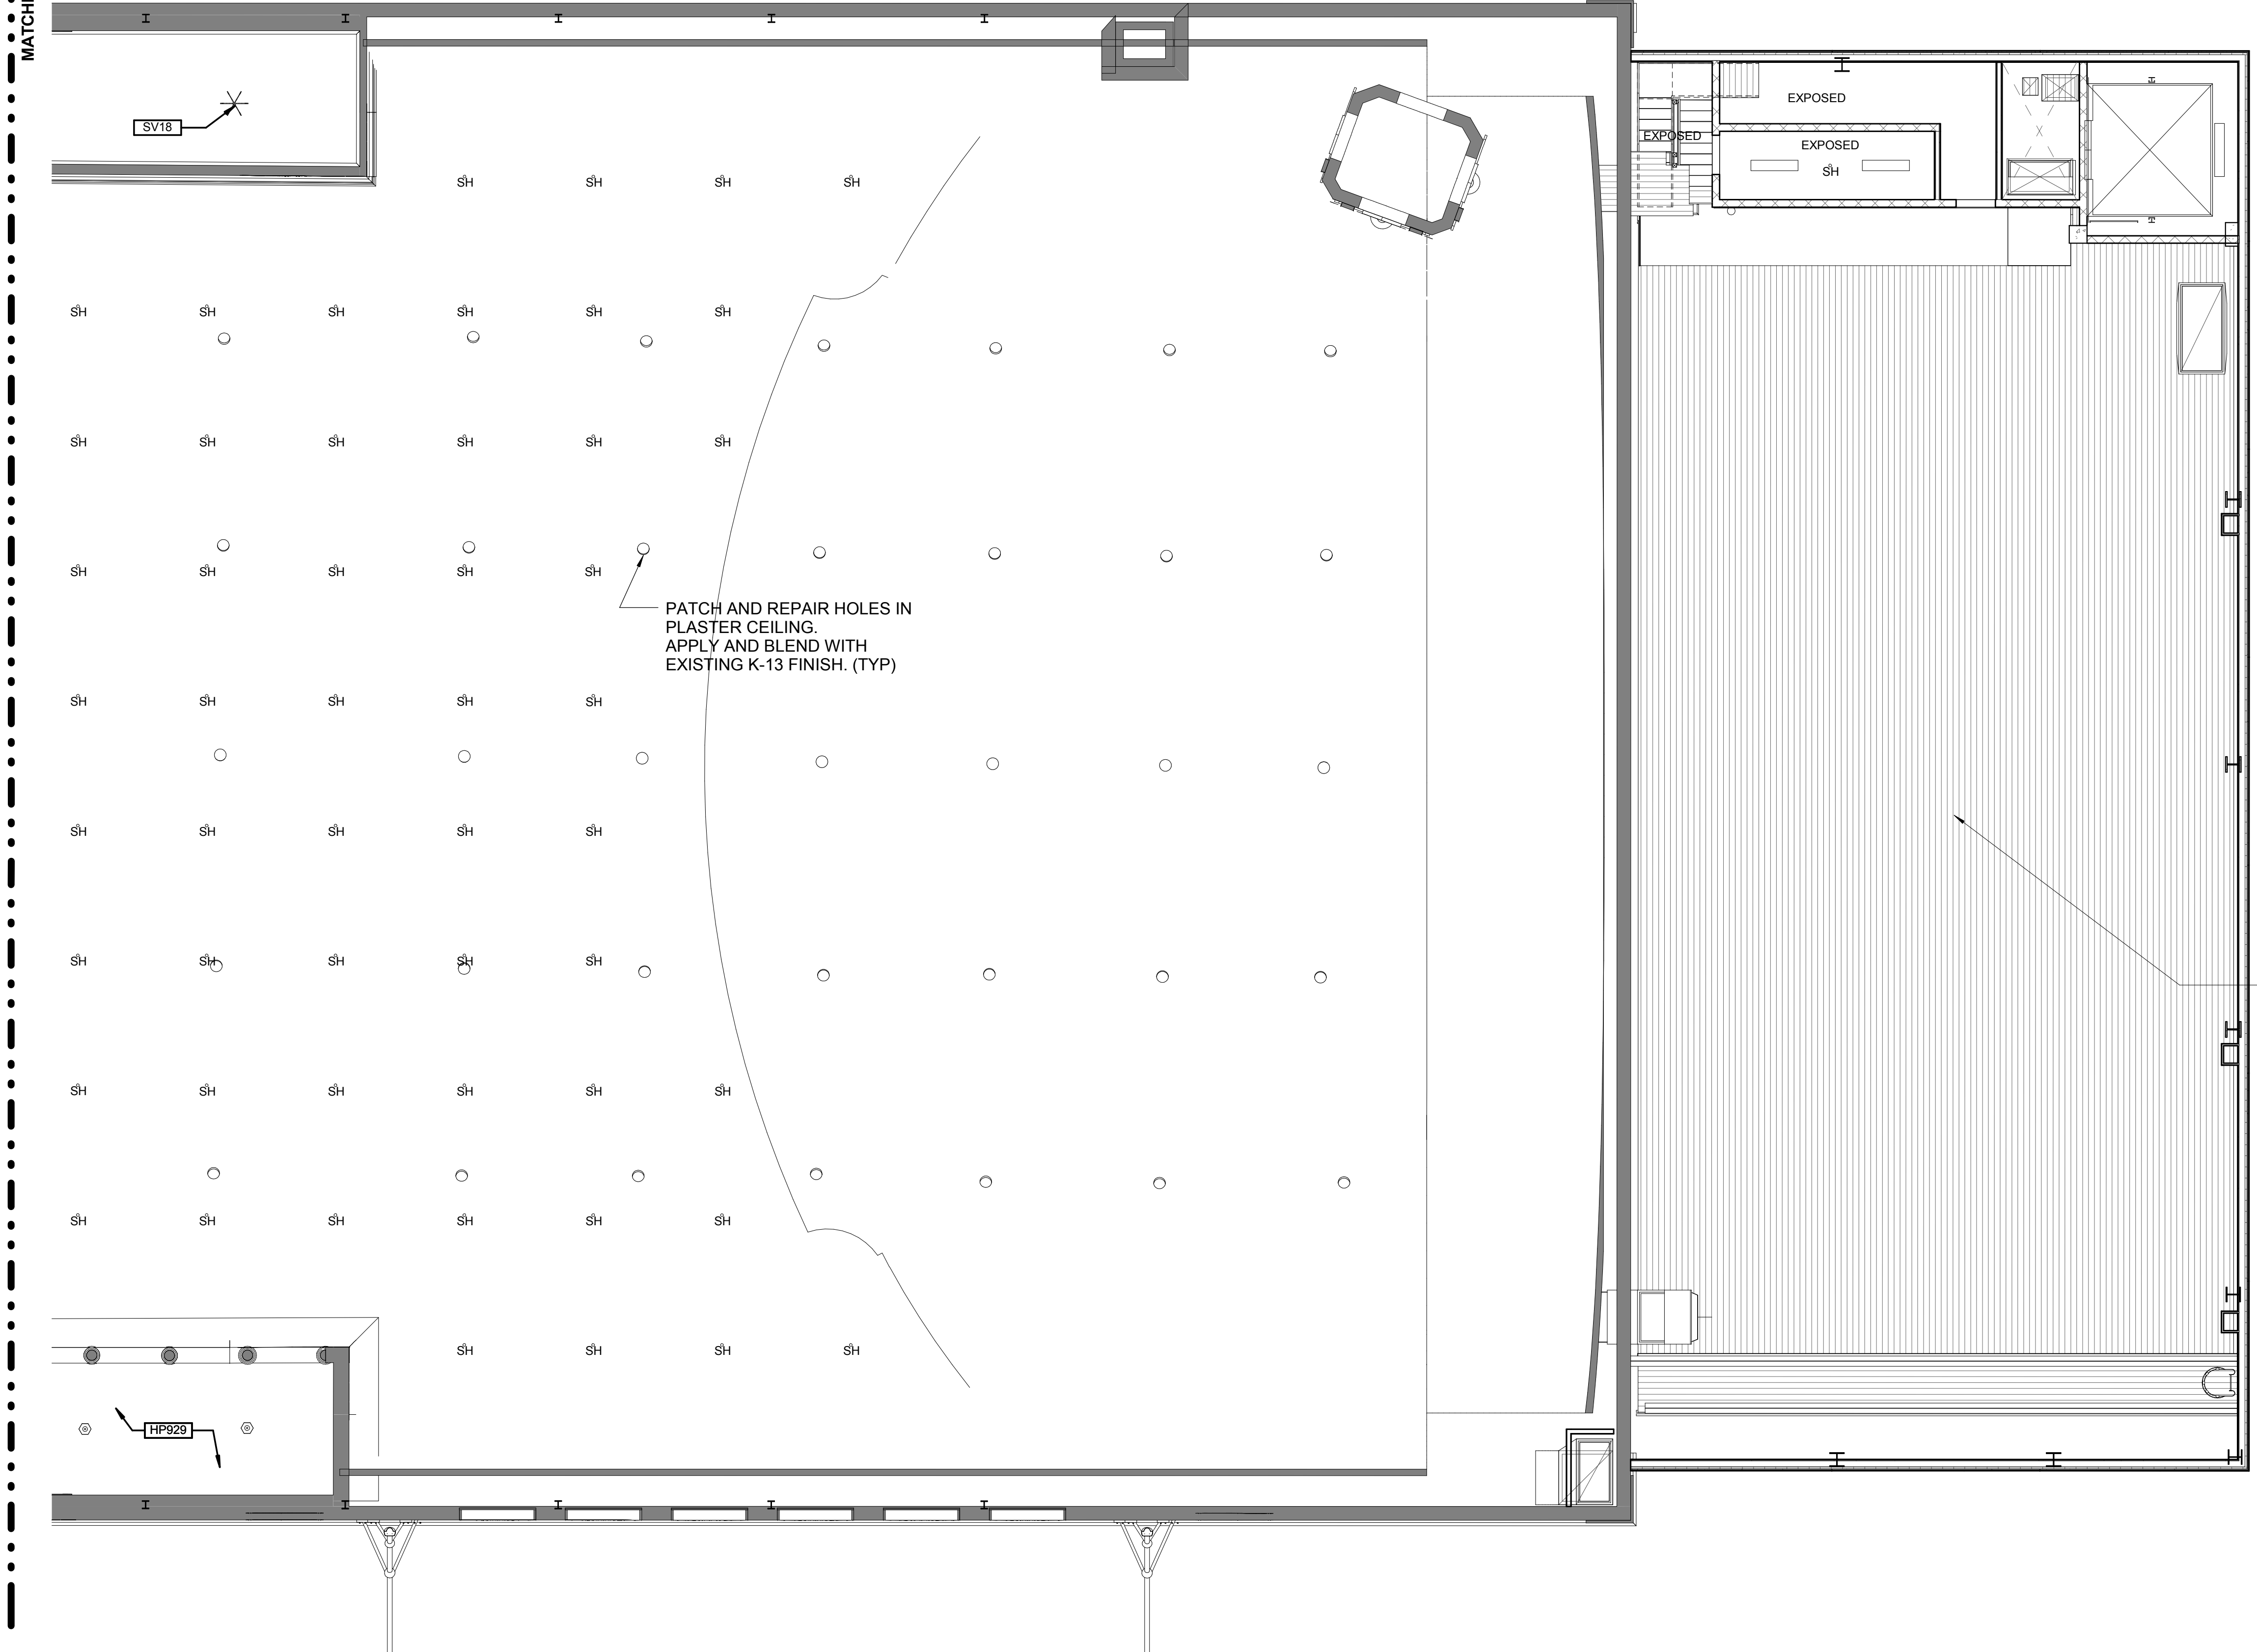

PATCH AND REPAIR HOLES IN PLASTER CEILING. APPLY AND BLEND WITH EXISTING K-13 FINISH. (TYP)

GRID IRON, ABOVE REF. STRUCT. DWGS.

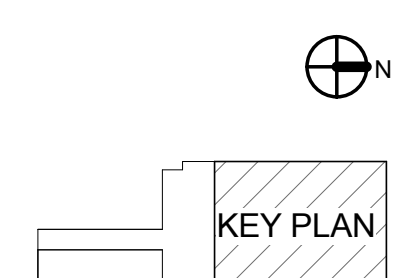

THE SAENGER THEATRE RENEWAL PROJECT
 142 North Rampart Street
 New Orleans, LA

Client
 Saenger Theatre Redevelopment Company
 1800 Post Oak Boulevard, 6
 Boulevard Place, Suite 450,
 Houston, TX 77056

Architect
MARTINEZ+JOHNSON
 ARCHITECTURE
 1412 Eye St., NW
 Washington, DC 20005
 202.333.4480

Structural Engineer
 Lundy & Franke Engineering, Inc.
 549 Heimer Road, San
 Antonio, TX 78232
 210.370.7900

Theatre Consultant
 Schuler Shook
 123 Third Street North #210,
 Minneapolis, MN 55401
 612.339.5958

Acoustical Engineer
 Akustiks
 93 North Main Street, South
 Norwalk, CT 06854
 203.299.1904

MEP Engineer
 JBA Consulting Engineers, Inc.
 3525 N. Causeway BLVD, Suite
 500 Metairie, LA 70002
 504.830.0159

Civil Engineer
 Linfield, Hunter, & Junius, Inc.
 3606 18th Street Suite 200,
 Metairie, LA 70002
 504.833.5300

Architectural Historian
 EHT Traceries, Inc.
 1121 Fifth Street NW
 Washington, DC 20001
 202.393.1199

THESE DRAWINGS, SPECIFICATIONS, AND OTHER DOCUMENTS (COLLECTIVELY, THE "DOCUMENTS") INCLUDING WITHOUT LIMITATION ELECTRONIC VERSIONS THEREOF AND THE IDEAS, DESIGNS, AND ARRANGEMENTS REPRESENTED THEREBY ARE AND SHALL REMAIN THE PROPERTY OF MARTINEZ & JOHNSON ARCHITECTURE PC, AS DEFINED BY APPLICABLE CONTRACTUAL AGREEMENTS (THE "AGREEMENTS") AND AS PROTECTED BY THE COPYRIGHT STATUTES OF THE UNITED STATES. USE OF THE DOCUMENTS SHALL BE STRICTLY LIMITED TO THE PROJECT FOR WHICH THEY WERE PREPARED AND DEVELOPED (THE "PROJECT") PER THE TERMS OF THE AGREEMENTS. NO PART OF THE DOCUMENTS SHALL BE COPIED, DISCLOSED TO OTHERS, OR USED IN CONNECTION WITH ANY OTHER WORK OR PROJECT, OR BY ANY OTHER PERSONS FOR ANY PURPOSES, OTHER THAN THE COMPLETION OF THE PROJECT WITHOUT THE SPECIFIC WRITTEN AUTHORIZATION OF MARTINEZ & JOHNSON ARCHITECTURE PC. THE DOWNLOADING, OPENING, OR VIEWING OF ELECTRONIC VERSIONS OF THE DOCUMENTS OR VISUAL CONTACT WITH ANY PRINTED FORM THEREOF SHALL CONSTITUTE CONCLUSIVE EVIDENCE OF ACCEPTANCE OF THESE RESTRICTIONS.

7502

DATE:	No.:	REVISION:
02.19.10		PERMIT SET
04.02.10		GMP CONTRACT SET
11.11.10		CONTRACT SET

SHEET TITLE:
 THEATRE - UPPER BALCONY LEVEL REFLECTED CEILING PLAN

A-1.29