




PLAN VIEW
SCALE: 1/4" = 1'-0"

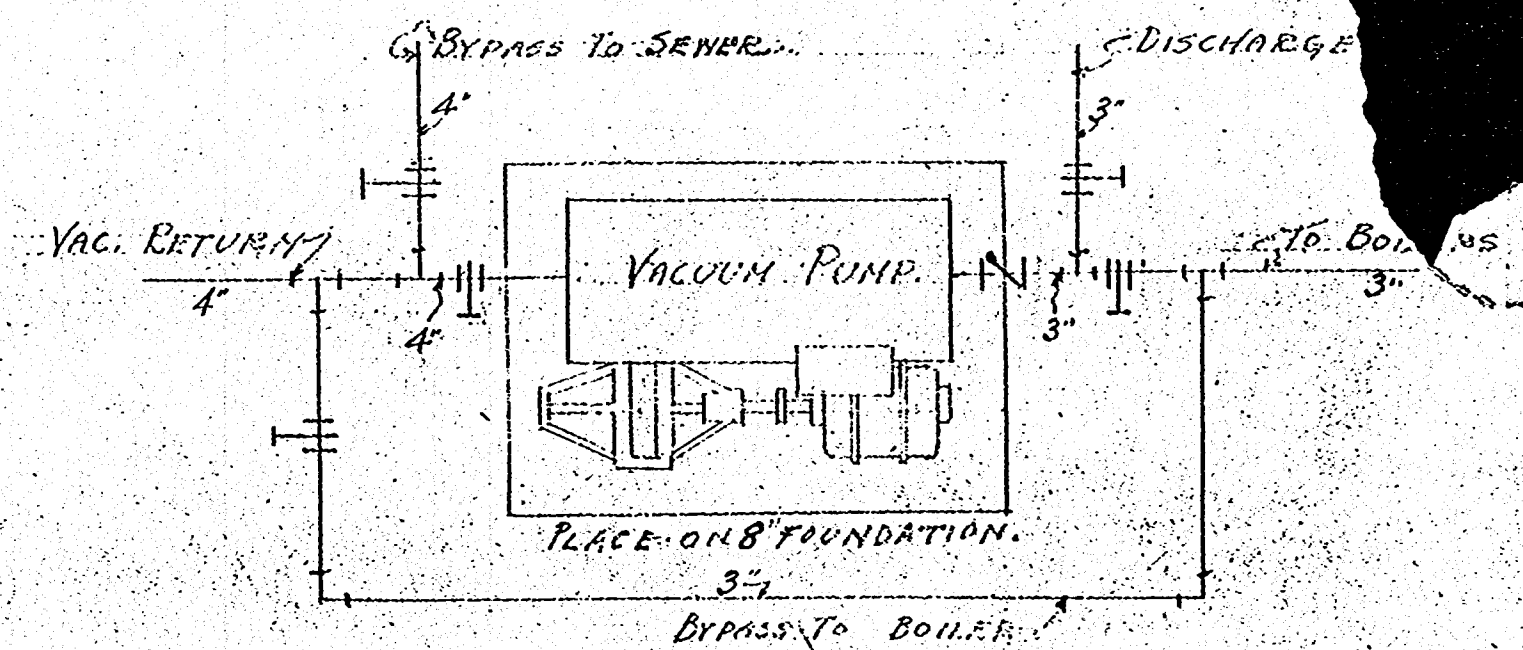

DETAIL OF CONNECTIONS AROUND VACUUM PUMP
NO SCALE

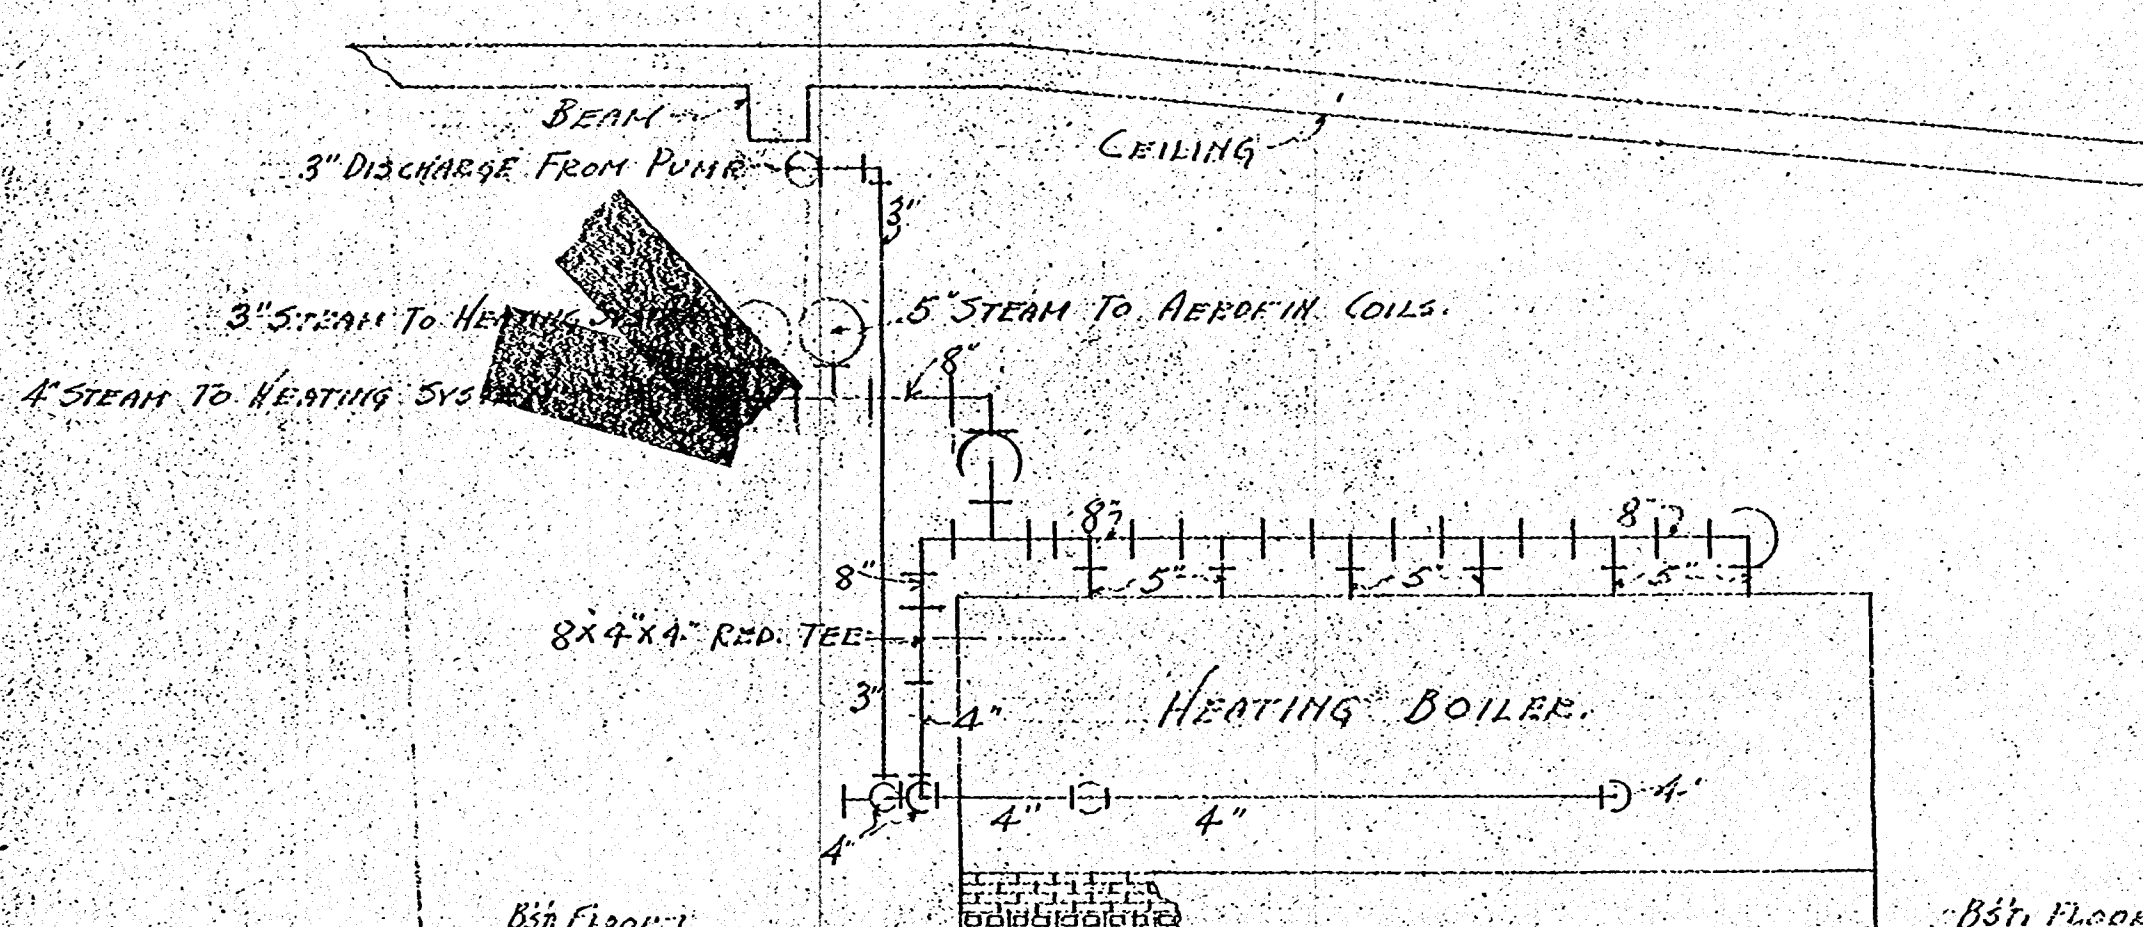

SIDE ELEVATION
SCALE: 1/4" = 1'-0"

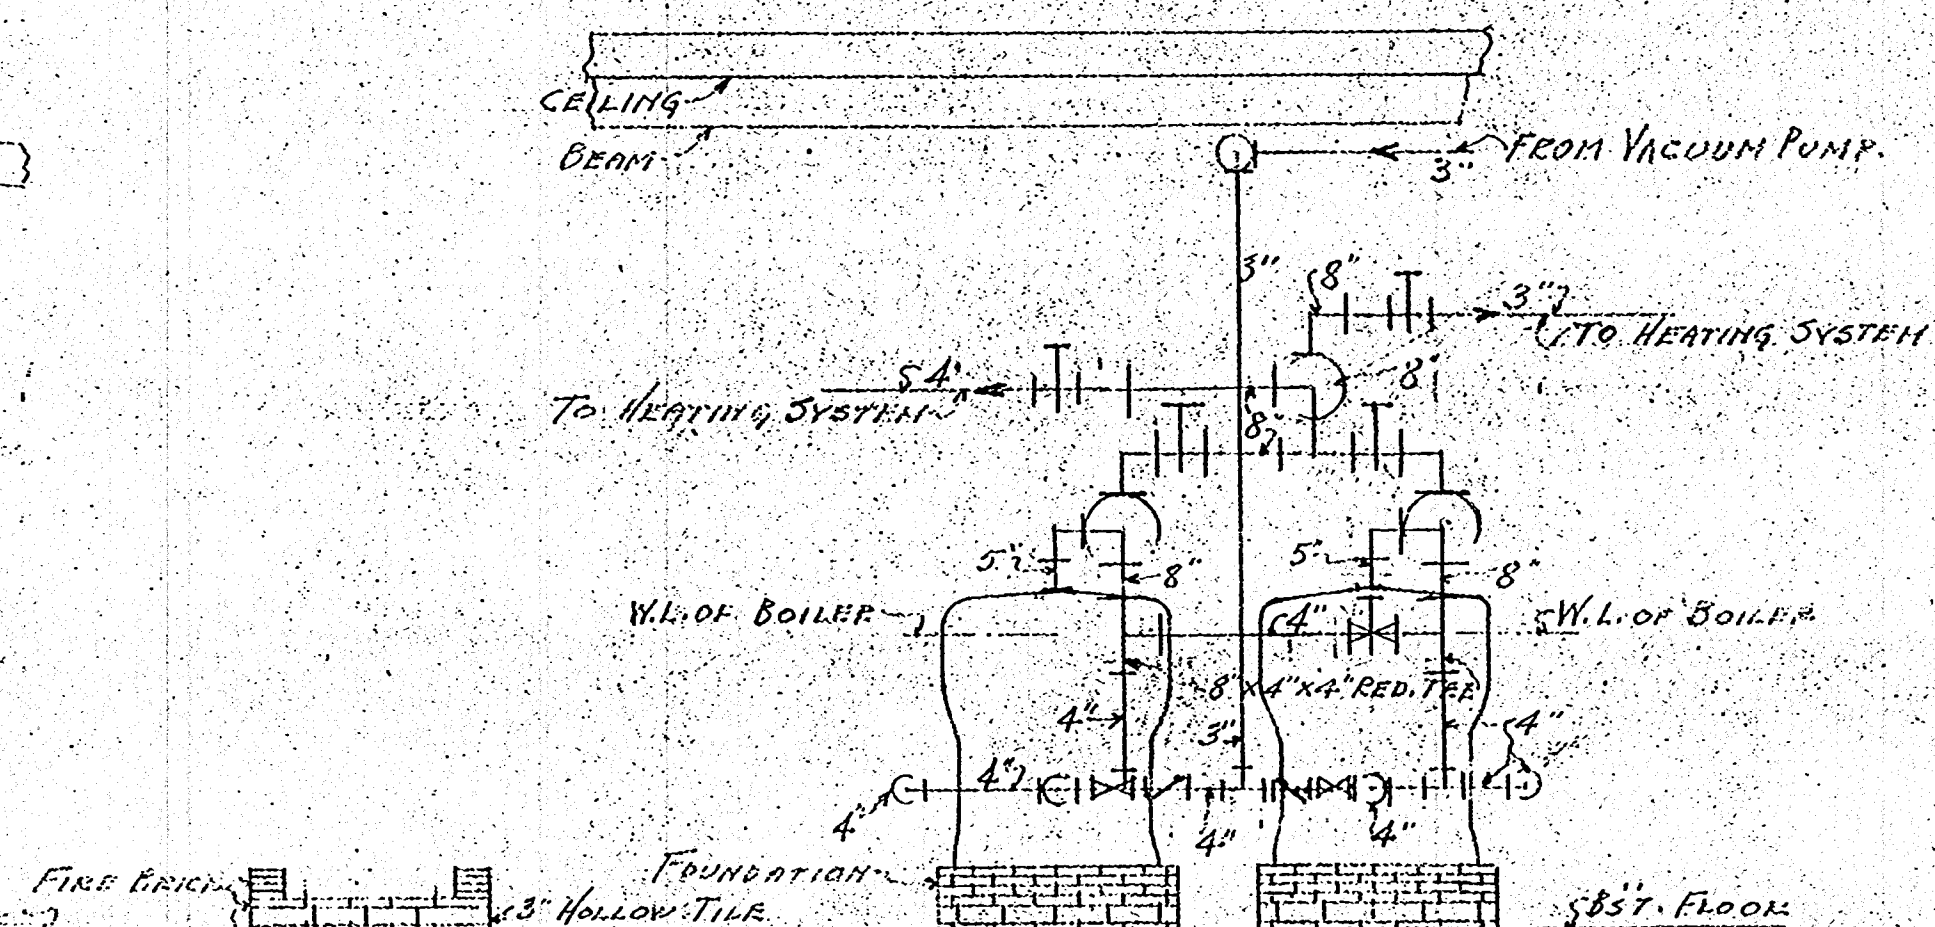

SECTION SHOWING BOILER FOUNDATIONS
SCALE: 1/4" = 1'-0"

REAR ELEVATION
SCALE: 1/4" = 1'-0"

DETAIL OF CONNECTIONS AROUND BOILERS, ETC.
SCALE: 1/4" = 1'-0" 4-17-26

F. H. CULSH
ENGR.

HEATING PL.
CANAL ST.
SOLINGER