

**MECHANICAL POWER PLAN - FIRST FLOOR**  
 SCALE: 1/8" = 1'-0"



SEE SHEET E6.1 FOR SPECIFIC NOTES

©2009 IMC 1734  
**CONSULTING ENGINEERS**  
 INC.  
 3120 20th STREET  
 METAIRIE, LOUISIANA 70002



**FINAL DESIGN**  
 Oct 29, 2009

**Nelson** WALDEMAR S. NELSON AND COMPANY  
 INCORPORATED  
 ENGINEERS AND ARCHITECTS  
 1200 ST. CHARLES AVE NEW ORLEANS, LA.

**BROADMOOR**  
 BUILDING by DESIGN  
 BROADMOOR, L.L.C.  
 2740 North Arnault Road  
 Metairie, Louisiana 70002  
 www.broadmoorllc.com

REV.	DESCRIPTION	DATE	APPROVAL	P.S.
0	FINAL DESIGN	10/29/09		

**NAVIRSEFAC CALIBRATION BLDG.**  
 MECHANICAL POWER PLAN  
 FIRST FLOOR  
 Belle Chasse, Louisiana  
 MAS JRB New Orleans  
 DATE: AUGUST 14, 2008  
 EFD FOR COMMANDER, NAVFAC

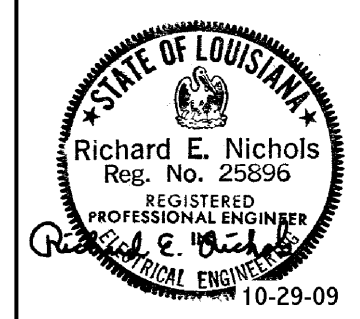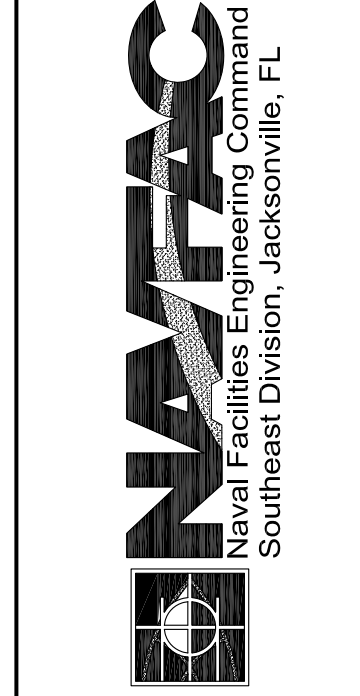

RECORD DRAWING DATE XX-XX-20XX  
 CODE ID. NO.  
 DRAWING SIZE: D  
 SPEC. NO. 06-  
 CONSTR. CONTR. NO. N62467  
 NAVFAC DRAWING NO. 15030969  
 SHEET OF  
**E-6.0**