

Lighting Control Panel Schedule

LCP Name:	LCP 1
Location:	ROOM 123
Surface/Flush:	Surface
Power Circuit:	HL1:1

Relay #	Circuit	Description	LV Switch/Sensor	Channel
1	HL1:1	CORRIDOR LIGHTS	LV SWITCH "A"	A
2	HL1:5	LIGHTS - CAL. WORK AREA	AS-100	B
3	HL1:9	LIGHTS - DRP WORK AREA	LV SWITCH "D"	D
4	HL1:11	LIGHTS - DRP WORK AREA	LV SWITCH "D"	D
5	HL1:13	LIGHTS - DRP SHIP RECEIVER	LV SWITCH "B"	A
6	HL1:15	LIGHTS - CAL. RECEIPT/ISSUE	LV SWITCH "C"	A
7	HL1:6	EXTERIOR LIGHTS	PHOTOCELL	C
8				

Channel	Scenario*	Scenario Times	Blink	Time Delay
A	(1)			
B	(3)			
C	(4)			
D	(1)			
E				
F				
G				
H				

\*Scenario Listings

- (1) Manual On / Sched Off
- (2) Scheduled On/Off
- (3) Manual ON / AS Switch Off
- (4) Photocell On/Off
- (5) Photo & Sched On/Off
- (6) Astronomic On/Off
- (7) Astro and Sched On/Off

Specifications:

Provide a single relay panel with up to 8 relays. Each relay to be individually scheduled through an easy to use integral clock with a backlit 8-line LCD display. Relays are to be SPST 20 Amp rated, mechanically held contactors capable of switching either 120 or 277VAC loads. Mounted next to each relay should be a LED to annunciate status and a pushbutton to toggle the relay's state. Panel shall have a multitap transformer and accept either 120V or 277V for power.

Panel enclosure to be NEMA 1, rated for environments from 32 - 139°F, 5 - 95% RH non-condensing. Panel to come with a split cover hinged in the center such that the high voltage side must be unscrewed to access the relays, but the low voltage side can be opened via a locking latch. Surface or flush covers shall be available.


Each relay can be controlled remotely by external switches or motion detectors. Switches can be 2- or 3-wire, momentary or maintained low voltage devices. Motion detectors must provide a 24VDC pilot signal to control the relays. Panel must be able to interlock time based schedules with the occupancy sensor input, so that lights scheduled on during the day are not affected by the motion detector, but after hours the occupancy sensor has control or the relay. Panel shall be capable of blink warning before "OFF" and true after hours time delay.

All programming to be entered via a simple keypad. Each relay can be programmed independently, or relays can be grouped together in firmware to follow the same channel schedule. On a daily 7-day repeating basis, relays can be assigned to follow any of the following scenarios:

- (1) Manual On / Sched Off
- (2) Scheduled On/Off
- (3) Manual ON / AS Switch Off (for use with AS-100 switches)
- (4) Photocell On/Off
- (5) Photo & Sched On/Off
- (6) Astronomic On/Off
- (7) Astro and Sched On/Off

The LCD screen should normally show the current time and date, as well as sunrise and sunset times for that day. Relay channels can also be monitored from the display to see their status - either ON, OFF, or MIXED. Additionally the relay groups can be overridden from the screen. Context sensitive help shall be available for each screen.

Panel to be Wattstopper Cat# LP2458Q1 - 115/277V panel and must be UL Listed 916, meet local energy codes (California CEC), and have a 1 year warranty.

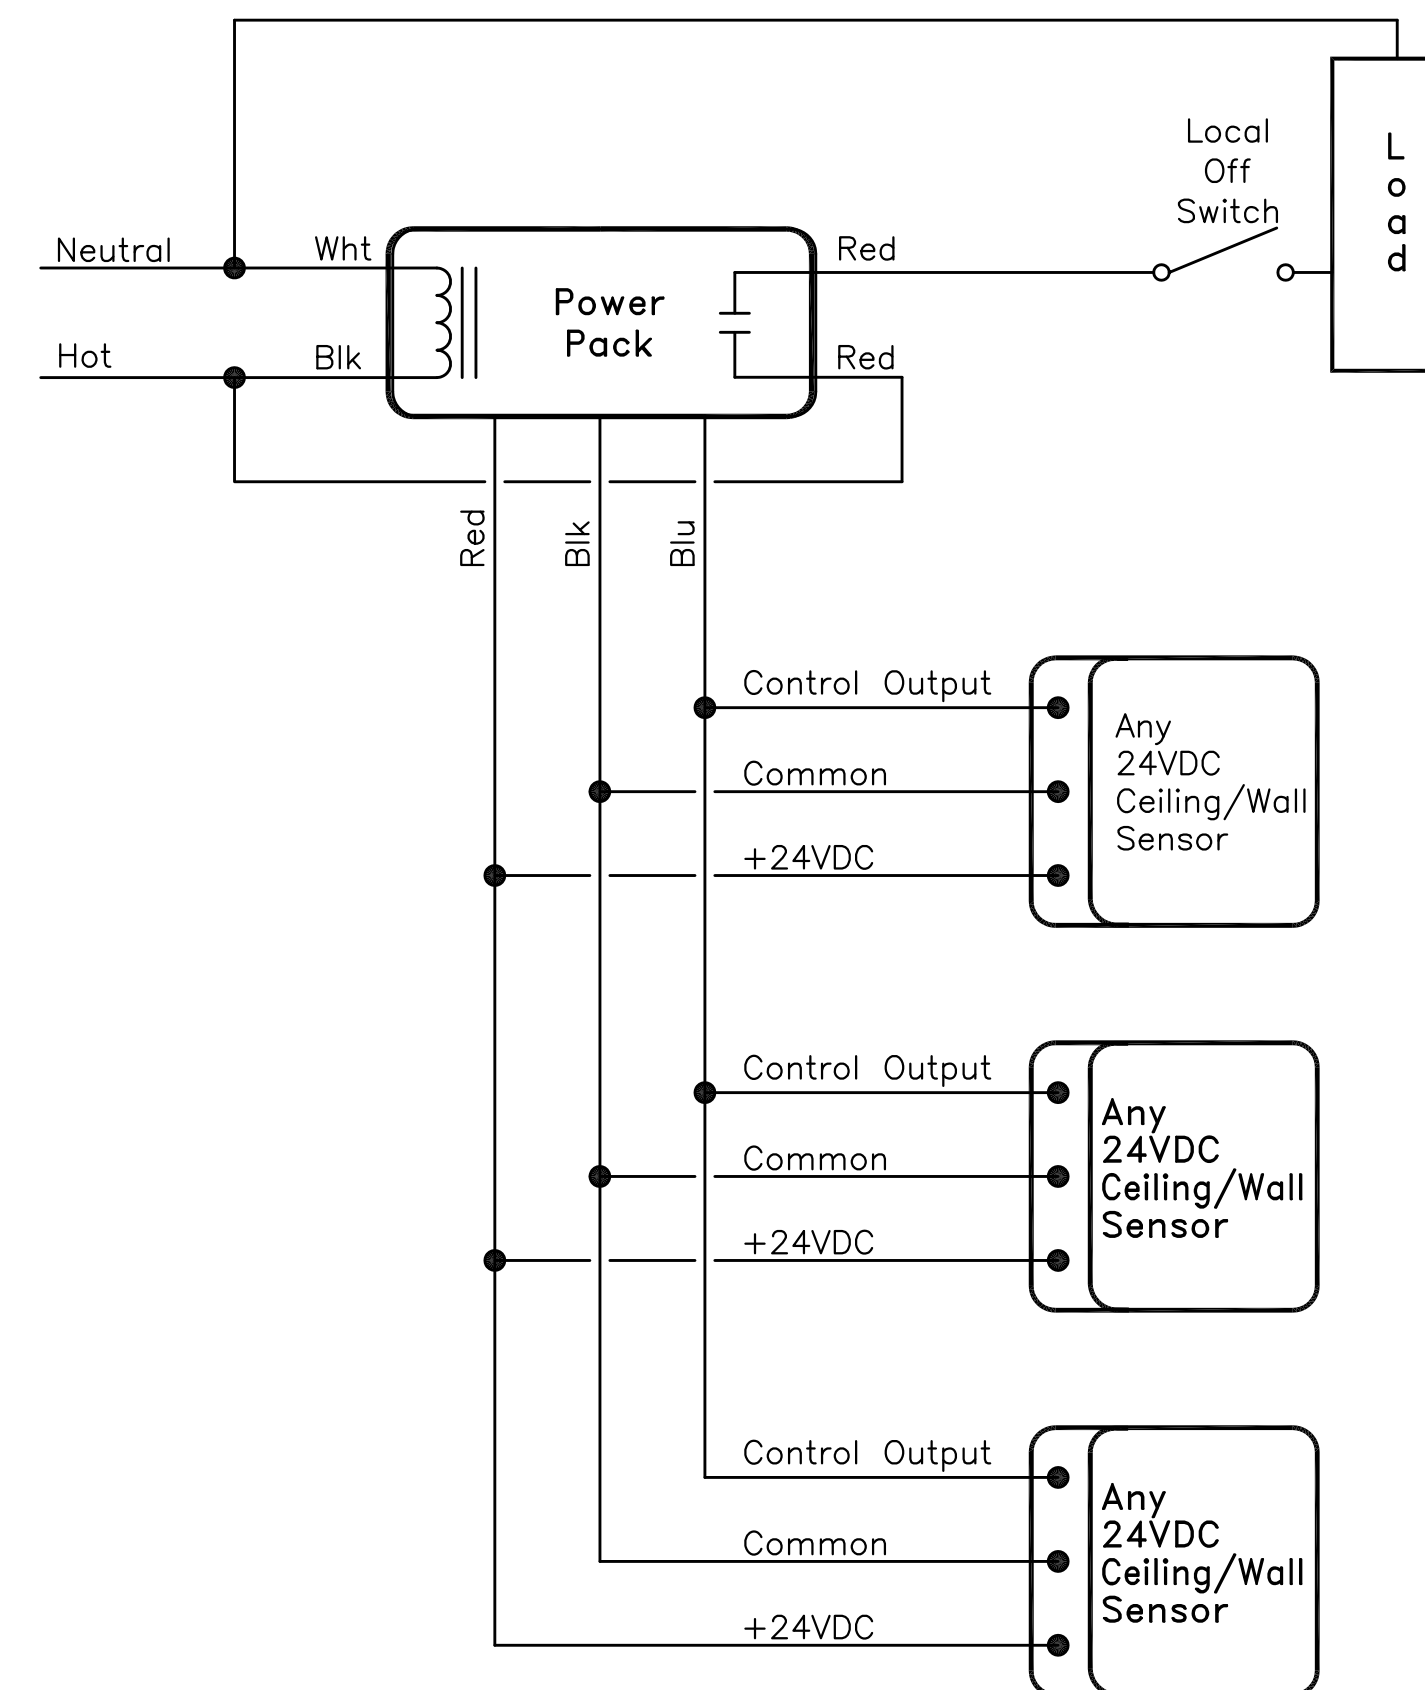


2 MULTIPLE OCCUPANCY SENSORS WIRING DIAGRAM  
SCALE: NONE

1 LIGHTING CONTROL PANEL DETAIL - LCP1  
SCALE: NONE

FINAL DESIGN  
Oct 29, 2009

WALDEMAR S. NELSON AND COMPANY  
ENGINEERS AND ARCHITECTS  
1200 ST. CHARLES AVE NEW ORLEANS, LA.

©2009 IMC 1734  
CONSULTING ENGINEERS  
INC.  
3120 20th STREET  
METAIRIE, LOUISIANA 70002

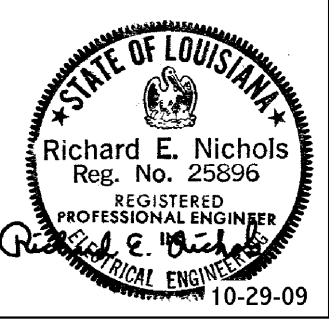

RECORD DRAWING DATE  
XX-XXX-20XX  
CODE ID. NO.  
DRAWING SIZE: D  
SPEC. NO.06-  
CONSTR. CONTR. NO.  
N62467-  
NAVFAC DRAWING NO.  
15030971  
SHEET OF

E-7.0

NAVJRB New Orleans Belle Chasse, Louisiana  
NAVAIRSEFAC CALIBRATION BLDG.  
ELECTRICAL DETAILS  
DATE: AUGUST 14, 2008  
EFD FOR COMMANDER, NAVFAC

REV.	DESCRIPTION	DATE	APPROVAL
0	FINAL DESIGN	10/29/09	P.S.

BROADMOOR  
BUILDING by DESIGN  
BROADMOOR, L.L.C.  
2740 North Amcott Road  
Metairie, Louisiana 70002  
www.broadmoorllc.com