




**5 WALL SECTION**  
A4.27 1/4"=1'-0"

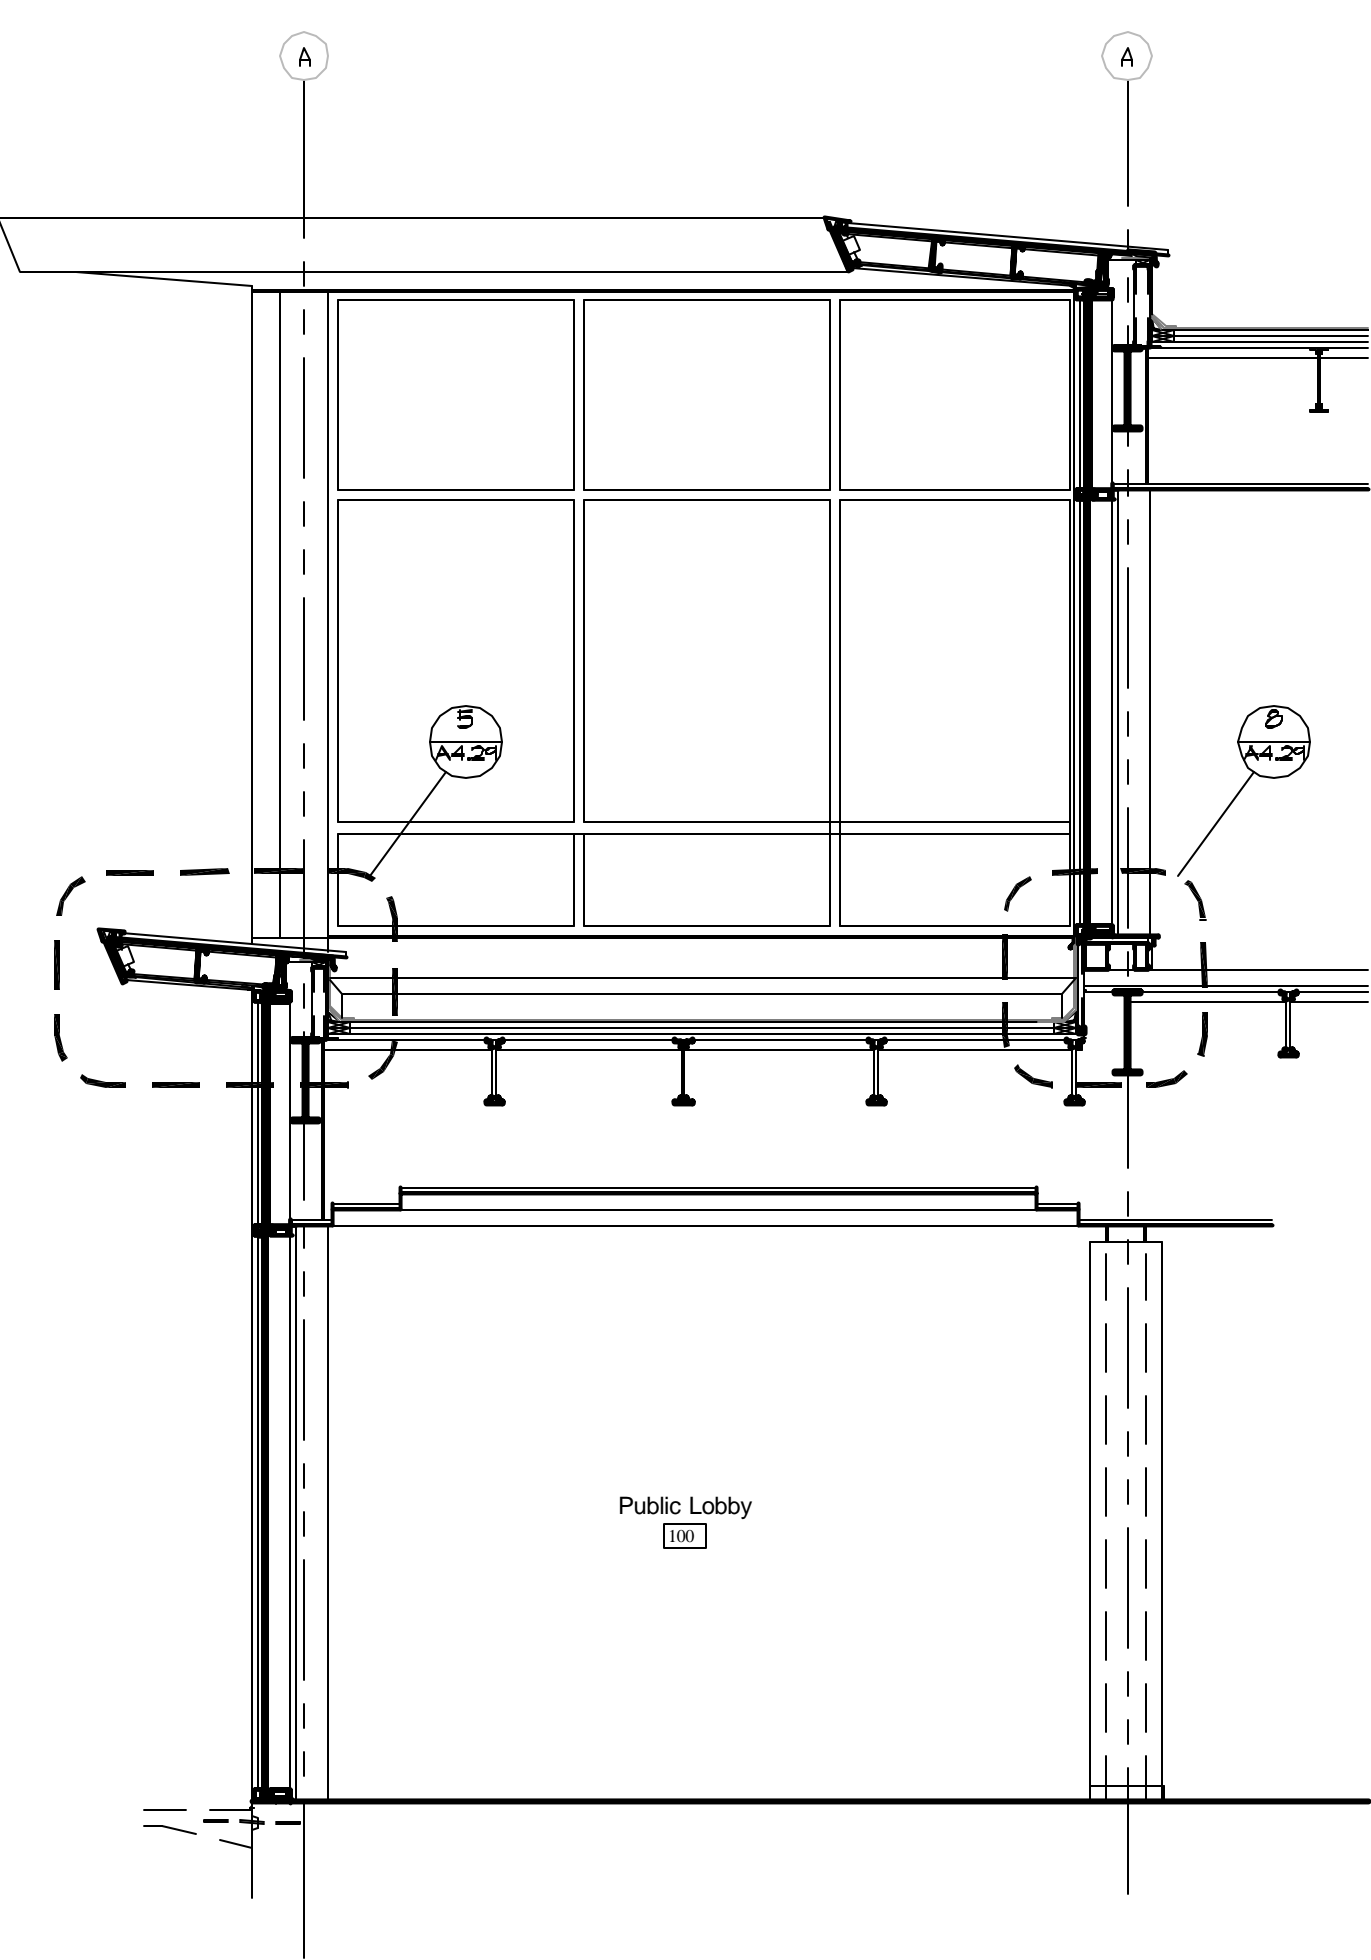


**4 WALL SECTION**  
A4.27 1/4"=1'-0"

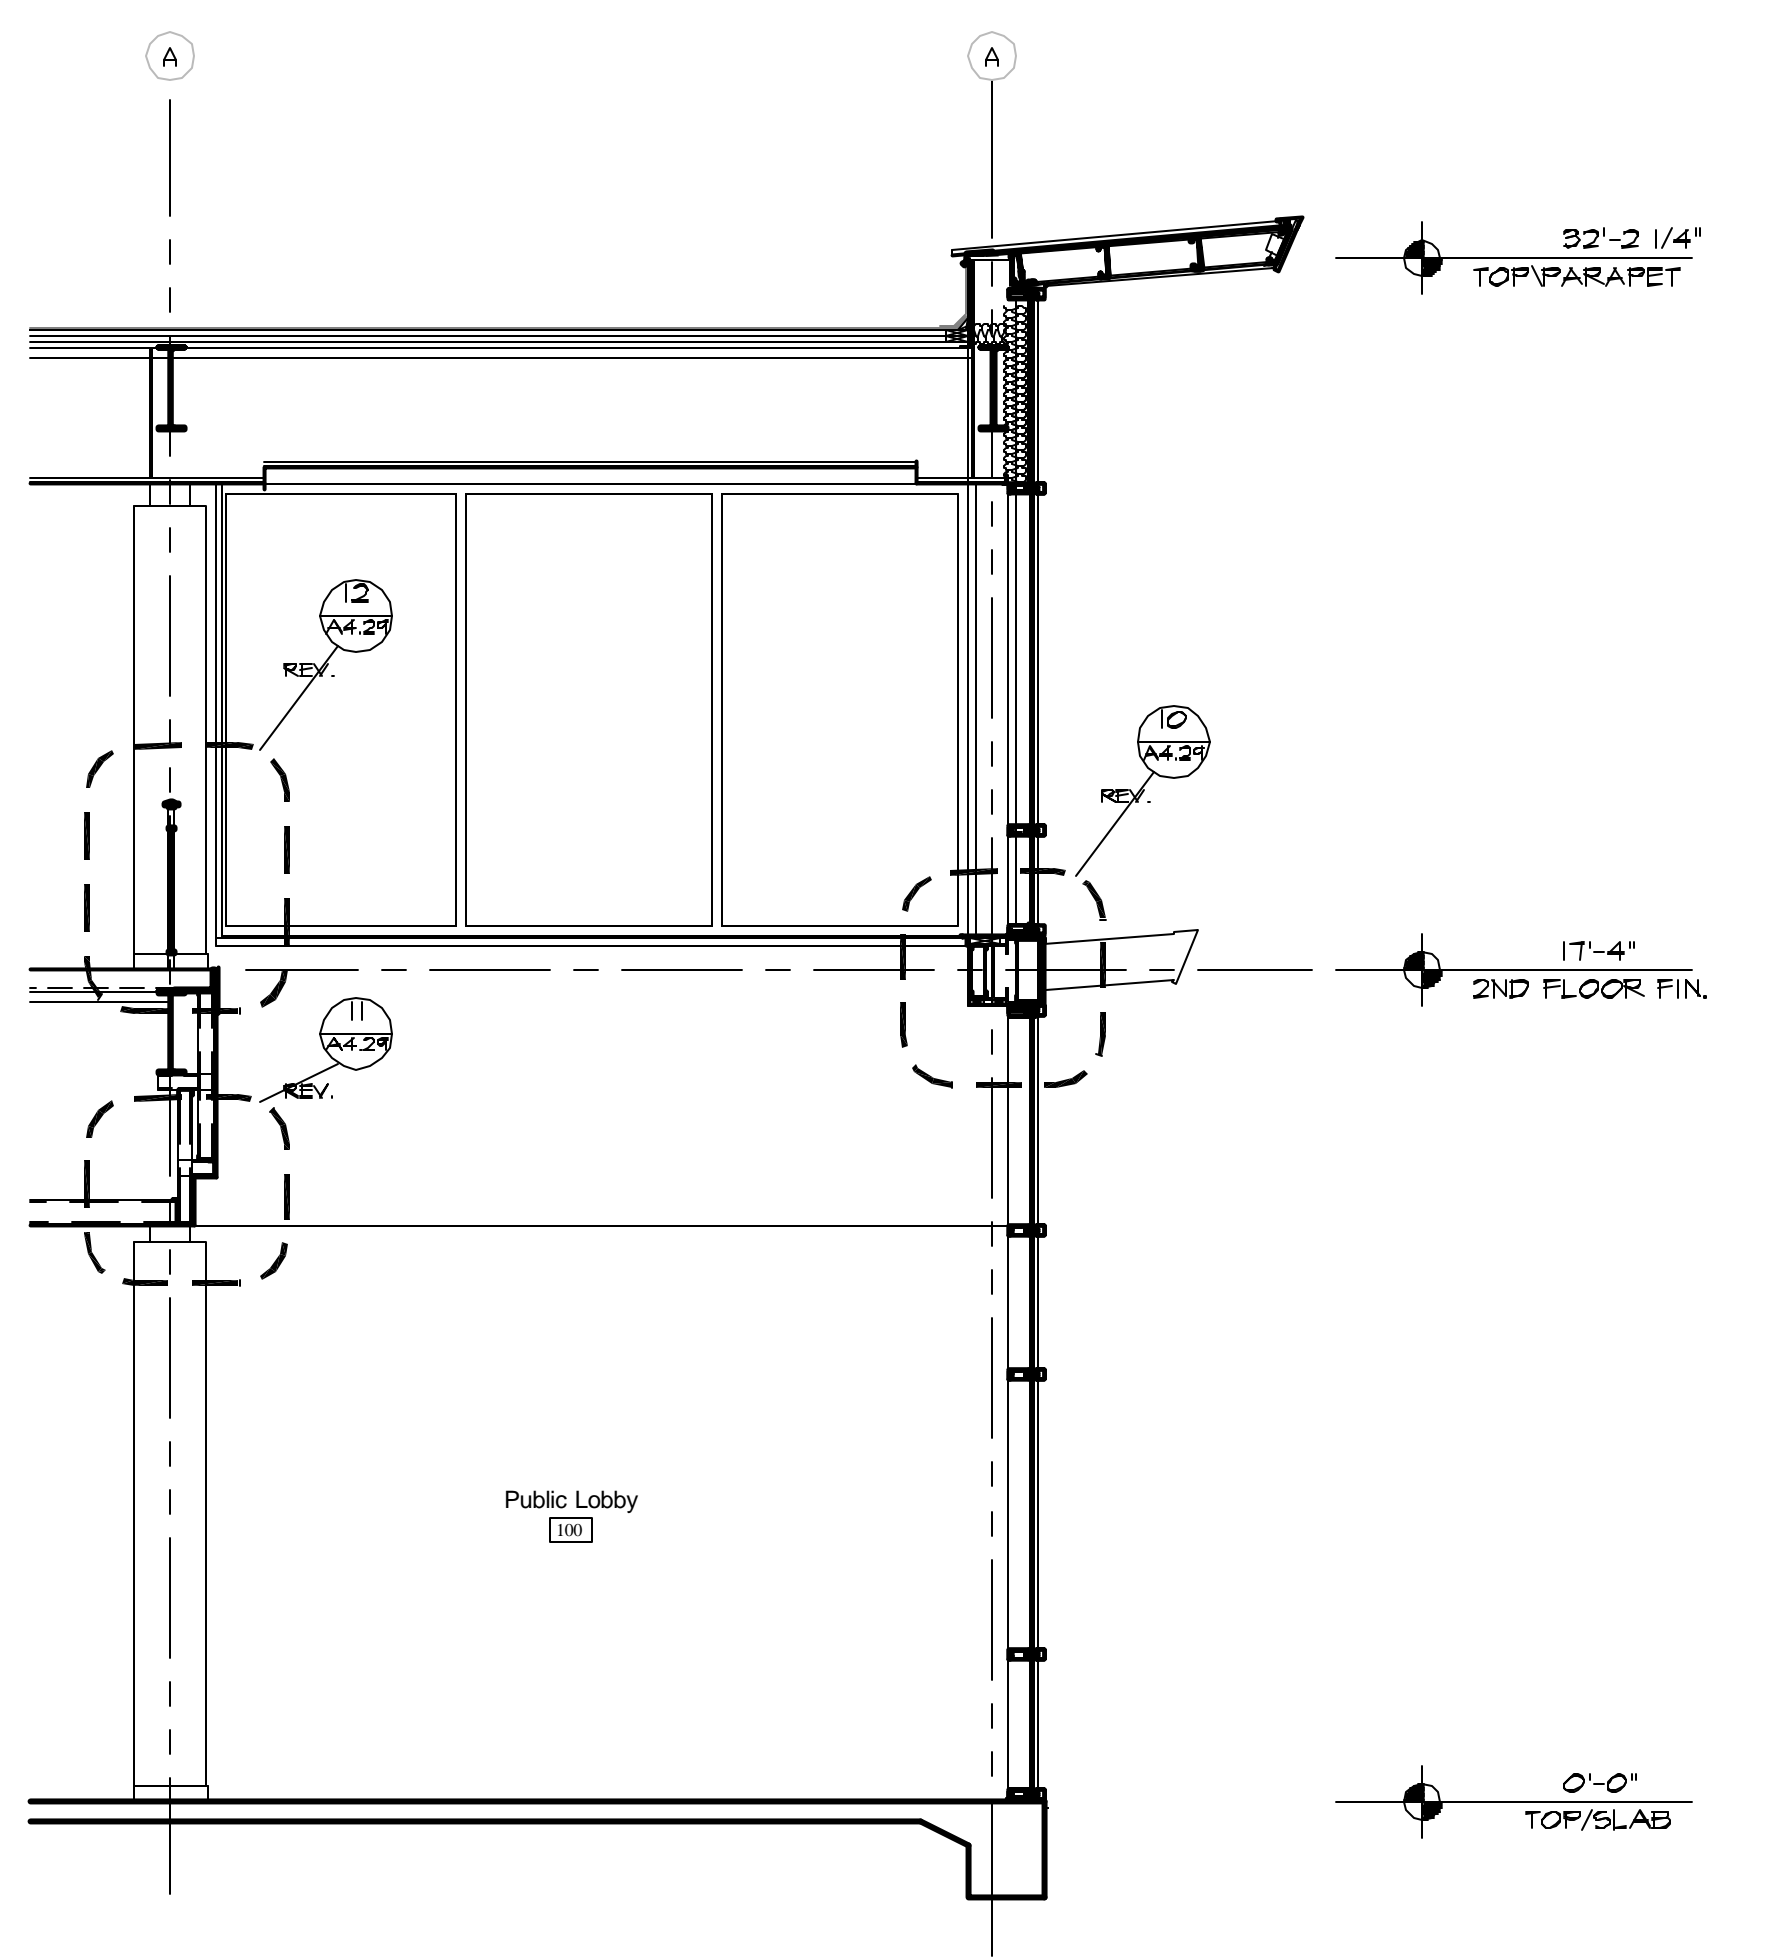

**3 WALL SECTION**  
A4.27 1/4"=1'-0"

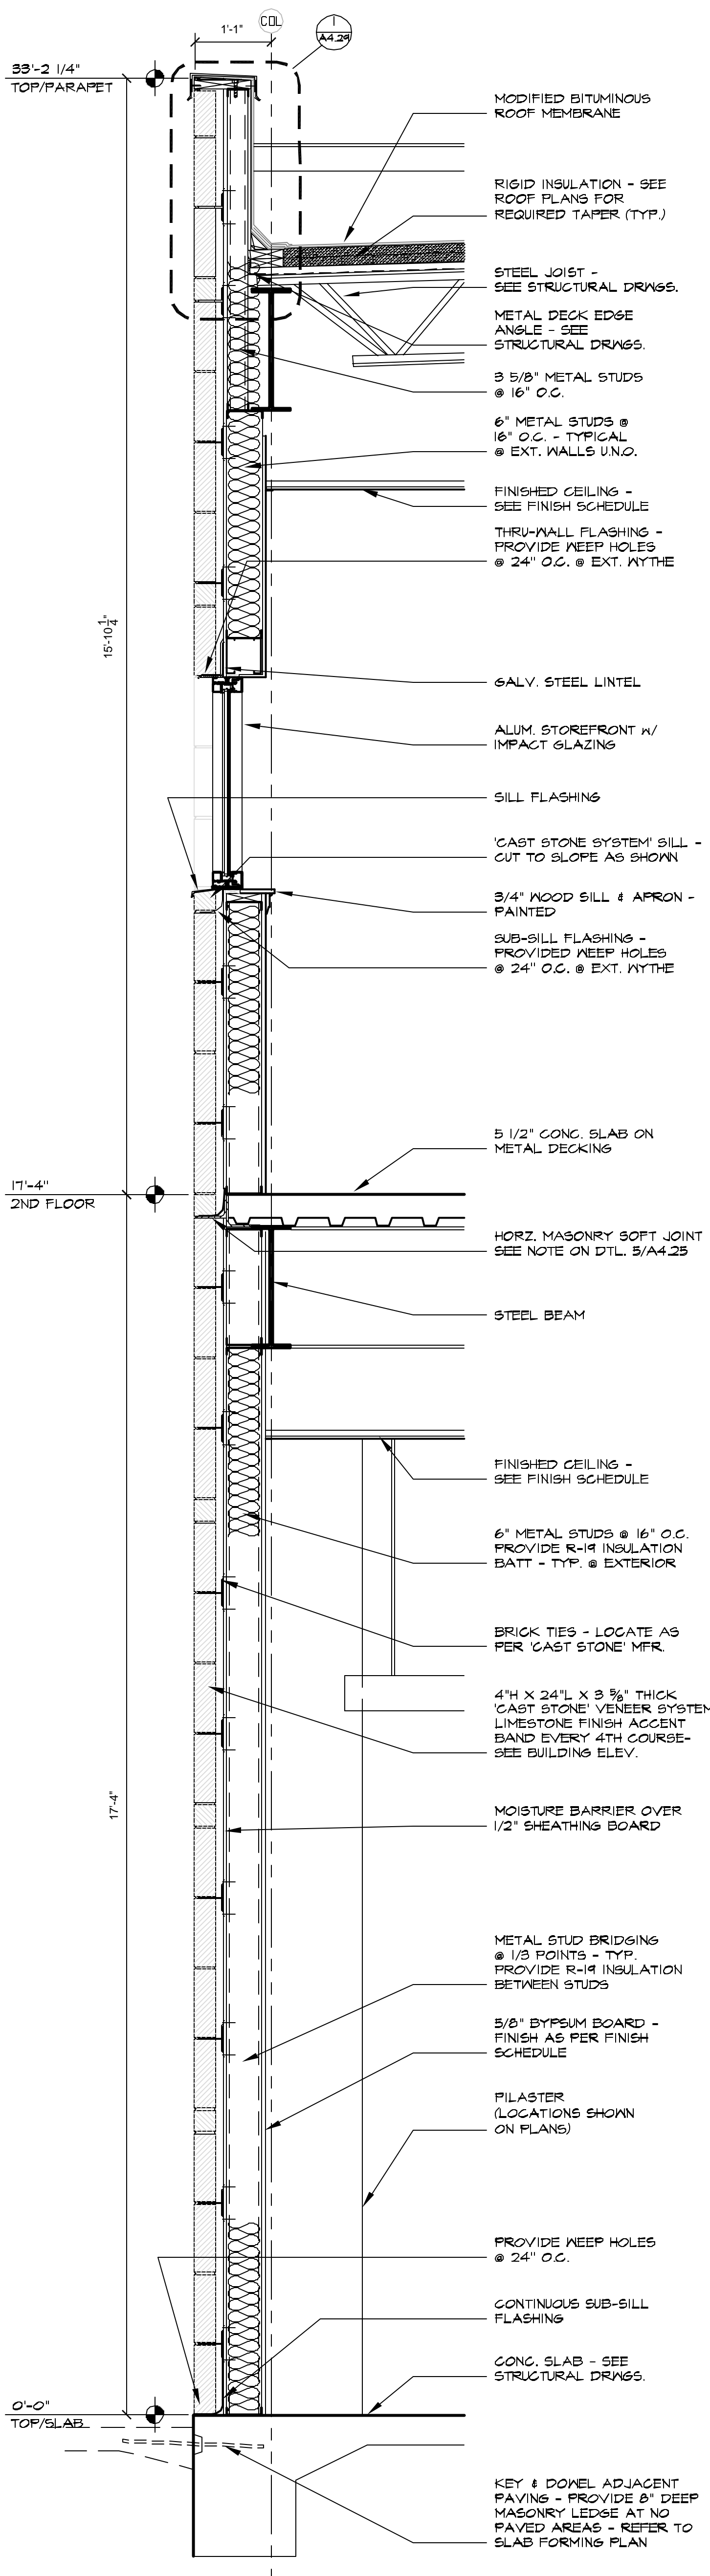

**2 WALL SECTION**  
A4.27 3/4"=1'-0"

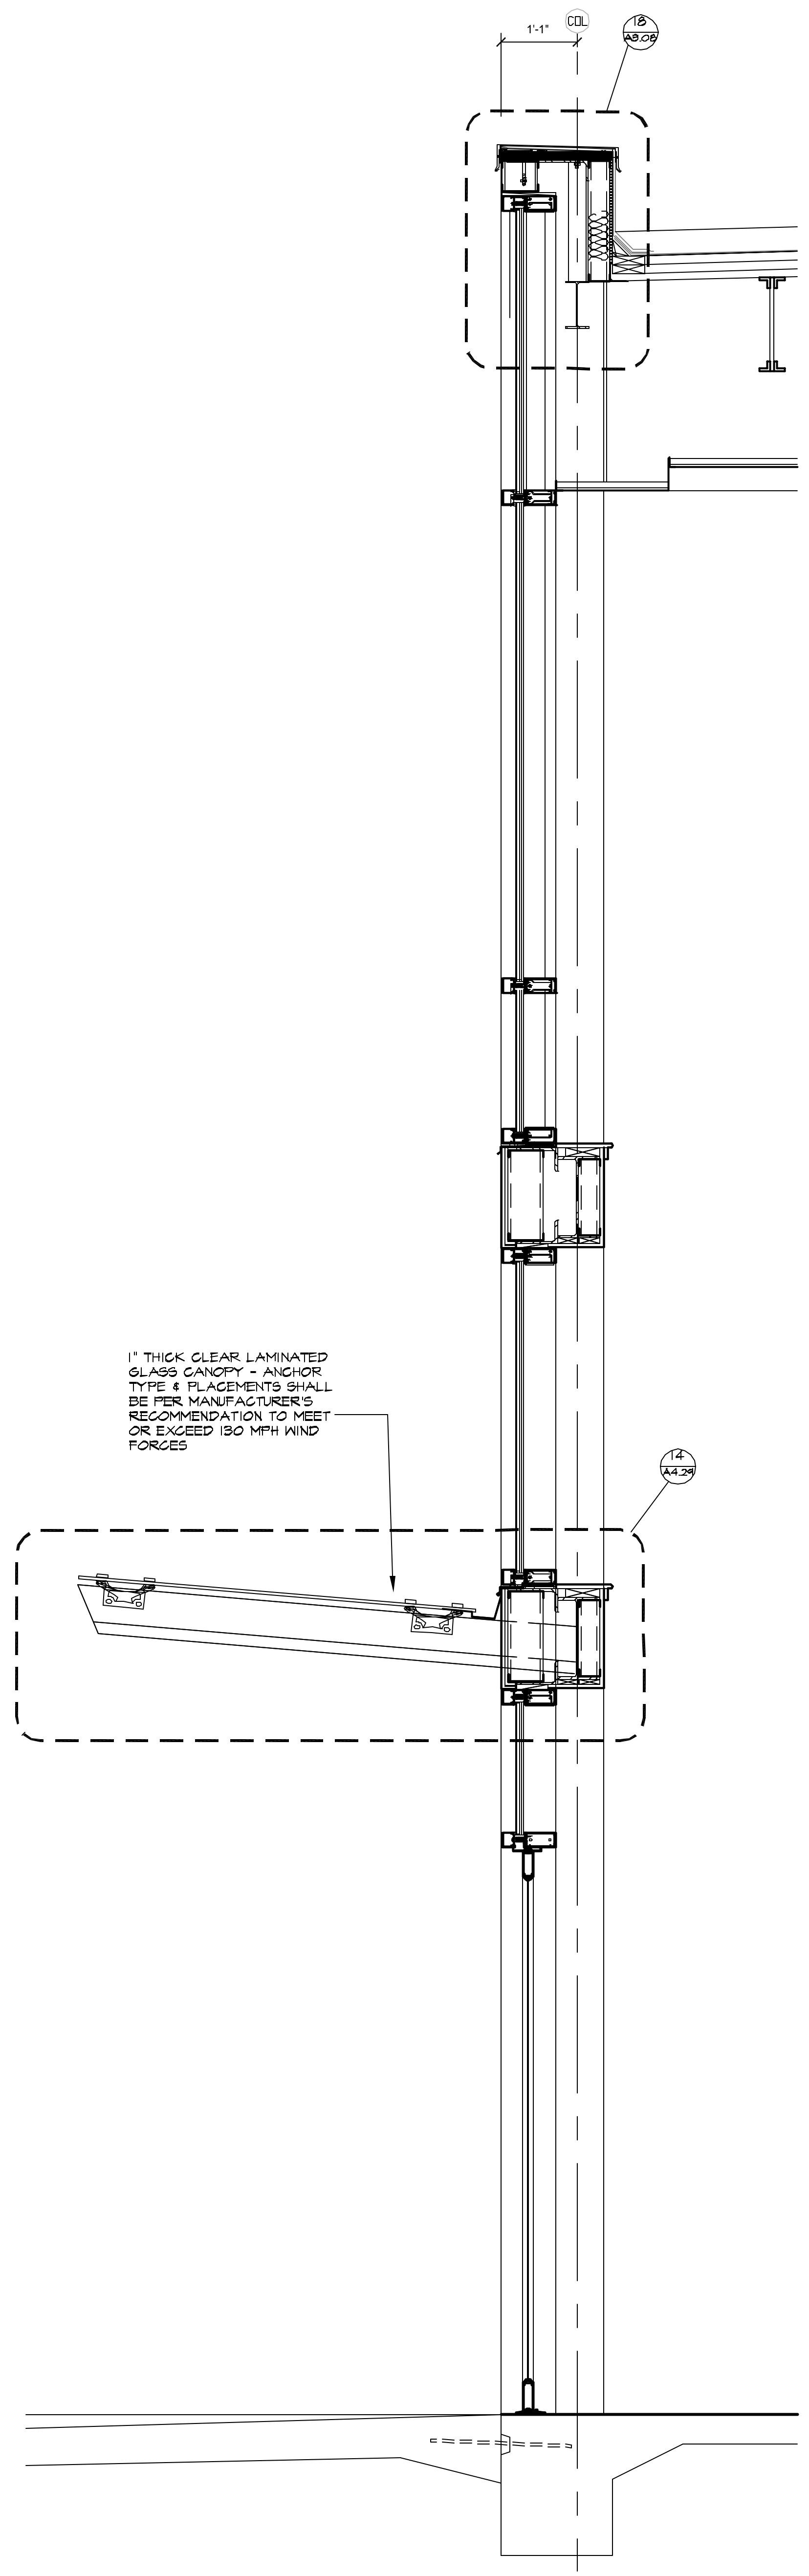

**1 WALL SECTION**  
A4.27 3/4"=1'-0"



**RCL**  
CONSULTANTS, L.L.C.  
Planning  
Architecture  
Engineering  
Construction  
Management

RICHARD C. LAMBERT  
CONSULTANTS, L.L.C.  
527 N. Canaway Blvd.  
Metairie, LA 70002  
985.723.4466  
Fax: 985.723.4467  
#1 Poydras St., Ste. 1800 #10  
New Orleans, LA 70139  
985.833.7346

The drawing and design is the exclusive property of Richard C. Lambert Consultants, L.L.C. and may not be reproduced or used without authorization and written permission. © 2007


RCLC Project Number: 0687  
Date Issued: 05/15/07  
Drawn By: VFA & JMS  
Checked By: RLE

Revisions:  
\_\_\_\_\_  
\_\_\_\_\_  
\_\_\_\_\_

Copyright © 2007

**ST. TAMMANY PARISH SHERIFF'S OFFICE**  
BROWNSWITCH ROAD  
SLIDELL, LOUISIANA

CONSTRUCTION DOCUMENTS

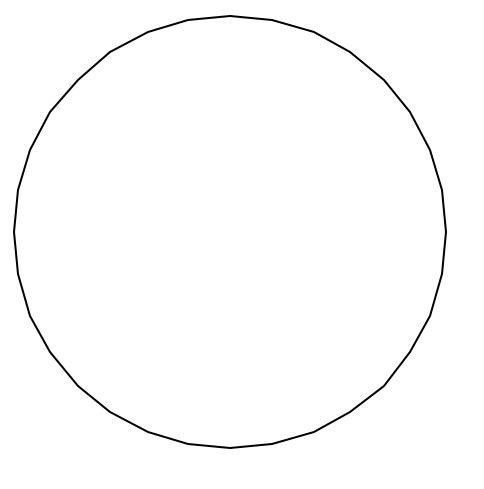

**WALL SECTIONS**

Sheet Number:  
**A4.27**